


Stormwater Management Plan

Dalton Drive, Maroochydore - Stage 1
Amendment

V171462

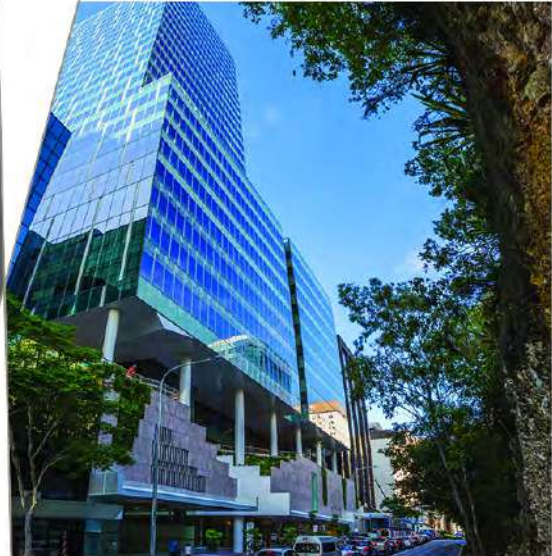

Prepared for
Maroochydore Spotlight Property 2 Pty Ltd
C/O Blueprint Group Australia Pty Ltd

28 March 2019

Contact Information

Cardno (Qld) Pty Ltd

ABN 57 051 074 992

Level 1

9 Maud Street

Maroochydore QLD 4558

Australia

www.cardno.com

Phone +61 7 5443 2555

Document Information

Prepared for

Maroochydore Spotlight
Property 2 Pty Ltd C/O
Blueprint Group Australia Pty
Ltd

Project Name

0BDalton Drive,
Maroochydore - Stage 1
Amendment

File Reference

V171462_SMP_STG1_REVI
SED.docx

Job Reference

V171462

Date

28 March 2019

Version Number

4

Author(s):



Zac McCosker

Stormwater & Drainage Engineer

Effective Date

21/03/2019

Approved



By:

Helen Doherty

Senior Water Engineer

Date Approved

21/03/2019

Document History

Version	Effective Date	Description of Revision	Prepared by	Reviewed by
1	27/08/2018	Draft for comment	ZM	HD
2	30/08/2018	Final	ZM	HD
3	22/10/2018	Updated Drain Drawing	ZM	HD
4	21/03/2019	Updated Drainage Layout	ZM	HD

© Cardno. Copyright in the whole and every part of this document belongs to Cardno and may not be used, sold, transferred, copied or reproduced in whole or in part in any manner or form or in or on any media to any person other than by agreement with Cardno.

This document is produced by Cardno solely for the benefit and use by the client in accordance with the terms of the engagement. Cardno does not and shall not assume any responsibility or liability whatsoever to any third party arising out of any use or reliance by any third party on the content of this document.

© Cardno. Copyright in the whole and every part of this document belongs to Cardno and may not be used, sold, transferred, copied or reproduced in whole or in part in any manner or form or in or on any media to any person other than by agreement with Cardno.

This document is produced by Cardno solely for the benefit and use by the client in accordance with the terms of the engagement. Cardno does not and shall not assume any responsibility or liability whatsoever to any third party arising out of any use or reliance by any third party on the content of this document.

Table of Contents

1	Introduction	1
2	Site Description	2
3	Proposed Development	4
3.1	Summary	4
3.2	Lawful Points of Discharge	4
4	Required Minimum Floor Levels	5
5	Stormwater Quality Objectives	6
5.1	Operational Phase	6
5.2	Construction Stage	6
6	Proposed Stormwater Quality Treatment	7
6.1	Summary	7
6.2	Future Development Stages	7
6.3	MUSIC Model	7
6.4	MUSIC Model Results	12
7	Maintenance	13
8	Conclusion	14

Appendices

Appendix A DEVELOPMENT PLAN

Appendix B DRAINAGE PLAN

Appendix C ENVIROPOD INFORMATION

Tables

Table 6-1	Rainfall Runoff Parameters	8
Table 6-2	Pollutant Export Parameters	8
Table 6-3	Catchment Areas and Proposed Stormwater Treatment	9
Table 6-4	East Bio-retention basin MUSIC Details	11
Table 6-5	West Bio-retention basin MUSIC Details	11
Table 6-6	MUSIC Model Results	12

Figures

Figure 2-1	Site Location	2
Figure 2-2	Existing Site Drainage (SCC MyMaps)	3
Figure 6-1	MUSIC Model Layout	9
Figure 6-2	MUSIC Model Catchments	10

1 Introduction

Cardno has been engaged by Maroochydore Spotlight Property 2 Pty Ltd C/O Blueprint Group Australia Pty Ltd to prepare a Stormwater Management Plan to support the Material Change of Use (MCU) development application for Stage 1 of Lot 1 on SP202103. For Stage 1 it is proposed to develop part of this site for large format retail development including a Spotlight and other showroom tenancies along with associated parking.

The development application is being made to Economic Development Queensland (EDQ), rather than the Sunshine Coast Council, given the site is located within the Maroochydore City Centre (MCC) Priority Development Area (PDA). Therefore, assessment of the development is undertaken in accordance with the Development Scheme, and not the Planning Scheme (other than where the development scheme is called up by the Planning Scheme).

The development site is zoned Principal Centre (CBD).

2 Site Description

The site has an area of 4.35 ha, of which approximately 2.25 ha of the southern portion will be developed as part of the Stage 1 development. The subject site is bounded by Dalton Drive to the west and south, residential townhouses to the south-east and the MCC PDA site (currently being developed by SunCentral Maroochydore Pty Ltd) to the north and north-east. The subject site is part of the Cornmeal Creek catchment.

The site is currently grassed and with relatively flat terrain. The Stage 1 development area generally slopes in a south-easterly direction towards Dalton Drive. The surface level of the Stage 1 development area ranges from approximately 3.0 mAHD to 4.0 mAHD. Figure 2.1 below shows the locality plan of the subject site with existing site drainage shown in Figure 2.2.



Figure 2-1 Site Location



Figure 2-2 Existing Site Drainage (SCC MyMaps)

3 Proposed Development

3.1 Summary

The proposed development plan is provided in Appendix A. Stage 1 of the development consists of large format retail with associated car parking. During Stage 1 of the development, vacant lots on the northern boundaries will be retained. An access road to the south, connecting to Dalton Drive, will be provided during Stage 1. This access road will require modification of the existing stormwater network, which has an invert level of 1.65 mAHD. Therefore a new connection point for the neighbouring lots may be required, to ensure that this area can continue to freely drain. The roof area from the proposed building and the carpark area will be drained towards the south, replicating the existing catchment area draining towards this location.

The carpark area will have syphonic drainage directed towards the east and west, with the eastern side discharging into a proposed 525 mm RCP. This 525 mm RCP then connects into a 600 mm RCP, heading south before discharging into the existing council drainage located near the south-east corner of the property at Dalton Drive. The western carpark area will drain to the existing council drainage located to the south west on Dalton Drive.

The main building envelope will be split with 50% draining via a syphonic system to the 600 mm RCP located on the eastern boundary and 50% draining via a syphonic system to the council drainage system located to the south west on Dalton Drive. All stormwater will be treated by end of line treatment devices before discharge into the respective outlets.

This drainage plan was based on preliminary drainage plans and road grading prepared for the future development of the MCC site. The proposed drainage layout can be seen in Appendix B. The developed case catchment plan has replicated the existing flow patterns on site as much as practicable.

3.2 Lawful Points of Discharge

The lawful point of discharge for flows directed towards the south is the existing headwall, located within the south-east corner of the site and the inlet located on the south west corner. Both of these locations connect to Council drainage in Dalton Drive.

The drainage network was established when the site was zoned by Maroochy Shire Council as Mixed Housing, which had an assumed fraction impervious of 0.60. Therefore the development, which will have an increased fraction impervious, will need to provide for detention on site so that the existing capacity of the downstream stormwater network is not exceeded. Detailed detention sizing and analysis of the proposed stormwater network will be required during Operational Works. The proposed drainage plan has considered the future service and level requirements of the neighbouring sites.

4 Required Minimum Floor Levels

The site will be affected by local and regional flood levels, which will need to be considered when defining the minimum floor and surface levels for the development.

The regional 1% Annual Exceedance Probability (AEP) peak flood level (at 2100) in the future neighbouring lake is proposed to be 3.23 mAHD. Appropriate freeboard above this regional flood level is required. Based on minimum freeboard requirements of 400 mm within the PDA, a minimum floor level of 3.63 mAHD would be required. Carpark levels should also be set a maximum of 250 mm below this 1% AEP regional flood level, i.e. a minimum surface level of 2.98 mAHD. The local flood levels will determine the required minimum floor levels for this site, as the floor levels should be set 300 mm above the local 1% AEP flood level. Based on preliminary grading of the site, as shown in Appendix C, a minimum floor level of around 4.2 mAHD would be required. This will be required to be confirmed during detailed design. It is also noted that the preliminary grading layout is as per previous design as part of the original Stage 1 Amendments in October 2018.

5 Stormwater Quality Objectives

5.1 Operational Phase

The stormwater quality design objectives applicable to the site, as outlined in Table B of the Department of Infrastructure, Local Government and Planning (DILGP) *State Planning Policy (SPP)* (July 2017) are:

- > Total Suspended Solids (TSS) – 80% removal of mean annual load from unmitigated development.
- > Total Phosphorous (TP) – 60% removal of mean annual load from unmitigated development.
- > Total Nitrogen (TN) – 45% removal of mean annual load from unmitigated development.
- > Gross Pollutants >5mm – 90% removal of mean annual load from unmitigated development.

5.2 Construction Stage

The construction phase stormwater quality design objectives applicable to the site are outlined in Table A of the DILGP *State Planning Policy* (July 2017).

The release limits for stormwater captured in a sediment basin are not to exceed the following limits:

- > Total Suspended Solids (TSS): 50 mg/L
- > pH: 6.5 – 8.0

Appropriate erosion and sediment control measures will be required to be designed, constructed and operated in accordance with the SPP 2017 guidelines.

6 Proposed Stormwater Quality Treatment

6.1 Summary

The proposed stormwater quality treatment for the site consists of:

- > A bio-retention garden planted with trees on the eastern boundary (B1);
- > A bio-retention garden planted with trees on the south west boundary (B2);
- > 80kL rainwater tank used for toilet flushing and irrigation; and,
- > Stormwater360 Enviropod litter baskets on all field and kerb inlets.

The stormwater treatment required for the northern carpark area is proposed to be provided by Enviropod's and bio-retention basins located on the south east and south west corners of the Lot. Treated stormwater will then discharge into the proposed 525 mm RCP on the east and existing council drainage on the west.

Approximately 50% of the main roof area on the southern section will drain to the western bio-retention system which will then discharge into council drainage on Dalton Drive. The other 50% will drain to a 80kL rainwater tank, assumed to be used for toilet flushing and irrigation. If the tank is full it will overflow into the eastern bio basin.

The eastern basin will be approximately 4 metres wide by 13 metres long. The filter width will be 4 metres wide with 1 in 1 batters. The filter depth will be 0.8 metres to allow for tree planting. The extended detention depth will be 200 mm. The western basin will be approximately 7 metres wide by 10 metres long. The filter width will be 7 metres wide with 1 in 3 batters. The filter depth will be 0.8 metres to allow for tree planting. The extended detention depth will be 200 mm. The ultimate arrangement will be determined during detailed design.

6.2 Future Development Stages

During future development, the vacant area to the north of Stage 1 will be developed. This will be required to provide its own treatment and detention of runoff before discharging to any proposed stormwater network.

6.3 MUSIC Model

A MUSIC model was set up to determine the efficiency of the proposed treatment train for all stages of the development. The MUSIC model was set up using Version 6.2. The model used 6 minute timestep rainfall from Nambour, from 1989 to 1998. The MUSIC source nodes were based on the values for urban developments, as outlined in the MUSIC Modelling Guidelines – Version 1.0 2010 (Water by Design, 2010). The adopted source nodes are summarised in Table 6-1 and 6-2.

The catchment was broken down into the different source types. The properties of each sub-catchment are summarised in Table 6-3. The MUSIC model layout is shown in Figure 6-1

Table 6-1 Rainfall Runoff Parameters

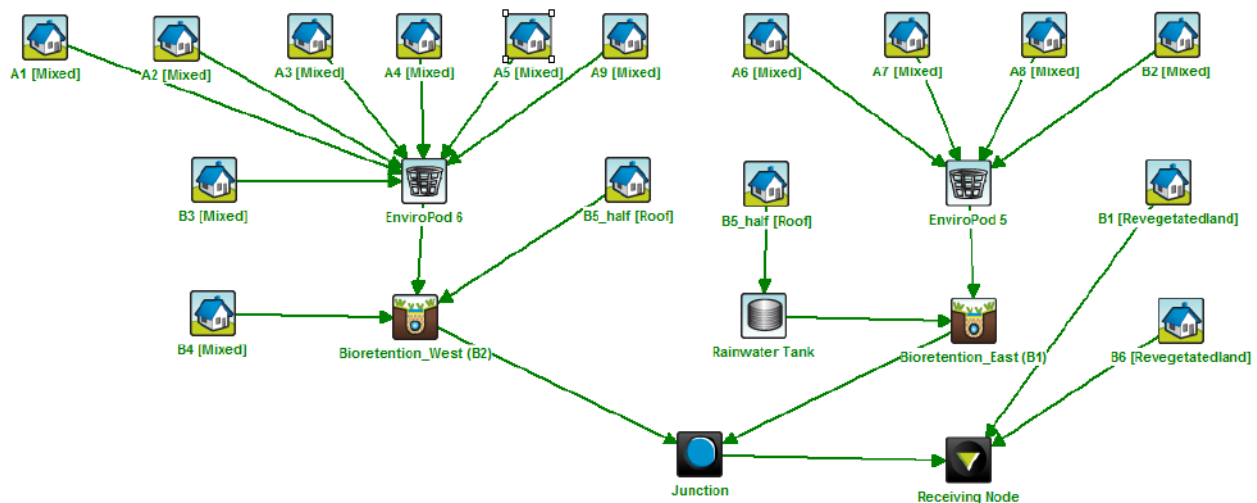
Parameter	Commercial Source Node
Rainfall threshold (mm)	1
Soil storage capacity (mm)	18
Initial storage (% capacity)	10
Field capacity (mm)	80
Infiltration capacity coefficient a	243
Infiltration capacity exponent b	0.6
Initial depth (mm)	50
Daily recharge rate (%)	0
Daily baseflow rate (%)	31
Daily deep seepage rate (%)	0

Table 6-2 Pollutant Export Parameters

Parameter	Surface Type	TSS Log ¹⁰ Values		TP Log ¹⁰ Values		TN Log ¹⁰ Values	
		Mean	Std. Dev	Mean	Std. Dev	Mean	Std. Dev
Commercial							
Baseflow	Roof	N/A	N/A	N/A	N/A	N/A	N/A
	Roads	0.78	0.39	-0.60	0.50	0.32	0.30
	Ground	0.78	0.39	-0.60	0.50	0.32	0.30
Stormflow	Roof	1.30	0.38	-0.89	0.34	0.37	0.34
	Roads	2.43	0.38	-0.30	0.34	0.37	0.34
	Ground	2.16	0.38	-0.39	0.34	0.37	0.34

Table 6-3 Catchment Areas and Proposed Stormwater Treatment

Catchment	Area (ha)	% Impervious	MUSIC Node	Proposed Treatment
A1	0.10	30	Commercial Landscaping	EnvPod, Bio retention
A2	0.09	90	Commercial Road	EnvPod, Bio retention
A3	0.09	90	Commercial Road	EnvPod, Bio retention
A4	0.09	90	Commercial Road	EnvPod, Bio retention
A5	0.18	90	Commercial Road	EnvPod, Bio retention
A6	0.13	90	Commercial Road	EnvPod, Bio retention
A7	0.14	90	Commercial Road	EnvPod, Bio retention
A8	0.13	90	Commercial Road	EnvPod, Bio retention
A9	0.07	90	Commercial Road	EnvPod, Bio retention
B1	0.04	6	Garden	Bio retention
B2	0.36	90	Commercial Road	EnvPod, Bio retention
B3	0.07	90	Commercial Road	EnvPod, Bio retention
B4	0.12	30	Commercial Landscaping	EnvPod, Bio retention
B5	0.62	100	Commercial Roof	50% Rainwater tank 50% Bio retention
B6	0.04	6	Garden	Bio retention


Figure 6-1 MUSIC Model Layout

The MUSIC catchments are shown in Figure 6-2.



Figure 6-2 MUSIC Model Catchments

The removal efficiencies for the proprietary treatment devices were provided by the manufacturer. Details of the Stormwater360 Enviropods are provided in Appendix D.

The details of the bio-retention gardens are provided in Table 6-4 and 6-5.

Table 6-4 East Bio-retention basin MUSIC Details

Parameter	Bio-retention Gardens
Extended Detention Depth (m)	0.2
Saturated Hydraulic Conductivity (mm/hr)	200
Filter Depth (m)	0.8
Filter Area (m ²)	50
TN Content of Filter Media (mg/kg)	500
Orthophosphate Content of Filter Media (mg/kg)	20

Table 6-5 West Bio-retention basin MUSIC Details

Parameter	Bio-retention Gardens
Extended Detention Depth (m)	0.2
Saturated Hydraulic Conductivity (mm/hr)	200
Filter Depth (m)	0.8
Filter Area (m ²)	70
TN Content of Filter Media (mg/kg)	500
Orthophosphate Content of Filter Media (mg/kg)	20

An 80kL tank was assumed to be used for toilet flushing and irrigation. The irrigation rate was assumed to be 730 mm/year, which totalled 1600 kL/year of irrigation. The number of toilets was not known, and so toilet flushing was excluded from the analysis. The rainwater tank will be required to be topped up from mains water supply. Half of the available roof area was assumed to be drained towards the tank. The proposed tank will provide 74% of the non-potable water demand.

6.4 MUSIC Model Results

The results of MUSIC are provided in Table 6-5. As demonstrated by this table the water quality objectives have been satisfied for all pollutants.

Table 6-6 MUSIC Model Results

Parameter	Mean Annual Load (kg/yr)		% Removal
	Sources	Residual	
Flow (ML/yr)	28.5	26.9	5.6
TSS	8300	829	90.0
TP	14.8	4.84	67.4
TN	90.3	49.4	45.3
GP	624	2.1	99.7

7 Maintenance

Maintenance of the stormwater quality devices is to be carried out by body corporate. The maintenance requirements of the proprietary products are to be carried out in accordance with manufacturer's guidelines. Maintenance of the bio-retention gardens should be carried out in accordance with Water by Design (2012) *Maintaining Vegetated Stormwater Assets (Version 1)* guidelines.

8 Conclusion

The proposed development of Stage 1 of Lot 1 on SP202103 has been shown through MUSIC modelling to satisfy the proposed stormwater quality requirements. The proposed stormwater treatment includes:

- > Bio-retention gardens planted with trees at two locations on the southern boundary;
- > 80kL rainwater tank used for toilet flushing and irrigation; and
- > Stormwater360 Enviropod litter baskets on all field and kerb inlets.

Further detailed modelling of the stormwater detention requirements will be necessary during the Operational Works stage.

APPENDIX

A

DEVELOPMENT PLAN


Maroochydore

Large Format Retail Precinct

Development Application

DRAWING LIST

A-DA- 0000	TITLE SHEET
A-DA- 0001	KEY PLAN
A-DA- 0002	MASTERPLAN
A-DA- 0100	BASEMENT PLAN
A-DA- 0101	GROUND PLAN
A-DA- 0102	LEVEL 1 PLAN
A-DA- 0120	ROOF PLAN
A-DA- 0130	FARMERS MARKET
A-DA- 0200	ELEVATIONS
A-DA- 0201	ELEVATIONS
A-DA- 0300	SECTIONS
A-DA- 0301	SECTIONS
A-DA- 0302	SECTIONS
A-DA- 0305	EASTERN BOUNDARY INTERFACE
A-DA- 0700	PERSPECTIVE
A-DA- 0701	PERSPECTIVE
A-DA- 0702	PERSPECTIVE
A-DA- 0703	PERSPECTIVE
A-DA- 0704	PERSPECTIVE
A-DA- 0705	PERSPECTIVE
A-DA- 0706	PERSPECTIVE
A-DA- 0707	PERSPECTIVE
A-DA- 0708	PERSPECTIVE
A-DA- 0709	PERSPECTIVE
A-DA- 0710	PERSPECTIVE
A-DA- 0800	REFERENCE 01
A-DA- 0801	REFERENCE 02
A-DA- 0802	REFERENCE 03

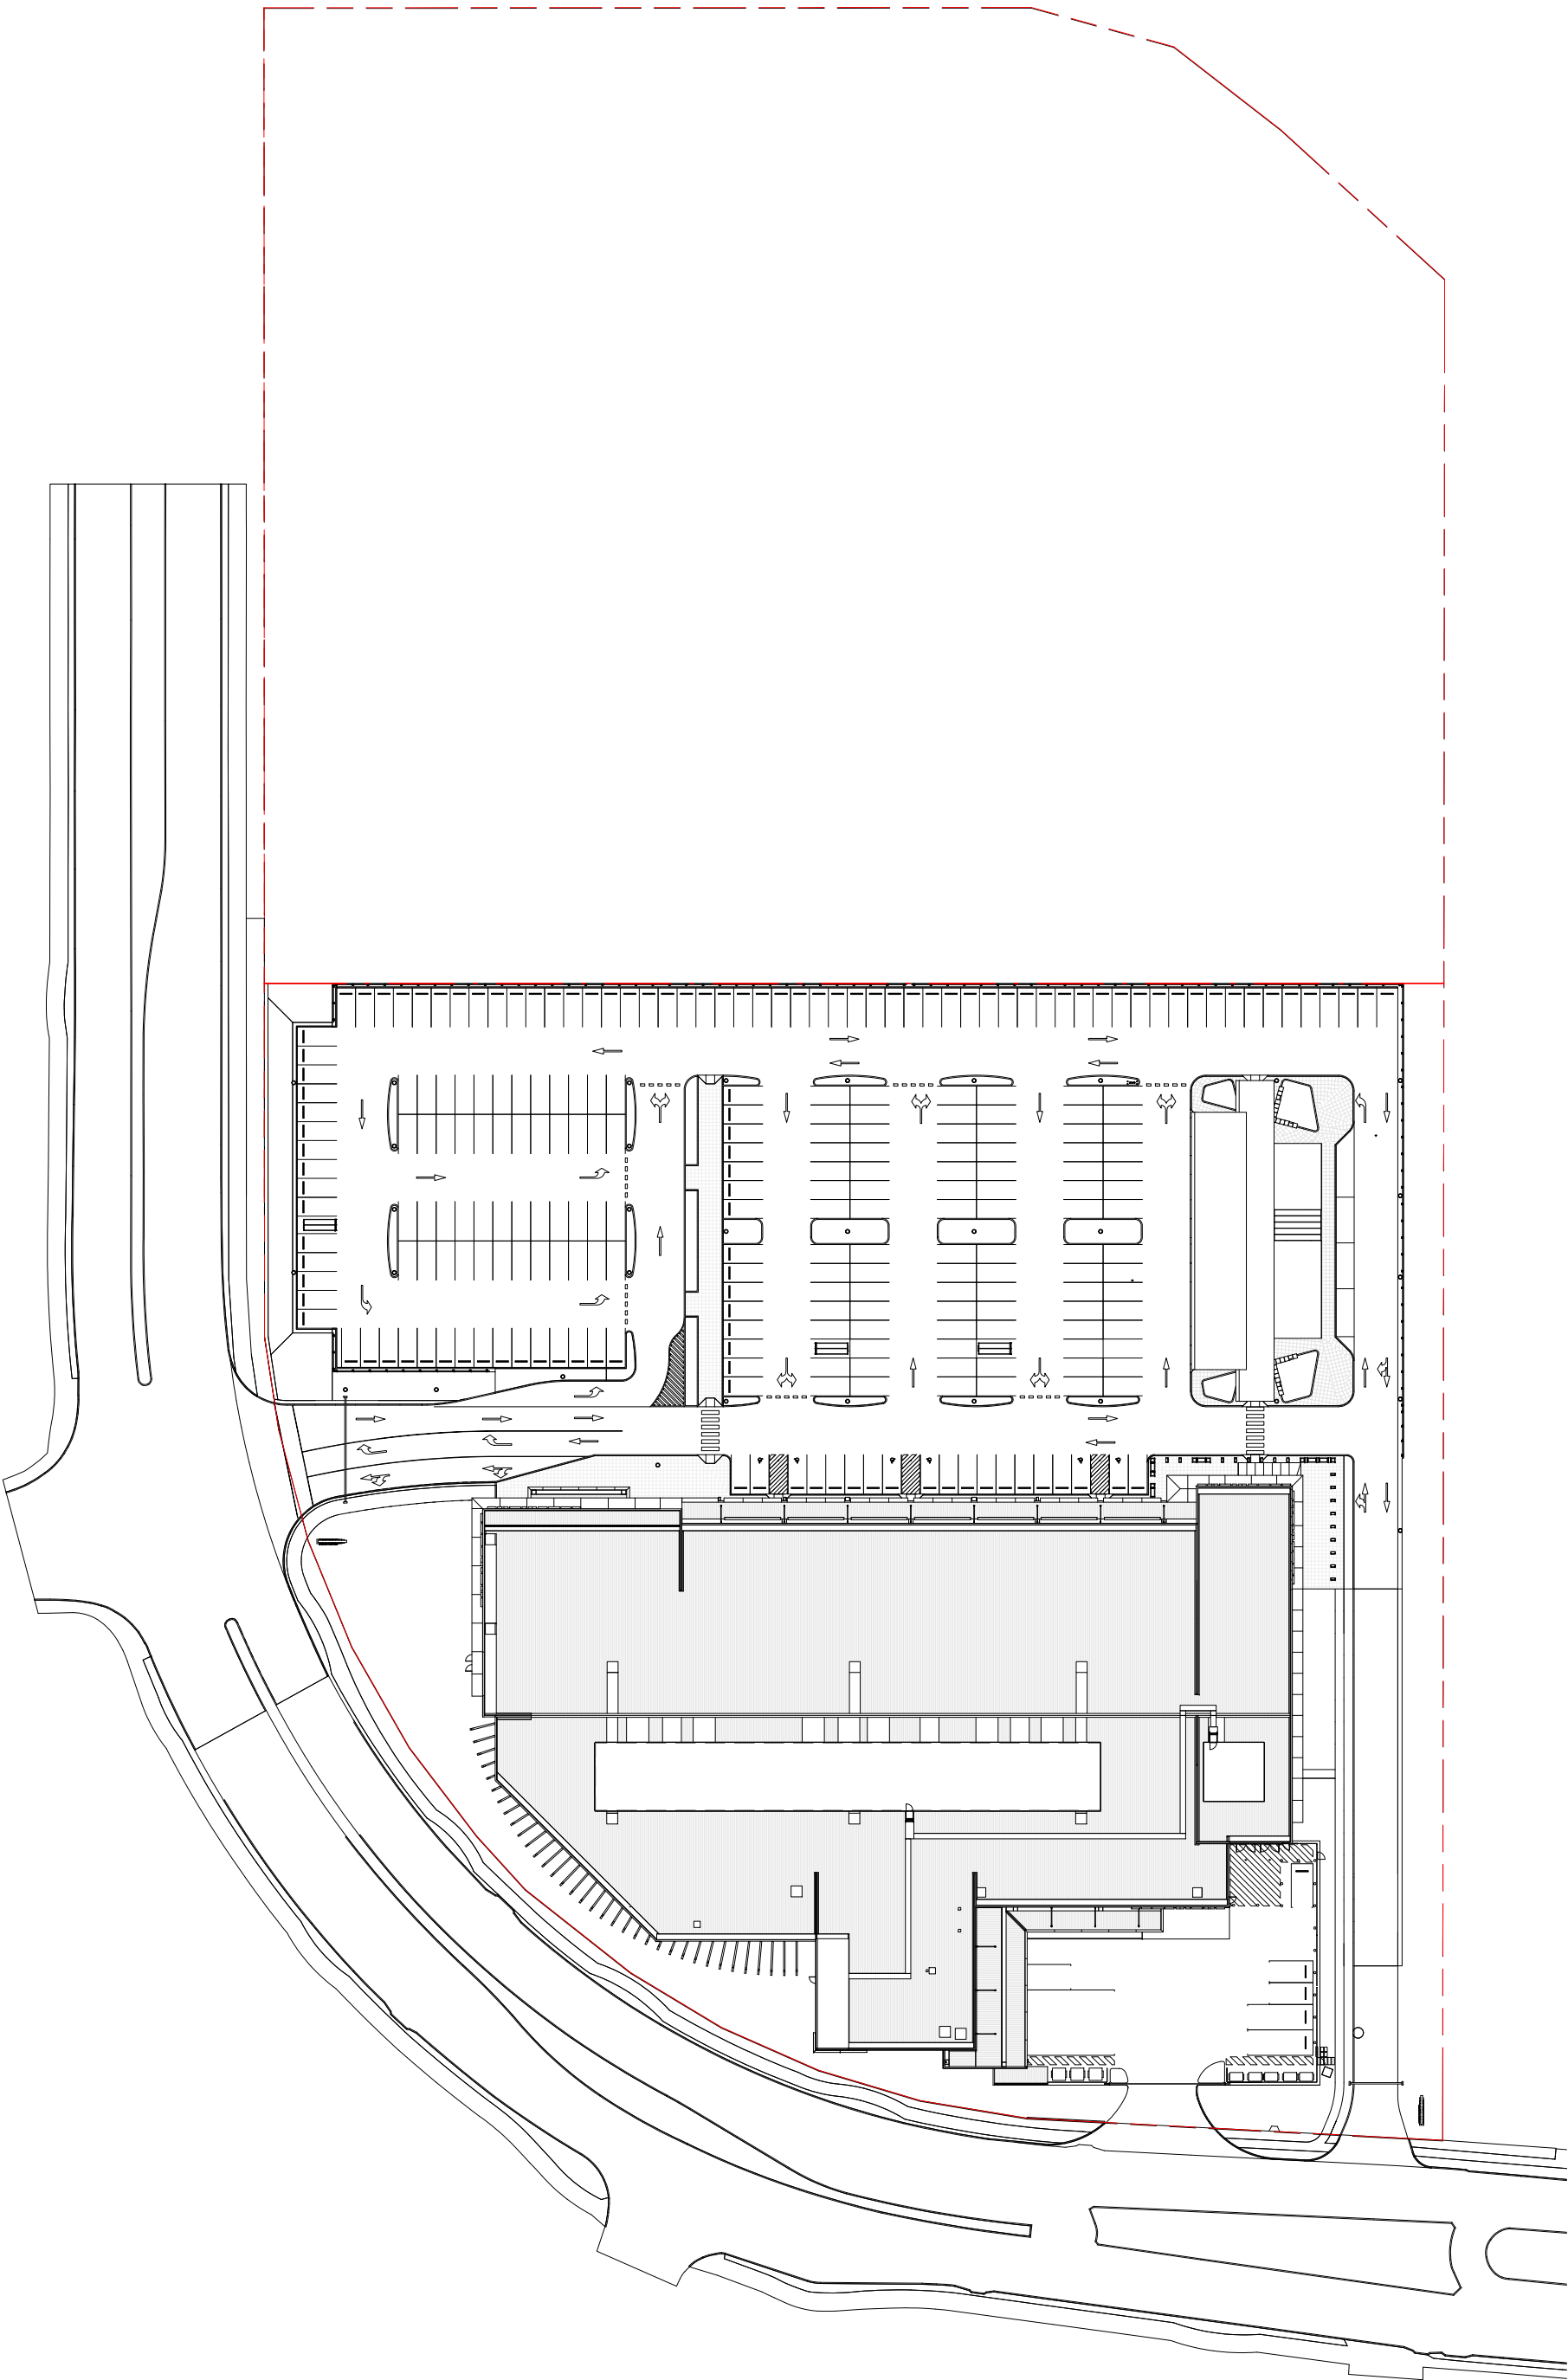

Rev.	Date	Description	Iss.	Appr.
B	28.03.2019	DEVELOPMENT APPLICATION	MB	BW

Do not scale this drawing. Verify all dimensions on site before commencing any work. Copyright © 2019 Buchan. This drawing remains the property of The Buchan Group Australia Pty Ltd. Reproduction in whole or in part without prior consent is forbidden.

File
X:\71717006_REVIT\DA

Project
MAROOCHYDORE
STAGE 1 DA
53-79 DALTON DRIVE

Project Number
717006

Status
DEVELOPMENT APPLICATION

Date Plotted
28-Mar-19 10:13:13 AM

Date Issued
28.03.2019

Scale
Not to scale

Drawing Title
TITLE SHEET

Drawing Number
A-DA-0000

Revision
B

BUCHAN

Brisbane Studio
+ 61 7 3859 9222 / buchangroup.com.au

DEVELOPMENT SCHEDULE

AREA & CARPARKING

NET LETTABLE AREA*	AREA m²
CAFE	163 m²
TENANCY 01	1872 m²
TENANCY 02	886 m²
TENANCY 03	759 m²
TENANCY 04	834 m²
TENANCY 05	551 m²
TENANCY 06	537 m²
ANCHOR	5462 m²
TOTAL NLA	11064 m²

SITE AREA	AREA m²
STAGE 1 SITE	22457 m²

CARPARKING	CARS
PROVIDED	
GROUND	270 CARS
TOTAL PROVIDED	270 CARS


REQUIRED	
PDA PLANNING / SHOWROOM (2:100)	207 CARS
PDA PLANNING / F&B (5:100)	8 CARS
PDA PLANNING / GYM (5:100)	26 CARS
TOTAL REQUIRED	241 CARS

SURPLUS / DEFICIT	
PDA PLANNING	+ 29 CARS

RATIO PROVIDED	2.4 : 100
----------------	-----------

ALL FIGURES ARE APPROXIMATE.

* NLA CALCULATED BY PROPERTY COUNCIL OF AUSTRALIA
METHOD OF MEASURE (GLA-R).

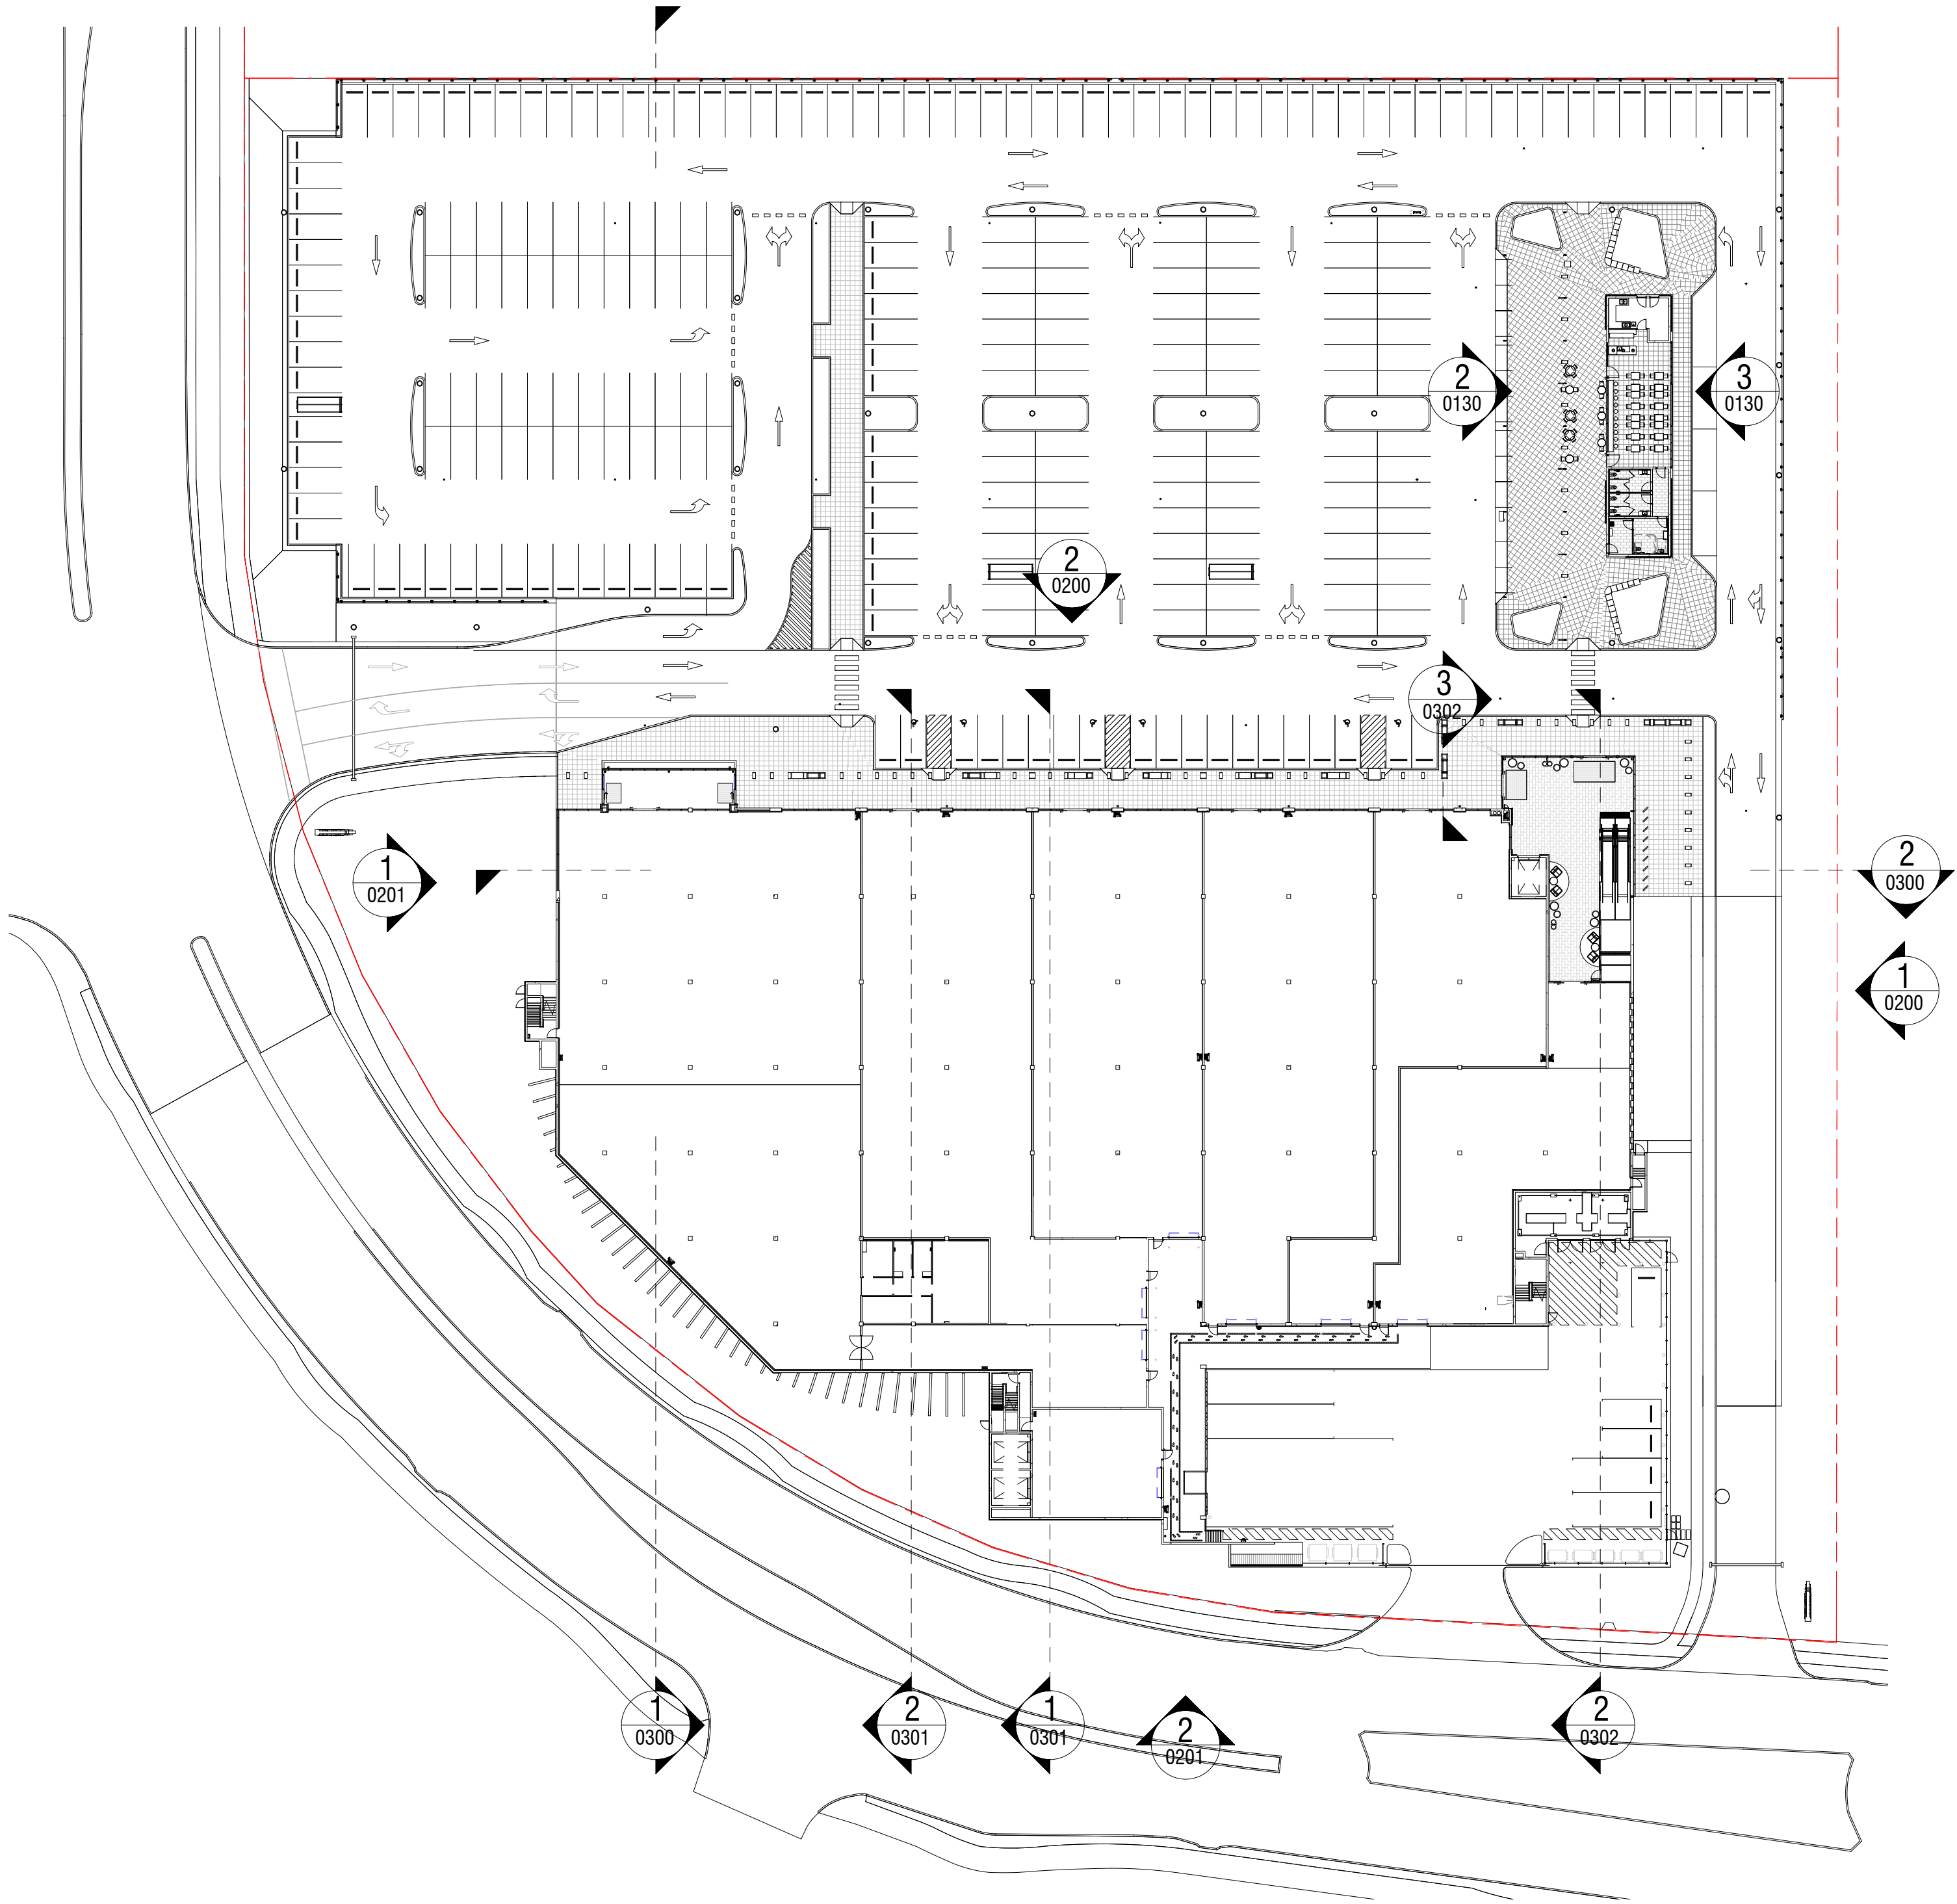

Do not scale this drawing. Verify all dimensions on site before commencing any work. Copyright © 2019 Buchan. This drawing remains the property of The Buchan Group Australia Pty Ltd. Reproduction in whole or in part without prior consent is forbidden.

File
X:\717\717006\REVIT\DA

Project
MAROOCHYDORE
STAGE 1 DA
53-79 DALTON DRIVE

Project Number
717006

Status
DEVELOPMENT APPLICATION

Date Plotted
28-Mar-19 10:13:27 AM

Date Issued
28.03.2019

Scale
1 : 500 @A2

0 2.5 5 10 15 20 25M


Drawing Title
KEY PLAN

Drawing Number
A-DA-0001

Revision
B

BUCHAN

Brisbane Studio
+ 61 7 3859 9222 / buchangroup.com.au

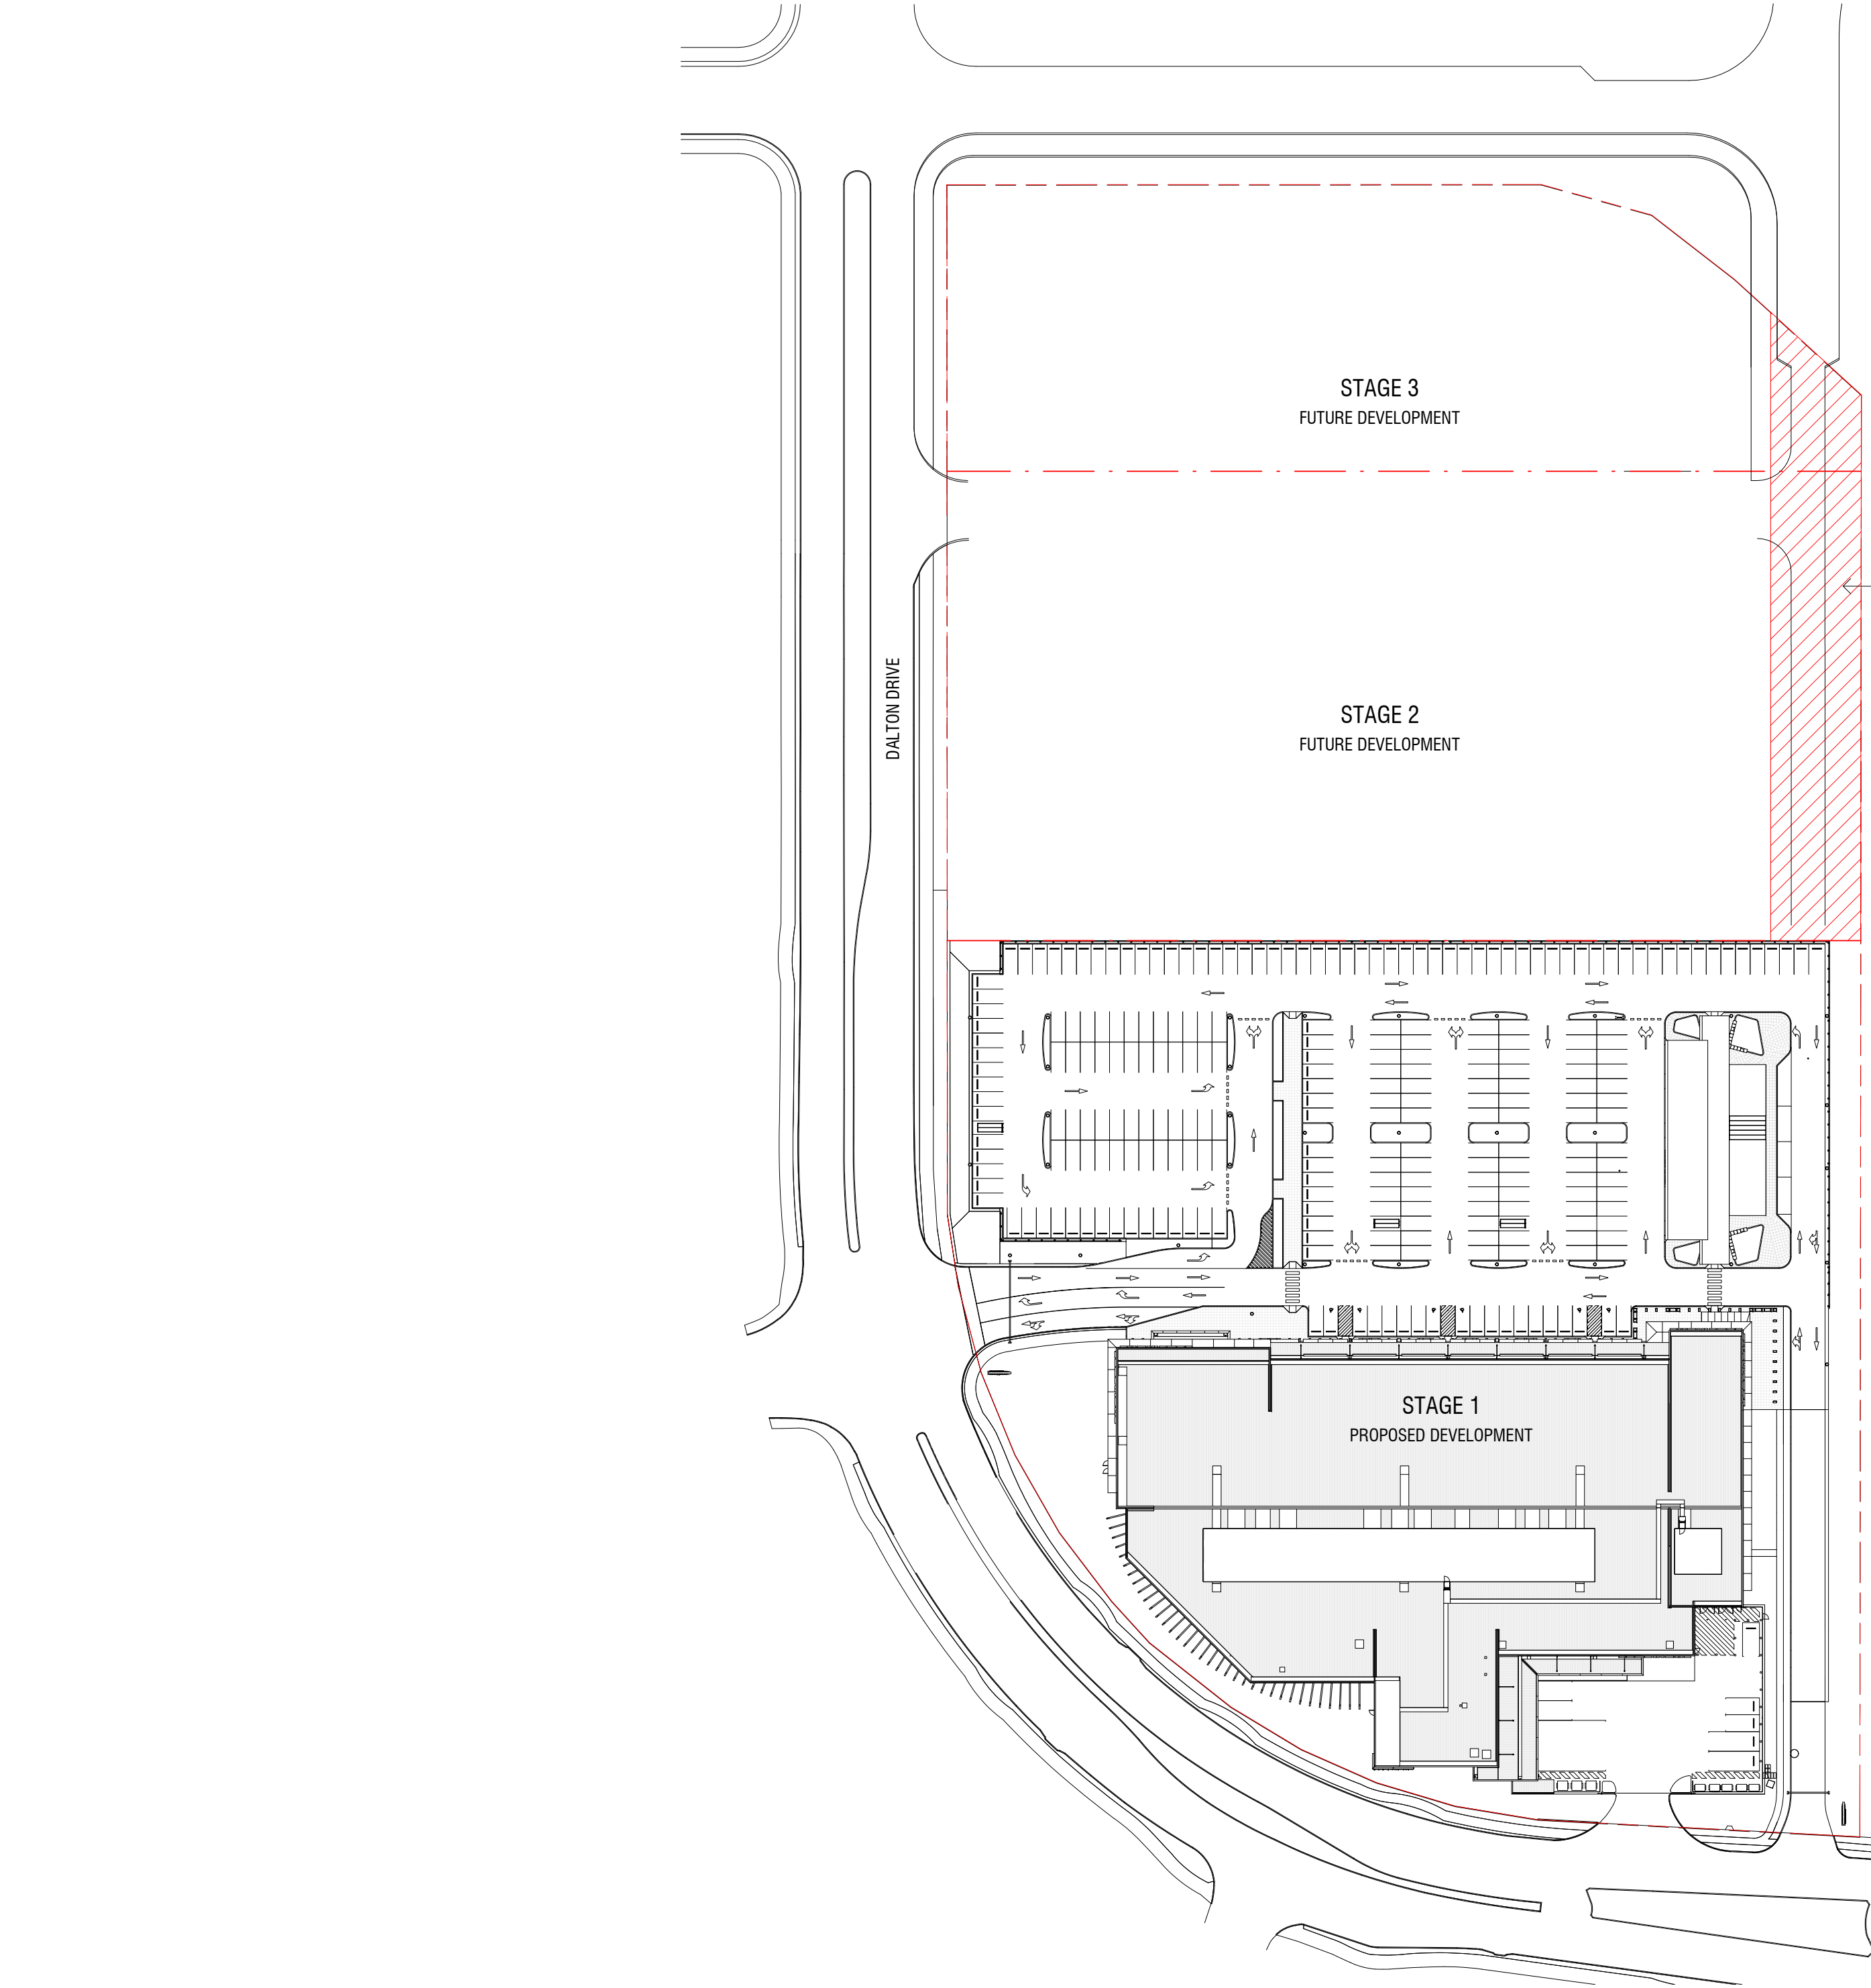

Rev.	Date	Description	Iss.	Appr.
B	28.03.2019	DEVELOPMENT APPLICATION	MB	BW

Do not scale this drawing. Verify all dimensions on site before commencing any work. Copyright © 2019 Buchan. This drawing remains the property of The Buchan Group Australia Pty Ltd. Reproduction in whole or in part without prior consent is forbidden.

File
X:\717\717006\REVIT\DA

Project
MAROOCHYDORE
STAGE 1 DA
53-79 DALTON DRIVE

Project Number	717006
Status	FOR INFORMATION
Date Plotted	28-Mar-19 10:13:39 AM
Date Issued	28.03.2019
Scale	1 : 900 @A2
04.5918273645M	

Drawing Title
MASTERPLAN


Drawing Number	A-DA-0002	Revision	B
----------------	-----------	----------	---

BUCHAN

Brisbane Studio
+ 61 7 3859 9222 / buchangroup.com.au

Do not scale this drawing. Verify all dimensions on site before commencing any work. Copyright © 2019 Buchan. This drawing remains the property of The Buchan Group Australia Pty Ltd. Reproduction in whole or in part without prior consent is forbidden.

File
X:\717171006_REVIT\DA

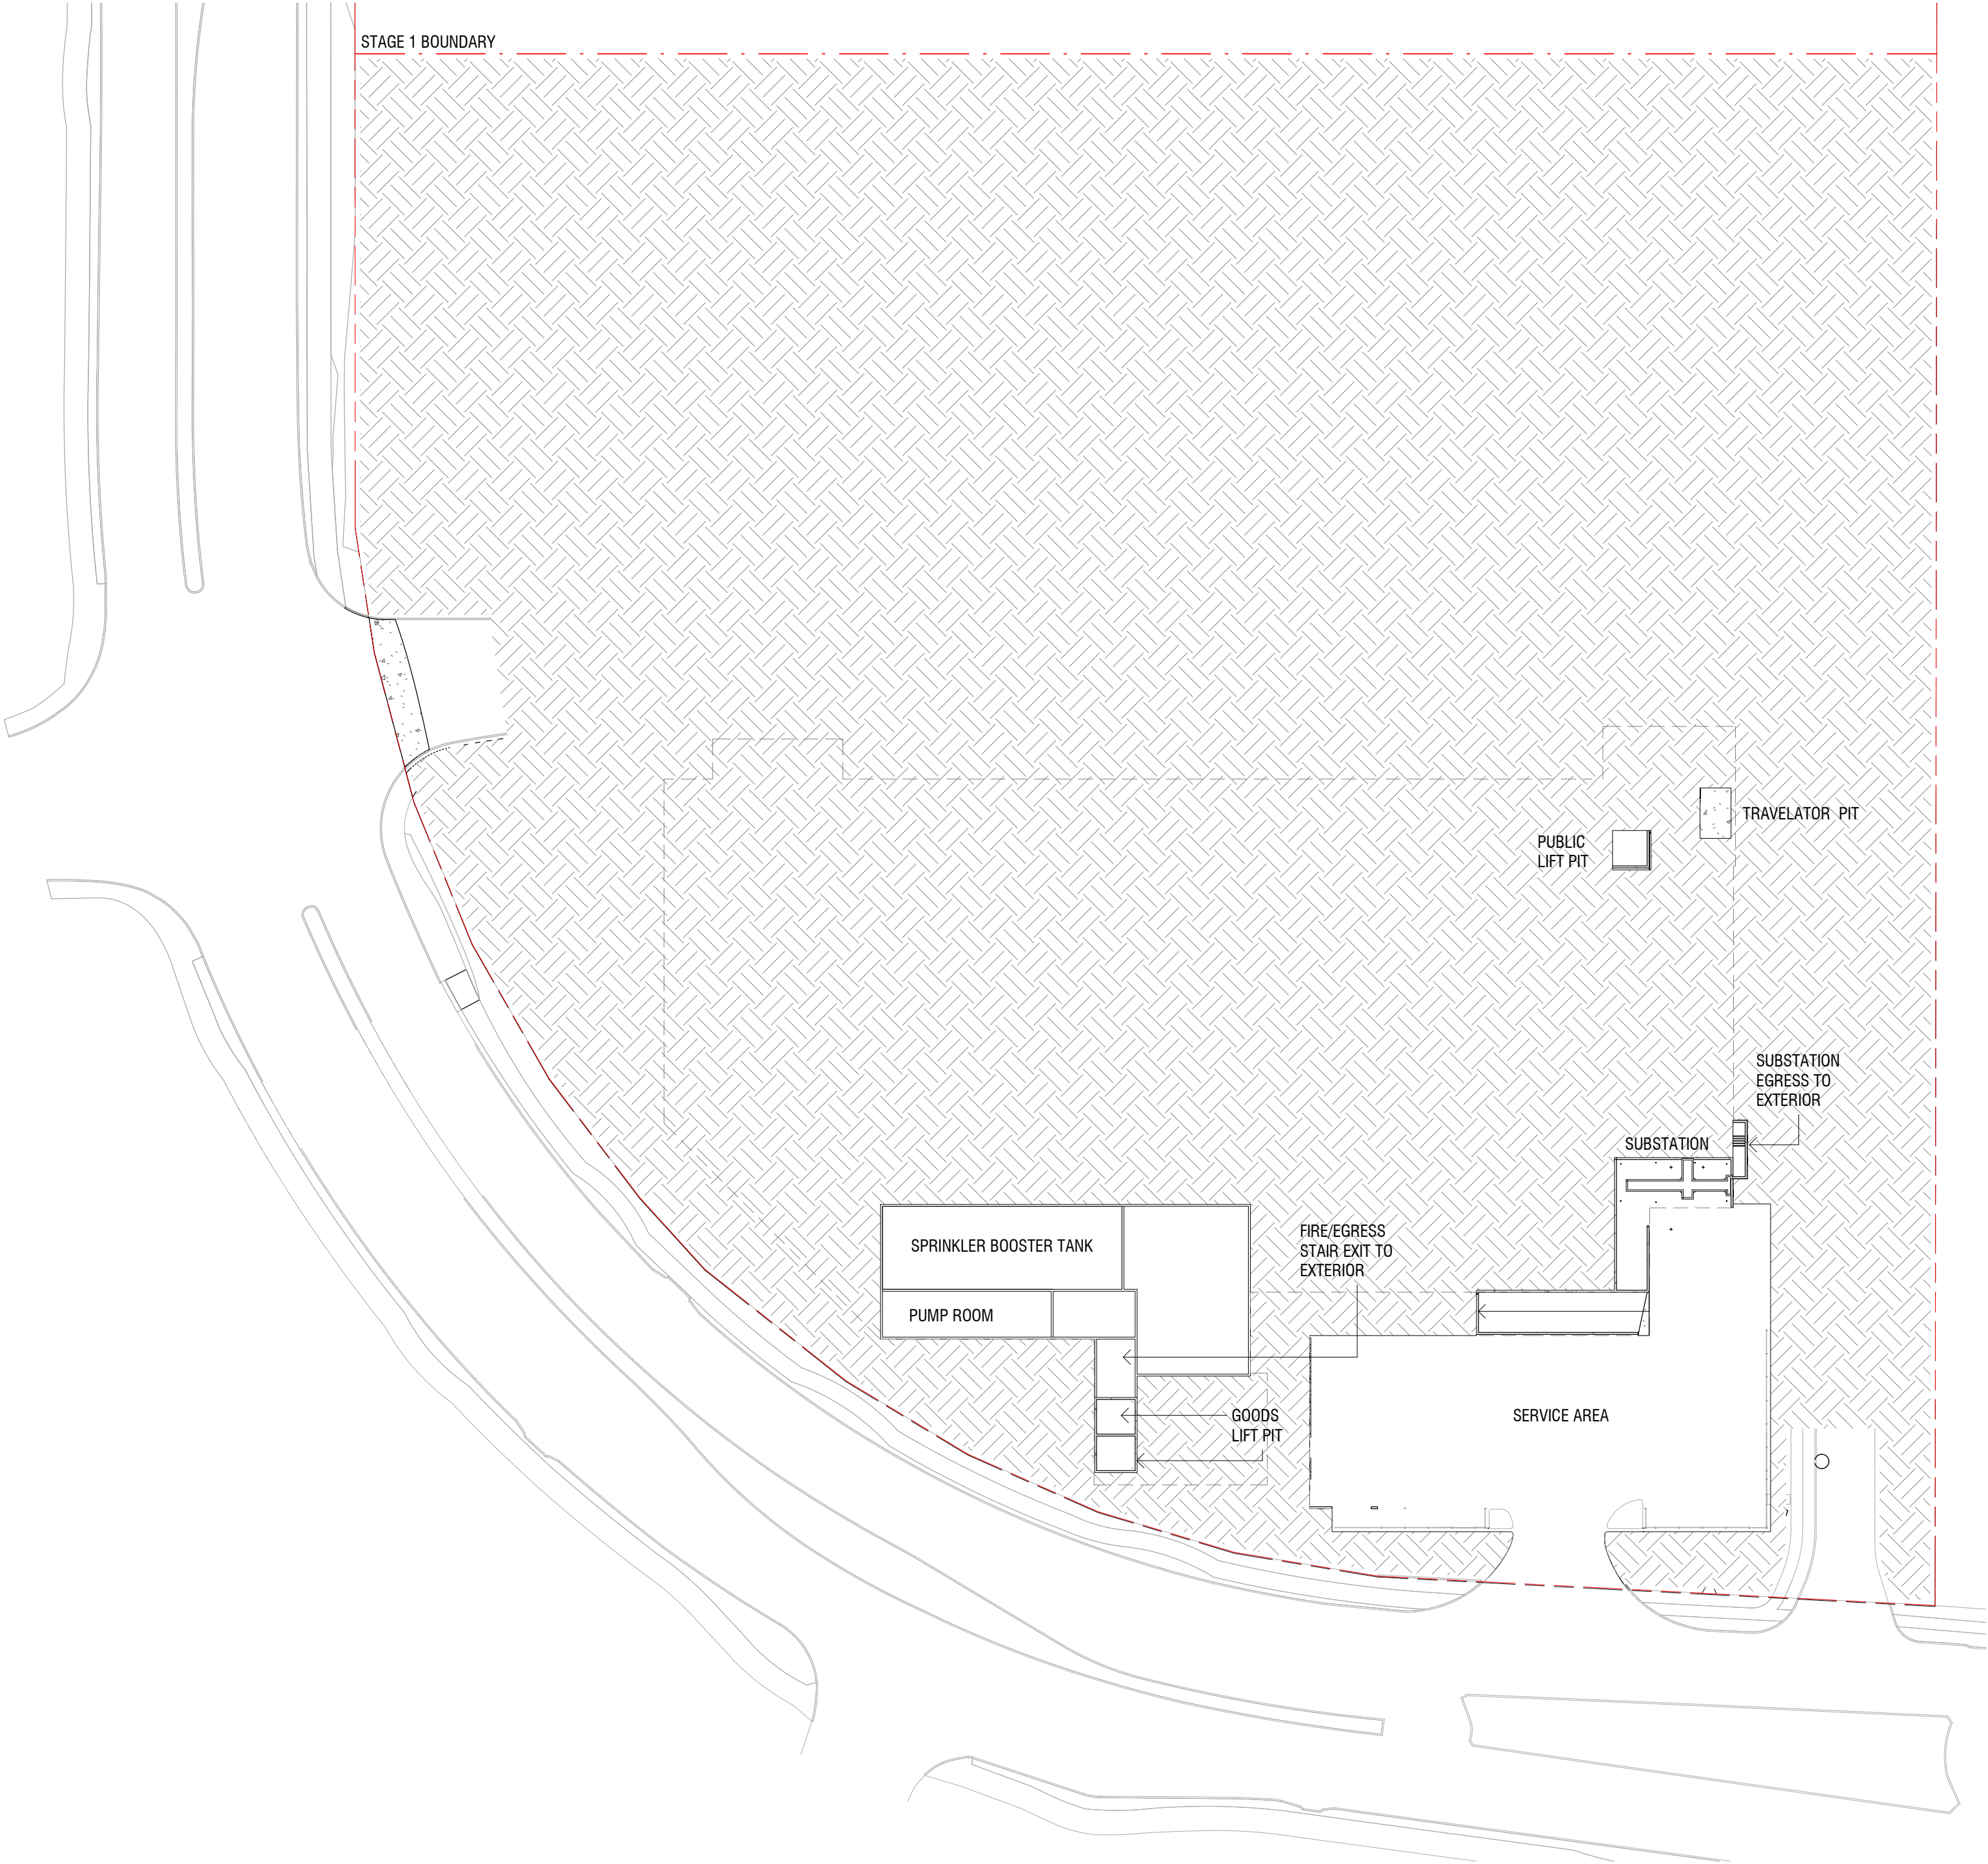

Project
MAROOCHYDORE
STAGE 1 DA
53-79 DALTON DRIVE

Project Number
717006

Status
DEVELOPMENT APPLICATION

Date Plotted
28-Mar-19 10:14:09 AM

Date Issued
28.03.2019

Scale
1 : 500 @A2

Drawing Title
BASEMENT PLAN

Drawing Number
A-DA-0100


Revision
B

BUCHAN

Brisbane Studio
+ 61 7 3859 9222 / buchangroup.com.au

Do not scale this drawing. Verify all dimensions on site before commencing any work. Copyright © 2019 Buchan. This drawing remains the property of The Buchan Group Australia Pty Ltd. Reproduction in whole or in part without prior consent is forbidden.

File
X:\717\717006_REVIT\DA

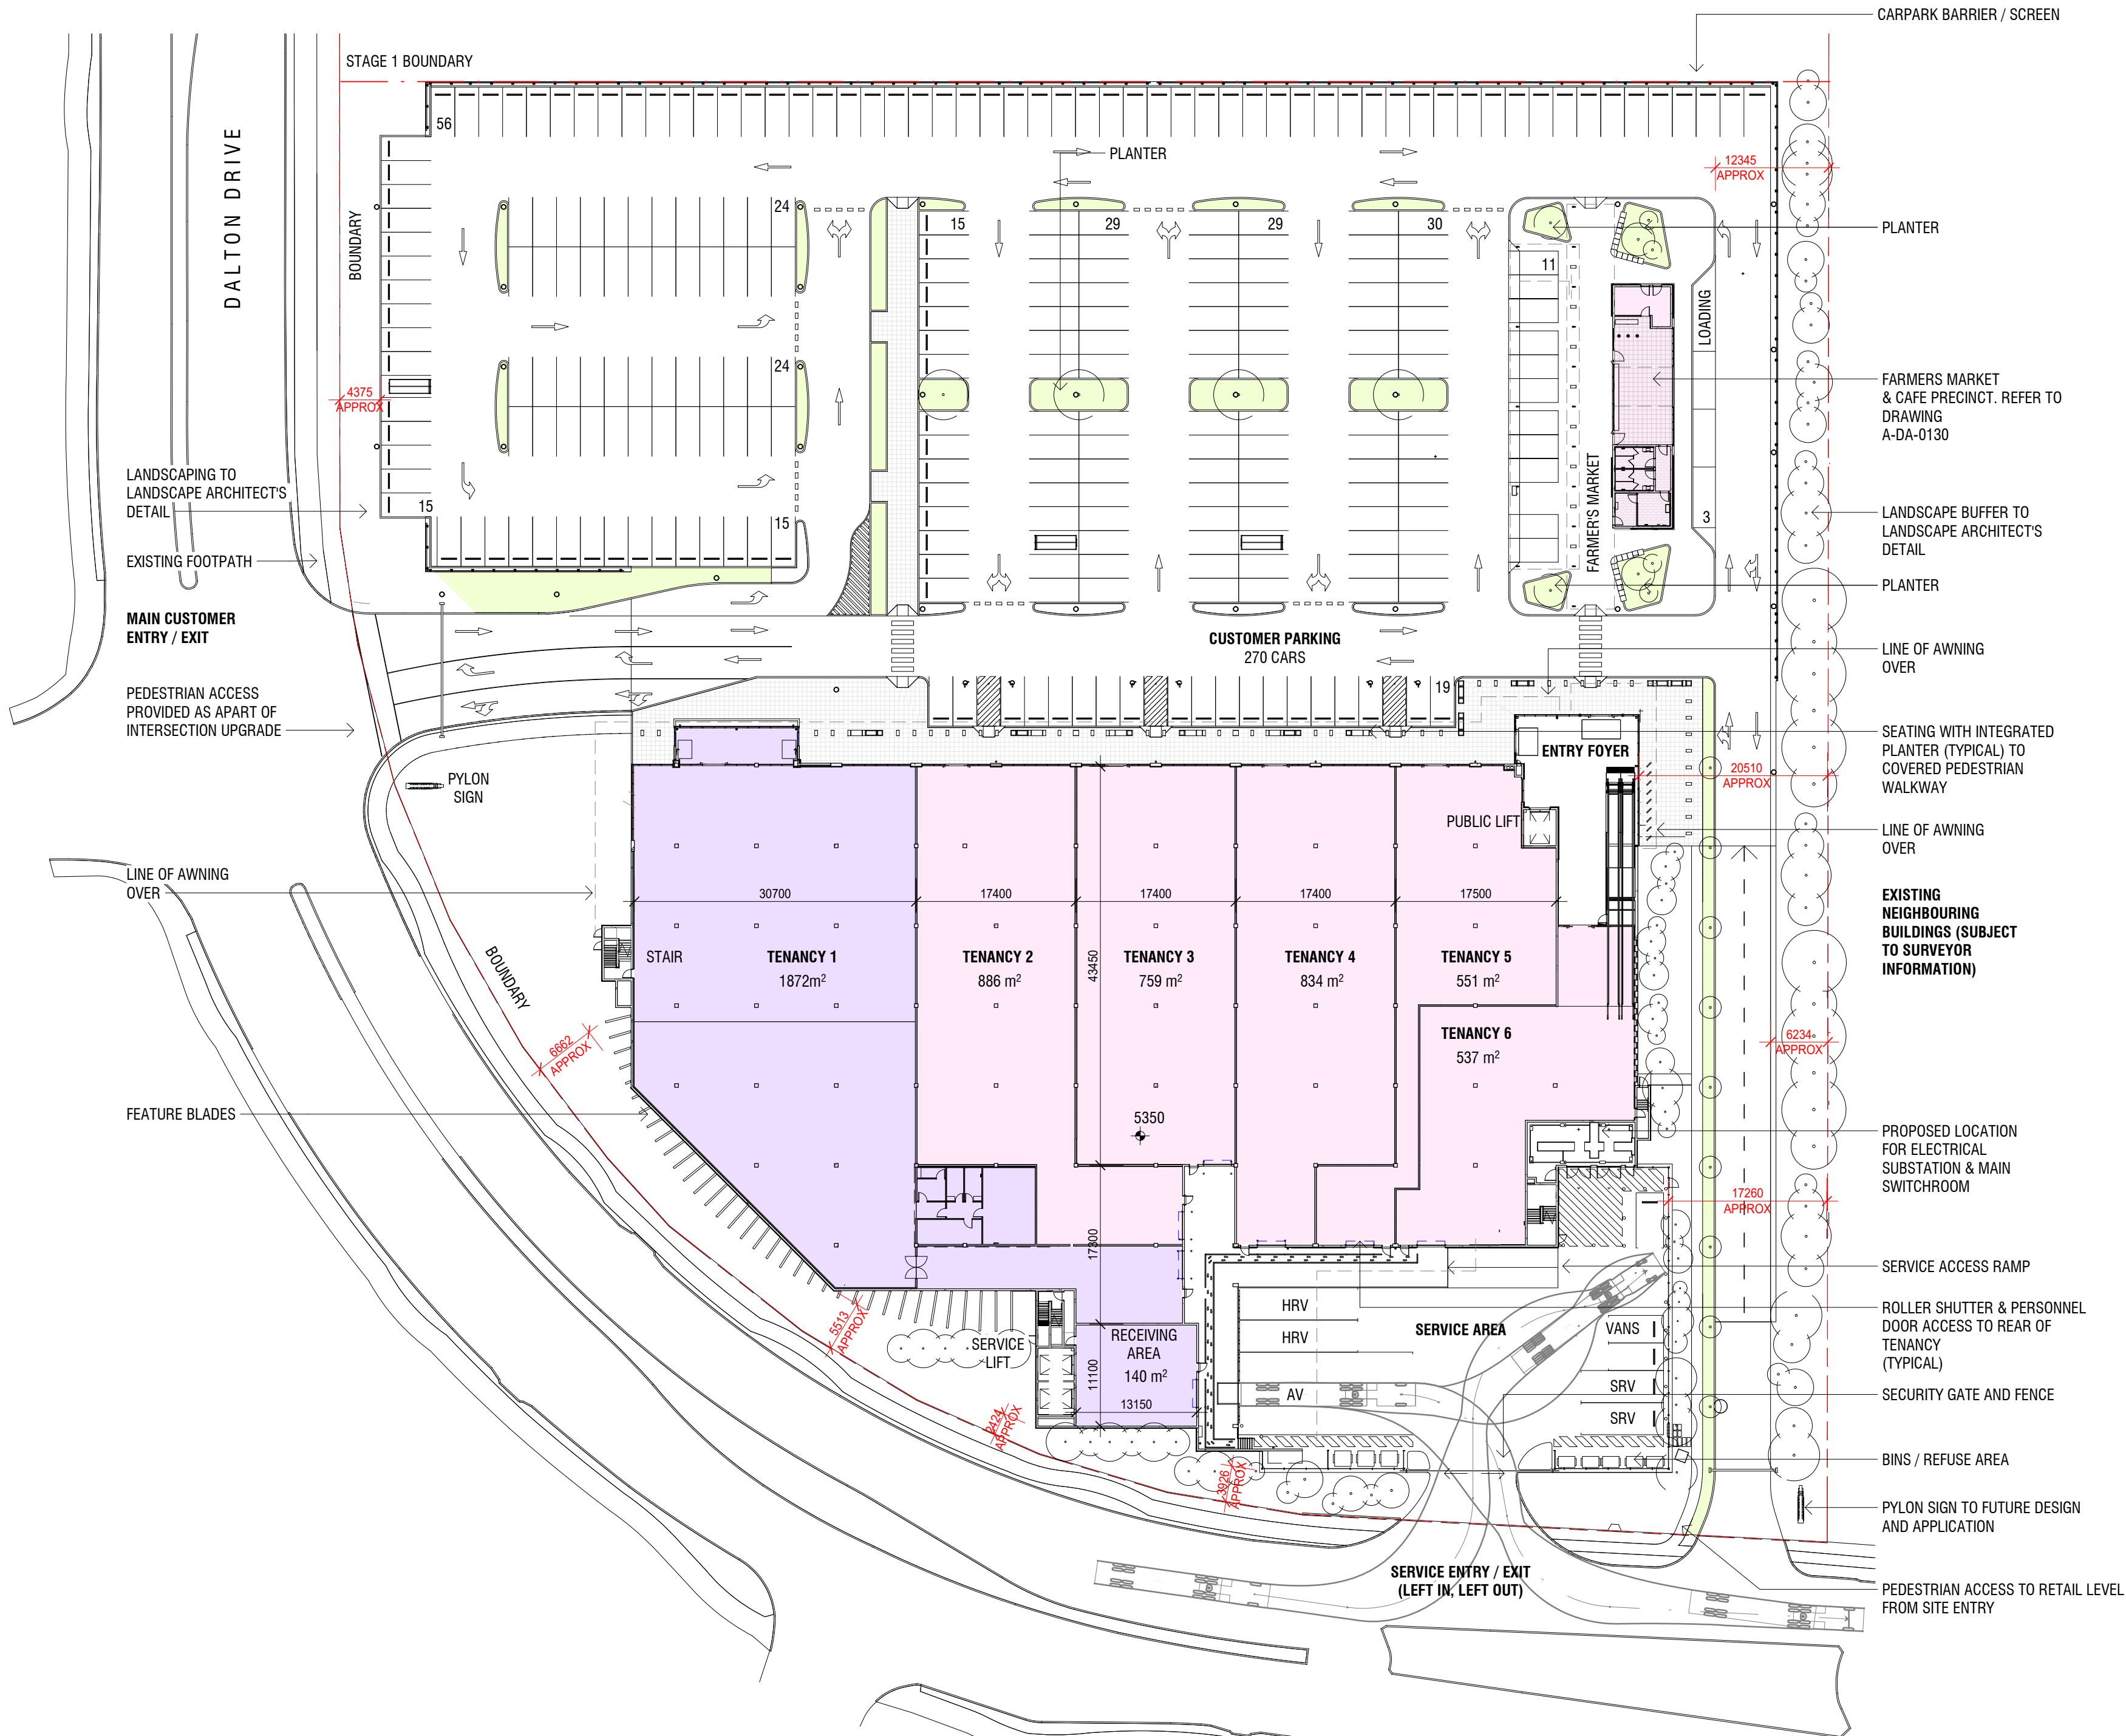

Project
MAROOCHYDORE
STAGE 1 DA
53-79 DALTON DRIVE

Project Number
717006

Status
DEVELOPMENT APPLICATION

Date Plotted
28-Mar-19 10:14:50 AM

Date Issued
28.03.2019

Scale
1 : 500 @A2

Drawing Title
GROUND PLAN

Drawing Number
A-DA-0101

Revision
B

BUCHAN

Brisbane Studio
+ 61 7 3859 9222 / buchangroup.com.au

Do not scale this drawing. Verify all dimensions on site before commencing any work. Copyright © 2019 Buchan. This drawing remains the property of The Buchan Group Australia Pty Ltd. Reproduction in whole or in part without prior consent is forbidden.

File
X:\717\717006_REVIT\DA

Project
MAROOCHYDORE
STAGE 1 DA
53-79 DALTON DRIVE

Project Number
717006
Status
DEVELOPMENT APPLICATION


Date Plotted 28-Mar-19 10:15:32 AM
Date Issued 28.03.2019
Scale 1 : 500 @A2

Drawing Title
LEVEL 1 PLAN

Drawing Number
A-DA-0102
Revision
B

BUCHAN

Brisbane Studio
+ 61 7 3859 9222 / buchangroup.com.au

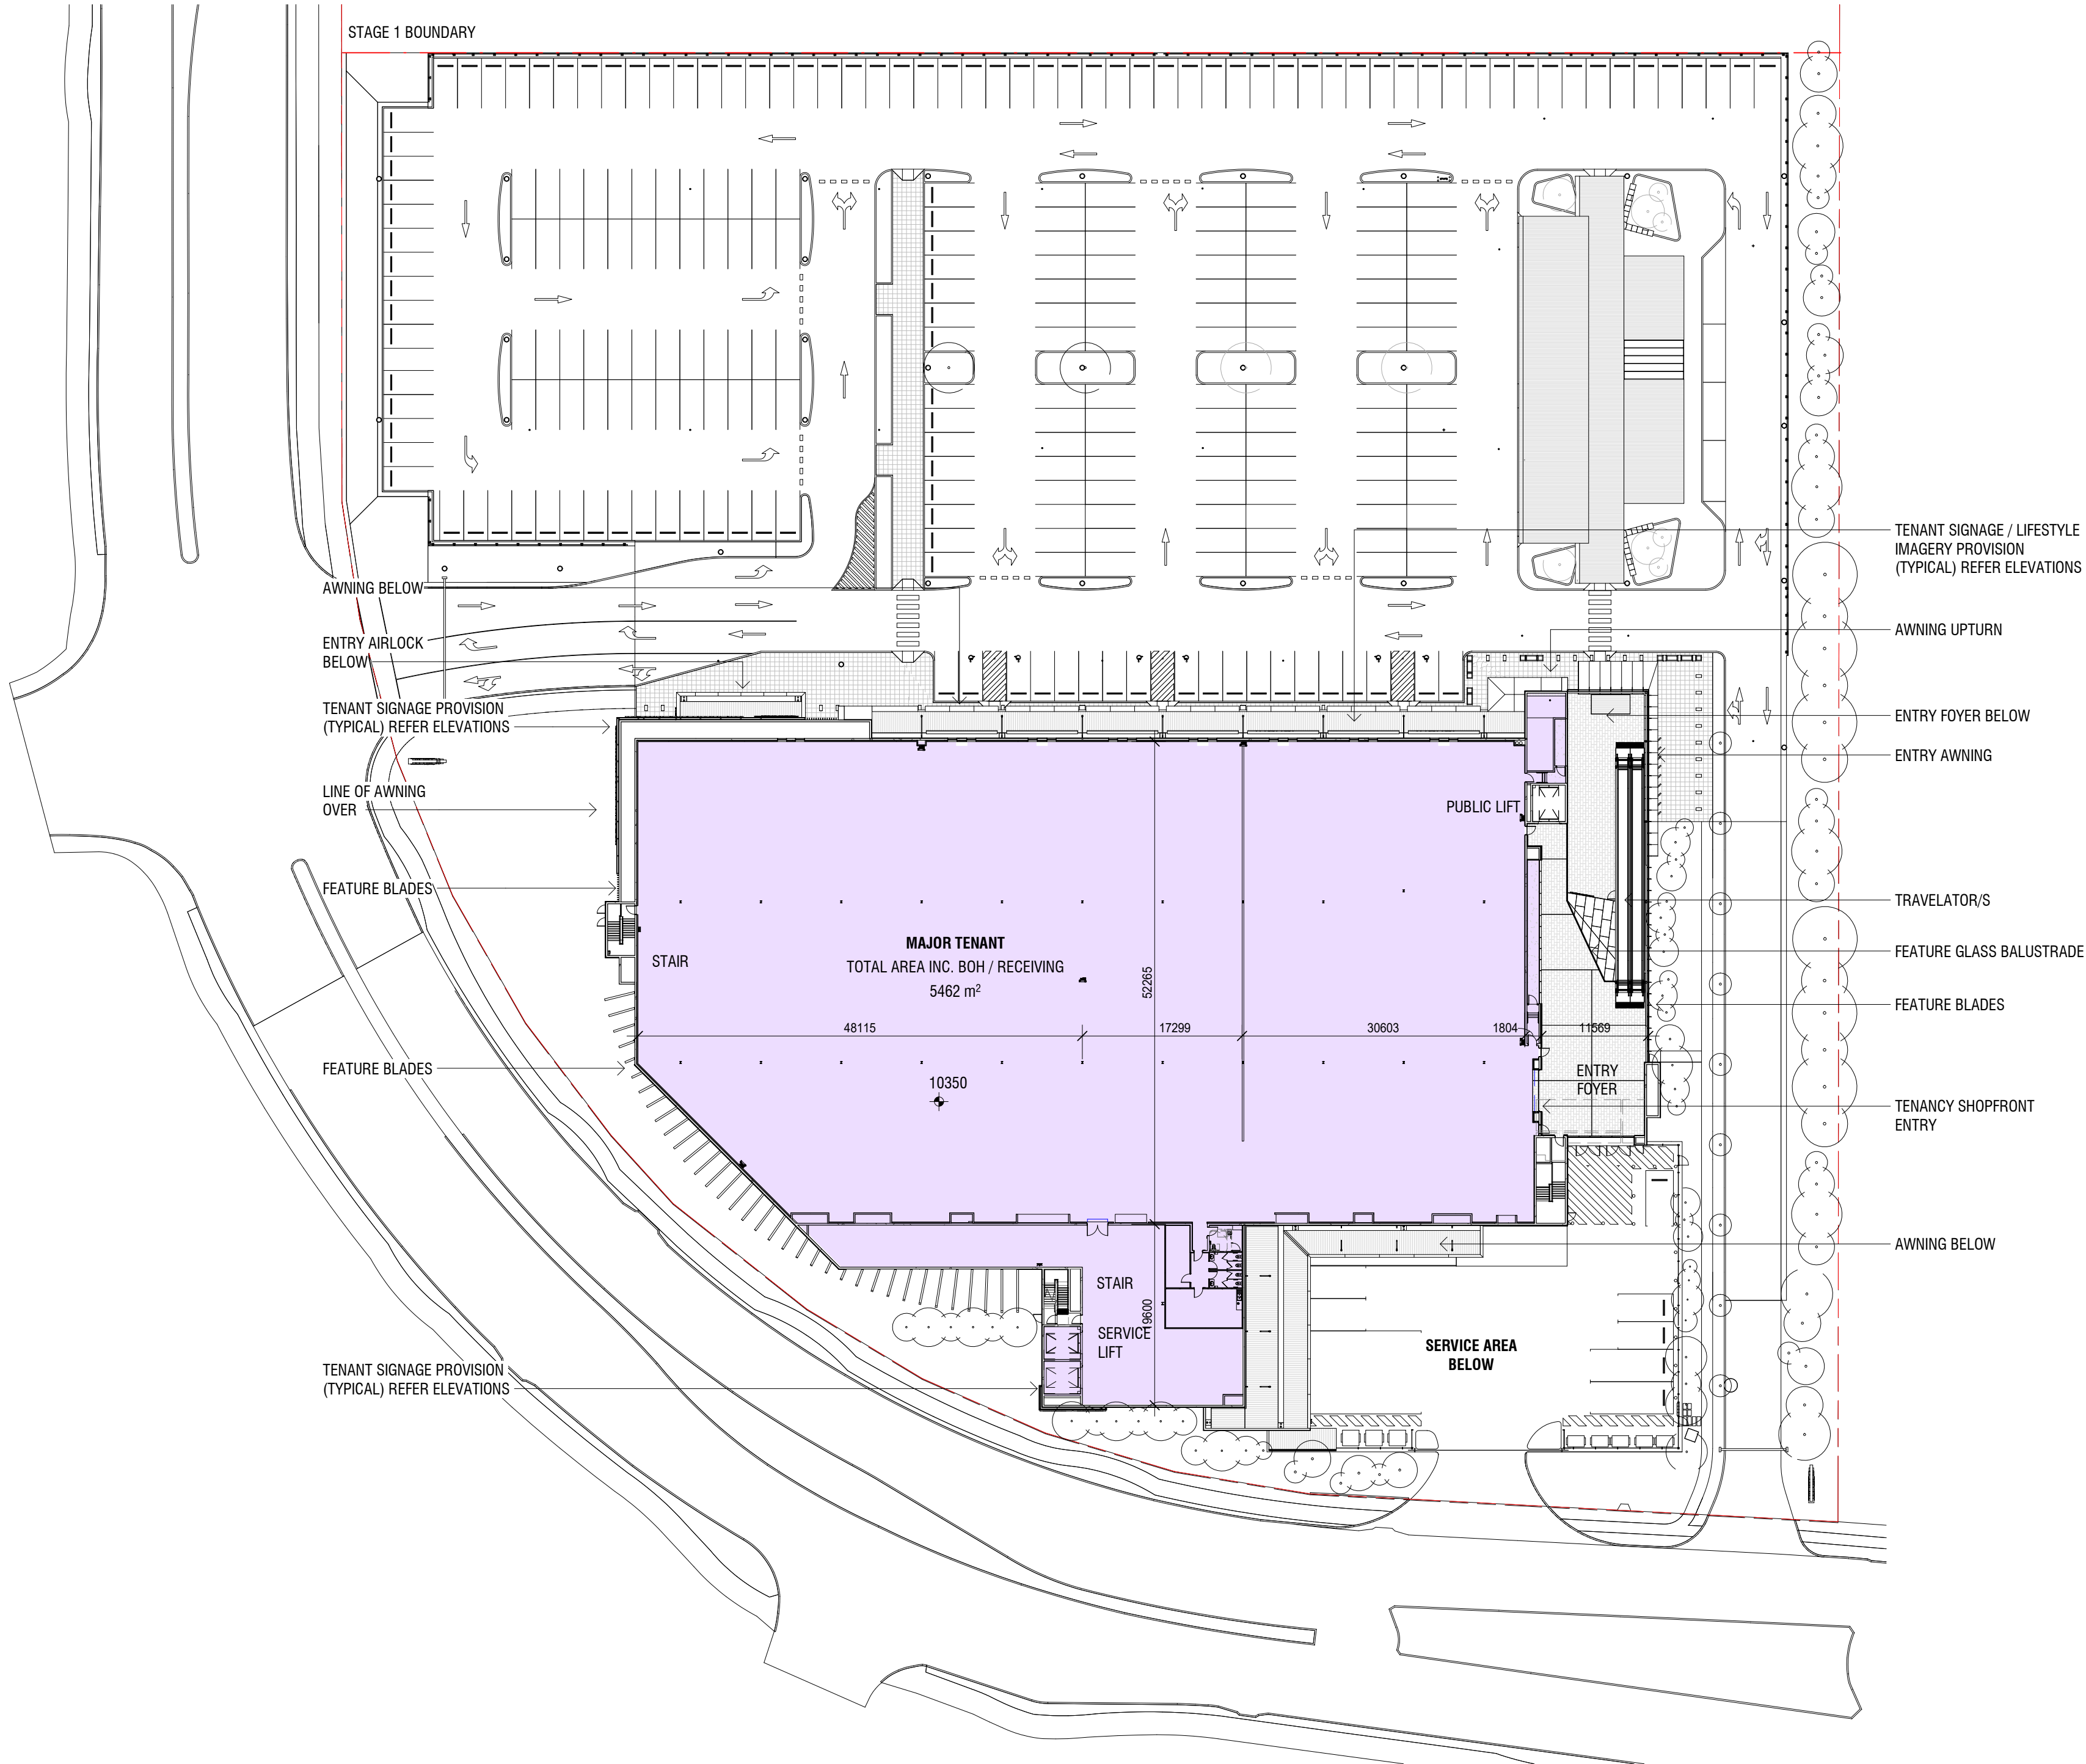

Do not scale this drawing. Verify all dimensions on site before commencing any work. Copyright © 2019 Buchan. This drawing remains the property of The Buchan Group Australia Pty Ltd. Reproduction in whole or in part without prior consent is forbidden.

File
X:\717\717006_REVIT\DA

MAJOR TENANT SIGNAGE
(TYPICAL) REFER TO
ELEVATIONS

PARAPET EXTENSION
TO PRIMARY FACADE
ELEMENTS (TYPICAL)

SPOTLIGHT FEATURE
ENTRY

PARAPET EXTENSION
TO PRIMARY FACADE
ELEMENTS (TYPICAL)

ROOF ACCESS AND
SAFETY SYSTEM TO
FUTURE DESIGN

MAJOR TENANT SIGNAGE
(TYPICAL) REFER TO
ELEVATIONS

Project
MAROOCHYDORE
STAGE 1 DA
53-79 DALTON DRIVE


Project Number	717006
Status	DEVELOPMENT APPLICATION
Date Plotted	28-Mar-19 10:15:58 AM
Date Issued	28.03.2019
Scale	1 : 500 @A2

Drawing Title
ROOF PLAN


Drawing Number	A-DA-0120	Revision	B
----------------	-----------	----------	---

BUCHAN


Brisbane Studio
+ 61 7 3859 9222 / buchangroup.com.au

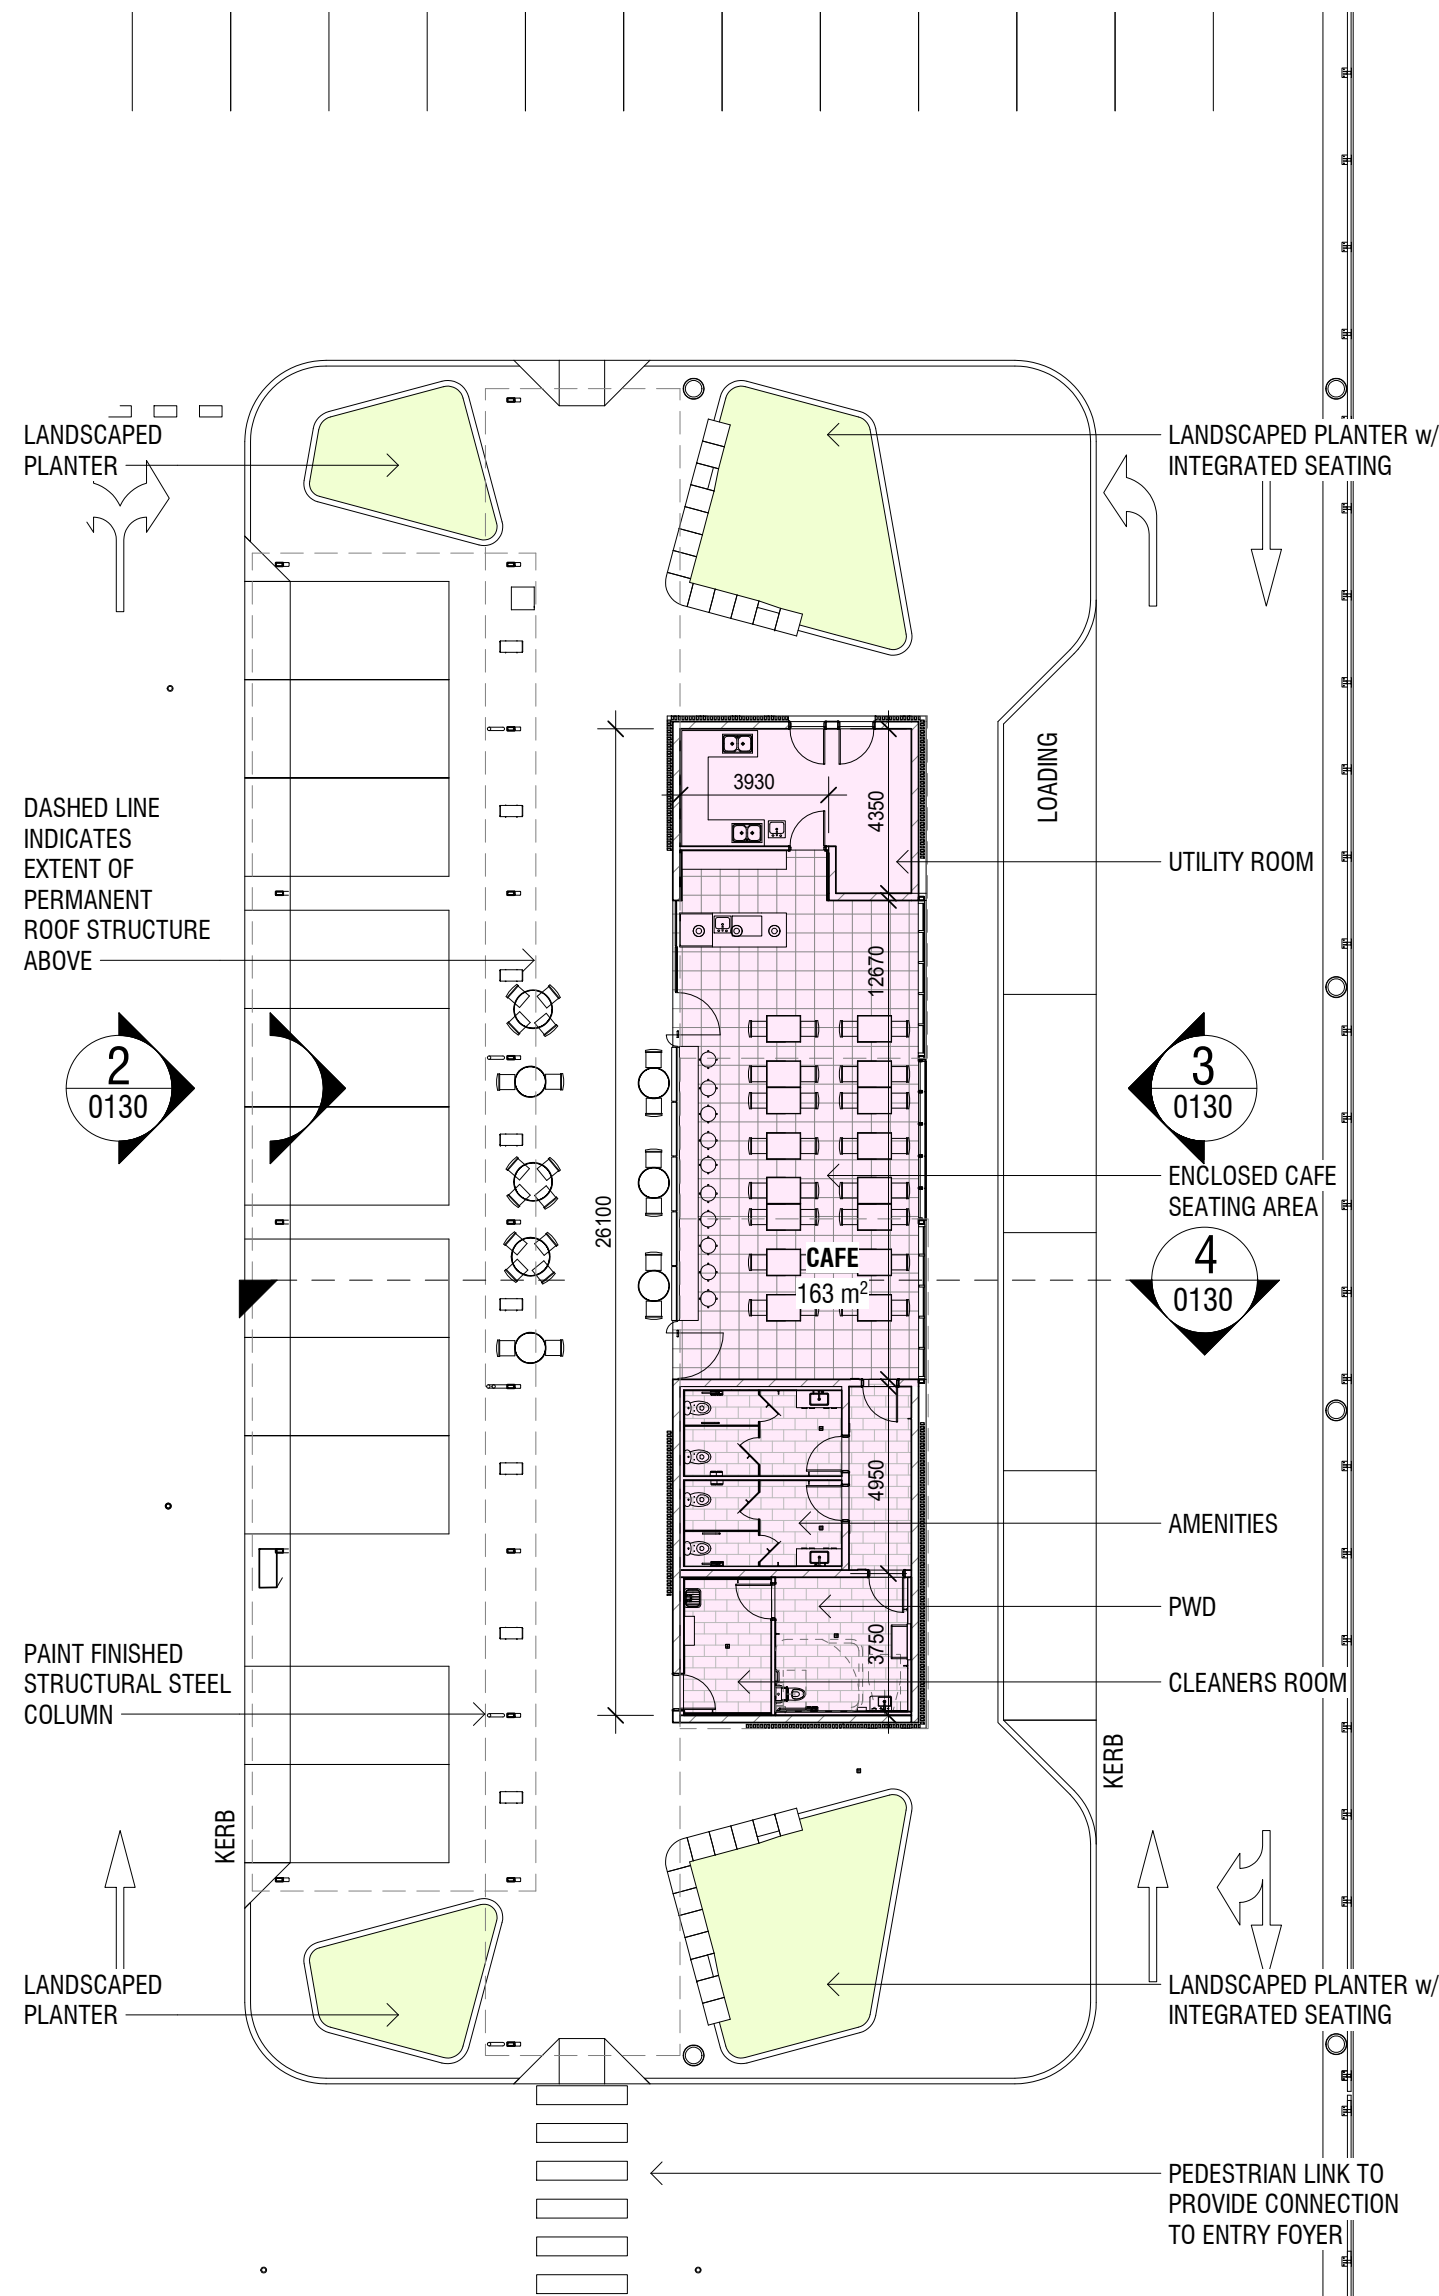


1 FARMERS MARKET PLAN
0300 1:200

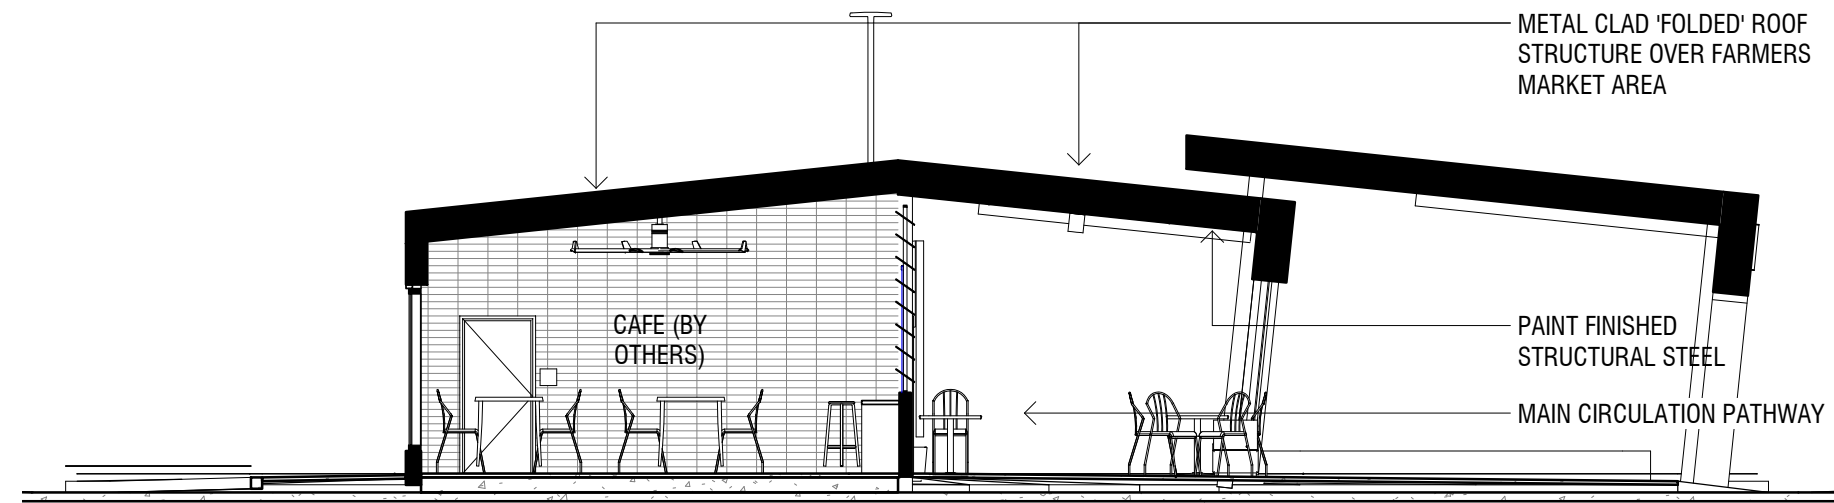

4 FARMERS MARKET SECTION
0130 1:100

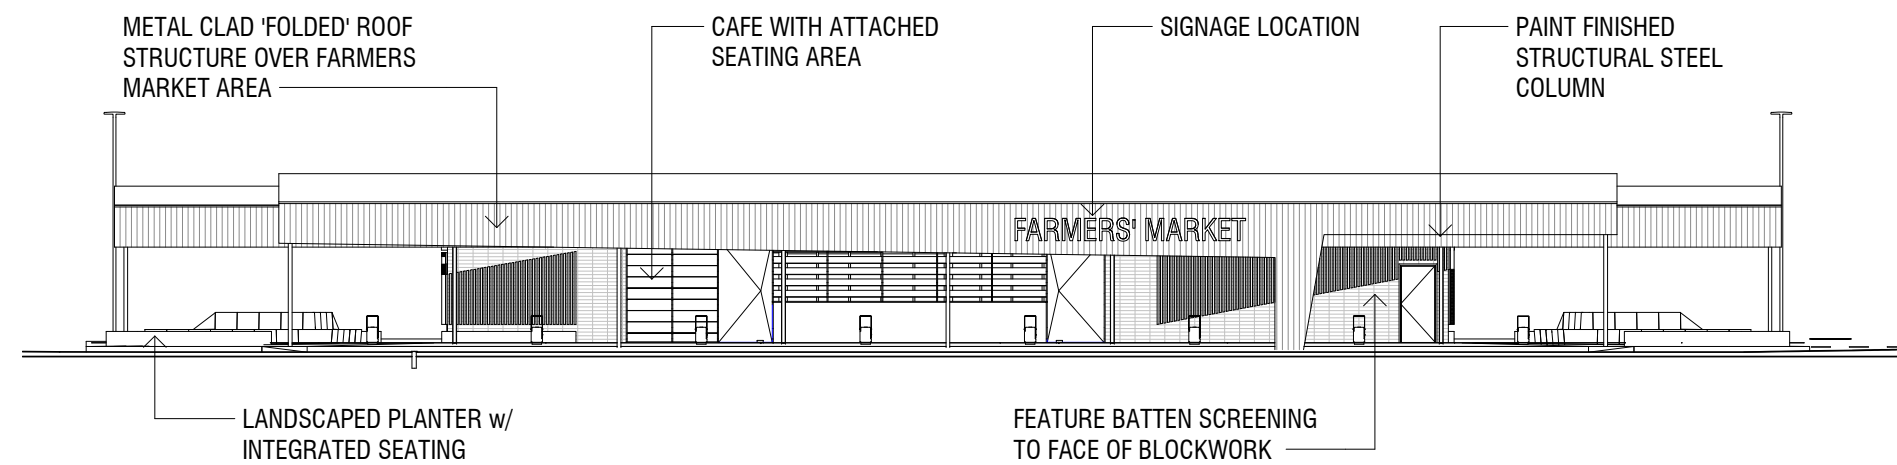

2 FARMERS MARKET WEST ELEVATION
0001 1:200

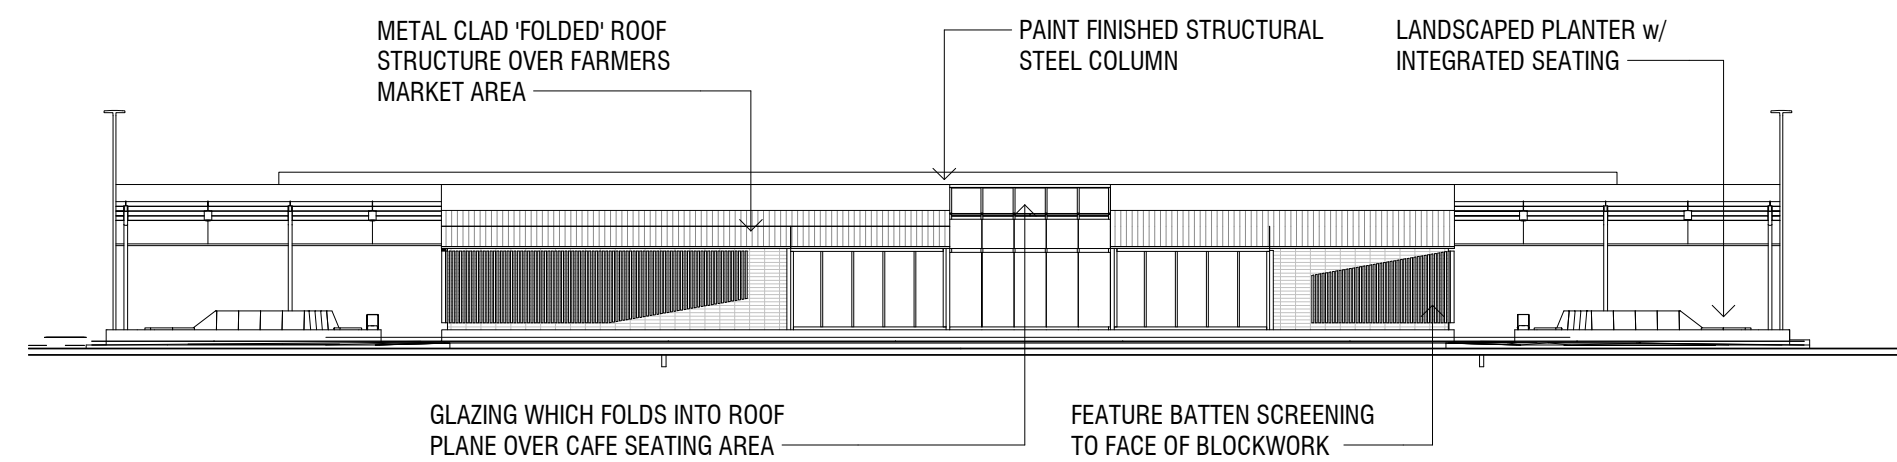

3 FARMERS MARKET EAST ELEVATION
0001 1:200

Do not scale this drawing. Verify all dimensions on site before commencing any work. Copyright © 2019 Buchan. This drawing remains the property of The Buchan Group Australia Pty Ltd. Reproduction in whole or in part without prior consent is forbidden.

File
X:\717\717006\REVIT\DA

Project
MAROOCHYDORE
STAGE 1 DA
53-79 DALTON DRIVE

Project Number
717006
Status
DEVELOPMENT APPLICATION


Date Plotted 28-Mar-19 10:16:22 AM
Date Issued 28.03.2019
Scale As indicated
0 1 2 4 6 8 10M

Drawing Title
FARMERS MARKET


Drawing Number
A-DA-0130
Revision
B

BUCHAN

Brisbane Studio
+ 61 7 3859 9222 / buchangroup.com.au

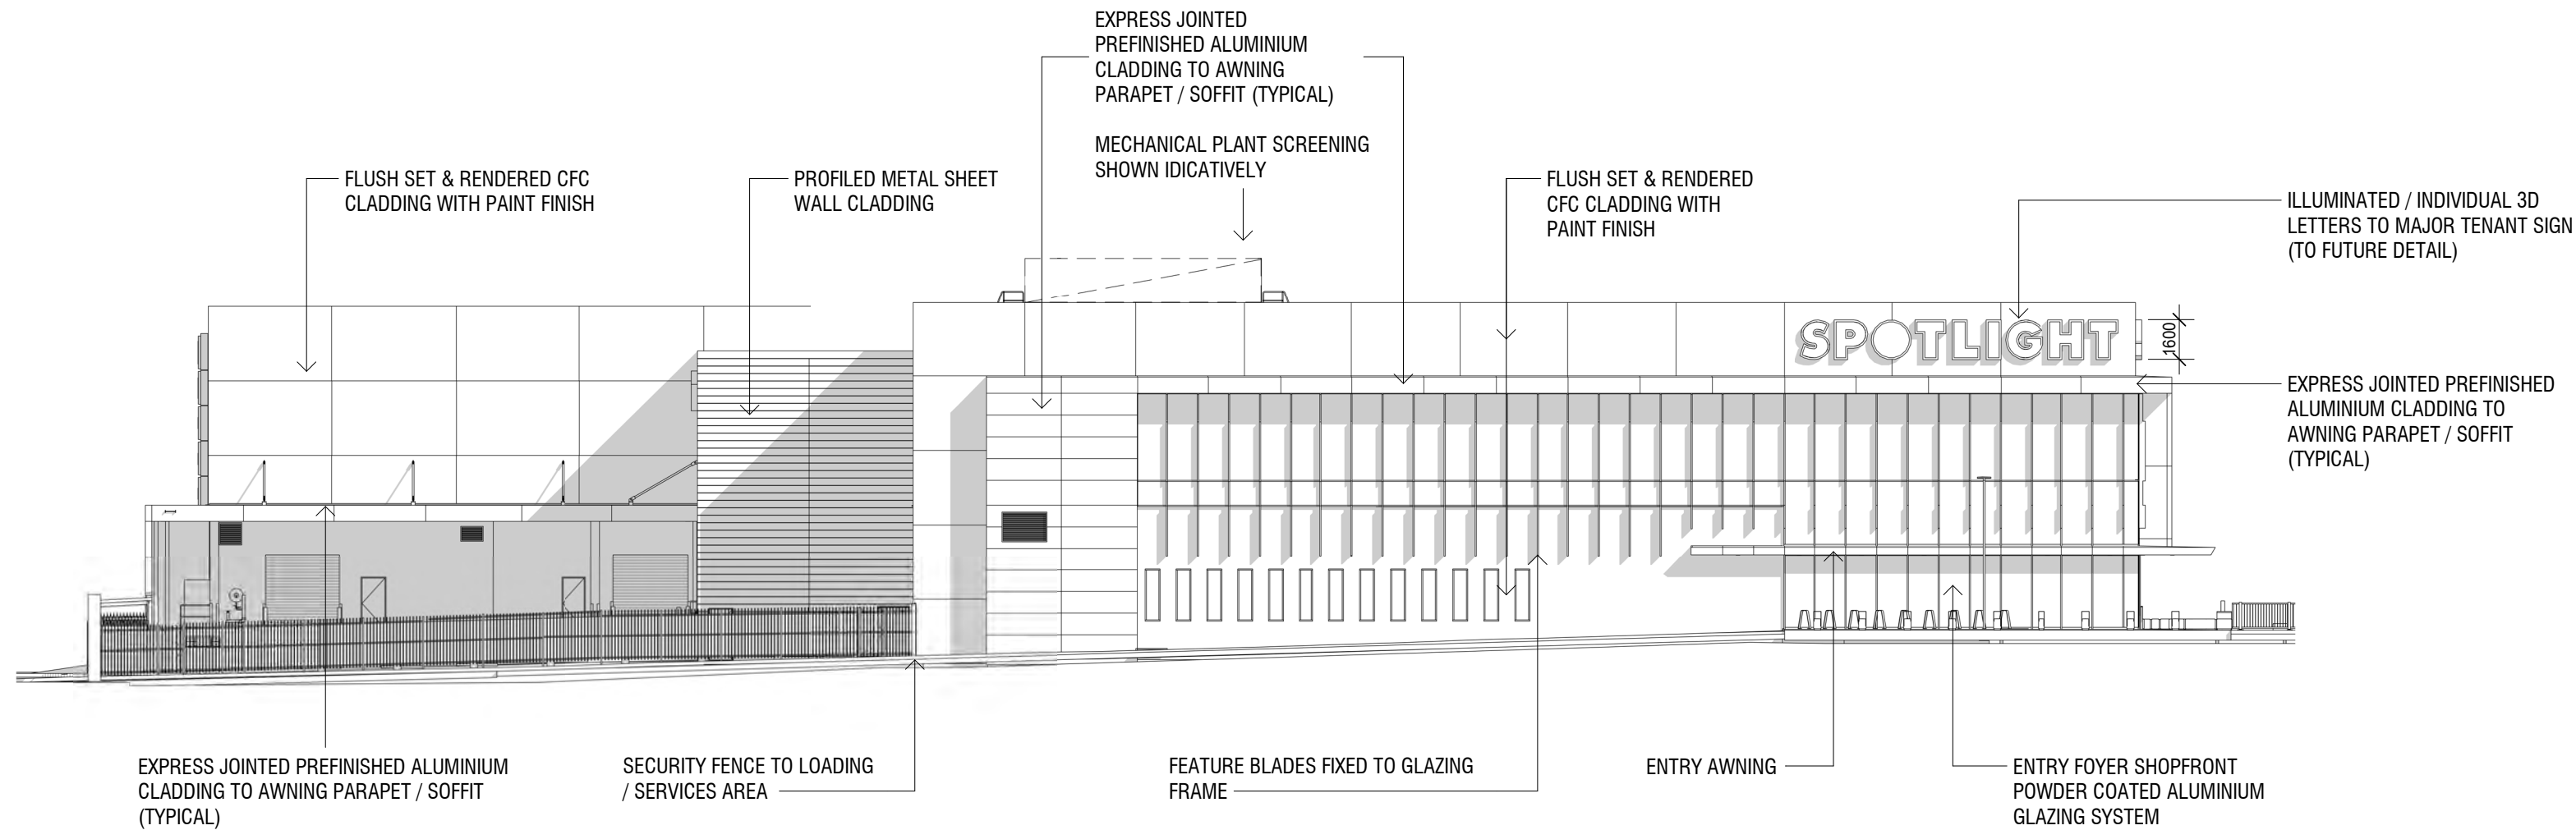

1 EAST ELEVATION
0001 1 : 250

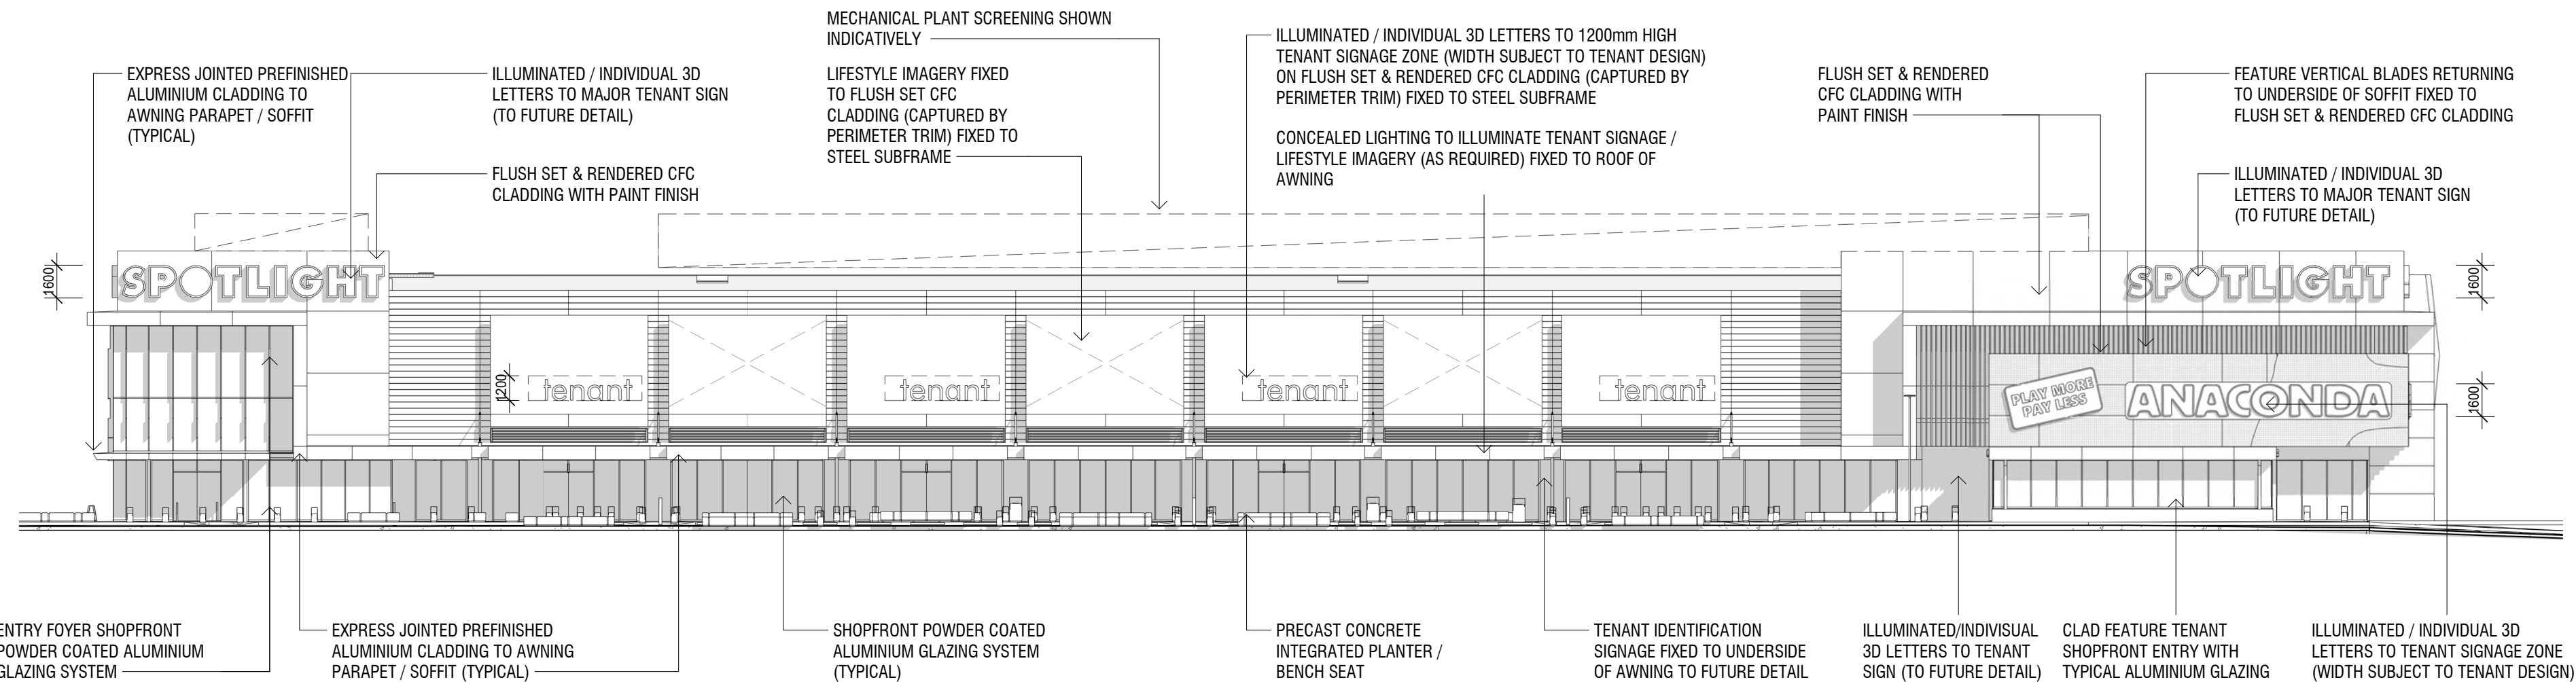

2 NORTH ELEVATION
0001 1 : 250

Do not scale this drawing. Verify all dimensions on site before commencing any work. Copyright © 2019 Buchan. This drawing remains the property of The Buchan Group Australia Pty Ltd. Reproduction in whole or in part without prior consent is forbidden.

File
X:\717\717006_REVIT\DA

Project
**MAROOCHYDORE
STAGE 1 DA**
53-79 DALTON DRIVE

Project Number
717006

Status
DEVELOPMENT APPLICATION

Date Plotted
28-Mar-19 10:17:02 AM

Date Issued
28.03.2019

Scale
1 : 250 @A2


Drawing Title
ELEVATIONS

Drawing Number
A-DA-0200

Revision
B


BUCHAN

Brisbane Studio
+ 61 7 3859 9222 / buchangroup.com.au

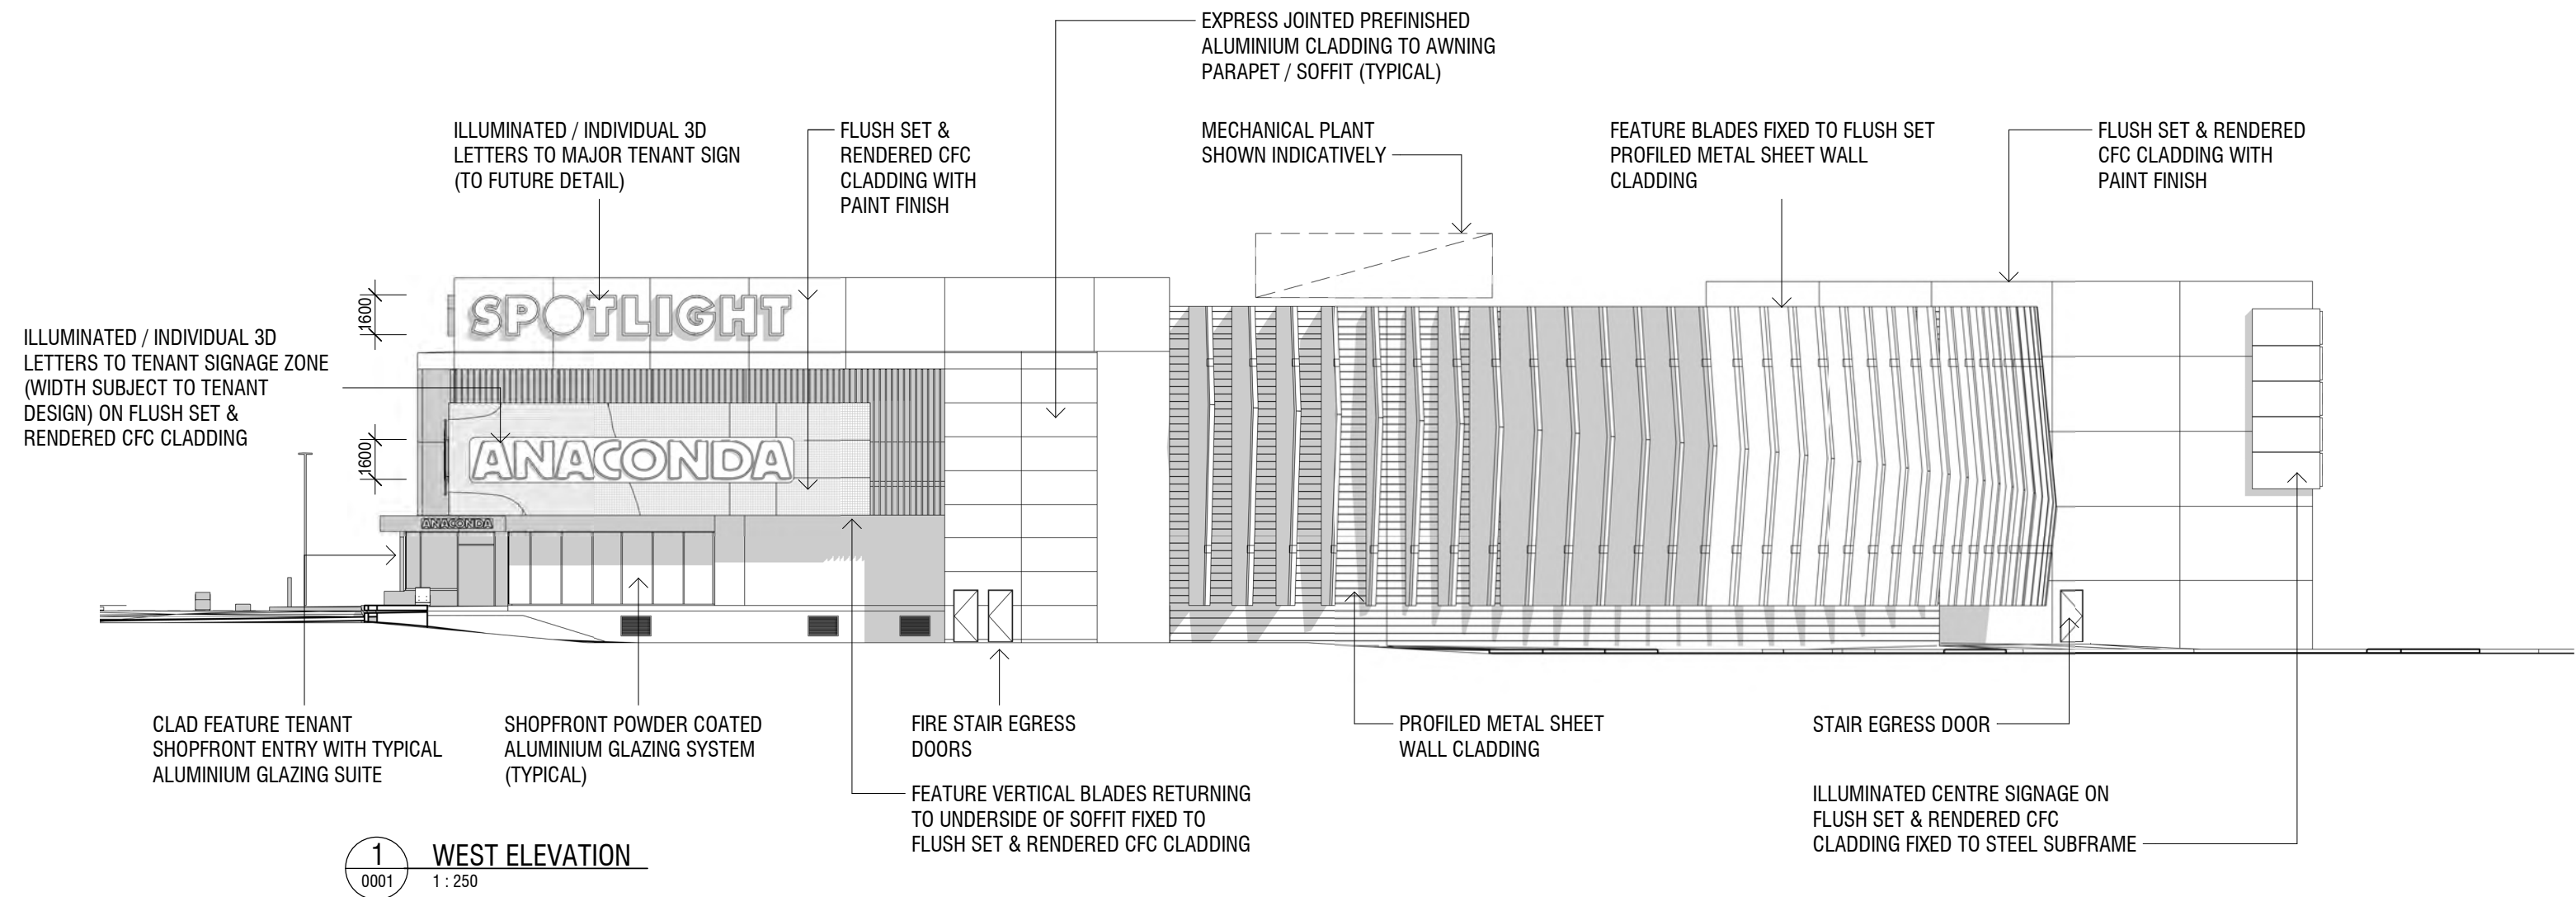

Do not scale this drawing. Verify all dimensions on site before commencing any work. Copyright © 2019 Buchan. This drawing remains the property of The Buchan Group Australia Pty Ltd. Reproduction in whole or in part without prior consent is forbidden.

File
X:\717\717006_REVIT\DA

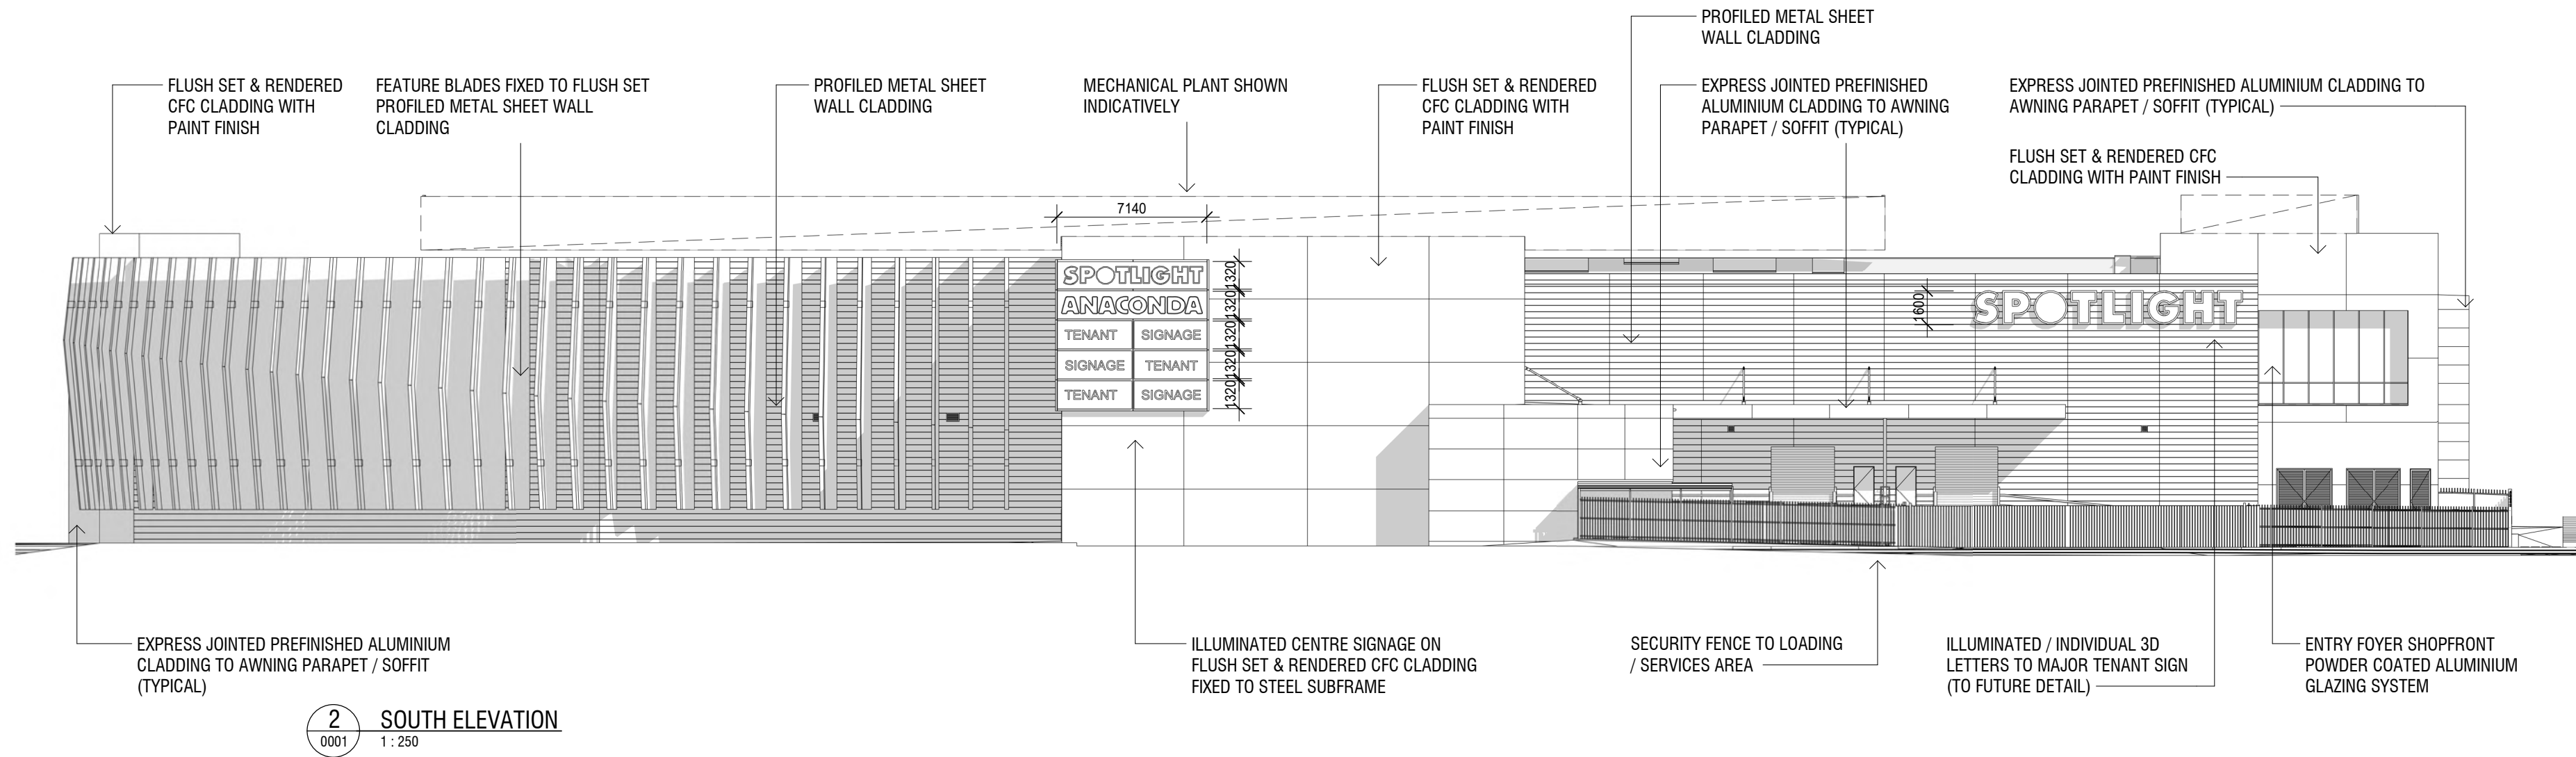

Project
**MAROOCHYDORE
STAGE 1 DA**
53-79 DALTON DRIVE

Project Number
717006

Status
DEVELOPMENT APPLICATION

Date Plotted 28-Mar-19 10:17:36 AM
Date Issued 28.03.2019
Scale 1 : 250 @A2
0 1.25 2.5 5 7.5 10 12.5M
Drawing Title
ELEVATIONS

Drawing Number
A-DA-0201

Revision
B

BUCHAN

Brisbane Studio
+ 61 7 3859 9222 / buchangroup.com.au




Project Number
717006

Status **DEVELOPMENT APPLICATION**

Drawing Title


SECTIONS

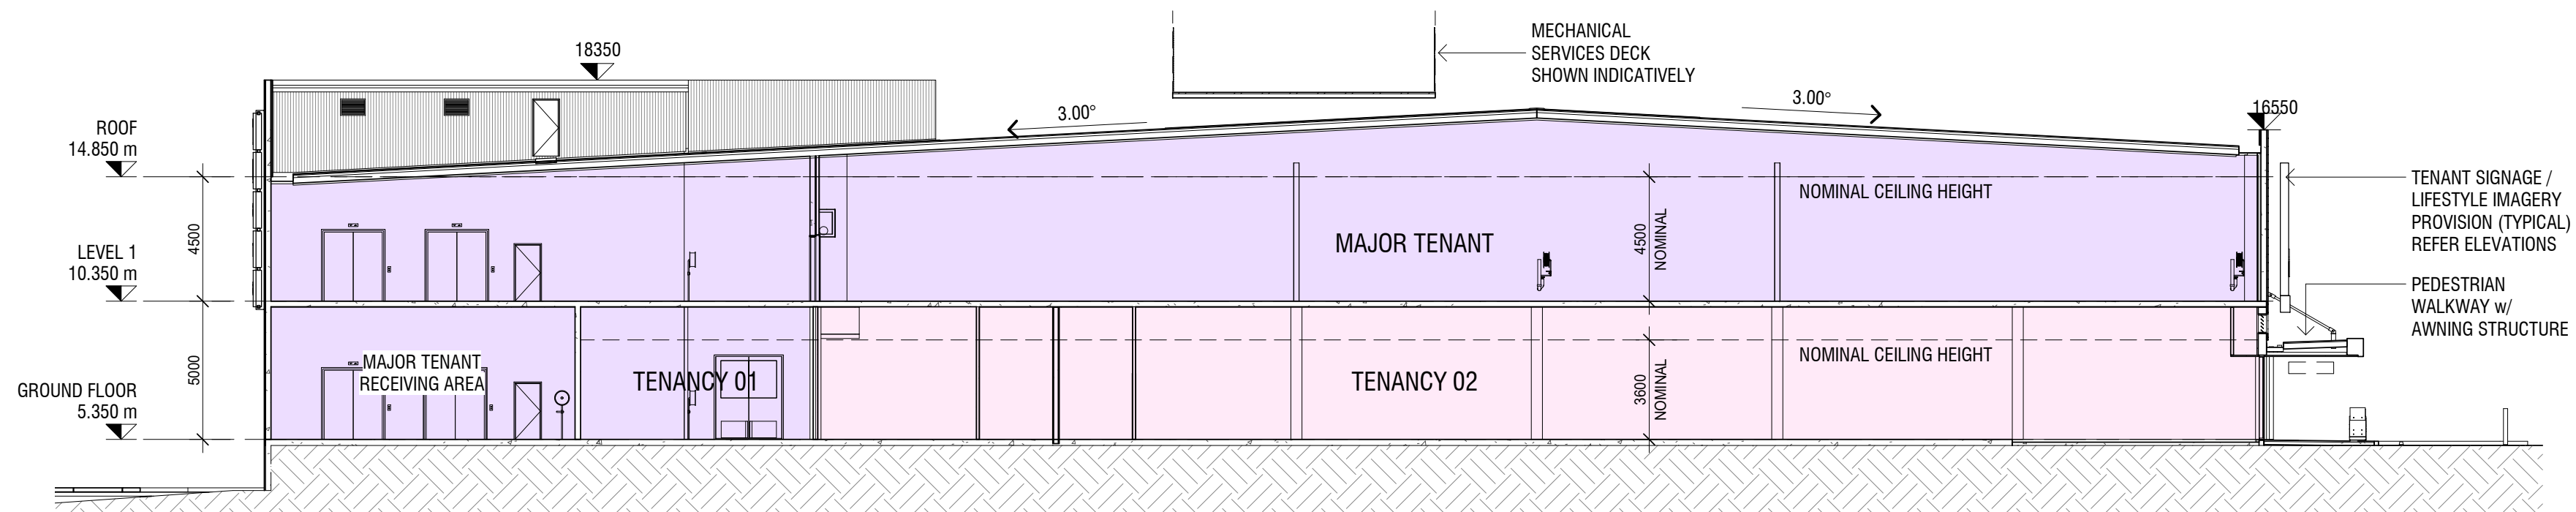

1
0001

TYPICAL BUILDING SECTION 02

1 : 200

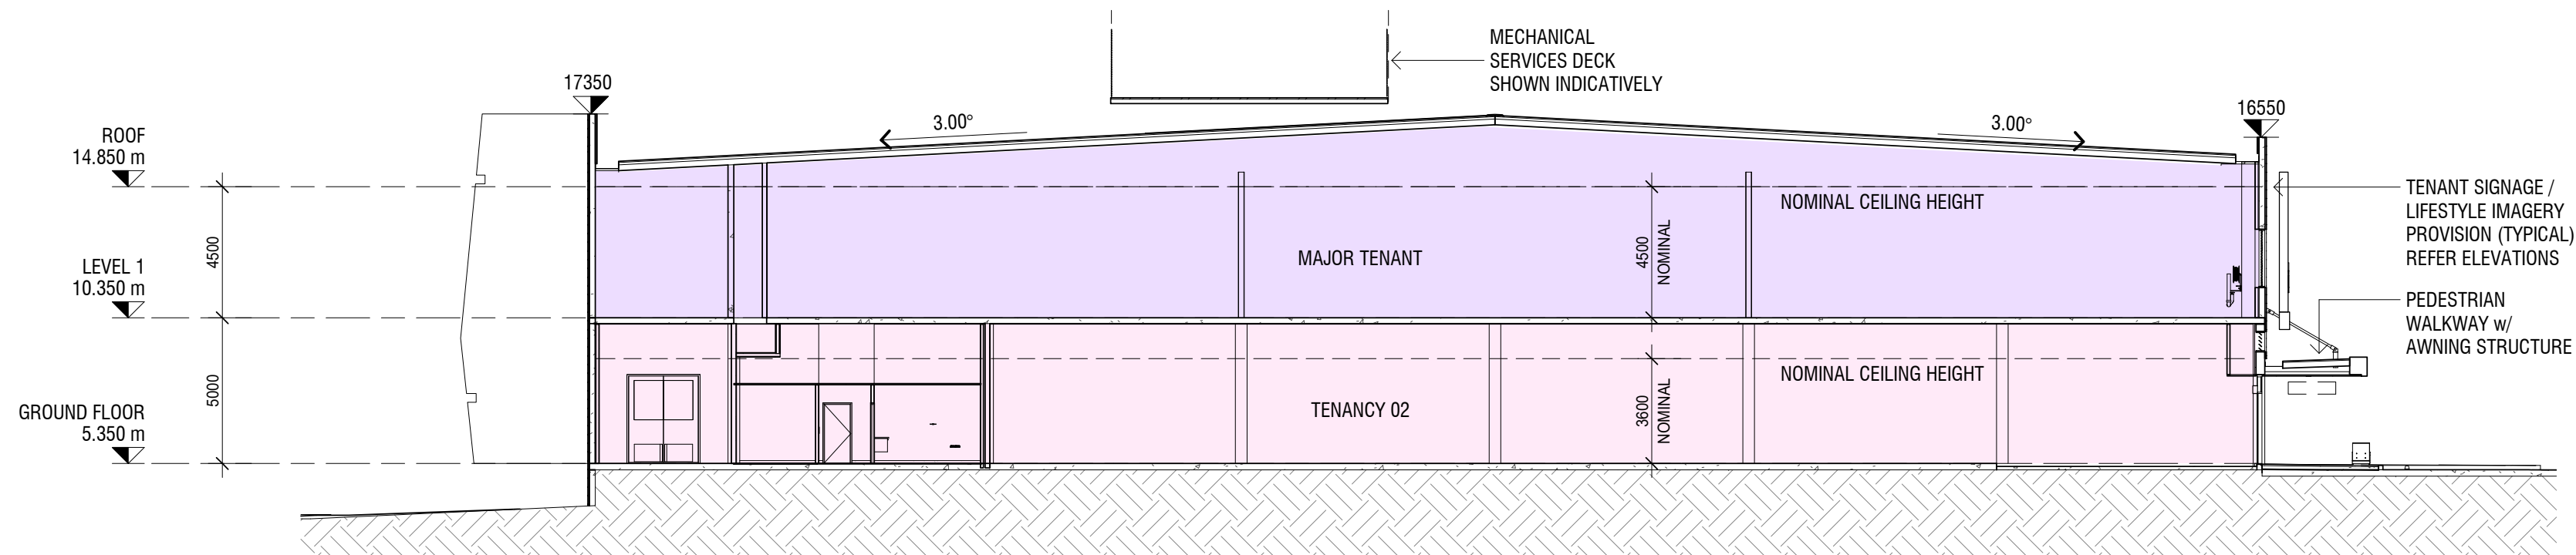

2
0001

TYPICAL BUILDING SECTION 01

1 : 200

Do not scale this drawing. Verify all dimensions on site before commencing any work. Copyright © 2019 Buchan. This drawing remains the property of The Buchan Group Australia Pty Ltd. Reproduction in whole or in part without prior consent is forbidden.

File
X:\717\717006\REVIT\DA

Project
MAROOCHYDORE
STAGE 1 DA
53-79 DALTON DRIVE

Project Number
717006

Status
DEVELOPMENT APPLICATION

Date Plotted 28-Mar-19 10:18:19 AM

Date Issued 28.03.2019

Scale 1 : 200 @A2

0 1 2 4 6 8 10M

Drawing Title

SECTIONS

Drawing Number
A-DA-0301

Revision
B

BUCHAN


Brisbane Studio
+ 61 7 3859 9222 / buchangroup.com.au

Do not scale this drawing. Verify all dimensions on site before commencing any work. Copyright © 2019 Buchan. This drawing remains the property of The Buchan Group Australia Pty Ltd. Reproduction in whole or in part without prior consent is forbidden.

File
X:\717\717006\REVIT\DA



3
0001
TYPICAL SHOPFRONT SECTION
1 : 50

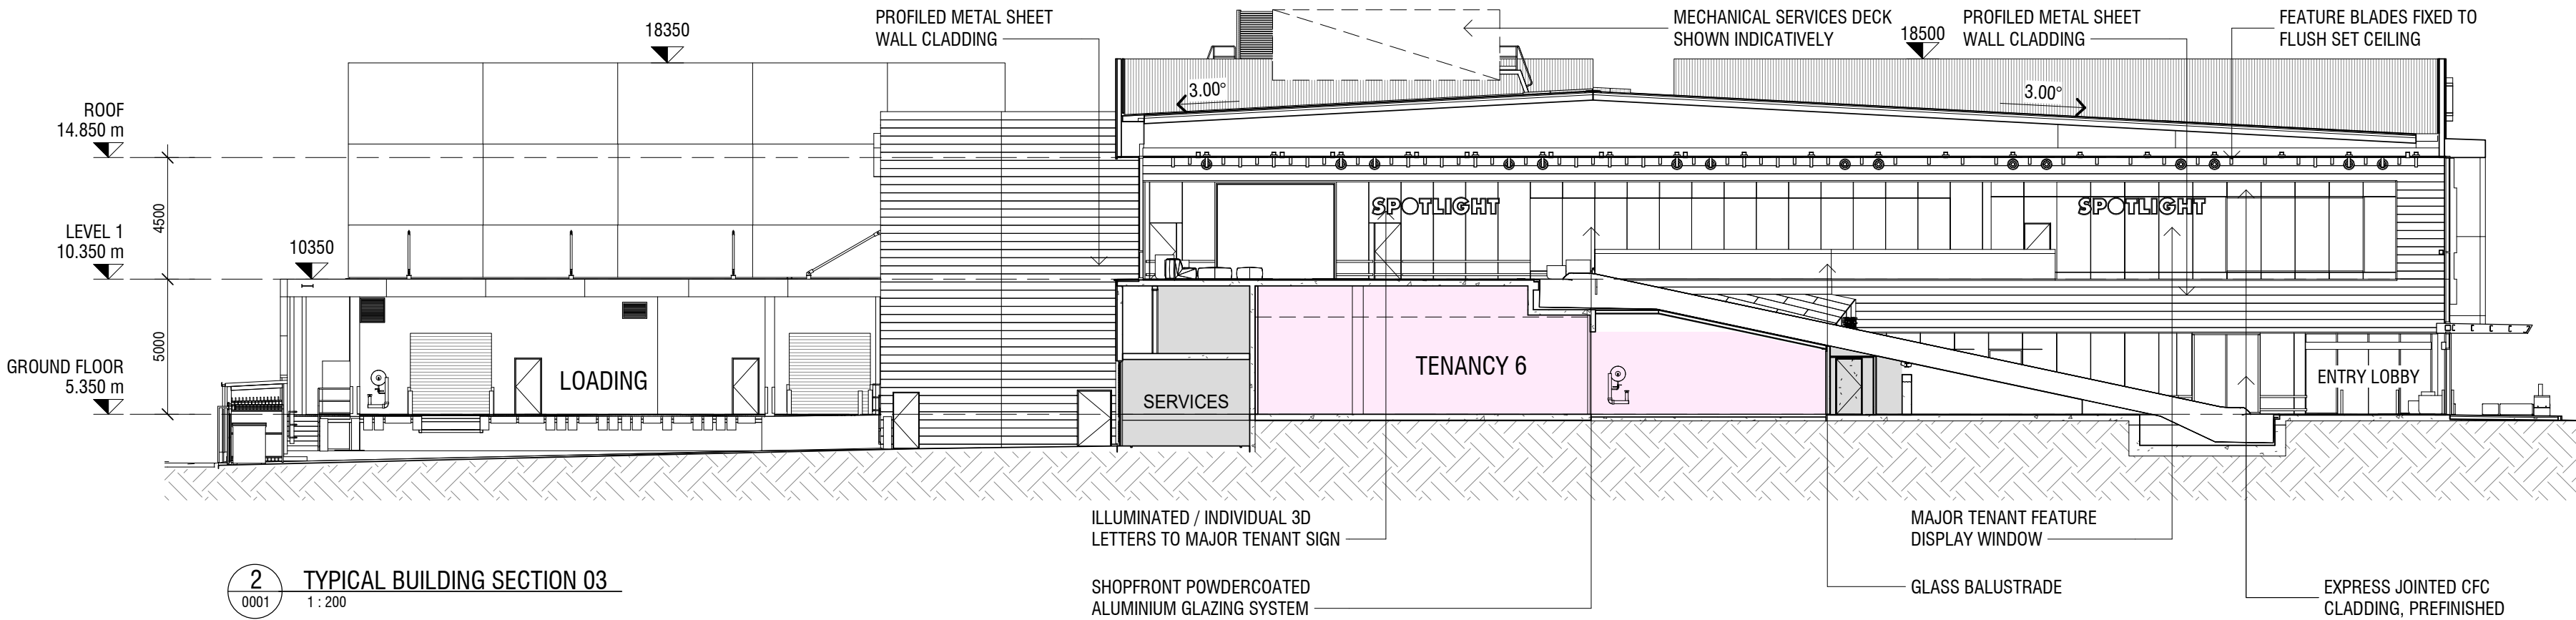

2
0001
TYPICAL BUILDING SECTION 03
1 : 200

Project
**MAROOCHYDORE
STAGE 1 DA**
53-79 DALTON DRIVE

Project Number
717006
Status
DEVELOPMENT APPLICATION

Date Plotted 28-Mar-19 10:18:49 AM

Date Issued 28.03.2019

Scale As indicated

0 1 2 @A2 4 6 8 10M

Drawing Title

SECTIONS

Drawing Number
A-DA-0302
Revision
B

BUCHAN

Brisbane Studio
+ 61 7 3859 9222 / buchangroup.com.au

Do not scale this drawing. Verify all dimensions on site before commencing any work. Copyright © 2019 Buchan. This drawing remains the property of The Buchan Group Australia Pty Ltd. Reproduction in whole or in part without prior consent is forbidden.

File
X:\71717006_REVIT\DA



Project
MAROOCHYDORE
STAGE 1 DA
53-79 DALTON DRIVE

Project Number
717006

Status
DEVELOPMENT APPLICATION

Date Plotted
28-Mar-19 10:19:13 AM

Date Issued
28.03.2019

Scale
1 : 100 @A2

0 0 0 0 0 0mm

Drawing Title
EASTERN BOUNDARY
INTERFACE

Drawing Number
A-DA-0305

Revision
B

BUCHAN

Brisbane Studio
+ 61 7 3859 9222 / buchangroup.com.au

Do not scale this drawing. Verify all dimensions on site before commencing any work. Copyright © 2019 Buchan. This drawing remains the property of The Buchan Group Australia Pty Ltd. Reproduction in whole or in part without prior consent is forbidden.

File
X:\717\717006_REVIT\DA



Project
**MAROOCHYDORE
STAGE 1 DA**
53-79 DALTON DRIVE

Project Number
717006

Status	DEVELOPMENT APPLICATION
Date Plotted	28-Mar-19 10:19:30 AM
Date Issued	28.03.2019
Scale	Not to scale

Drawing Title
PERSPECTIVE

Drawing Number	Revision
A-DA-0700	B

BUCHAN

Brisbane Studio
+ 61 7 3859 9222 / buchangroup.com.au

Do not scale this drawing. Verify all dimensions on site before commencing any work. Copyright © 2019 Buchan. This drawing remains the property of The Buchan Group Australia Pty Ltd. Reproduction in whole or in part without prior consent is forbidden.

File
X:\7171717006_REVIT\DA



Project
**MAROOCHYDORE
STAGE 1 DA**
53-79 DALTON DRIVE

Project Number
717006

Status	DEVELOPMENT APPLICATION
Date Plotted	28-Mar-19 10:19:47 AM
Date Issued	28.03.2019
Scale	Not to scale

Drawing Title
PERSPECTIVE

Drawing Number	Revision
A-DA-0701	B

BUCHAN

Brisbane Studio
+ 61 7 3859 9222 / buchangroup.com.au

Do not scale this drawing. Verify all dimensions on site before commencing any work. Copyright © 2019 Buchan. This drawing remains the property of The Buchan Group Australia Pty Ltd. Reproduction in whole or in part without prior consent is forbidden.

File
X:\7171717006_REVIT\DA



Project
**MAROOCHYDORE
STAGE 1 DA**
53-79 DALTON DRIVE

Project Number
717006

Status	DEVELOPMENT APPLICATION
Date Plotted	28-Mar-19 10:20:05 AM
Date Issued	28.03.2019
Scale	Not to scale

Drawing Title
PERSPECTIVE

Drawing Number	Revision
A-DA-0702	B

BUCHAN

Brisbane Studio
+ 61 7 3859 9222 / buchangroup.com.au



Do not scale this drawing. Verify all dimensions on site before commencing any work. Copyright © 2019 Buchan. This drawing remains the property of The Buchan Group Australia Pty Ltd. Reproduction in whole or in part without prior consent is forbidden.

File
X:\71717006_REVIT\DA

Project
**MAROOCHYDORE
STAGE 1 DA**
53-79 DALTON DRIVE

Project Number
717006

Status	DEVELOPMENT APPLICATION
Date Plotted	28-Mar-19 10:20:22 AM
Date Issued	28.03.2019
Scale	Not to scale

Drawing Title
PERSPECTIVE

Drawing Number	Revision
A-DA-0703	B

BUCHAN

Brisbane Studio
+ 61 7 3859 9222 / buchangroup.com.au

Do not scale this drawing. Verify all dimensions on site before commencing any work. Copyright © 2019 Buchan. This drawing remains the property of The Buchan Group Australia Pty Ltd. Reproduction in whole or in part without prior consent is forbidden.

File
X:\7171717006_REVIT\DA



Project
**MAROOCHYDORE
STAGE 1 DA**
53-79 DALTON DRIVE

Project Number
717006

Status	DEVELOPMENT APPLICATION
Date Plotted	28-Mar-19 10:20:39 AM
Date Issued	28.03.2019
Scale	Not to scale

Drawing Title
PERSPECTIVE

Drawing Number	Revision
A-DA-0704	B

BUCHAN

Brisbane Studio
+ 61 7 3859 9222 / buchangroup.com.au

Do not scale this drawing. Verify all dimensions on site before commencing any work. Copyright © 2019 Buchan. This drawing remains the property of The Buchan Group Australia Pty Ltd. Reproduction in whole or in part without prior consent is forbidden.

File
X:\7171717006_REVIT\DA



Project
**MAROOCHYDORE
STAGE 1 DA**
53-79 DALTON DRIVE

Project Number
717006

Status	DEVELOPMENT APPLICATION
Date Plotted	28-Mar-19 10:20:57 AM
Date Issued	28.03.2019
Scale	Not to scale

Drawing Title
PERSPECTIVE

Drawing Number	Revision
A-DA-0705	B

BUCHAN

Brisbane Studio
+ 61 7 3859 9222 / buchangroup.com.au

Do not scale this drawing. Verify all dimensions on site before commencing any work. Copyright © 2019 Buchan. This drawing remains the property of The Buchan Group Australia Pty Ltd. Reproduction in whole or in part without prior consent is forbidden.

File
X:\71717006_REVIT\DA



Project
MAROOCHYDORE
STAGE 1 DA
53-79 DALTON DRIVE

Project Number
717006

Status	DEVELOPMENT APPLICATION
Date Plotted	28-Mar-19 10:21:15 AM
Date Issued	28.03.2019
Scale	Not to scale

Drawing Title
PERSPECTIVE

Drawing Number	Revision
A-DA-0706	B

BUCHAN

Brisbane Studio
+ 61 7 3859 9222 / buchangroup.com.au

Do not scale this drawing. Verify all dimensions on site before commencing any work. Copyright © 2019 Buchan. This drawing remains the property of The Buchan Group Australia Pty Ltd. Reproduction in whole or in part without prior consent is forbidden.

File
X:\71717006\REVIT\DA



Project
MAROOCHYDORE
STAGE 1 DA
53-79 DALTON DRIVE

Project Number
717006

Status	DEVELOPMENT APPLICATION
Date Plotted	28-Mar-19 10:21:33 AM
Date Issued	28.03.2019
Scale	Not to scale

Drawing Title
PERSPECTIVE

Drawing Number	Revision
A-DA-0707	B

BUCHAN

Brisbane Studio
+ 61 7 3859 9222 / buchangroup.com.au

Do not scale this drawing. Verify all dimensions on site before commencing any work. Copyright © 2019 Buchan. This drawing remains the property of The Buchan Group Australia Pty Ltd. Reproduction in whole or in part without prior consent is forbidden.

File
X:\7171717006_REVIT\DA



Project
**MAROOCHYDORE
STAGE 1 DA**
53-79 DALTON DRIVE

Project Number
717006

Status	DEVELOPMENT APPLICATION
Date Plotted	28-Mar-19 10:21:37 AM
Date Issued	28.03.2019
Scale	Not to scale

Drawing Title
PERSPECTIVE

Drawing Number	Revision
A-DA-0708	B

BUCHAN

Brisbane Studio
+ 61 7 3859 9222 / buchangroup.com.au

Do not scale this drawing. Verify all dimensions on site before commencing any work. Copyright © 2019 Buchan. This drawing remains the property of The Buchan Group Australia Pty Ltd. Reproduction in whole or in part without prior consent is forbidden.

File
X:\717\717006_REVIT\DA



Project
MAROOCHYDORE
STAGE 1 DA
53-79 DALTON DRIVE

Project Number
717006

Status	DEVELOPMENT APPLICATION
Date Plotted	28-Mar-19 10:21:48 AM
Date Issued	28.03.2019
Scale	Not to scale

Drawing Title
PERSPECTIVE

Drawing Number	Revision
A-DA-0709	B

BUCHAN

Brisbane Studio
+ 61 7 3859 9222 / buchangroup.com.au



Do not scale this drawing. Verify all dimensions on site before commencing any work. Copyright © 2019 Buchan. This drawing remains the property of The Buchan Group Australia Pty Ltd. Reproduction in whole or in part without prior consent is forbidden.

File
X:\71717006\REVIT\DA

Project
**MAROOCHYDORE
STAGE 1 DA**
53-79 DALTON DRIVE

Project Number
717006

Status
DEVELOPMENT APPLICATION

Date Plotted
28-Mar-19 10:21:54 AM

Date Issued
28.03.2019

Scale
Not to scale

Drawing Title
PERSPECTIVE

Drawing Number
A-DA-0710

Revision
B

BUCHAN

Brisbane Studio
+ 61 7 3859 9222 / buchangroup.com.au

Do not scale this drawing. Verify all dimensions on site before commencing any work. Copyright © 2019 Buchan. This drawing remains the property of The Buchan Group Australia Pty Ltd. Reproduction in whole or in part without prior consent is forbidden.

File
X:\717\717006_REVIT\DA

1 BASEMENT REFERENCE PLAN
1 : 1000

2 GROUND REFERENCE PLAN
1 : 1000

3 LEVEL 1 REFERENCE PLAN
1 : 1000

4 ROOF REFERENCE PLAN
1 : 1000

LEGEND

1. REMOVAL OF CARPARK RAMP TO BASEMENT
2. INTRODUCTION OF AIRLOCK TO TENANCY 1
3. TENANCY MIXES ADJUSTED
4. GF ENTRY LOBBY TO INCLUDE ENTRY FOR TENANCY 6
5. FARMERS MARKET ENVELOPE INCREASED. DEDICATED BUILDING FOR AMENITIES AND CAFE ADDED.
6. WESTERN PEDESTRIAN CONNECTION ADDED
7. CARPARK BAYS SHIFTED WEST TO ALLOW FOR PED. CONNECTION, REDUCING LANDSCAPE BUFFER ALONG DALTON DRIVE (15M TO 3M APPROX)
8. REMOVAL OF BASEMENT CARPARK
9. CONSOLIDATION OF SPRINKLER TANKS AND OTHER FIRE SERVICES BENEATH BUILDING ENVELOPE
10. REMOVAL OF MECHANICAL SERVICES ROOMS FROM BASEMENT

Project
**MAROOCHYDORE
STAGE 1 DA**
53-79 DALTON DRIVE

Project Number
717006

Status
DEVELOPMENT APPLICATION

Date Plotted
28-Mar-19 10:23:26 AM

Date Issued
28.03.2019

Scale
1 : 1000 @A2


Drawing Title
REFERENCE 01

Drawing Number
A-DA-0800


Revision
B

BUCHAN


Brisbane Studio
+ 61 7 3859 9222 / buchangroup.com.au

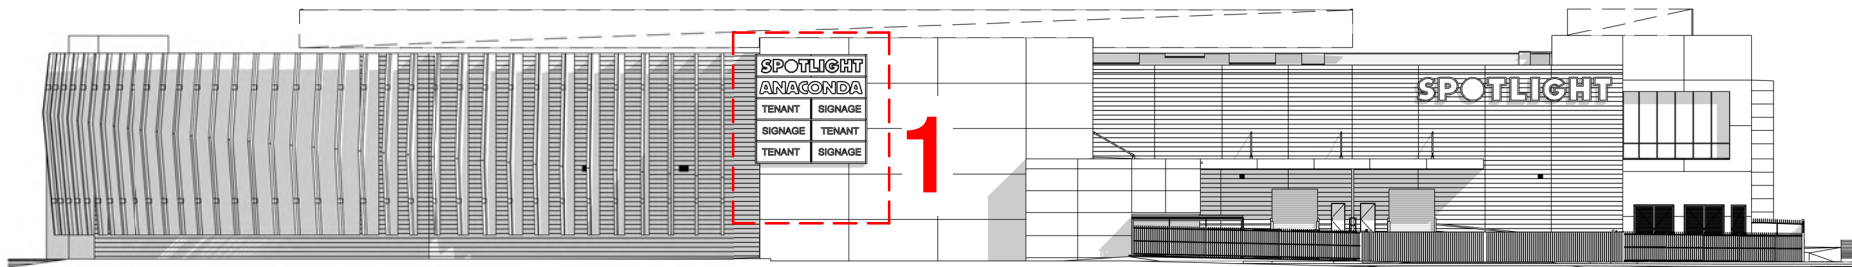


5 SOUTH ELEVATION REFERENCE
0001 1 : 500

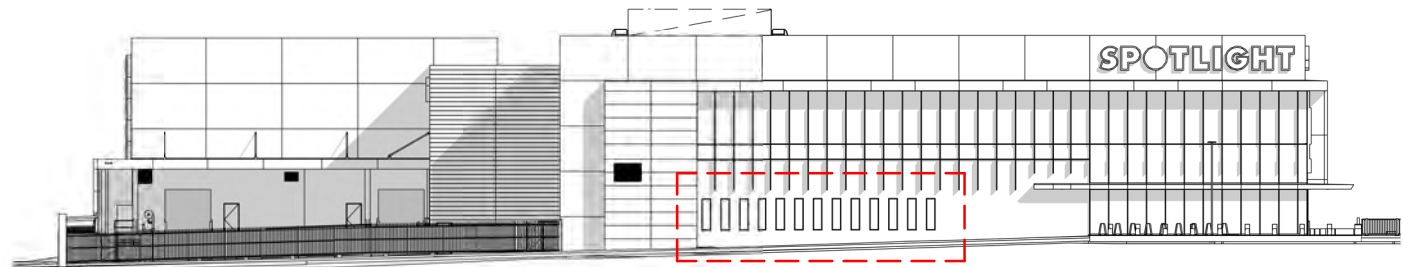


6 EAST ELEVATION REFERENCE
0001 1 : 500

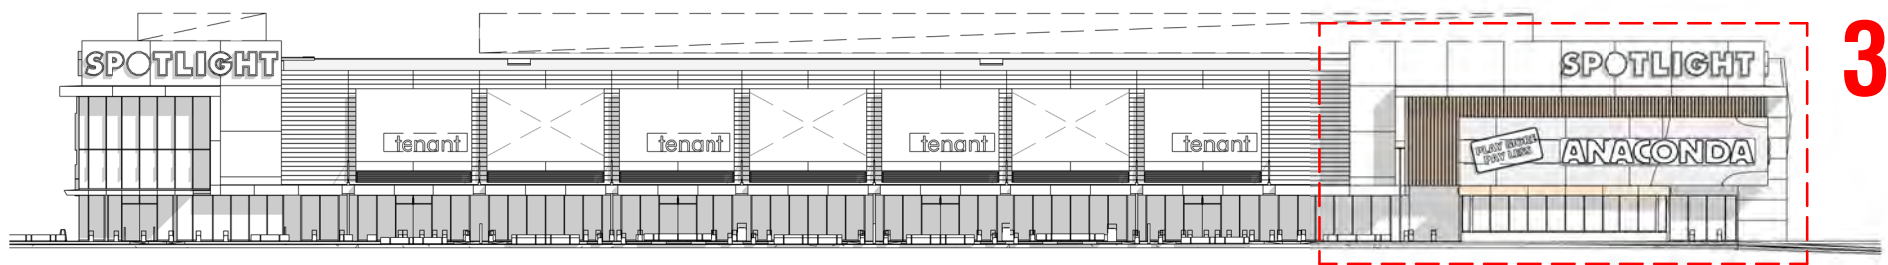


3 NORTH ELEVATION REFERENCE
0001 1 : 500

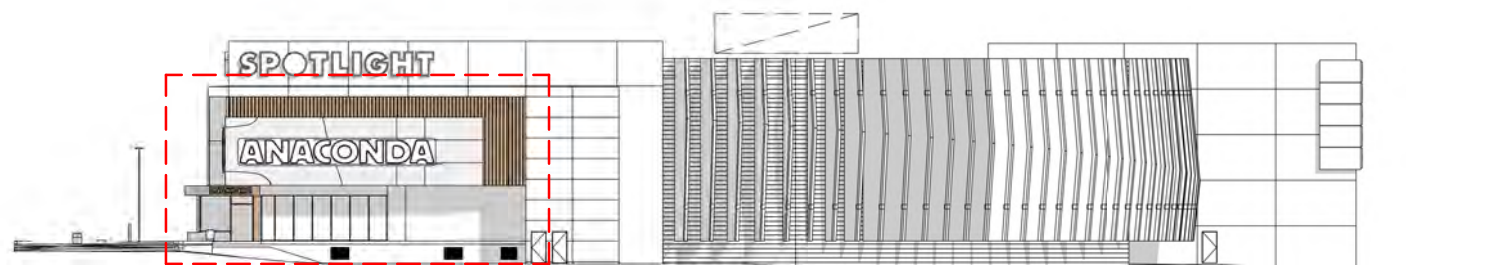

4 WEST ELEVATION REFERENCE
0001 1 : 500

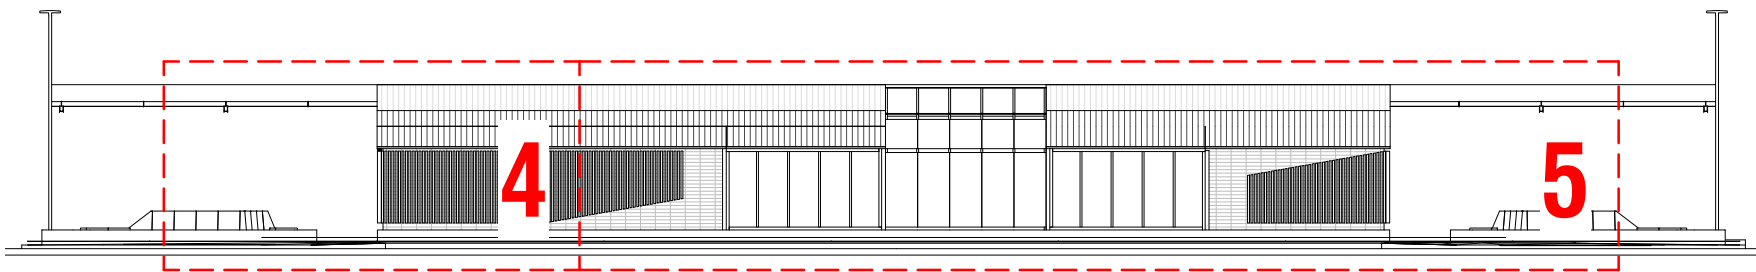

1 FARMERS MARKET EAST ELEVATION REFERENCE
0001 1 : 200

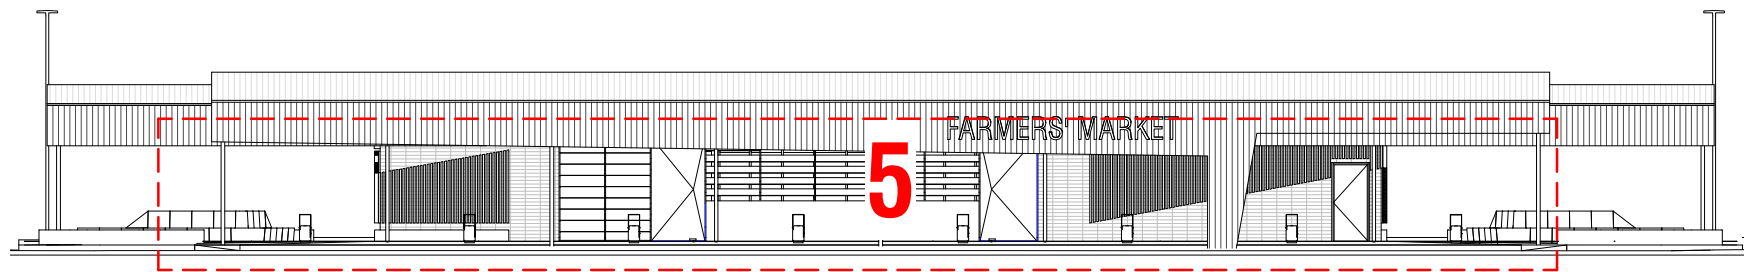

2 FARMERS MARKET WEST ELEVATION REFERENCE
0130 1 : 200

LEGEND

1. BUILDING IDENTIFICATION SIGANCE AMENDED (ADDITIONAL SIGNAGE BOXES)
2. SLOT WINDOWS ADDED
3. FACADE WIDTH INCREASED ON NORTHERN ELEVATION. ENTRY AIRLOCK ADDED BELOW SIGNAGE
4. ENCLOSED AMENITIES ADDED TO FARMERS MARKET STRUCTURE.
5. ENCLOSED CAFE AND SEATING AREA ADDED TO FARMERS MARKET STRUCTURE.
6. FARMERS MARKET BUILDING ENVELOPE EXTENDED, PARKING PROVIDED BENEATH STRUCTURE

Do not scale this drawing. Verify all dimensions on site before commencing any work. Copyright © 2019 Buchan. This drawing remains the property of The Buchan Group Australia Pty Ltd. Reproduction in whole or in part without prior consent is forbidden.

File
X:\717\717006_REVIT\DA

Project
MAROOCHYDORE
STAGE 1 DA
53-79 DALTON DRIVE


Project Number
717006
Status
DEVELOPMENT APPLICATION
Date Plotted
28-Mar-19 10:24:11 AM
Date Issued
28.03.2019
Scale
As indicated

Drawing Title
REFERENCE 02

Drawing Number
A-DA-0801
Revision
B

BUCHAN

Brisbane Studio
+ 61 7 3859 9222 / buchangroup.com.au

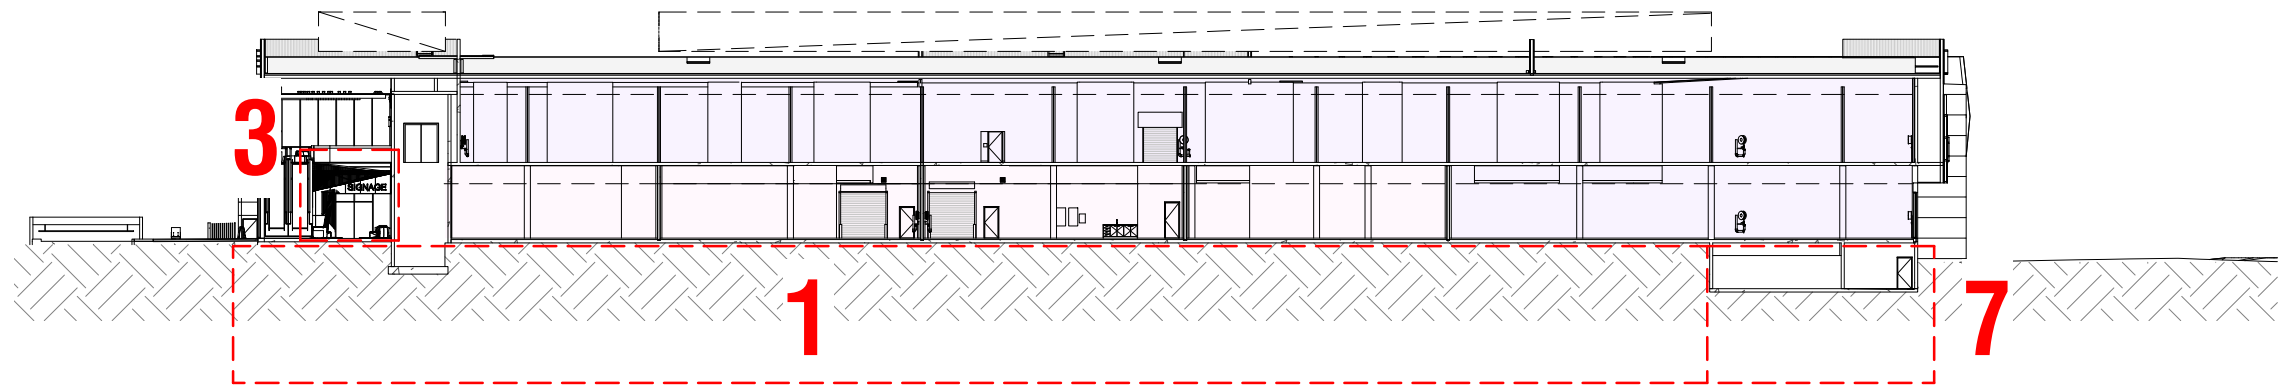


LEGEND

- 1. REMOVAL OF BASEMENT CARPARK
- 2. LEVEL 1 DISPLAY WINDOW ADDED TO ENTRY LOBBY
- 3. TENANCY 6 SHOPFRONT ADDED TO ENTRY LOBBY
- 4. SERVICES ROOM CONSOLIDATED OVER SUBSTATION, ACCESS VIA ADJACENT STAIR
- 5. LOADING ARRANGEMENTS AMENDED BASED ON NEW TENANCY MIXES
- 6. ROOF ACCESS VIA DEDICATED STAIR ADDED
- 7. FIRE SERVICES CONSOLIDATED BENEATH BUILDING ENVELOPE
- 8. BASEMENT LEVEL REMOVED FROM ENTRY LOBBY


Do not scale this drawing. Verify all dimensions on site before commencing any work. Copyright © 2019 Buchan. This drawing remains the property of The Buchan Group Australia Pty Ltd. Reproduction in whole or in part without prior consent is forbidden.

File
X:\717\717006\REVIT\DA

1 OVERALL CROSS SECTION 02 REFERENCE
1 : 500

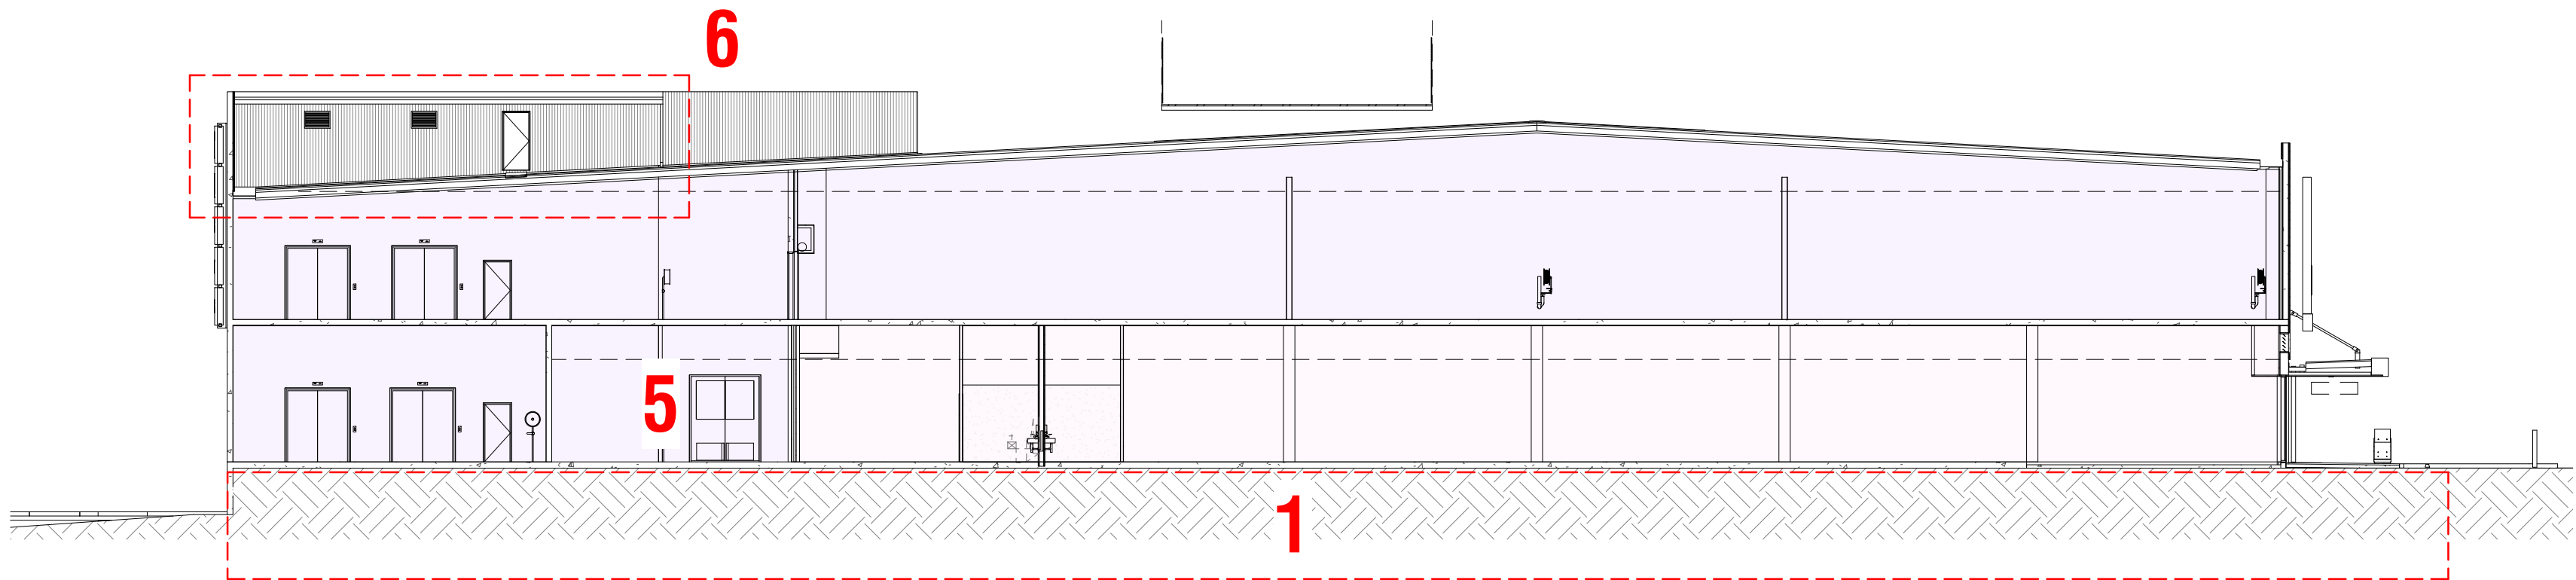

2 TYPICAL BUILDING SECTION 02 REFERENCE
1 : 200

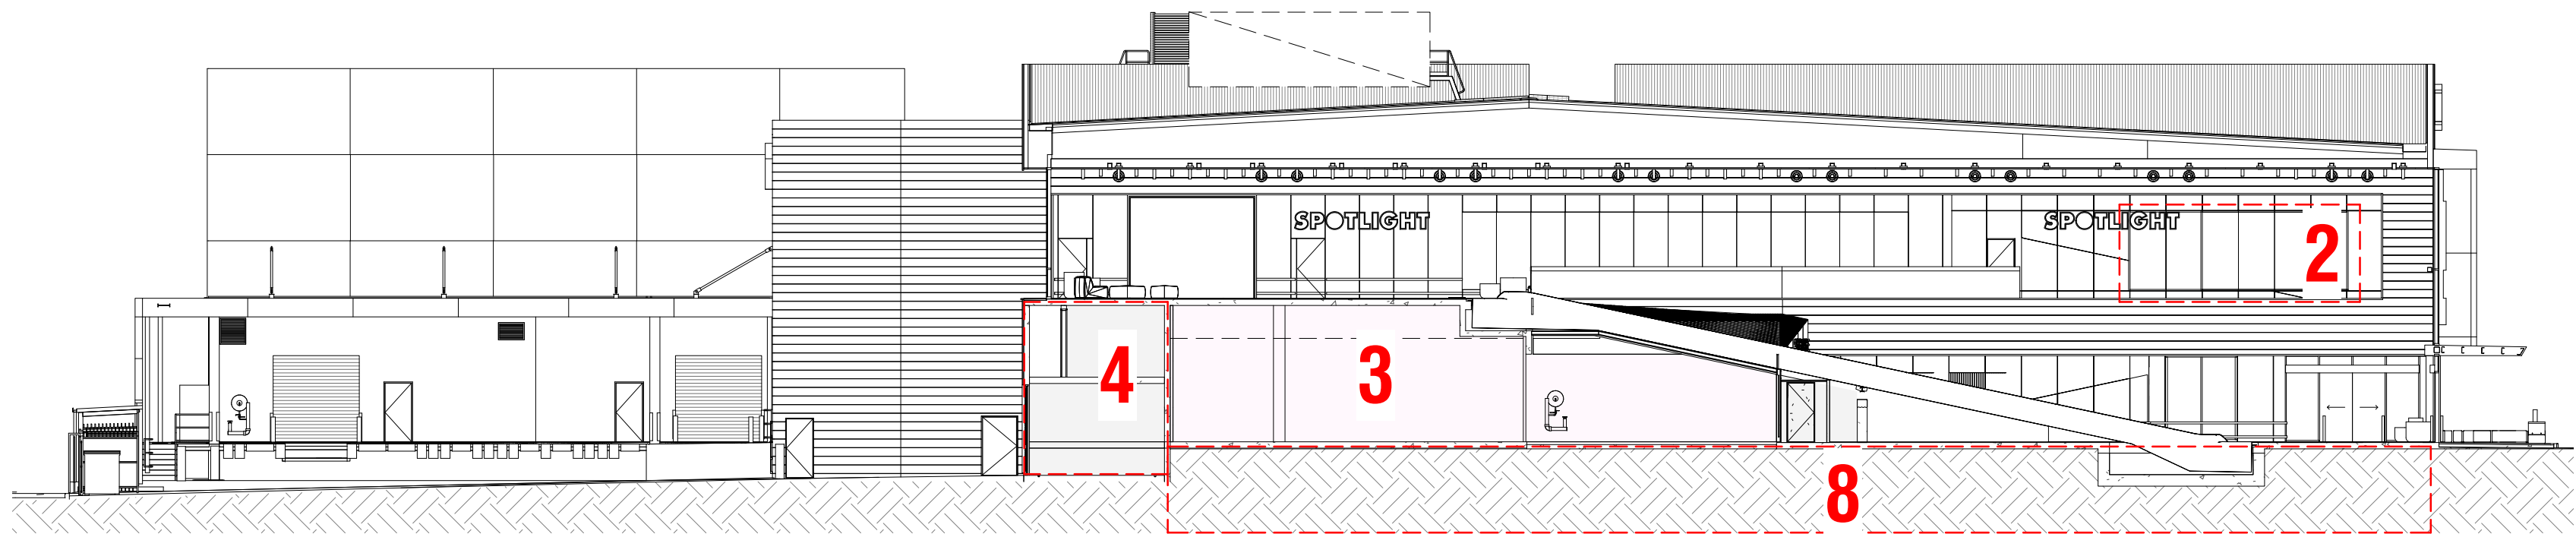

3 TYPICAL BUILDING SECTION 03 REFERENCE
1 : 200

Project
MAROOCHYDORE
STAGE 1 DA
53-79 DALTON DRIVE

Project Number
717006
Status
DEVELOPMENT APPLICATION
Date Plotted
28-Mar-19 10:24:43 AM
Date Issued
28.03.2019
Scale
Not to scale

Drawing Title
REFERENCE 03

Drawing Number
A-DA-0802
Revision
B


BUCHAN

Brisbane Studio
+ 61 7 3859 9222 / buchangroup.com.au

APPENDIX

B



DRAINAGE PLAN

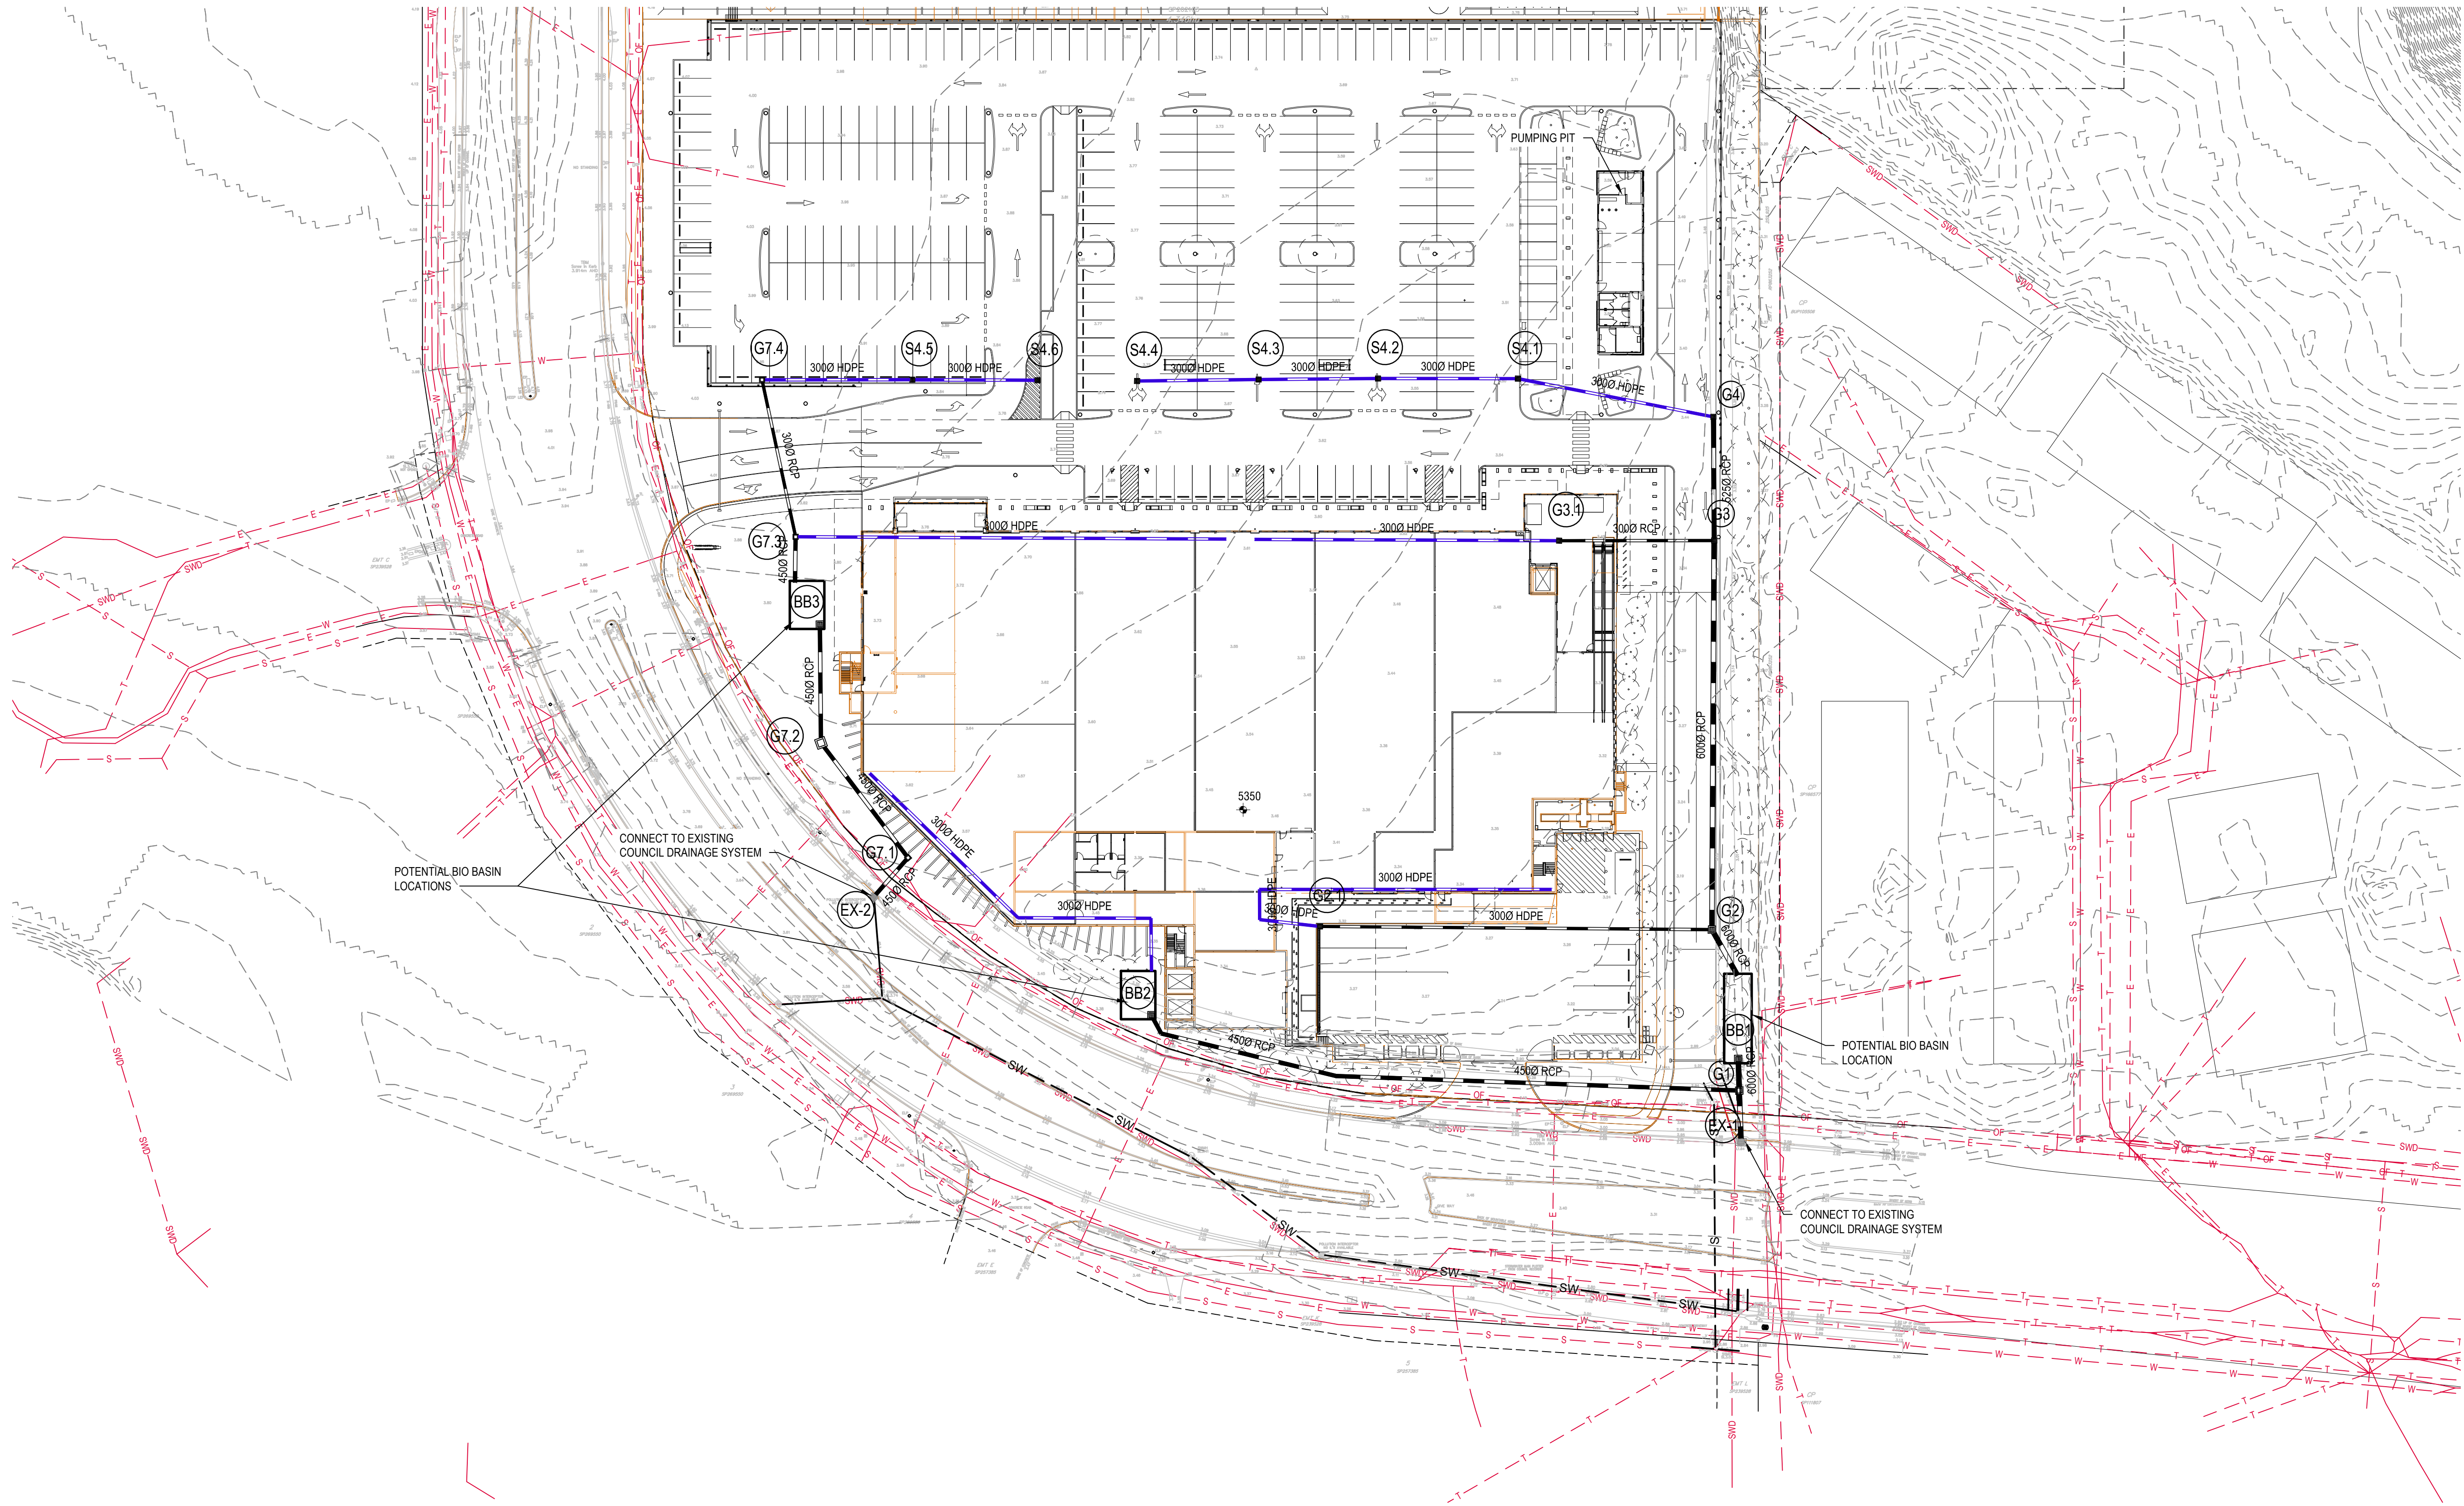

LEGEND

	EXISTING STORMWATER DRAIN, PIT, DIAMETER AND DRAINAGE INVERT LEVEL
	PROPOSED STORMWATER DRAIN, PIT, DIAMETER AND DRAINAGE INVERT LEVEL
	PROPOSED SYPHONIC DRAIN, PIT, DIAMETER AND DRAINAGE INVERT LEVEL
	PROPOSED PIT AND PIT NUMBER
	EXISTING PIT
	PROPOSED SWALE DRAIN
	EXISTING SEWER
	EXISTING ELECTRICITY
	EXISTING FIBRE OPTIC
	EXISTING TELECOM
	EXISTING WATER

 CONTRACTOR TO VERIFY EXISTING SERVICES CONNECTION LEVELS PRIOR TO CONSTRUCTION. ANY DISCREPANCIES MUST BE IMMEDIATELY IDENTIFIED AND THE SUPERINTENDENT NOTIFIED PRIOR TO CONSTRUCTION COMMENCING.

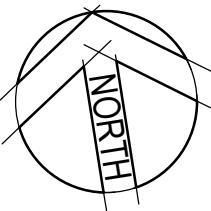

© Cardno Limited All Rights Reserved.
This document is produced by Cardno Limited solely for the benefit of and use by the client in accordance with the terms of the retainer. Cardno Limited does not and shall not assume any responsibility or liability whatsoever to any third party arising out of any use or reliance by third party on the content of this document.



Cardno
Shaping the Future

Cardno Victoria Pty Ltd | ABN 47 106 610 913
Level 4, 501 Swenston Street
Melbourne VIC 3000
Tel: 03 8415 7777 Fax: 03 8415 7788
Web: www.cardno.com.au

BLUEPRINT AUSTRALIA			
PROPOSED DRAINAGE PLAN			
SHEET 2 OF 2			
Date	29.03.2019	Scale	1:500
Size	A1		
Drawing Number	V171462-CI-SK008	Revision	7

APPENDIX

C

ENVIROPOD INFORMATION

EnviroPod[®]

Technical Design Manual



Stormwater360
AUSTRALIA

Contents

1.1	Design and Operation	3
1.2	Parameter Performance	5
1.2.1	Gross Pollutants and Coarse Sediment	5
1.2.2	Suspended Solids	5
1.2.3	Oil and Grease	6
1.3	Inspection and Maintenance	7

1.1 Design and Operation

The EnviroPod® is a proven catchpit insert designed to be easily retrofitted into new and existing stormwater catchpits, requiring no construction or land take. It removes a significant portion of sediment, trash, debris and other pollutants from water entering the stormwater system, and can be installed in either curb inlet, standard pre-cast catchpits or manhole catchpits. Using low-cost passive screening and optional oil-adsorbent media, the EnviroPod® can be customised to meet site-specific requirements with interchangeable polyester mesh screens ranging from 100 to 1600 micron pore size. 200 micron filter mesh screening bags are supplied as standard (unless specified otherwise). This filter mesh has a moderate/high removal rate and a moderate maintenance requirement.

The EnviroPod is also effective as a pretreatment device for use in a treatment train with hydrodynamic separators, filtration, ponds, swales and wetlands. In many cases, it's often the most practical solution for retrofits.

Independently trialled and tested by city councils throughout Australia and New Zealand and with installation of over 7,000 units including North America, the EnviroPod® Filter is the premiere pit insert.

Design and Operation

The EnviroPod® consists of a screening bag supported by a filterbox and structural cage. Modular plastic deflector panels attach to the filterbox and guide the flow of water to the screening bag. The screening bag captures pollutants and allows the water to pass through to the outlet pipe. Optional absorbent material inside the screening bag captures oil and grease. Openings in the filterbox allow water to bypass the screening bag during high flow conditions to prevent surface flooding.

Configurations

The EnviroPod® is designed to simply insert into the gully pit below the grate and is mounted on aluminum rails anchored to the (gully) pit walls. The one configuration fits sump type grates, road gullies, kerb entry units etc. Plastic deflector panels seal against the pit walls and direct flow into the filterbox and through the mesh screens. There are mainly two standard sizes to fit most pre-cast (FRC & plastic included) regular and curb entry gullypits with varying plan dimensions between 500 x 500 up to 900 x 900. Custom designs are able to be fabricated for non-standard pits.

Maintenance

Maintenance of the EnviroPod is easy and straight forward. Simply lift the screening bag from the frame and dump out the captured pollutants. Alternatively, the bag can be vacuumed for even faster maintenance. If necessary, replace the oil absorbent media bags.

Capabilities

- ✓ Captures sediment, trash, debris and other pollutants before they enter the storm drain system
- ✓ Fits curb inlet and flat-grate gully pits
- ✓ Easy access — maintenance-friendly design
- ✓ Fits a range of gully pit sizes — ideal for retrofits
- ✓ Adjustable panels allows fine-tuning during installation for a perfect fit

Configurations

Table 1.

	Enviropod - A	Enviropod - C
Gully Pit Width, Min – Max (mm)	500 - 900	500 - 900
Gully Pit Length, Min – Max (mm)	730 - 900	450 – 750
Mesh Size ¹ (µm)	200, 1600	200, 1600
Mesh Size ¹ (µm)	135	60
Mesh Size ¹ (µm)	10-100	10-100
Bypass Flow Rate ² (L/s)	200+	130+



Figure 1. Standard Enviropod Filter

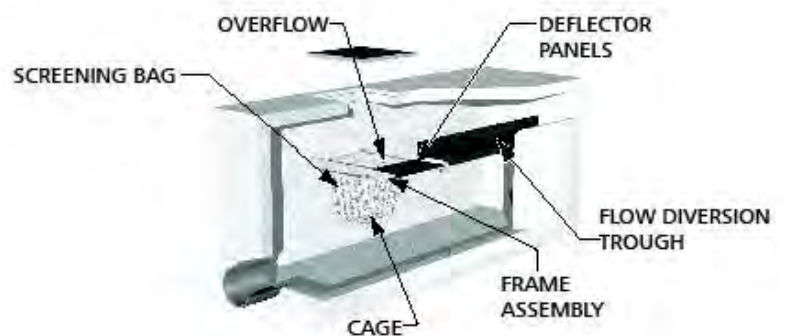


Figure 2. Gully Pit Enviropod Filter configuration

1.2 Parameter Performance

1.2.1 Parameter Performance: Gross Pollutants and Coarse Sediment

Testing at the University of South Australia Urban Water Resources Centre found that the Enviropod unit retained all litter up to an approach flow of 100L/sec. On this basis and the design of the Enviropod Filter bag material which has a sieve aperture of 200 micron we can say with confidence that the Enviropod pre-treatment will retain 100% of Gross Pollutants and coarse sediment – defined by the Victoria Stormwater Committee as particles ranging from 500 to 5000 micron.

For full copies of the testing data please contact Stormwater360.

1.2.2 Parameter Performance: Gross Pollutants and Coarse Sediment

The Enviropod Filter is a gully pit insert designed to be easily retrofitted into new and existing stormwater gully pits, requiring no construction and no land take. Located at the source of stormwater contaminants the Enviropod Filter has interchangeable filters ranging from 100 micron to 4000 micron pore size. For Suspended Solids reduction application we recommend using a monofilament 200micron pore size filter bag (Enviropod 200).

The Enviropod filter relies on removing contaminants from stormwater by the mechanism of direct screening, guaranteeing debris and particles larger the pore size will be removed. Testing done in Auckland using an Enviropod 200micron filter shows a removal of up 97% Suspended Solids for particles 100 to 500micron in size (Butler, Ockleston, Foster, no date, pg 6).

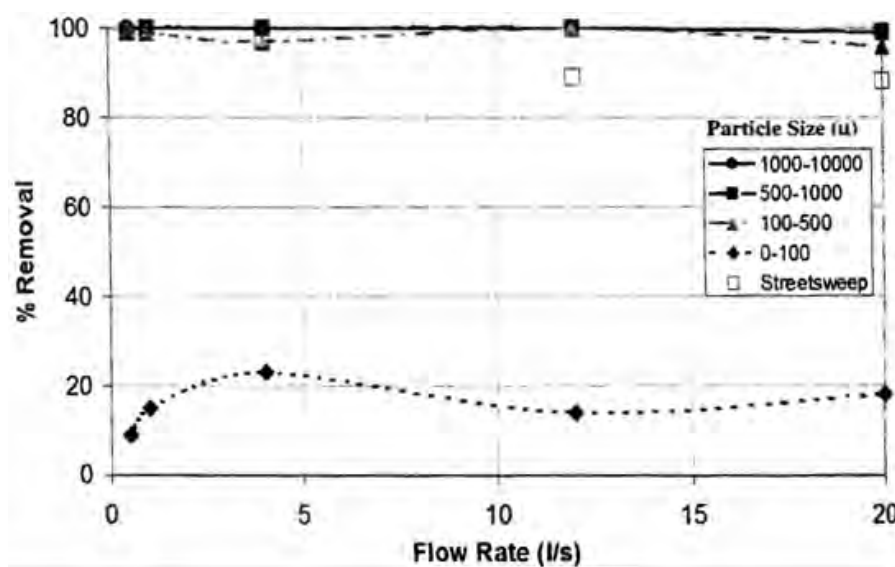


Figure 3. Percentage Removal for various particle sizes.

For full copies of the testing data please contact Stormwater360.

1.2.3 Parameter Performance: Oil and Grease

The EnviroPod uses a perlite based adsorbent material (optional) specially treated to enhance its natural ability to capture and retain oil and grease. The adsorbent material is contained in pouches that are designed to ensure maximum contact with stormwater as it enters the gully pit. Laboratory testing demonstrated that the oil adsorbent material can capture and retain three times its weight in oil.

Each EnviroPod is configured with oil adsorbent pouches around one side of the frame, at the top of the screening bag. During low flows, the water entering the catch basin contacts the oil adsorbent pouches before passing through the screening bag. During high flows, when the EnviroPod begins to bypass, the pouches skim floating oil and grease from the surface of the water retained in the screening bag.



The pouches are clipped to the screening bag for easy removal during maintenance. As the pouches capture oil, the adsorbent material darkens. When the pouches are nearly black they have almost reached their oil adsorbent capacity and should be replaced.

1.3 Inspection and Maintenance

EnviroPod installations vary due the vast number of gully pit configurations. These guidelines should apply to most cases as written. For the remaining cases, follow the general actions of these guidelines, varying them as necessary.

The maintenance crew is responsible for disposing of debris in accordance with all applicable regulations and is responsible for following all applicable regulations, including confined space entry requirements.

Contact the maintenance department at Stormwater360 for more information or to order EnviroPod bags and oil absorbent pouches.

Vacuum Truck Maintenance

1. Establish a safe working area per typical catch basin service activity.
2. Remove grate.
3. Vacuum accumulated debris from the upper portion of the catch basin.
4. Remove and inspect the oil absorbent pouches clipped to the inside of the EnviroPod bag. Replace with new pouches in step 8 if the pouches are dark with oil.
5. Vacuum contents from bag. Once most of the material is removed, remove the bag from the EnviroPod with two manhole cover hooks through the loops at the top of the bag.
6. Clean sediment and oils from sides of bag by shaking and/or brushing, taking care not to damage the bag.
7. Inspect the bag, replace if damaged.
8. Re-install oil absorbent pouches. Place bag in EnviroPod.
9. Replace grate.

Hand Maintenance

1. Establish a safe working area per typical catch basin service activity.
2. Remove manhole cover.
3. Remove any material that is in the trough through the curb inlet or manhole.
4. Remove the bag from the EnviroPod with two manhole cover hooks through the loops at the top of the bag. Excess debris should be scooped out first if the bag is near full.
5. Remove and inspect the oil absorbent pouches clipped to the inside of the bag. Replace with new pouches in step 9 if the pouches are dark with oil.
6. Pour contents of bag into disposal container.
7. Clean sediment and oils from sides of bag by shaking and/or brushing, taking care not to damage the bag.
8. Inspect bag, replace if damaged.
9. Re-install oil absorbent pouches in bag.
10. Place bag in EnviroPod. CRITICAL – There is a steel ring inside the bag. Make sure the loose ends are joined together in the connector tube.
11. Replace manhole cover.