


DRAWING NUMBER
500336-0000-CC-DWG-0001
500336-0000-CC-DWG-0002

DRAWING NUMBER	DISCIPLINE	TITLE
500336-0000-CC-DWG-0001	CIVIL	DRAWING LIST & SITE LOCATION PLAN
500336-0000-CC-DWG-0002	CIVIL	SITE GENERAL ARRANGEMENT PLAN
500336-0000-PP-DWG-0001	PROCESS	PROCESS FLOW DIAGRAM
500336-0000-PP-DWG-0002	PROCESS	LEGEND - SHEET 1 OF 2
500336-0000-PP-DWG-0003	PROCESS	LEGEND - SHEET 2 OF 2
500336-0000-PP-DWG-0004	PROCESS	PROCESS & INSTRUMENT DIAGRAM - TRANSFER STORAGE TANK
500336-0000-PP-DWG-0005	PROCESS	PROCESS & INSTRUMENT DIAGRAM - HELEN STREET RETICULATION PUMPING STATION
500336-0000-PP-DWG-0006	PROCESS	PROCESS & INSTRUMENT DIAGRAM - SODIUM HYPOCHLORITE DOSING SYSTEM 1 OF 2
500336-0000-PP-DWG-0007	PROCESS	PROCESS & INSTRUMENT DIAGRAM - SODIUM HYPOCHLORITE DOSING SYSTEM 2 OF 2
500336-0000-PP-DWG-0008	PROCESS	PROCESS & INSTRUMENT DIAGRAM - AMMONIA DOSING SYSTEM 1 OF 2
500336-0000-PP-DWG-0009	PROCESS	PROCESS & INSTRUMENT DIAGRAM - AMMONIA DOSING SYSTEM 2 OF 2
500336-0000-CC-DWG-0003	CIVIL	NOT USED
500336-0000-CC-DWG-0004	CIVIL	NOT USED
500336-0000-CC-DWG-0005	CIVIL	BULK EARTHWORKS - GENERAL ARRANGEMENT PLAN
500336-0000-CC-DWG-0006	CIVIL	BULK EARTHWORKS - GENERAL ARRANGEMENT SECTIONS
500336-0000-CC-DWG-0007	CIVIL	NOT USED
500336-0000-CC-DWG-0008	CIVIL	NOT USED
500336-0000-CC-DWG-0009	CIVIL	NOT USED
500336-0000-CC-DWG-0010	CIVIL	ROADWORKS - GENERAL ARRANGEMENT PLAN
500336-0000-CC-DWG-0011	CIVIL	ROADWORKS - GENERAL ARRANGEMENT SECTIONS
500336-0000-CC-DWG-0012	CIVIL	ROADWORKS - TYPICAL DETAILS
500336-0000-CC-DWG-0013	CIVIL	ROAD DRAINAGE - GENERAL ARRANGEMENT PLAN
500336-0000-CC-DWG-0014	CIVIL	ROAD DRAINAGE - TYPICAL DETAILS
500336-0000-CC-DWG-0015	CIVIL	LANDSCAPING - GENERAL ARRANGEMENT PLAN
500336-0000-MP-DWG-0001	PIPING	PIPEWORK - GENERAL ARRANGEMENT PLAN
500336-0000-MP-DWG-0002	PIPING	PIPEWORK - DN375 FEED FROM ROUND MOUNTAIN - GENERAL ARRANGEMENT PLAN
500336-0000-MP-DWG-0003	PIPING	PIPEWORK - DN1200 TREATED WATER TANK INLET - GENERAL ARRANGEMENT PLAN
500336-0000-MP-DWG-0004	PIPING	PIPEWORK - DN1200 TREATED WATER TANK OUTLET - GENERAL ARRANGEMENT PLAN
500336-0000-MP-DWG-0005	PIPING	PIPEWORK - DN1200 TREATED WATER TANK OVERFLOW - GENERAL ARRANGEMENT PLAN
500336-0000-SS-DWG-0001	STRUCTURAL	TREATED WATER TANKS - GENERAL ARRANGEMENT PLAN
500336-0000-SS-DWG-0002	STRUCTURAL	TREATED WATER TANKS - GENERAL ARRANGEMENT SECTIONS
500336-0000-SS-DWG-0003	STRUCTURAL	TREATED WATER TANKS - ACCESS STAIRS - GENERAL ARRANGEMENT PLAN
500336-0000-SS-DWG-0004	STRUCTURAL	TREATED WATER TANKS - ACCESS STAIRS - GENERAL ARRANGEMENT SECTION
500336-0000-SS-DWG-0005	STRUCTURAL	NOT USED
500336-0000-SS-DWG-0006	STRUCTURAL	ELECTRICAL TRANSFORMATION - GENERAL ARRANGEMENT PLAN & SECTION
500336-0000-SS-DWG-0007	STRUCTURAL	TREATED WATER PUMPING STATION - GENERAL ARRANGEMENT PLAN
500336-0000-SS-DWG-0008	STRUCTURAL	TREATED WATER PUMPING STATION - GENERAL ARRANGEMENT ELEVATIONS
500336-0000-SS-DWG-0009	STRUCTURAL	TREATED WATER PUMPING STATION - GENERAL ARRANGEMENT SECTIONS
500336-0000-SS-DWG-0010	STRUCTURAL	CHEMICAL DELIVERY & STORAGE AREA - GENERAL ARRANGEMENT PLAN
500336-0000-SS-DWG-0011	STRUCTURAL	CHEMICAL DELIVERY & STORAGE AREA - GENERAL ARRANGEMENT SECTIONS
500336-0000-EC-DWG-0001	ELECTRICAL	PLC/SCADA SYSTEM - NETWORK CONNECTION DIAGRAM
500336-0000-EE-DWG-0001	ELECTRICAL	MAIN SWITCHBOARD MSB-300 - GENERAL ARRANGEMENT
500336-0000-EE-DWG-0011	ELECTRICAL	MAIN SWITCHBOARD MSB-300 - SINGLE LINE DIAGRAM


Approval no: DEV2019/1026
Date: 05 February 2020



--- 100m INTERNAL NOISE BUFFER
 --- 1 IN 100 YR FLOOD LEVEL (RL 32.450)
 --- 1 IN 10,000 YR FLOOD LEVEL (RL 37.000)
 --- 200m BUFFER FROM WIER FULL SUPPLY LEVEL (RL 20.500)

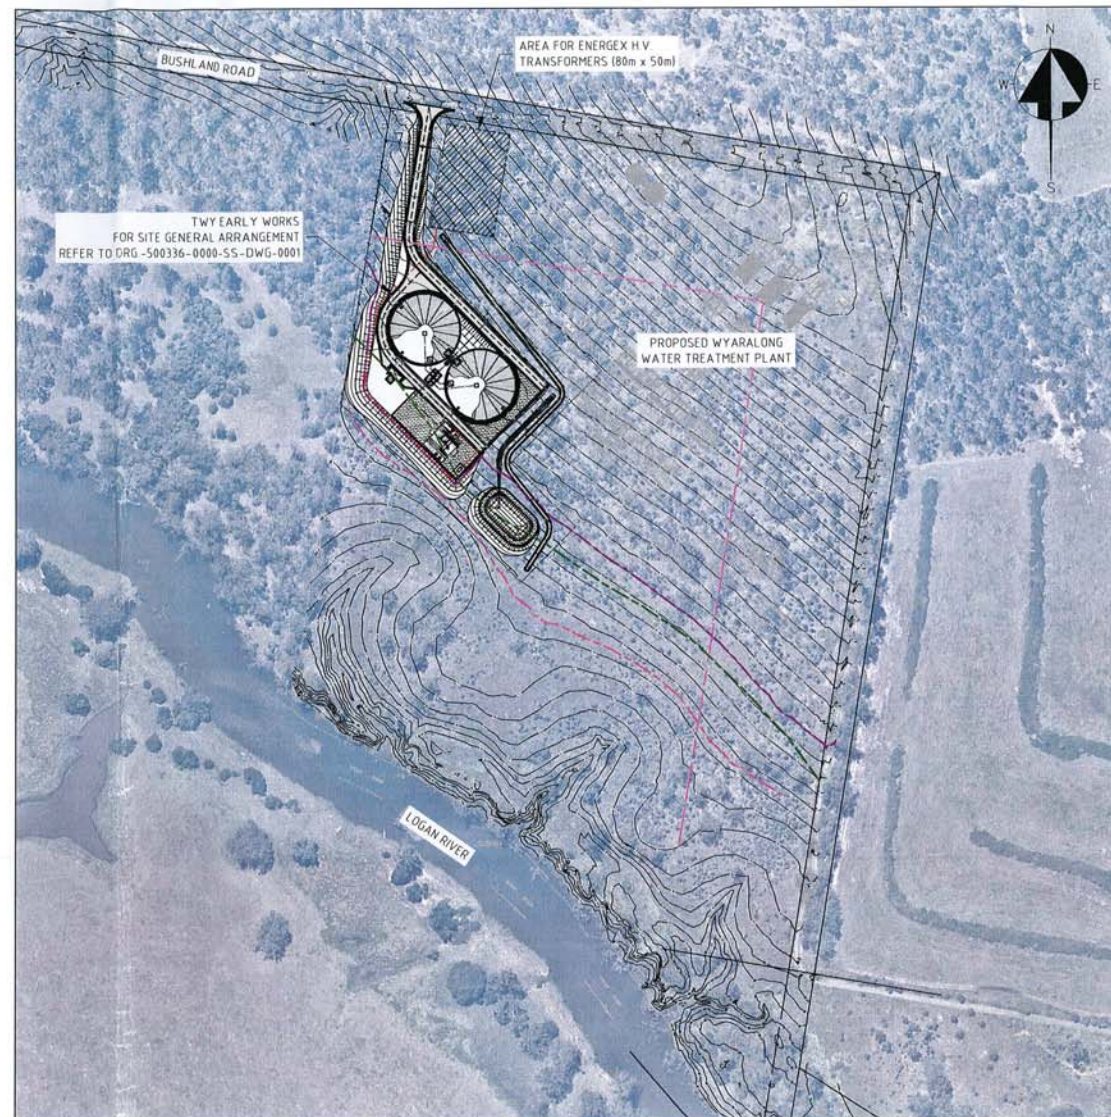

SITE LOCATION PLAN
SCALE 1:2000

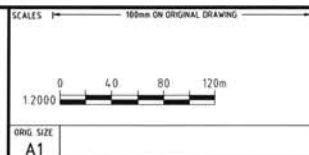[illegible]

TITLE
WYARALONG WATER TREATMENT PLANT
TWO EARLY WORKS

DRAWING LIST & SITE LOCATION PLAN

DRAWING NUMBER
500336-0000-CC-DWG-0001

REVIS	C
-------	---

REVISION