



LINEMARKING LEGEND

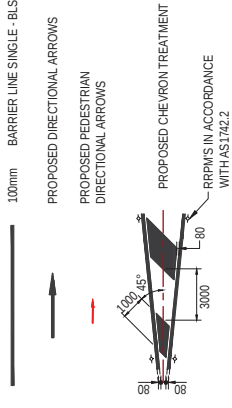

LEGEND

- PROPOSED KERB TYPE B2 IN ACCORDANCE WITH IPWEA STD DRG RS-080
- PROPOSED KERB AND CHANNEL TYPE B1 IN ACCORDANCE WITH IPWEA STD DRG RS-080
- PROPOSED CONCRETE INVERT IN ACCORDANCE WITH IPWEA STD DRG RS-080
- PROPOSED TOP OF BANK
- DESIGN CONTOURS
- PROPOSED STORMWATER DRAINAGE
- PROPOSED WHEEL STOP
- PROPOSED PAVEMENT
- PROPOSED TEMPORARY DRIVEWAY
- PROPOSED BIO-RETENTION
- PROPOSED LANDSCAPING
- EXISTING PAVEMENT SLAB
- EXISTING STORMWATER
- EXISTING SEWER RETICULATION
- EXISTING WATERMAIN
- EXISTING PNEUMATIC WASTE

TOTAL CARPARKS: 199 WITH 1 MOTORBIKE PARK AND 5 ALLOCATED PWD

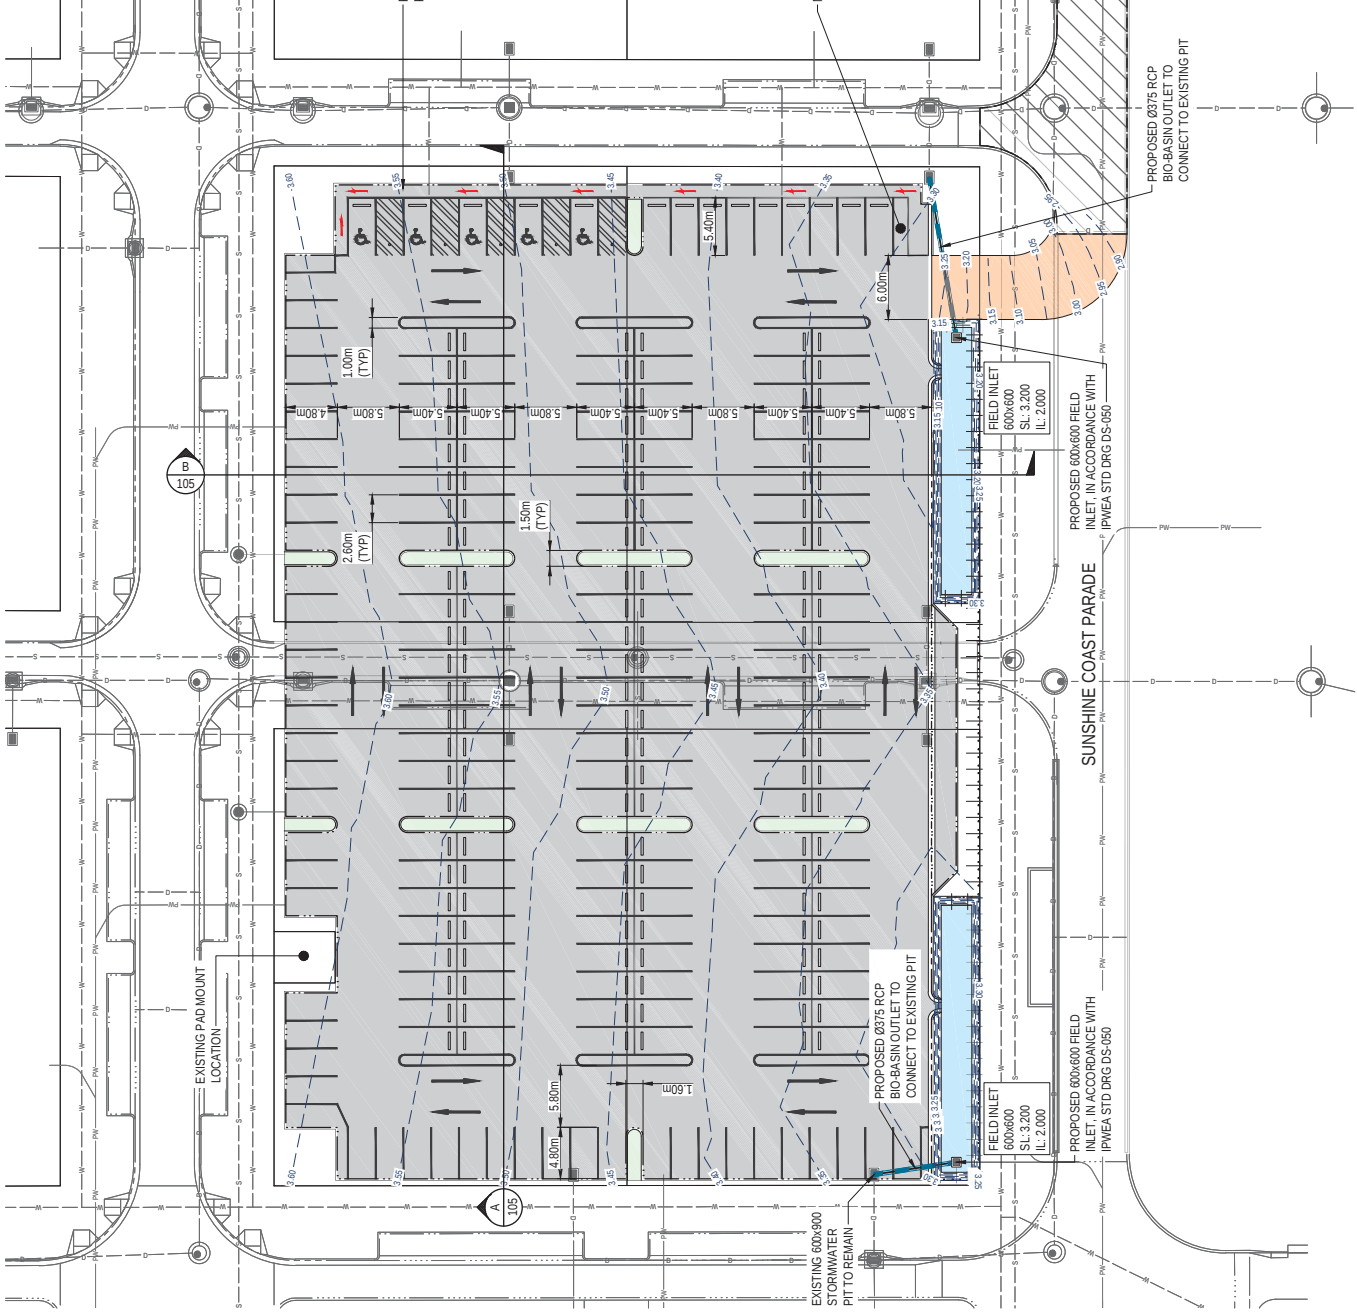

PLANS AND DOCUMENTS referred to in the PDA DEVELOPMENT APPROVAL

Approval no: DEV2019/1090
Date: 6th February 2020

REVISION	DATE	BY	DESCRIPTION
A	22/11/19		ISSUED FOR PERMIT
B			
C			
D			
E			
F			
G			

STATUS	DATE	BY	DESCRIPTION
APPROVED			
DRAFT			
NOT FOR CONSTRUCTION			

SCALE	DATE	BY	DESCRIPTION
SCALE 1:500 (A1)			
SCALE 1:500 (A2)			
SCALE 1:500 (A3)			
SCALE 1:500 (A4)			
SCALE 1:500 (A5)			
SCALE 1:500 (A6)			
SCALE 1:500 (A7)			
SCALE 1:500 (A8)			
SCALE 1:500 (A9)			
SCALE 1:500 (A10)			



SUN CENTRAL
K1, K2, L1 & L2 TEMPORARY CARPARK

Calbre Consulting (Qld) Pty Ltd
10/11-13/15
Bentley QLD Australia 4705
Phone: 08 9440 1111
Fax: 08 9440 1112
Email: info@calbre.com.au

ROADWORKS AND DRAINAGE LAYOUT PLAN

PROJECT NO: 19-000375

DRAWING NO: 104

REVISION