

MACARTHUR AVE.



CIRQUE DU SOLEIL®

PROJECT

OVO INFRA AP 2012

PREPROD

OVO INFRA AP 2012


PREPROD

PRELIMINARY

TITLE	EQUIPMENT ID
BRISBANE 2012	
NORTHSHORE	
SITE LAYOUT	
GENERAL VIEW	

ECHALFOUR	
DRAWN BY	
D. ROUSSEL	
ELEPAGE	
SCALE	
AS SHOWN	
DATE	D
2011/07/25	
APPROVED BY	

FILE NAME
ER-PBSxyY0109_v08
SHEET NUMBER
SHEET REVISION
PBSxyY-01 07

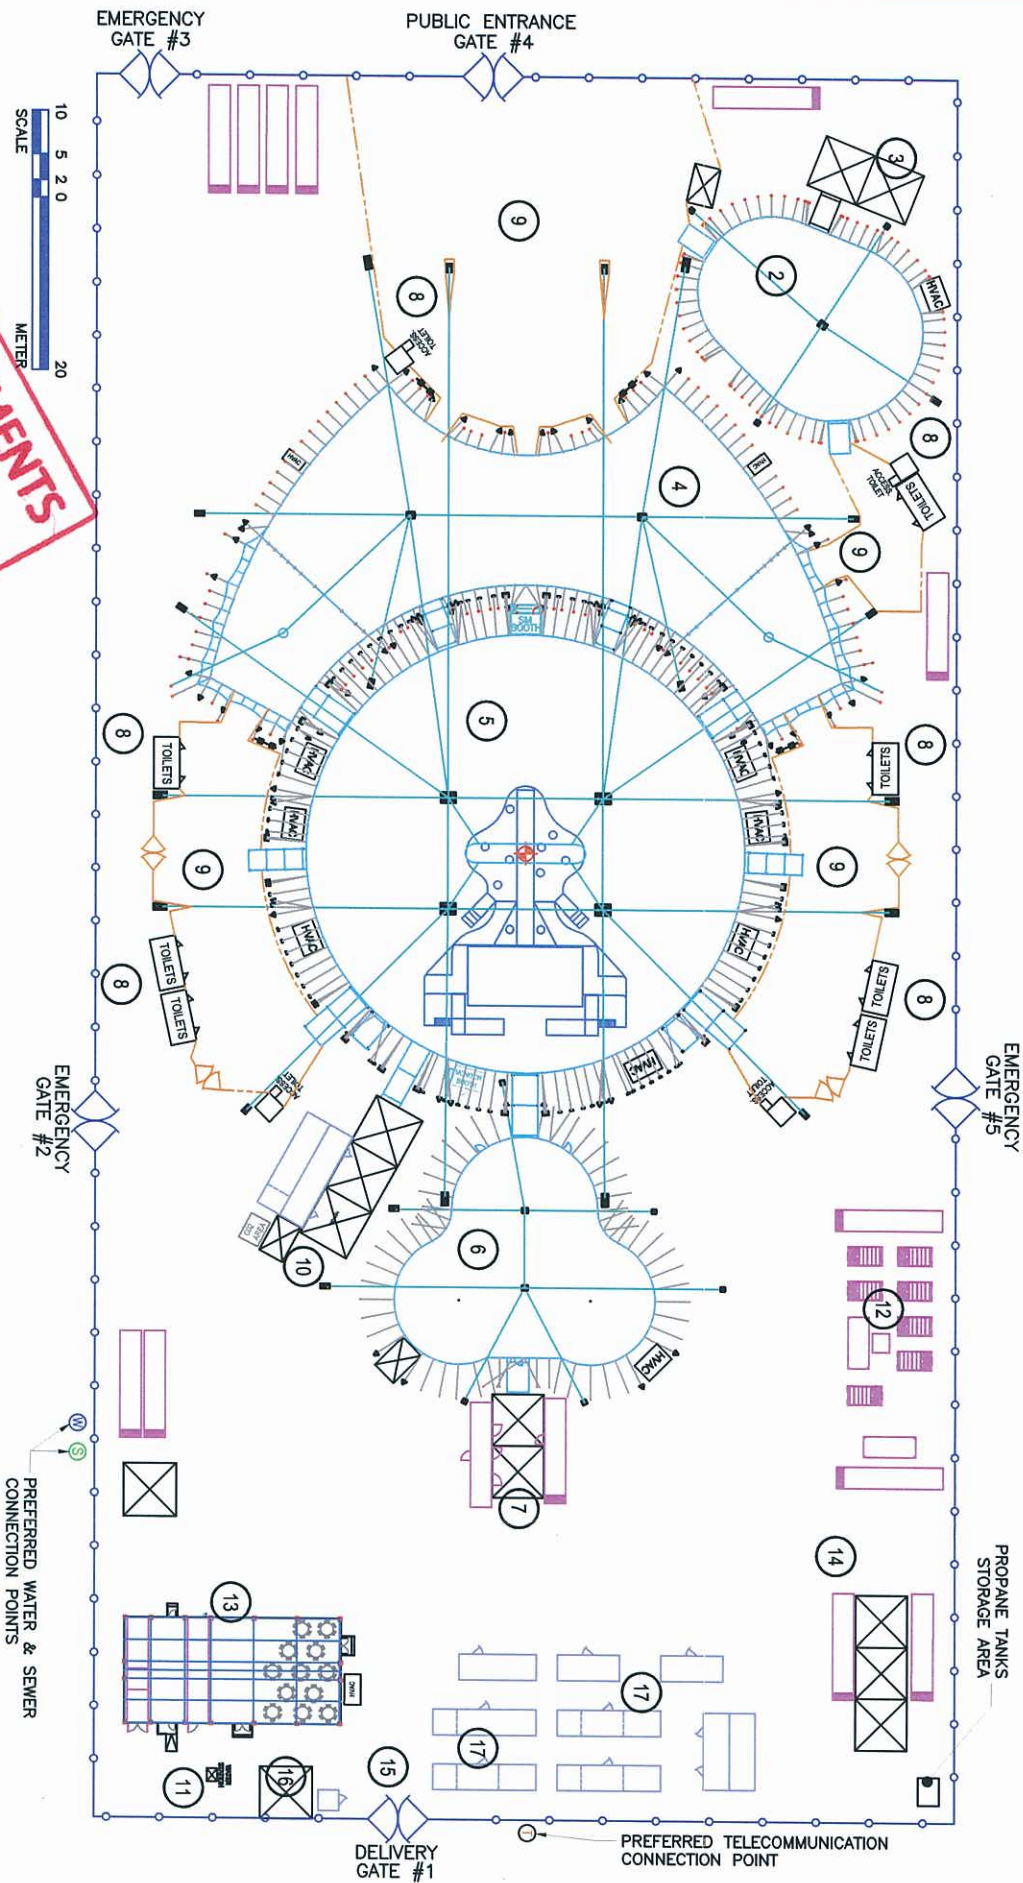

PLANS AND DOCUMENTS
APPROVAL dated 15/6/12

SITE REQUIREMENTS
EASY DRAINAGE OF SITE
CLEAN AND SOLID UNDERGROUND
FENCING OF SITE - 800RS
NO OBSTACLES ON SITE
LEVELLED GROUND
PARKING AVAILABLE OUT OF SITE

SERVICES
ELECTRICITY:
POWER PLANT OUTPUT 2 MW
DISTRIBUTION 480V - 3 PHASES - 3 WIRES + GROUND FOR
HIGH VOLTAGE AND 120/208V - 3 PHASES - 3 WIRES +
GROUND FOR LOW VOLTAGE

TELECOMMUNICATION:
RADIO FREQUENCY AVAILABILITY
IP TELEPHONE SYSTEM, OPTICAL FIBRE ON ALL SITE
21 TELEPHONE LINES

WATER:
50mm AT 2.8 MPa OR 170 L/MIN
SEWER:
11 000 L/30 MIN OR 150mm CONNECTION

HAZARDOUS MATERIALS
FOR PERFORMANCE: HELIUM AND CO2 CYLINDERS ARE USED FOR THE SHOW
PROpane: 3 X 11 KG BOTTLES FOR BBQ
20 X 15 KILOS (33 LBS) PROpane TANKS USED FOR FORK LIFTS
PROVIDED BY LOCAL LICENSED SUPPLIER. WILL REFILL EVERY 15 DAYS.
THE DELIVERY WILL BE DONE IN THE MORNING AND NEVER WHEN PUBLIC IS ON SITE.

HAZARDOUS MATERIALS
DIESEL: 10 000 LITERS (2640 GALLONS) OF DIESEL, DOUBLE WALL TANK FOR GENERATOR SUPPLY, DELIVERED ON SITE BY LOCAL LICENSED
SUPPLIER. THE DELIVERY WILL BE DONE IN THE MORNING AND NEVER WHEN PUBLIC IS ON SITE.
WELDING AND CUTTING GAS: MINOR WELDING WORK IS DONE ON SITE FOR MAINTENANCE OF OUR EQUIPMENT. PROVIDED BY LOCAL
LICENSED SUPPLIER. 2 OXYGEN TANKS COMPRESSED 2 ACETYLENE DISSOLVED 2 PURE ARGON

- 2 V.I.P. TENT**
 - 456 sq. m. - 4908 sq. ft.
 - LOUNGE AREA WITH CATERING SERVICE
 - HVAC: (1) DX UNIT 80 TONS, 168kW HEATING
 - ELECTRICAL SUPPLY: 120/208V
- 3 CATERING TENTS**
 - 2 TENTS 20x20' (6m x 6m)
 - STORAGE AND PREPARATION OF FOOD FOR THE V.I.P.
 - WATER AND SEWER CONNECTION
 - ELECTRICAL SUPPLY: 120/208V
- 4 ENTRANCE TENT**
 - 1081 sq. m. - 11735 sq. ft.
 - BISTRO AREA
 - POINT OF SALES
 - WATER AND SEWER CONNECTIONS AT R&B COUNTERS
 - HVAC: NONE - HEATING: (2) HU UNITS 168kW
 - ELECTRICAL SUPPLY: 120/208V
- 5 BIG TOP TENT**
 - 51m Ø - 2043 sq. m. (161'-4" Ø - 21989 sq. ft.)
 - 2583 SEATS
 - GRANDSTAND WITH INDIVIDUAL SEATING AND STAGE FOR THE PERFORMANCE OF THE SHOW
 - 10 EXITS (4 STAIRS, 4 YOUNGONES AND 2 WHEELCHAIRS)
 - HVAC: (6) DX UNITS 80 TONS, 168kW HEATING & (1) DX UNITS 30 TONS
 - ELECTRICAL SUPPLY: 120/208V
- 6 ARTISTIC TENT**
 - 566 sq. m. - 6092 sq. ft.
 - FOR WARDROBE, DRESSING ROOMS AND ARTISTIC TRAINING
 - CONNECTION TO THE BIG TOP VIA ARTISTIC TUNNEL
 - HVAC: (1) DX UNIT 80 TONS, 168kW HEATING
 - ELECTRICAL SUPPLY: 120/208V
- 7 SANITARY FACILITIES**
 - FOR ARTISTS AND STAFF USE ONLY: TOILETS, URINALS, SHOWERS, LAVATORIES, WASHERS & DRYERS
 - WATER AND SEWER CONNECTION
 - ELECTRICAL SUPPLY: 480V
- 8 PUBLIC TOILETS**
 - WATER CLOSET WITH ACCESSIBLE UNITS
 - HAND WASHING STATIONS AVAILABLE AT EVERY LOCATION OF PUBLIC TOILETS
 - WATER AND SEWER CONNECTIONS
 - ELECTRICAL SUPPLY: 120/208V
- 9 PUBLIC AREA**
 - WAITING AREA
 - DELIMITED WITH A NON-FIXED 3' HIGH WOOD FENCE
- 10 SHOW SHOP**
 - PREPARATION, REPAIRS AND MAINTENANCE OF ACCESSORIES FOR THE SHOW
 - ELECTRICAL SUPPLY: 480V
- 11 WATER STATION AND DISTRIBUTION**
 - UNIT FOR TREATMENT AND PRESSURE CONTROL - DISTRIBUTION OF WATER ON SITE BY PUMP AND MAINFOLD
 - ELECTRICAL SUPPLY: 120/208V
- 12 ELECTRICAL SERVICES**
 - DIESEL POWERED POWER GENERATOR
 - ELECTRICAL DISTRIBUTION CONTAINER WITH MAIN - NO OF GENERATORS AND SPECS: (7) 350 kW
 - NO OF FUEL TANK: 1
- 13 STAFF KITCHEN**
 - KITCHEN FOR STAFF & ARTISTS WITH DINNING SPACES
 - WATER AND SEWER CONNECTION
 - ELECTRICAL SUPPLY: 120/208V
- 14 WORK SHOP**
 - GENERAL MAINTENANCE FOR SITE EQUIPMENT - WELDING AND CUTTING GAS
 - ELECTRICAL SUPPLY: 480V, 120/208V
- 15 SECURITY GATE**
 - STAFF MAIN ENTRANCE GATE WITH 24 HOURS SECURITY
- 16 TEMPORARY STAFF TENT**
 - 1 TENTS 20x20' (6.1m x 6.1m)
 - LOCKER AND OFFICE TEMPORARY STAFF
 - ELECTRICAL SUPPLY: 120/208 V
- 17 PRODUCTION OFFICES**
 - LOGISTICAL, FINANCES, OPERATION, SCHOOL AND TOUR MANAGER OFFICES
 - ELECTRICAL SUPPLY: 120/208V



CIRQUE DU SOLEIL.



CIRQUE DU SOLEIL.

CDS

PERMIT

OVO INFRA AP 2012

PREPROD

REVISIONS HISTORY

No	DATE	YYYYMMDD	BY	DESCRIPTION	CODE
01	2012/03/30		ELEPAGE	GEN	

TITLE

TYPICAL SITE

DESCRIPTION LIST

GENERAL VIEW

EQUIPMENT ID

PROJ. MANAGER

E. CHALFOUR

DRAWN BY

ELEPAGE

D. ROUSSEL

SCALE

AS SHOWN

DATE

2011/07/25

APPROVED BY

ER-PSIXP0106

SHEET NUMBER

PSIXP-02

SHEET REVISION

01