

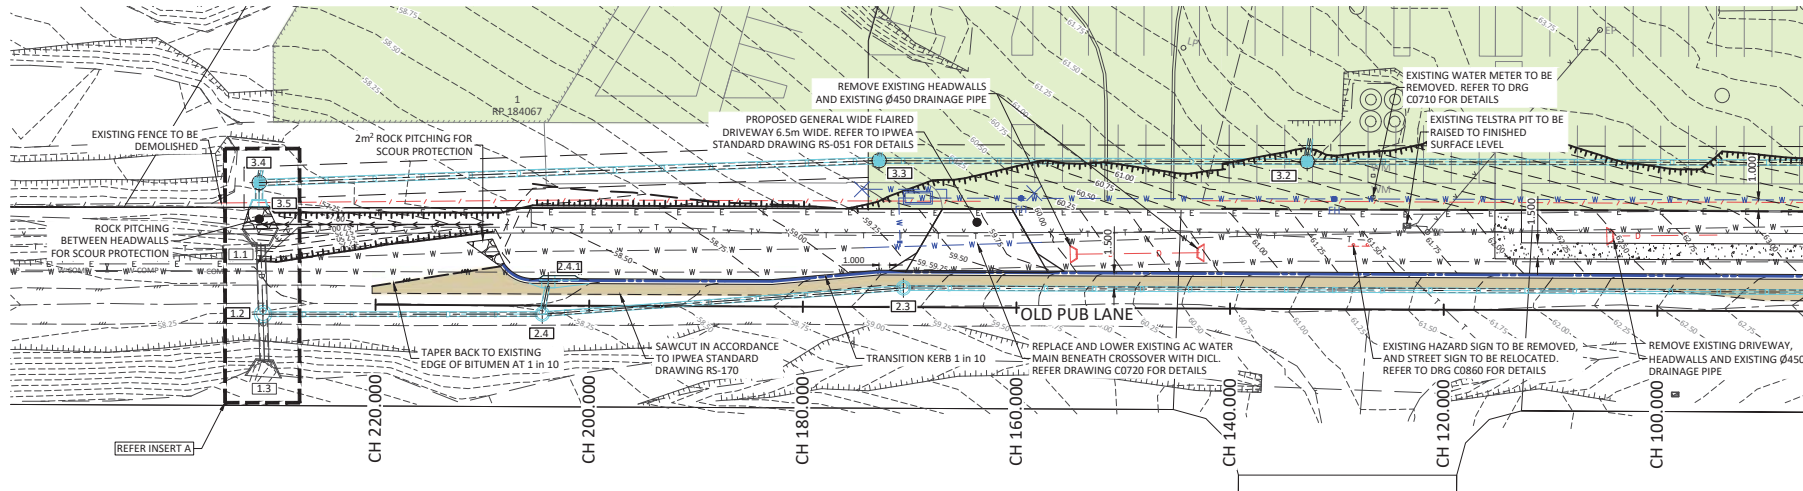


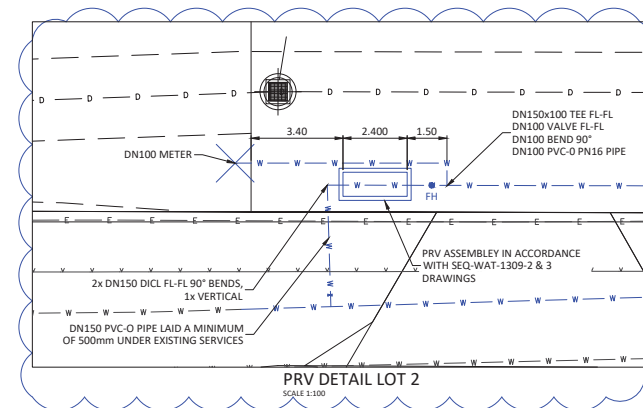

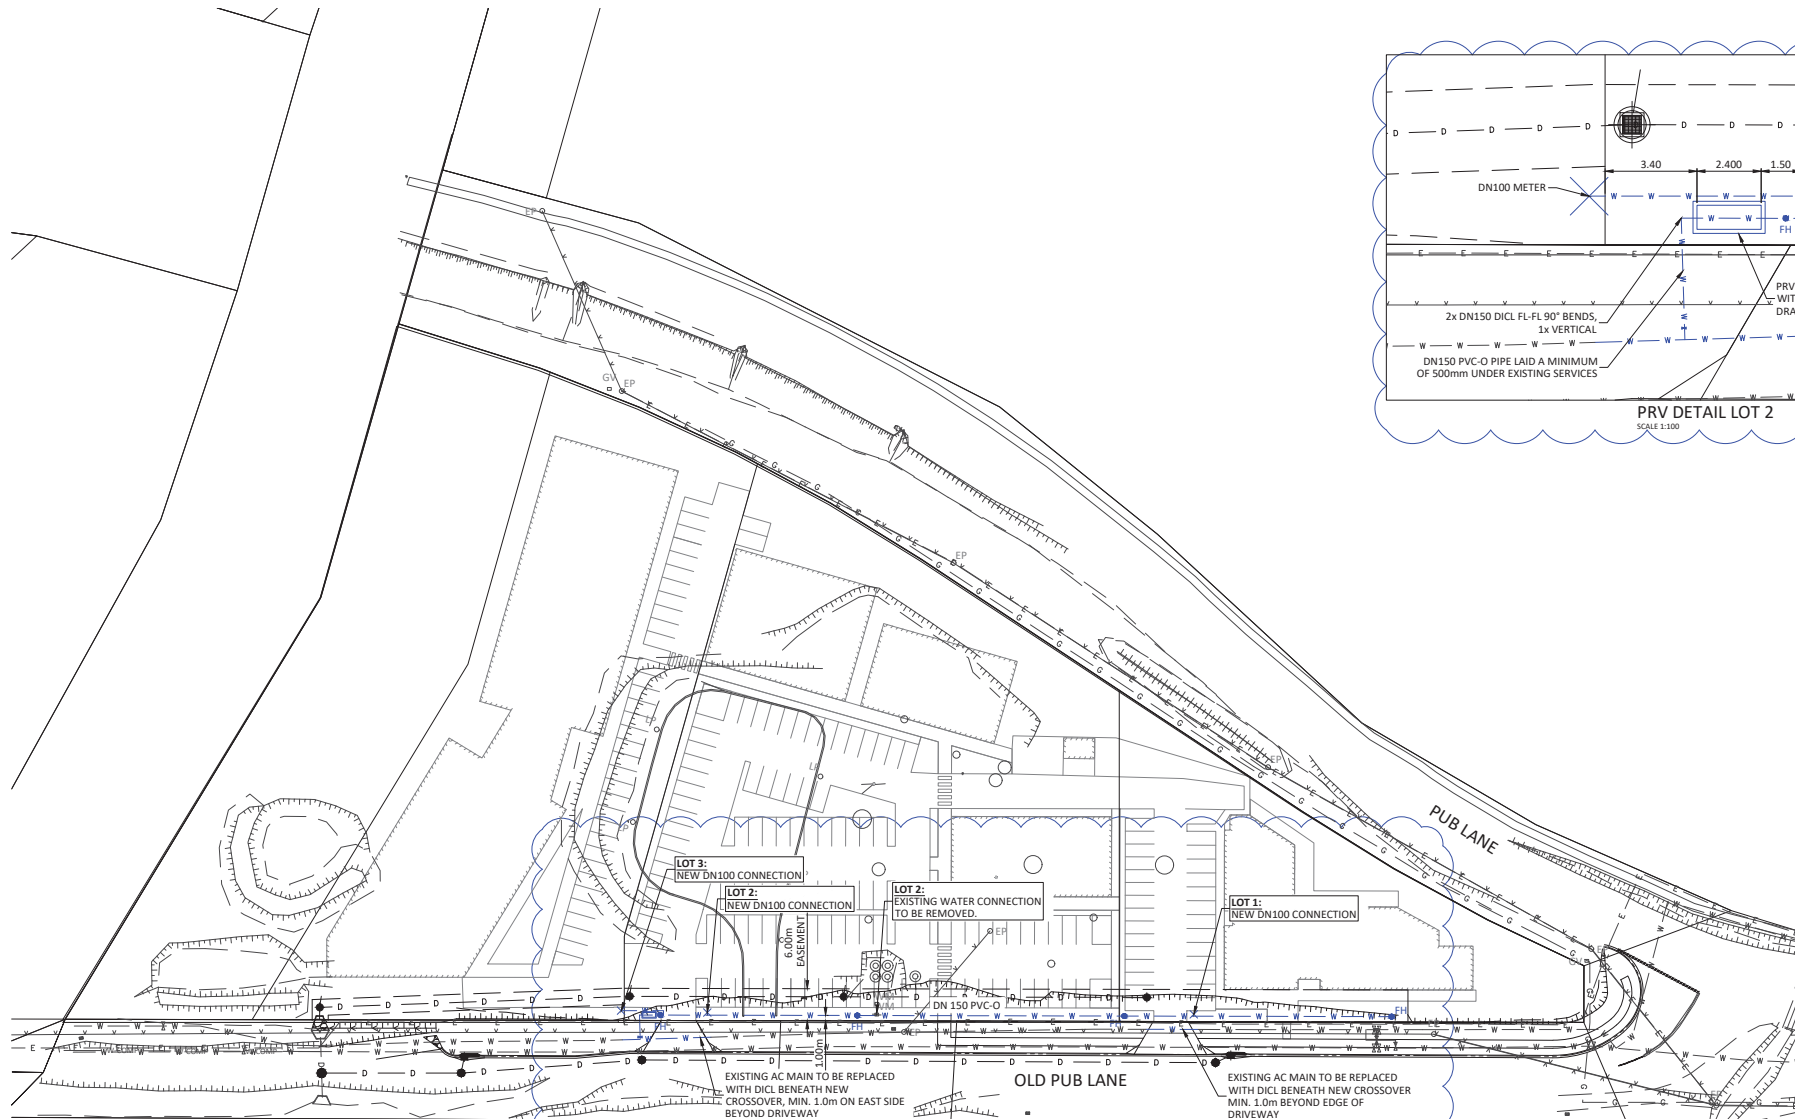

PLAN
SCALE 1:500

PLANS AND DOCUMENTS
referred to in the PDA
DEVELOPMENT APPROVAL

Approval no: DEV2019/1042/4
Date: 23 September 2020



THIS DRAWING IS BEST
VIEWED IN COLOUR AND
ON AN ELECTRONIC DEVICE

PROJECT NORTH

DIMENSIONS IN METRES EXCEPT WHERE SHOWN OTHERWISE. CULVERT AND PIPE SIZES IN MILLIMETRES

SCALES

0 5 10 15 20 25m

1:500 / 1:1000

STATUS

FOR APPROVAL

SCAN QR CODE TO
CONFIRM CURRENT
DRAWING REVISION



REV	DATE	DESCRIPTION	DWN	DES	CHK	APP
B	06.08.20	PRV & WATERMAIN ADDED	BK	BK	RG	
A	13.07.20	EDQ RFI RESPONSE	LCF	AL	RG	

ASSOCIATED CONSULTANTS

APPROVED	CHECKED
..... 7729 RPEQ	
DATE	DATE


**BORNHORST
+WARD**

CLIENT
OLD PUB LANE PTY LTD

PROJECT
OLD PUB LANE, GREENBANK

SUBJECT
WATER RETICULATION SITE PLAN

PROJECT No.
19097
DRAWING No.
C0702
REVISION
B

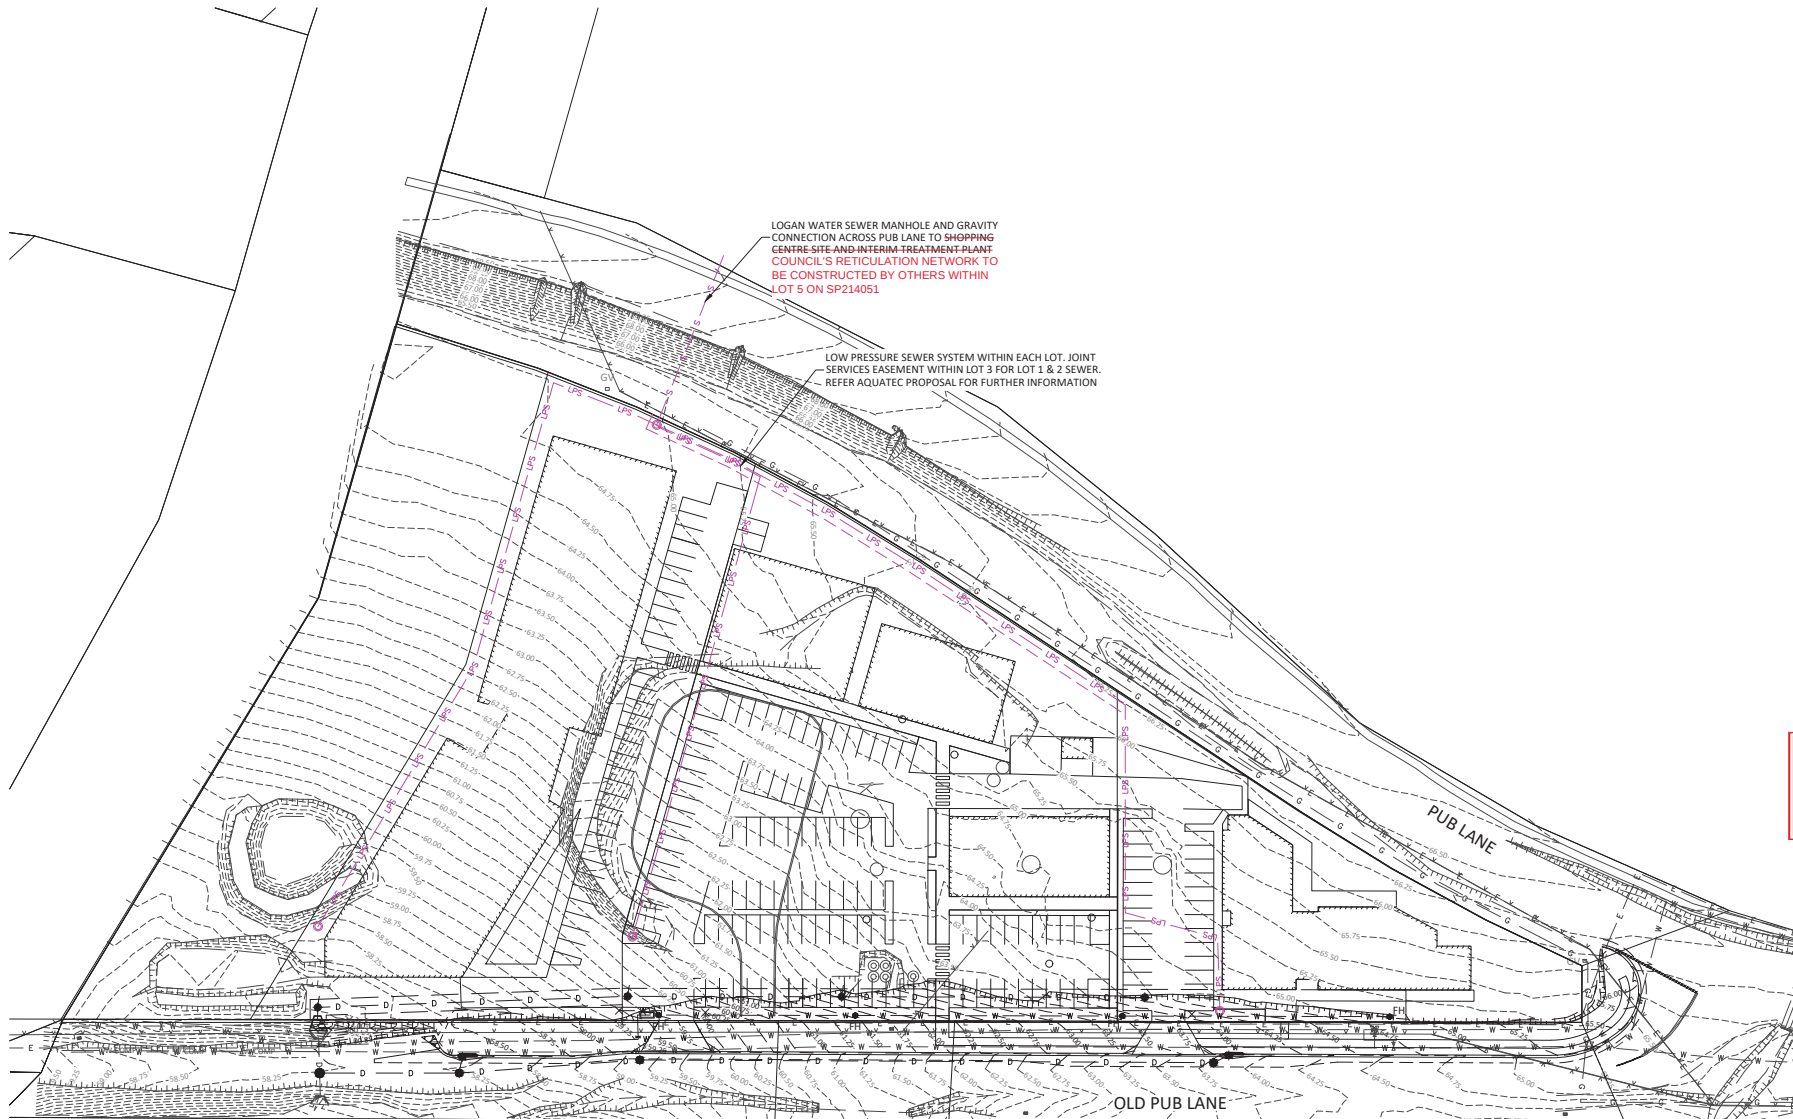

AMENDED IN RED

By: Anita Torbey Fuller

Date: 20 August 2020



THIS DRAWING IS BEST VIEWED IN COLOUR AND ON AN ELECTRONIC DEVICE



DIMENSIONS IN METRES EXCEPT WHERE SHOWN OTHERWISE. CULVERT AND PIPE SIZES IN MILLIMETRES

SCALES

0 5 10 15 20 25m

1 : 500 / 1 : 1000

A1 UNREDUCED
A3 REDUCED
UNREDUCED / REDUCED

PLANS AND DOCUMENTS
referred to in the PDA
DEVELOPMENT APPROVAL

Approval no: DEV2019/1042/4

Date: 23 September 2020



FOR APPROVAL

SCAN QR CODE TO
CONFIRM CURRENT
DRAWING REVISION



REV	DATE	DESCRIPTION	DWN	DES	CHK	APP
A	13.07.20	EDQ RFI RESPONSE	LCF	AL	RG	

ASSOCIATED CONSULTANTS	APPROVED	CHECKED
	7729 RPEQ	
	DATE	DATE

BORNHORST + WARD

+61 (0) 3013 4000 www.bornhorstward.com.au

CLIENT
OLD PUB LANE PTY LTD

PROJECT
OLD PUB LANE,
GREENBANK

SUBJECT
CONCEPT SITE SEWER PLAN

PROJECT No.
19097

DRAWING No.
C0602

REVISION
A