



ARCHITECTURAL DRAWING REGISTER

A-SD - 00.01	Cover Sheet & Drawing List
A-SD - 00.02	3D Views
A-SD - 00.03	3D Views
A-SD - 00.04	3D Views
A-SD - 00.05	3D Views
A-SD - 00.06	3D Views
A-SD - 10.01	Site Plan
A-SD - 23.01	Floor Plan - Level 0
A-SD - 23.02	BCA Floor Plan
A-SD - 24.01	Roof Plan
A-SD - 25.01	Reflected Ceiling Plan - Level 0
A-SD - 29.01	Detail Floor Plan - Level 0 Part A
A-SD - 29.02	Detail Floor Plan - Level 0 Part B
A-SD - 29.03	Detail Floor Plan - Level 0 Part C
A-SD - 30.01	Building Elevations
A-SD - 40.01	Building Sections
A-SD - 40.02	Building Sections
A-SD - 80.01	Materials & Finishes Schedule
A-SD - 80.02	Materials & Finishes Schedule
A-SD - 90.01	3D Perspective

+ Caloundra South Ambulance Station -
Vehicle Swept Path Sketch Garbage Truck -
Project No. BR210695, Drawing No:
SKC01-001 Issue A dated Nov 2022 by Phillips
Smith Conwell & Acor Consultants (QLD) Pty
Ltd

VIEW FROM CORNER OF
SPLENDOUR & FESTIVAL STREET

Refer to Approved Landscape Plan for
revised landscape intent

AMENDED IN RED

By: Andrew McKnight
Date: 29 November 2022



PLANS AND DOCUMENTS
referred to in the PDA
DEVELOPMENT APPROVAL

Approval no: DEV2022/1351
Date: 30 January 2023



Barcode			
PHILLIPS SMITH CONWELL 46 Berwick Street PO Box 479 Fortitude Valley Queensland 4006 Australia T +617 3257 1167 pscarch@psc-architects.com.au Verify all dimensions & check levels on site before commencing work. Do not scale from the drawing. The drawing is copyright & remains the property of the architect & shall not be reproduced or copied in any form or by any means without the written permission of the architect.			
AMD	SUBJECT	INT	DATE
1	REVIEW ISSUE	IB/IR	12.08.22
DRAWING INDEX SYSTEM Building & Asset Services ePlan Room use only ☐ CEILING PLANS ☐ CONSTRUCTION DETAILS ☐ ELEVATIONS ☐ EXTERNAL WORKS ☐ FITOUTS ☐ FLOOR PLANS ☐ FURNITURE & EQUIPMENT ☐ HYDRAULICS ☐ MASTER PLAN ☐ MISCELLANEOUS DETAILS ☐ OTHER ☐ PLAY STRUCTURES ☐ ROOF PLANS ☐ SECTIONS ☐ SETOUT PLAN ☐ SITE PLAN ☐ STANDARDS			



VIEW FROM SPLENDOUR STREET

Refer to Approved Landscape Plan for revised landscape intent

AMENDED IN RED
By: Andrew McKnight
Date: 29 November 2022

PLANS AND DOCUMENTS referred to in the PDA DEVELOPMENT APPROVAL
Approval no: DEV2022/1351
Date: 30 January 2023

Barcode

PHILLIPS
SMITH
CONWELL

46 Berwick Street
PO Box 479 Fortitude Valley
Queensland 4006 Australia
T +617 3257 1167
pscarch@psc-architects.com.au

Verify all dimensions & check levels on site before commencing work. Do not scale from the drawing. The drawing is copyright & remains the property of the architect & shall not be reproduced or copied in any form or by any means without the written permission of the architect.

AMD	SUBJECT	INT	DATE
1	REVIEW ISSUE	IB/IR	12.08.22
2	REVIEW ISSUE	IB/IR	#NOT ISSUED
3	AMENDED FENCE	OT/IR	22.11.22

DRAWING INDEX SYSTEM

Building & Asset Services ePlan Room use only

☐ CEILING PLANS

☐ CONSTRUCTION DETAILS

☐ ELEVATIONS

☐ EXTERNAL WORKS

☐ FITOUTS

☐ FLOOR PLANS

☐ FURNITURE & EQUIPMENT

☐ HYDRAULICS

☐ MASTER PLAN

☐ MISCELLANEOUS DETAILS

☐ PLAY STRUCTURES

☐ ROOF PLANS

☐ SECTIONS

☐ SETOUT PLAN

☐ SITE PLAN

☐ STANDARDS

CLIENT



CONTRACTOR

PROJECT MANAGER

 **Queensland Government**
Department of Energy and Public Works

DRAWN

DATE

IB

DRAFTING CHECK

DATE

ND

DISCIPLINE DIRECTOR AUTHORISED FOR ISSUE

DATE

Ian Robinson

DISCIPLINE TEAM LEADER

DATE

Nick Dazeley

STATUS

Preliminary

Caloundra South Ambulance Station

3D Views

Scale at A1

Scale at A3

Master Site Number

PSC Job Number

5857

Drawing Number

Issue

Sheet No.

A-SD-00.02

3



VIEW FROM CORNER OF SPLENDOUR & FESTIVAL STREET

Refer to Approved Landscape Plan for revised landscape intent

AMENDED IN RED
By: Andrew McKnight
Date: 29 November 2022

PLANS AND DOCUMENTS
referred to in the PDA
DEVELOPMENT APPROVAL
Approval no: DEV2022/1351
Date: 30 January 2023

Barcode

PHILLIPS
SMITH
CONWELL

46 Berwick Street
PO Box 479 Fortitude Valley
Queensland 4006 Australia
T +617 3257 1167
pscarch@psc-architects.com.au

Verify all dimensions & check levels on site before commencing work. Do not scale from the drawing. The drawing is copyright & remains the property of the architect & shall not be reproduced or copied in any form or by any means without the written permission of the architect.

AMD	SUBJECT	INT	DATE
1	REVIEW ISSUE	IB/IR	12.08.22

DRAWING INDEX SYSTEM

Building & Asset Services ePlan Room use only

☐ CEILING PLANS

☐ CONSTRUCTION DETAILS

☐ ELEVATIONS

☐ EXTERNAL WORKS

☐ FITOUTS

☐ FLOOR PLANS

☐ FURNITURE & EQUIPMENT

☐ HYDRAULICS

☐ MASTER PLAN

☐ MISCELLANEOUS DETAILS

☐ OTHER

☐ PLAY STRUCTURES

☐ ROOF PLANS

☐ SECTIONS

☐ SETOUT PLAN

☐ SITE PLAN

☐ STANDARDS

CLIENT



CONTRACTOR

PROJECT MANAGER



Queensland
Government

Department of
Energy and Public Works

DRAWN

DATE

IB

DRAFTING CHECK

DATE

ND

DISCIPLINE DIRECTOR
AUTHORISED FOR ISSUE

DATE

Ian Robinson

DISCIPLINE TEAM LEADER

DATE

Nick Dazeley

STATUS

Preliminary

Caloundra South Ambulance Station

3D Views

Scale at A1

Scale at A3

Master Site Number

PSC Job Number

5857

Drawing Number

Issue

Sheet No.

A-SD-00.03

1



VIEW OF ROOFED PATIO

PLANS AND DOCUMENTS
referred to in the PDA
DEVELOPMENT APPROVAL
Approval no: DEV2022/1351
Date: 30 January 2023



Barcode

PHILLIPS
SMITH
CONWELL

46 Berwick Street
PO Box 479 Fortitude Valley
Queensland 4006 Australia
T +617 3257 1167
pscarch@psc-architects.com.au

Verify all dimensions & check levels on site before commencing work. Do not scale from the drawing. The drawing is copyright & remains the property of the architect & shall not be reproduced or copied in any form or by any means without the written permission of the architect.

AMD	SUBJECT	INT	DATE
1	REVIEW ISSUE	IB/IR	12.08.22

DRAWING INDEX SYSTEM

Building & Asset Services ePlan Room use only

☐ CEILING PLANS

☐ CONSTRUCTION DETAILS

☐ ELEVATIONS

☐ EXTERNAL WORKS

☐ FITOUTS

☐ FLOOR PLANS

☐ FURNITURE & EQUIPMENT

☐ HYDRAULICS

☐ MASTER PLAN

☐ MISCELLANEOUS DETAILS

☐ OTHER

☐ PLAY STRUCTURES

☐ ROOF PLANS

☐ SECTIONS

☐ SETOUT PLAN

☐ SITE PLAN

☐ STANDARDS

CLIENT



CONTRACTOR

PROJECT MANAGER



Queensland
Government

Department of
Energy and Public Works

DRAWN	DATE
IB	
DRAFTING CHECK	DATE
ND	
DISCIPLINE DIRECTOR AUTHORISED FOR ISSUE	DATE
Ian Robinson	
DISCIPLINE TEAM LEADER	DATE
Nick Dazeley	

STATUS

Preliminary

Caloundra South Ambulance Station

3D Views

Scale at A1

Scale at A3

Master Site Number	PSC Job Number	
	5857	
Drawing Number	Issue	Sheet No.
A-SD-00.04	1	



VIEW OF KITCHEN

PLANS AND DOCUMENTS
referred to in the PDA
DEVELOPMENT APPROVAL


Approval no: DEV2022/1351
Date: 30 January 2023

Barcode

PHILLIPS
SMITH
CONWELL

46 Berwick Street
PO Box 479 Fortitude Valley
Queensland 4006 Australia
T +617 3257 1167
pscarch@psc-architects.com.au

Verify all dimensions & check levels on site before commencing work. Do not scale from the drawing. The drawing is copyright & remains the property of the architect & shall not be reproduced or copied in any form or by any means without the written permission of the architect.

AMD	SUBJECT	INT	DATE
1	REVIEW ISSUE	IB/IR	12.08.22

DRAWING INDEX SYSTEM

Building & Asset Services ePlan Room use only

☐ CEILING PLANS

☐ CONSTRUCTION DETAILS

☐ ELEVATIONS

☐ EXTERNAL WORKS

☐ FITOUTS

☐ FLOOR PLANS

☐ FURNITURE & EQUIPMENT

☐ HYDRAULICS

☐ MASTER PLAN

☐ MISCELLANEOUS DETAILS

☐ PLAY STRUCTURES

☐ ROOF PLANS

☐ SECTIONS

☐ SETOUT PLAN

☐ SITE PLAN

☐ STANDARDS

CLIENT



CONTRACTOR

PROJECT MANAGER



Queensland
Government

Department of
Energy and Public Works

DRAWN

Author

DATE

DRAFTING CHECK

Checker

DATE

DISCIPLINE DIRECTOR
AUTHORISED FOR ISSUE

Ian Robinson

DATE

03/04/22

DISCIPLINE TEAM LEADER

Nick Dazeley

DATE

03/04/22

STATUS

Preliminary

Caloundra South Ambulance Station

3D Views

Scale at A1

Scale at A3

Master Site Number

PSC Job Number

5857

Drawing Number

Issue

Sheet No.

A-SD- 00.05

1



VIEW OF DAYROOM



VIEW OF SIGN & BRICKWORK DETAIL

Barcode

PHILLIPS
SMITH
CONWELL

46 Berwick Street
PO Box 479 Fortitude Valley
Queensland 4006 Australia
T +617 3257 1167
pscarch@psc-architects.com.au

Verify all dimensions & check levels on site before commencing work. Do not scale from the drawing. The drawing is copyright & remains the property of the architect & shall not be reproduced or copied in any form or by any means without the written permission of the architect.

AMD	SUBJECT	INT	DATE
1	REVIEW ISSUE	IB/IR	12.08.22

DRAWING INDEX SYSTEM
Building & Asset Services ePlan Room use only

☐ CEILING PLANS
☐ CONSTRUCTION DETAILS
☐ ELEVATIONS
☐ EXTERNAL WORKS
☐ FITOUTS
☐ FLOOR PLANS
☐ FURNITURE & EQUIPMENT
☐ HYDRAULICS
☐ MASTER PLAN

☐ MISCELLANEOUS DETAILS
☐ OTHER
☐ PLAY STRUCTURES
☐ ROOF PLANS
☐ SECTIONS
☐ SETOUT PLAN
☐ SITE PLAN
☐ STANDARDS

CLIENT



CONTRACTOR

PROJECT MANAGER



Queensland
Government

Department of
Energy and Public Works

DRAWN	DATE
IB	
DRAFTING CHECK	DATE
ND	
DISCIPLINE DIRECTOR AUTHORISED FOR ISSUE	DATE
Ian Robinson	
DISCIPLINE TEAM LEADER	DATE
Nick Dazeley	

STATUS

Preliminary

Caloundra South Ambulance Station

3D Views

Scale at A1Scale at A3

Master Site Number	PSC Job Number	
	5857	
Drawing Number	Issue	Sheet No.
A-SD-00.06	1	



VIEW FROM FESTIVAL STREET STREET

Refer to Approved Landscape Plan for revised landscape intent

AMENDED IN RED
By: Andrew McKnight
Date: 29 November 2022

PLANS AND DOCUMENTS
referred to in the PDA
DEVELOPMENT APPROVAL
Approval no: DEV2022/1351
Date: 30 January 2023

Barcode

PHILLIPS
SMITH
CONWELL

46 Berwick Street
PO Box 479 Fortitude Valley
Queensland 4006 Australia
T +617 3257 1167
pscarch@psc-architects.com.au

Verify all dimensions & check levels on site before commencing work. Do not scale from the drawing. The drawing is copyright & remains the property of the architect & shall not be reproduced or copied in any form or by any means without the written permission of the architect.

AMD	SUBJECT	INT	DATE
1	AMENDED FENCE	OT/R	22.11.22

DRAWING INDEX SYSTEM

Building & Asset Services ePlan Room use only

☐ CEILING PLANS

☐ CONSTRUCTION DETAILS

☐ ELEVATIONS

☐ EXTERNAL WORKS

☐ FITOUTS

☐ FLOOR PLANS

☐ FURNITURE & EQUIPMENT

☐ HYDRAULICS

☐ MASTER PLAN

☐ MISCELLANEOUS DETAILS

☐ PLAY STRUCTURES

☐ ROOF PLANS

☐ SECTIONS

☐ SETOUT PLAN

☐ SITE PLAN

☐ STANDARDS

CLIENT



CONTRACTOR

PROJECT MANAGER



Queensland
Government

Department of
Energy and Public Works

DRAWN	DATE
Author	

DRAFTING CHECK	DATE
Checker	

DISCIPLINE DIRECTOR AUTHORISED FOR ISSUE	DATE
Ian Robinson	11/22/22

DISCIPLINE TEAM LEADER	DATE
Nick Dazeley	11/22/22

STATUS

Preliminary

Caloundra South Ambulance Station

Stairs


3D Views

Scale at A1

Scale at A3

Master Site Number	PSC Job Number
	5857

Drawing Number	Issue	Sheet No.
A-SD- 00.07	1	

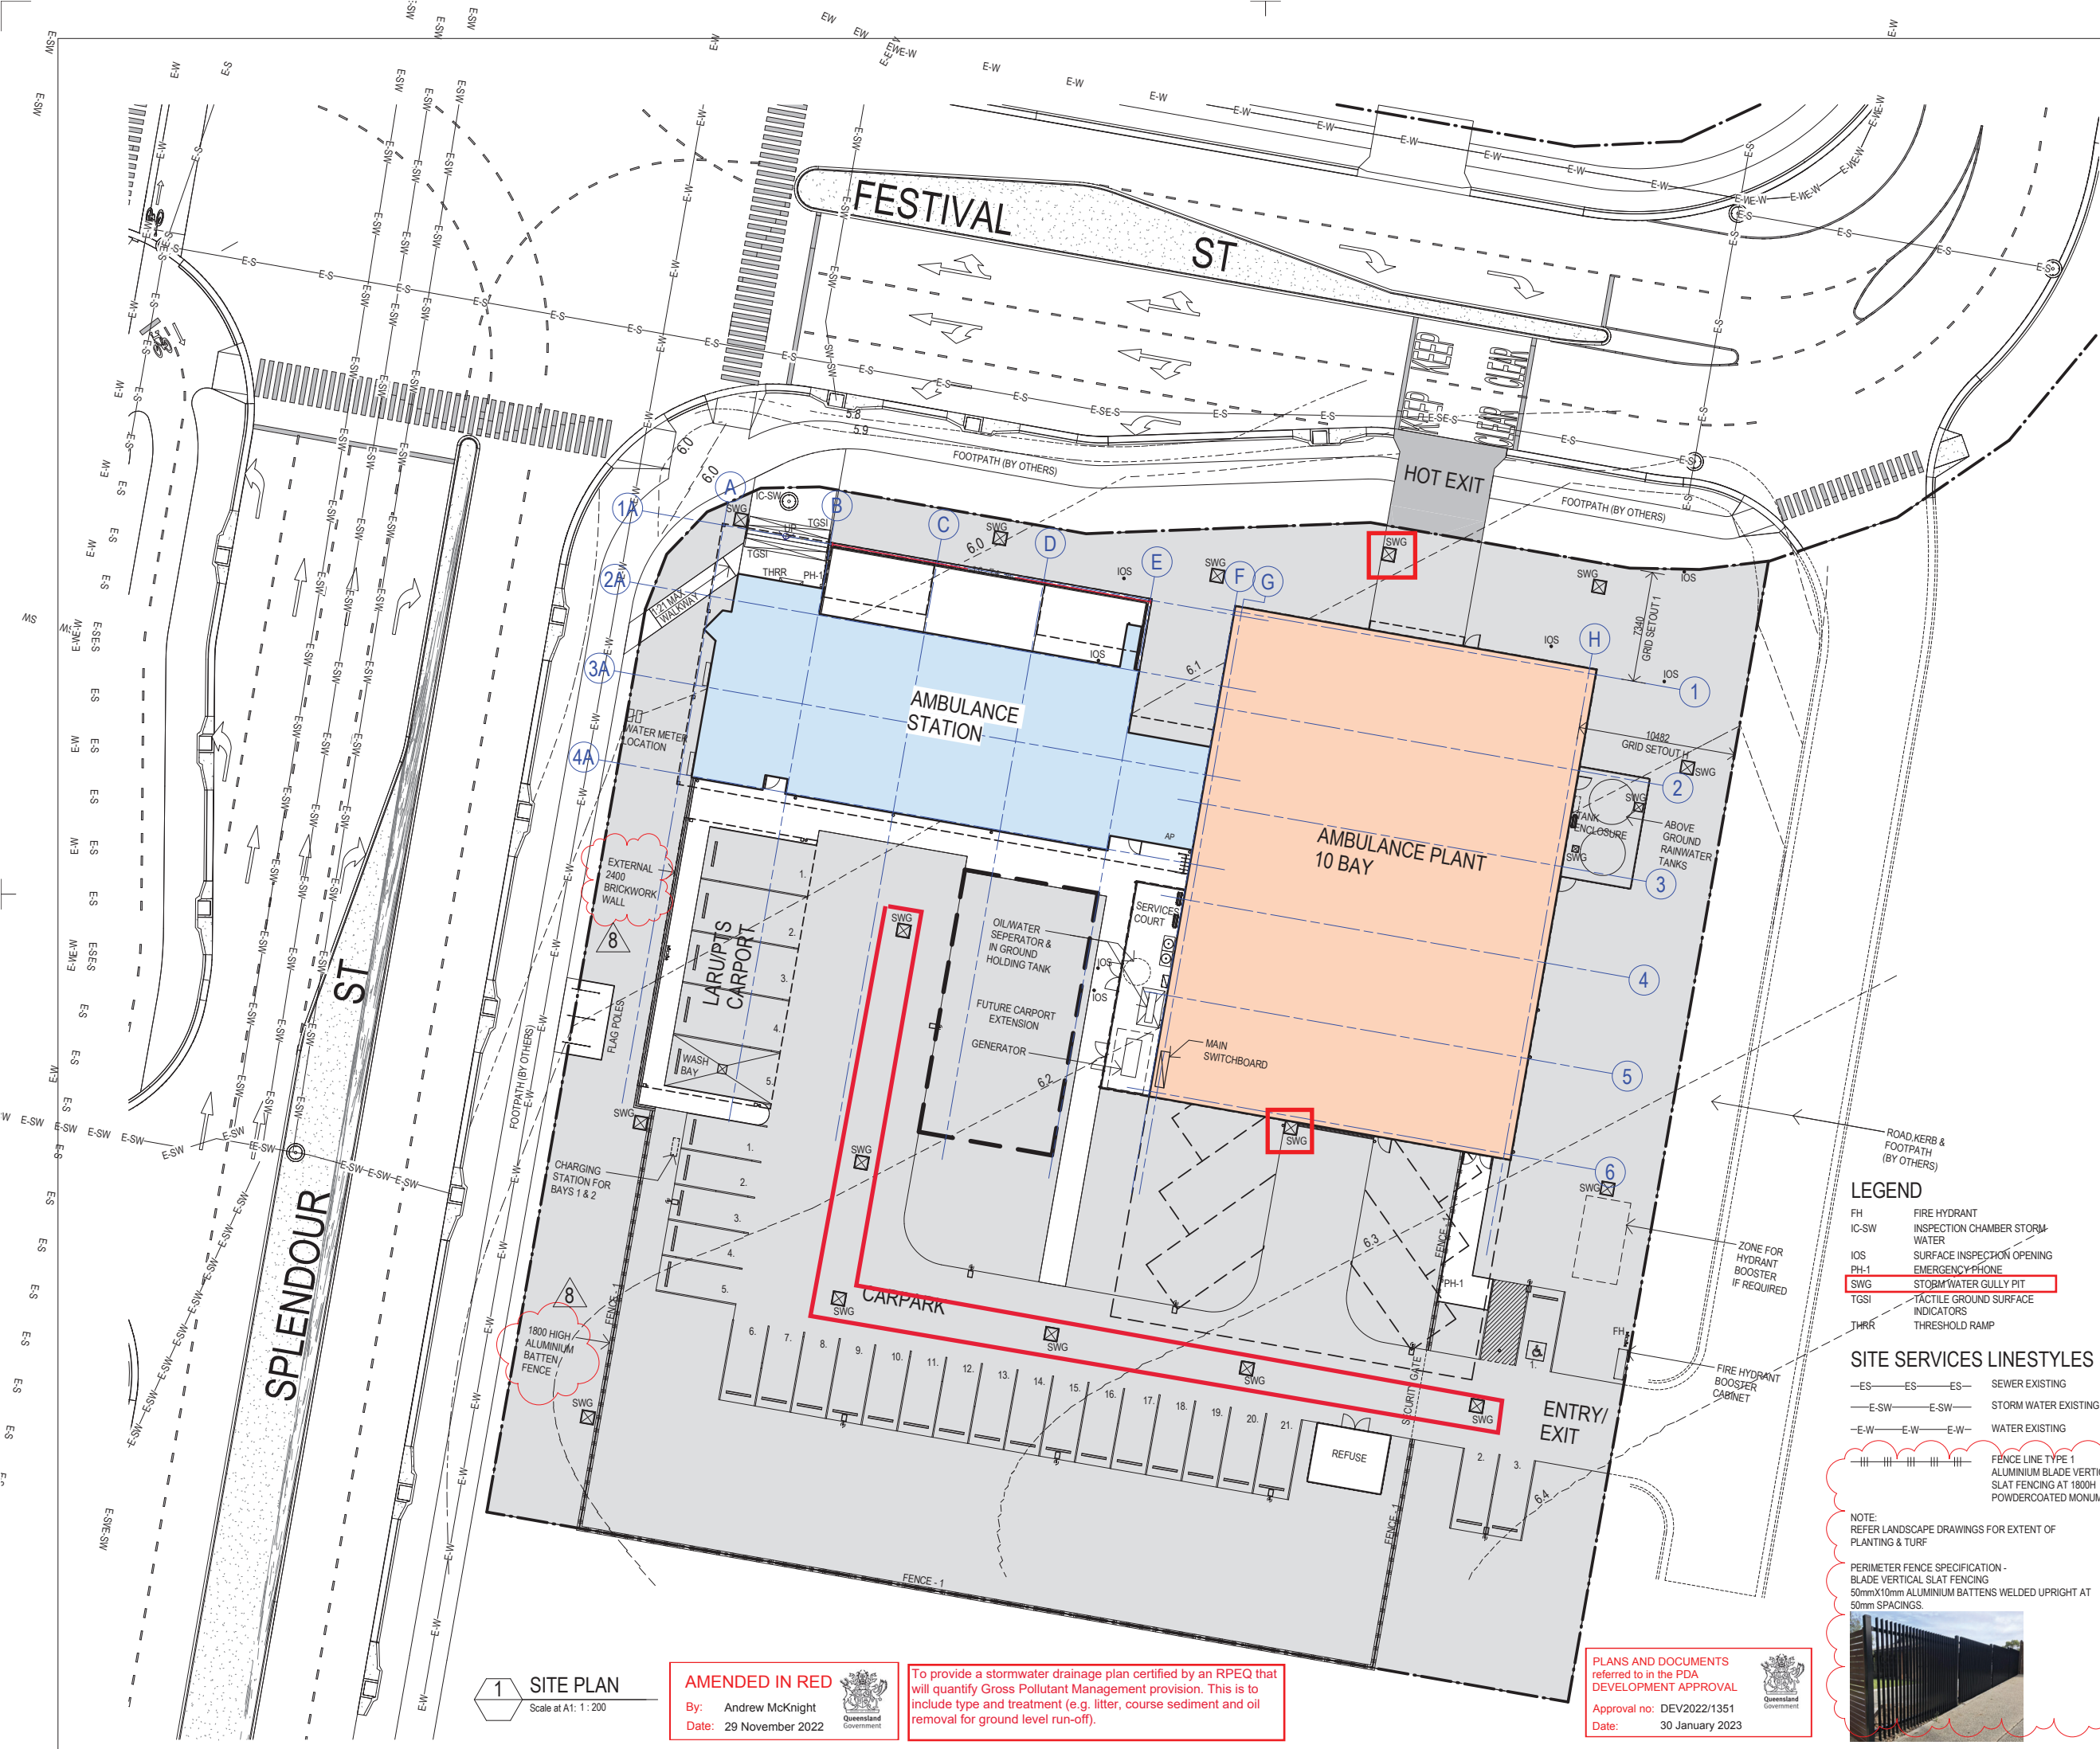

Barcode

PHILLIPS
SMITH
CONWELL

46 Berwick Street
PO Box 479 Fortitude Valley
Queensland 4006 Australia
T +617 3257 1167
pscarch@psc-architects.com.au

Verify all dimensions & check levels on site before commencing work. Do not scale from the drawing. The drawing is copyright & remains the property of the architect & shall not be reproduced or copied in any form or by any means without the written permission of the architect.

AMD	SUBJECT	INT	DATE
1	PRELIMINARY ISSUE	IB/IR	08.03.22
2	PRELIMINARY ISSUE	IB/IR	16.03.22
3	PRELIMINARY ISSUE	IB/IR	29.03.22
4	PRELIMINARY ISSUE	IB/IR	08.04.22
5	PRELIMINARY ISSUE	IB/IR	22.06.22
6	CONSULTANT ISSUE	IB/IR	12.07.22
7	REVIEW ISSUE	IB/IR	12.08.22
8	AMENDED FENCE	OT/IR	22.11.22

DRAWING INDEX SYSTEM

Building & Asset Services ePlan Room use only

☐ CEILING PLANS

☐ CONSTRUCTION DETAILS

☐ ELEVATIONS

☐ EXTERNAL WORKS

☐ FITOUTS

☐ FLOOR PLANS

☐ FURNITURE & EQUIPMENT

☐ HYDRAULICS

☐ MASTER PLAN

☐ MISCELLANEOUS DETAILS

☐ OTHER

☐ PLAY STRUCTURES

☐ ROOF PLANS

☐ SECTIONS

☐ SETOUT PLAN

☐ SITE PLAN

☐ STANDARDS

CLIENT



CONTRACTOR

PROJECT MANAGER


Department of Energy and Public Works

DRAWN

DATE

IB

DRAFTING CHECK

DATE

ND

DISCIPLINE DIRECTOR

AUTHORISED FOR ISSUE

DATE

Ian Robinson

DISCIPLINE TEAM LEADER

DATE

Nick Dazeley

STATUS

Preliminary

Caloundra South Ambulance Station

Site Plan



0 2 4 6 8 10 16m

Scale at A1

Scale at A3

As indicated

1:400

Master Site Number

PSC Job Number

5857

Drawing Number

Issue

Sheet No.

A-SD- 10.01

8

AMENDED IN RED

By: Andrew McKnight

Date: 29 November 2022




To provide a stormwater drainage plan certified by an RPEQ that will quantify Gross Pollutant Management provision. This is to include type and treatment (e.g. litter, coarse sediment and oil removal for ground level run-off).

PLANS AND DOCUMENTS referred to in the PDA DEVELOPMENT APPROVAL

Approval no: DEV2022/1351

Date: 30 January 2023



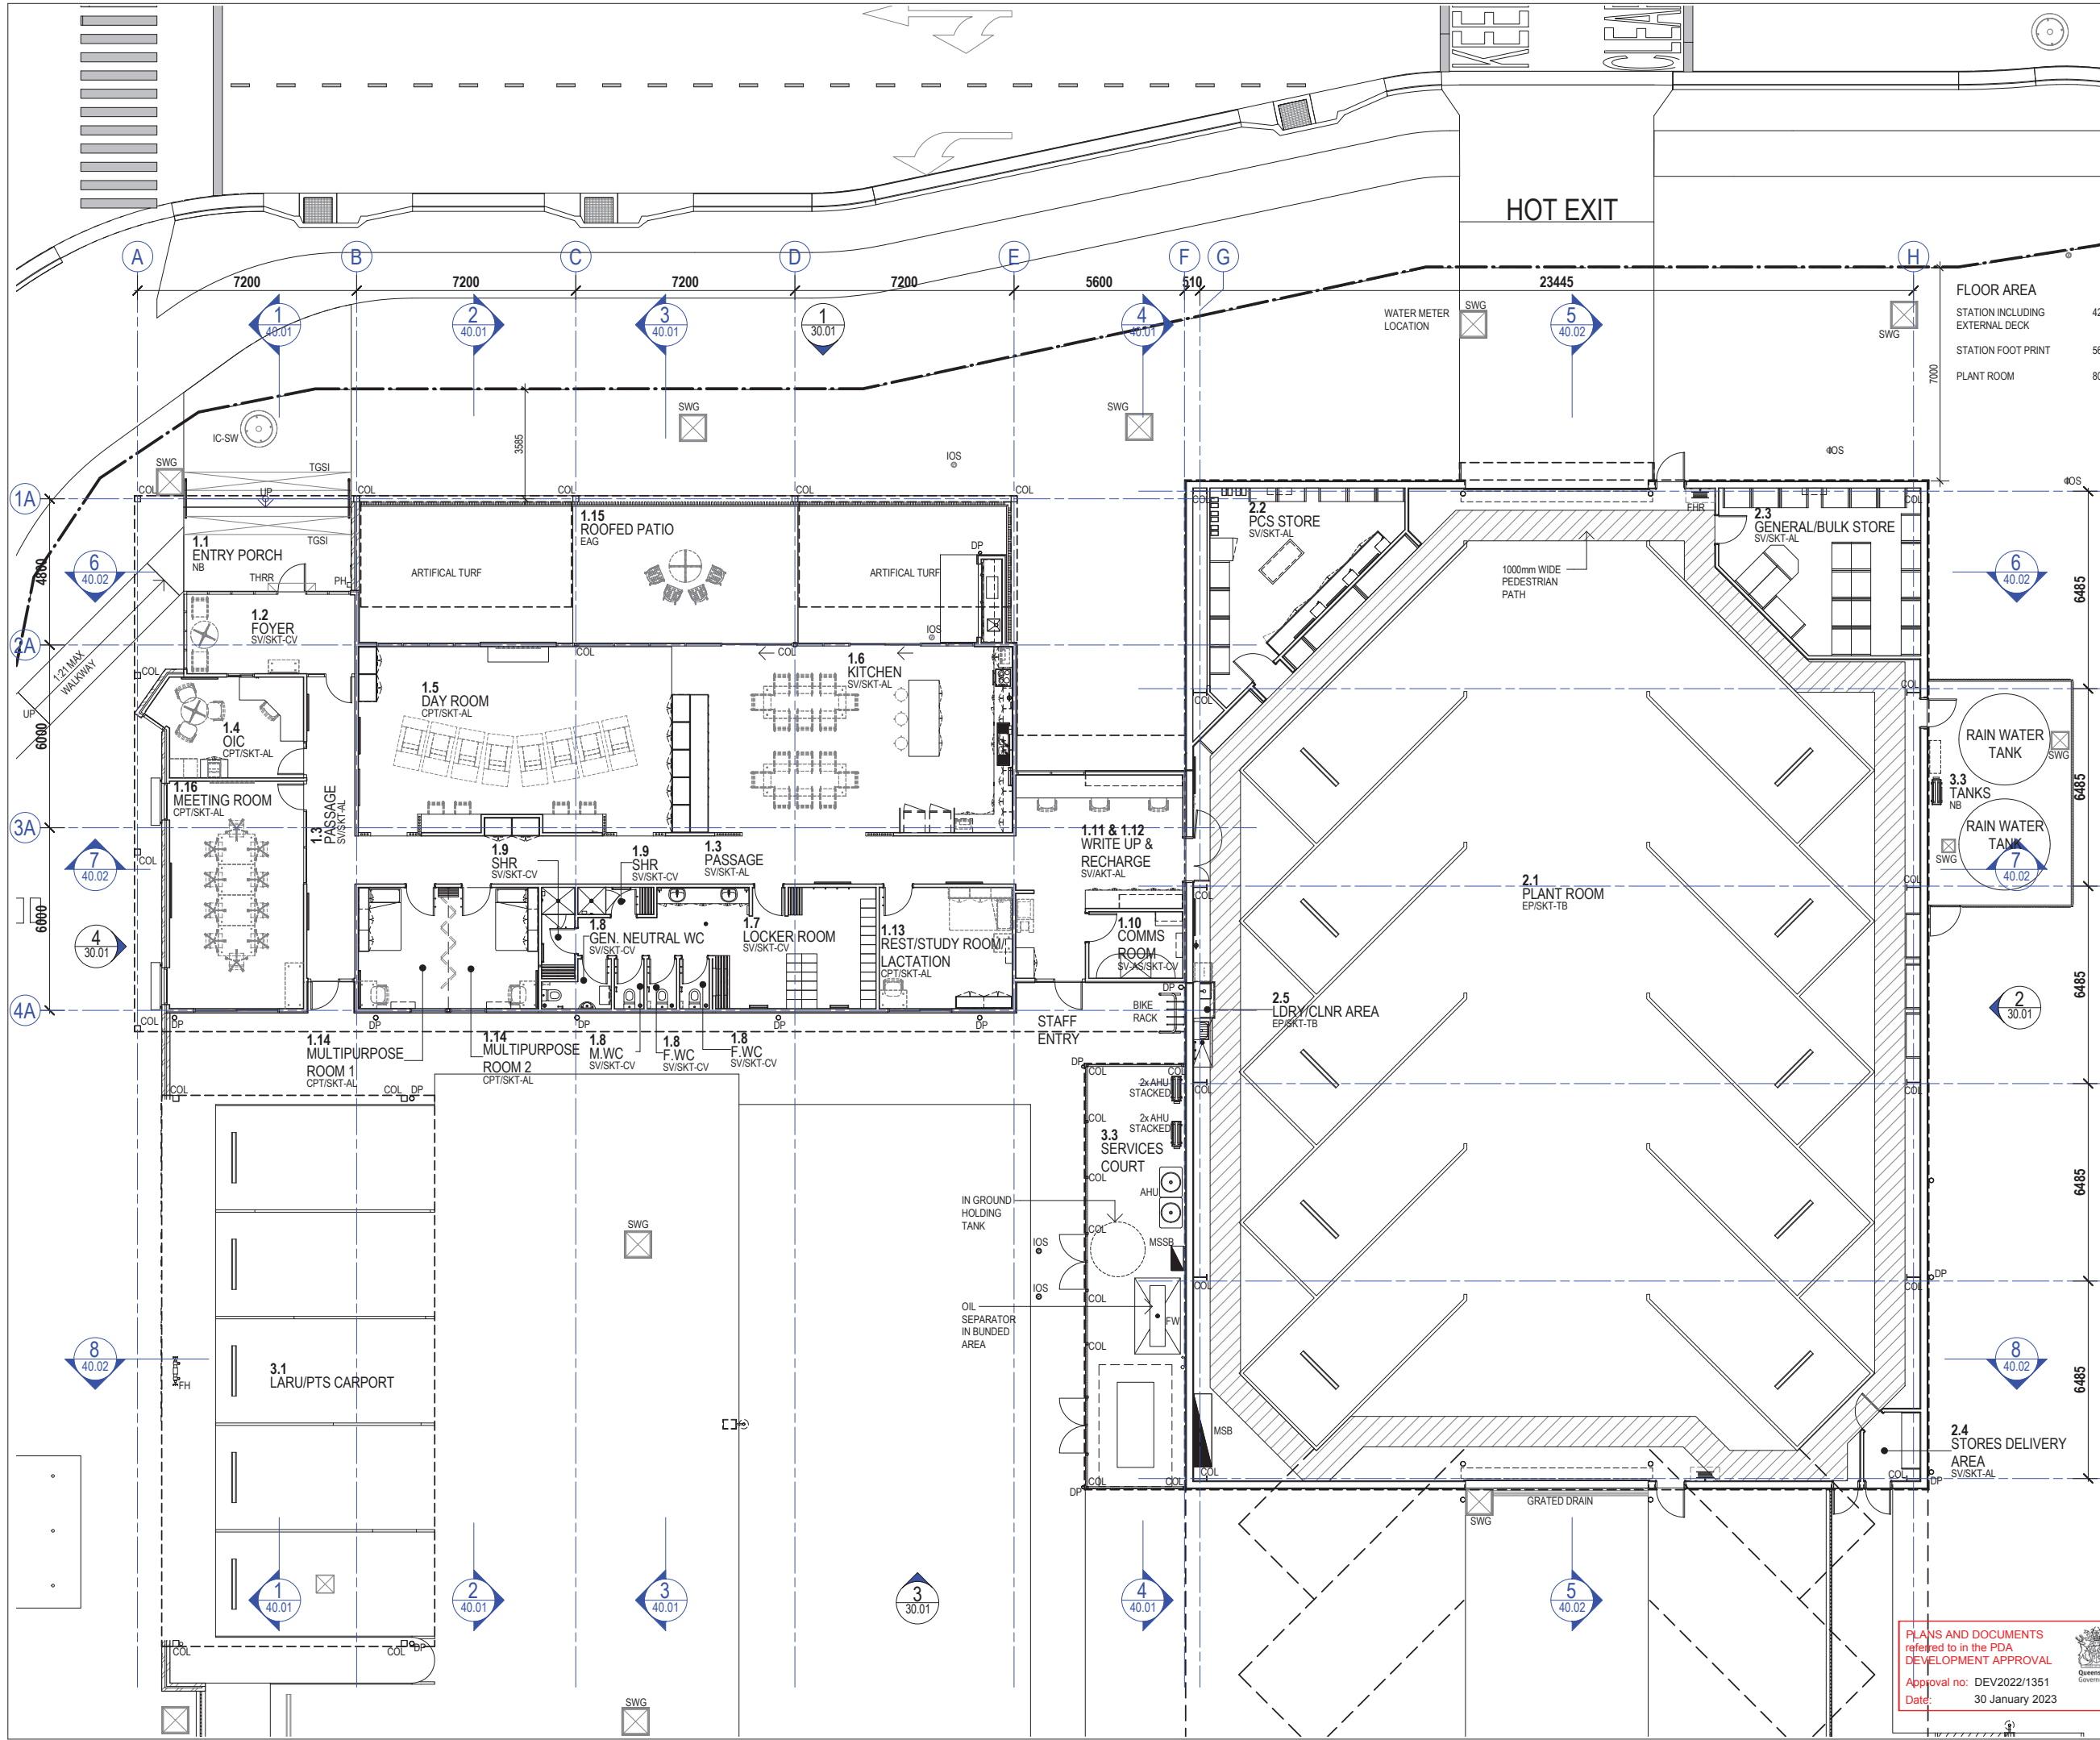

LEGEND

AHU	AIR HANDLING UNIT
COL	STRUCTURAL COLUMN
DP	DOWNSPIPE
FH	FIRE HYDRANT
FHR	FIRE HOSE REEL
FW	FLOOR WASTE
IC-SW	INSPECTION CHAMBER STORM WATER
IOS	SURFACE INSPECTION OPENING
MSB	MAIN SWITCHBOARD
MSSB	MECHANICAL SERVICES SWITCHBOARD
SWG	STORM WATER GULLY PIT
TGSI	TACTILE GROUND SURFACE INDICATORS
THRR	THRESHOLD RAMP

PHILLIPS SMITH CONWELL

46 Berwick Street
PO Box 479 Fortitude Valley
Queensland 4006 Australia
T +617 3257 1167
pscarch@psc-architects.com.au

Verify all dimensions & check levels on site before commencing work. Do not scale from the drawing. The drawing is copyright & remains the property of the architect & shall not be reproduced or copied in any form or by any means without the written permission of the architect.

AMD	SUBJECT	INT	DATE
1	PRELIMINARY ISSUE	IB/IR	08.03.22
2	PRELIMINARY ISSUE	IB/IR	16.03.22
3	PRELIMINARY ISSUE	IB/IR	29.03.22
4	PRELIMINARY ISSUE	IB/IR	08.04.22
5	PRELIMINARY ISSUE	IB/IR	22.06.22
6	CONSULTANT ISSUE	IB/IR	12.07.22
7	REVIEW ISSUE	IB/IR	12.08.22

DRAWING INDEX SYSTEM
Building & Asset Services ePlan Room use only

☐ CEILING PLANS	☐ MISCELLANEOUS DETAILS
☐ CONSTRUCTION DETAILS	☐ OTHER
☐ ELEVATIONS	☐ PLAY STRUCTURES
☐ EXTERNAL WORKS	☐ ROOF PLANS
☐ FITOUTS	☐ SECTIONS
☐ FLOOR PLANS	☐ SETOUT PLAN
☐ FURNITURE & EQUIPMENT	☐ SITE PLAN
☐ HYDRAULICS	☐ STANDARDS
☐ MASTER PLAN	

CLIENT

CONTRACTOR

PROJECT MANAGER

Queensland Government
Department of Energy and Public Works

DRAWN	DATE
IB	
DRAFTING CHECK	DATE
ND	
DISCIPLINE DIRECTOR	DATE
AUTHORISED FOR ISSUE	
Ian Robinson	
DISCIPLINE TEAM LEADER	DATE
Nick Dazeley	

STATUS

Preliminary

Caloundra South Ambulance Station

Floor Plan - Level 0

0 1 2 3 4 5 8m

Scale at A1
1 : 100


Scale at A3
1 : 200

Master Site Number	PSC Job Number
	5857
Drawing Number	Issue
A-SD-23.01	7
	Sheet No.

PLANS AND DOCUMENTS referred to in the PDA DEVELOPMENT APPROVAL

Approval no: DEV2022/1351

Date: 30 January 2023

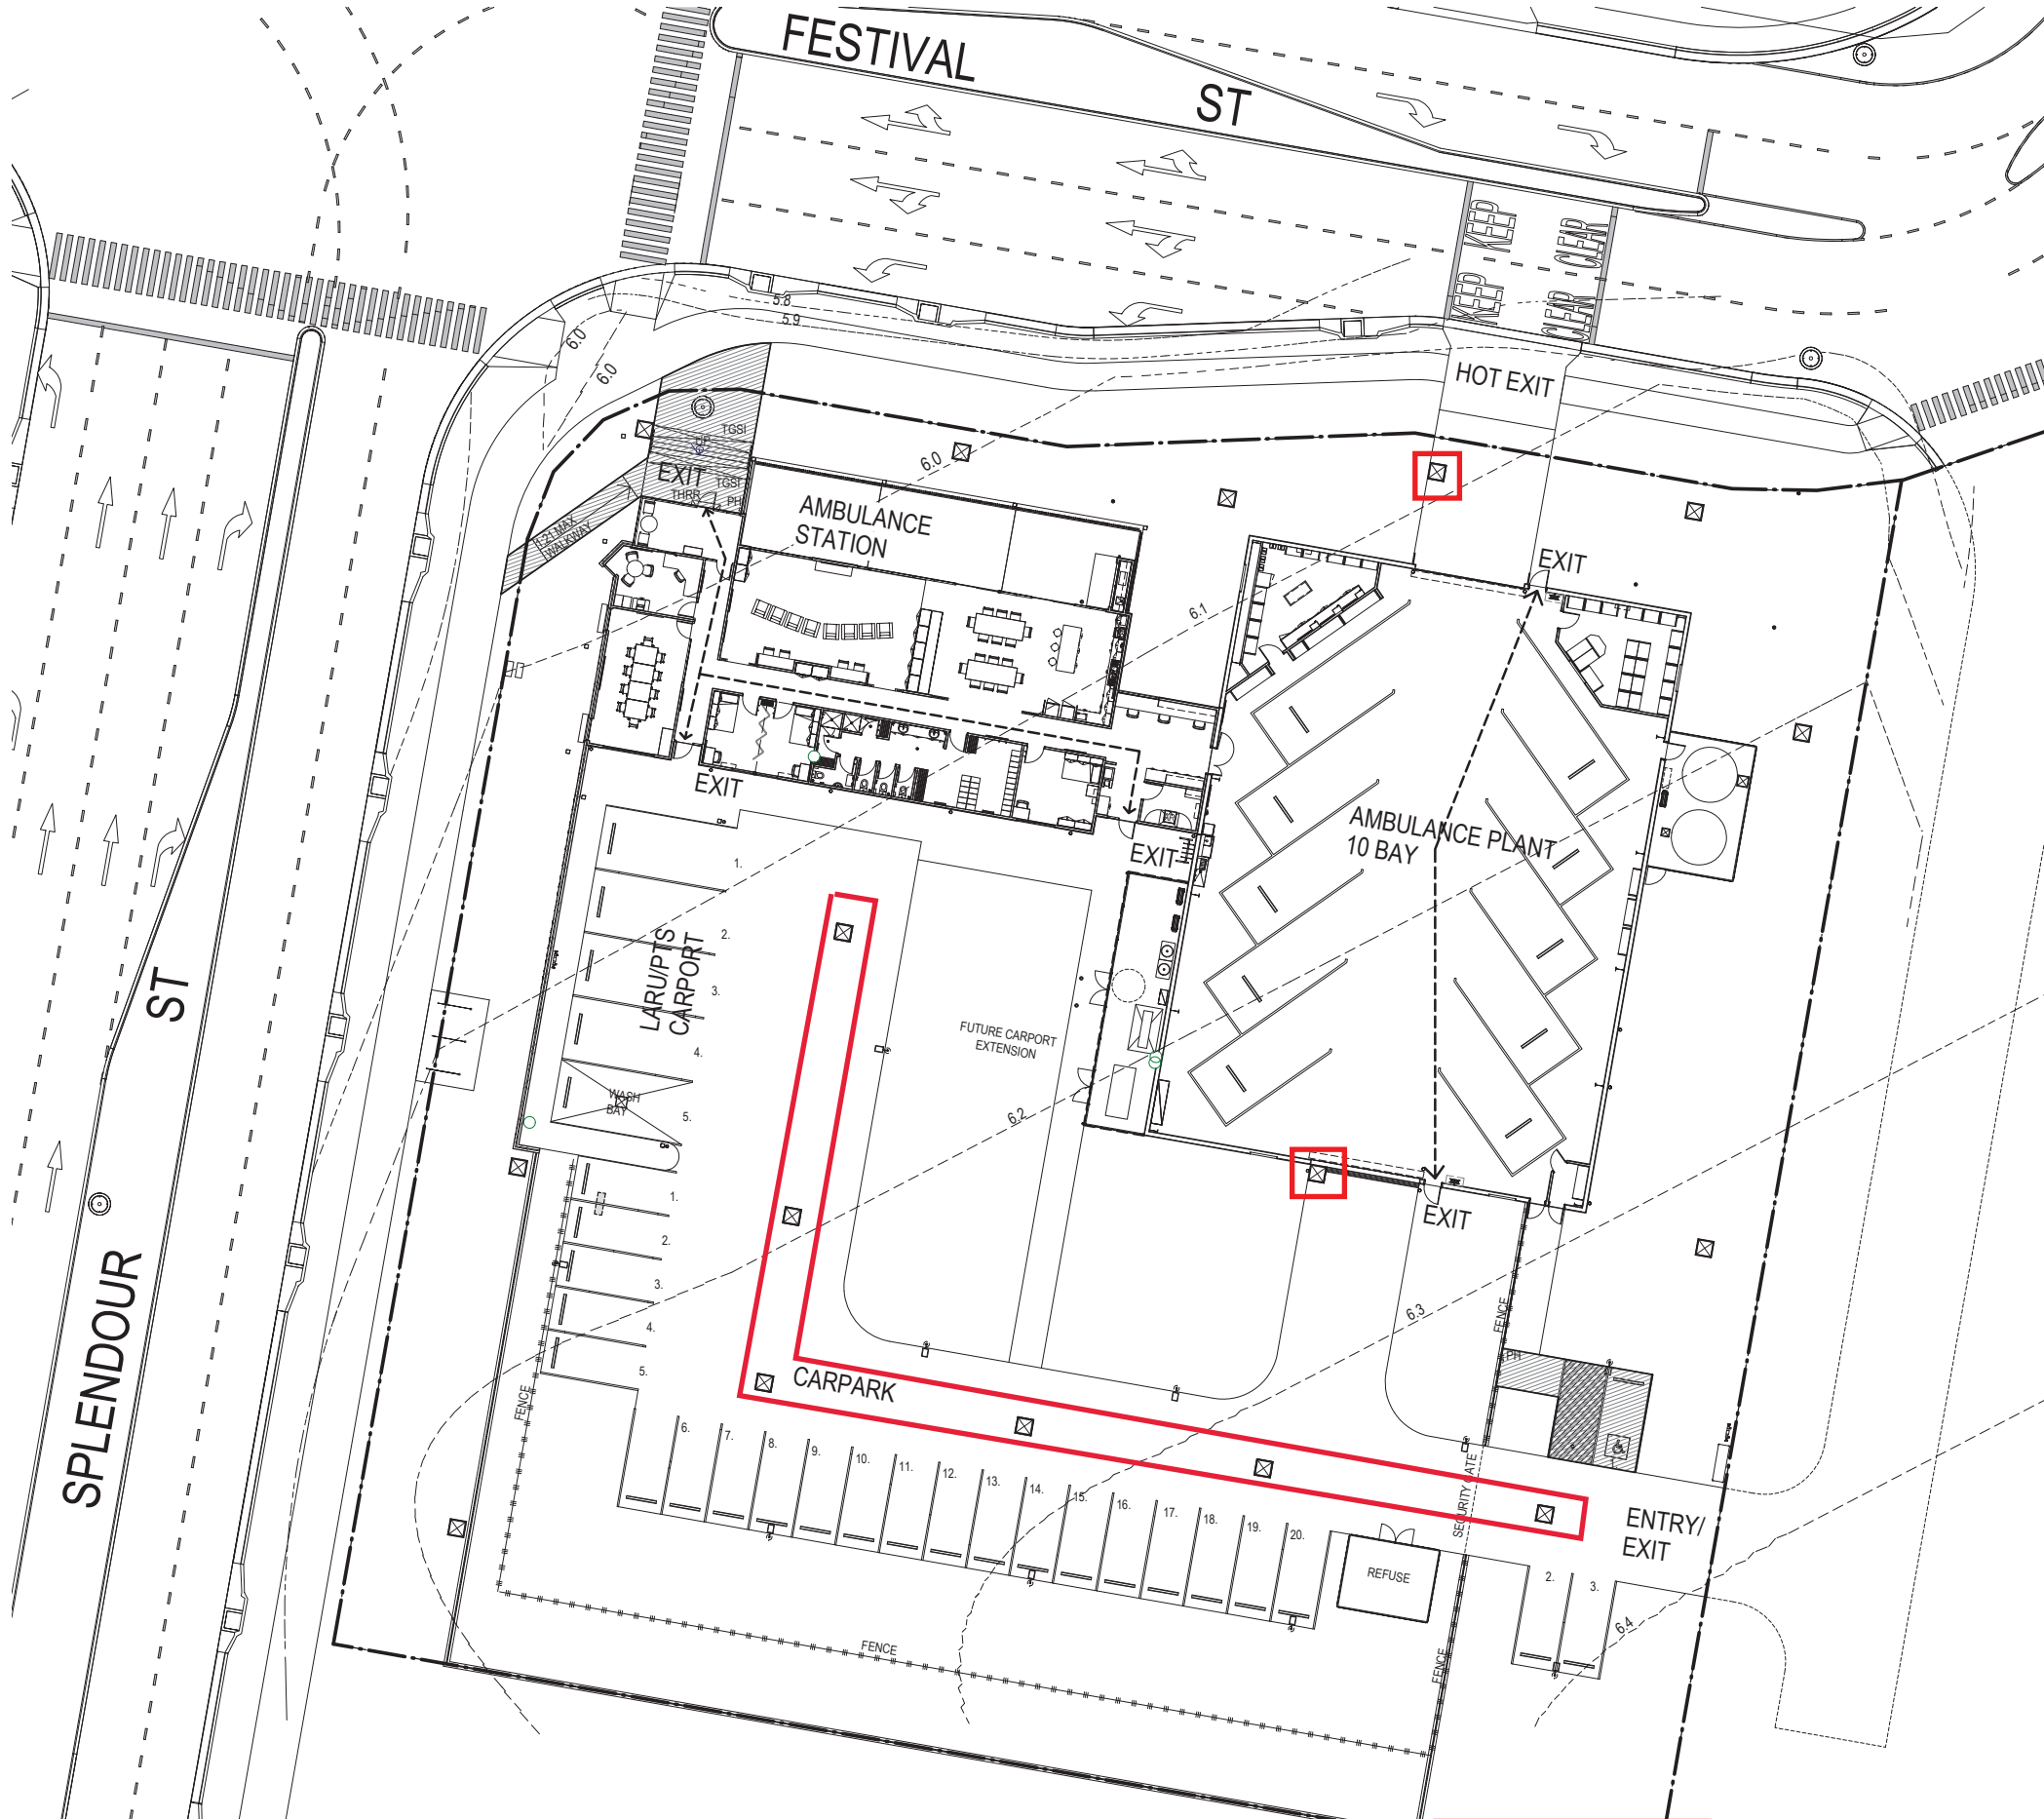

PUBLIC ACCESSIBLE AREA
 PWD COMPLIANCE

PHILLIPS SMITH CONWELL

46 Berwick Street
PO Box 479 Fortitude Valley
Queensland 4006 Australia
T +617 3257 1167
pscarch@psc-architects.com.au

Verify all dimensions & check levels on site before commencing work. Do not scale from the drawing. The drawing is copyright & remains the property of the architect & shall not be reproduced or copied in any form or by any means without the written permission of the architect.

AMD	SUBJECT	INT	DATE
1	REVIEW ISSUE	IB/IR	12.08.22

- DRAWING INDEX SYSTEM**
Building & Asset Services ePlan Room use only
- | | |
|--|--|
| ☐ CEILING PLANS | ☐ MISCELLANEOUS DETAILS |
| ☐ CONSTRUCTION DETAILS | ☐ OTHER |
| ☐ ELEVATIONS | ☐ PLAY STRUCTURES |
| ☐ EXTERNAL WORKS | ☐ ROOF PLANS |
| ☐ FITOUTS | ☐ SECTIONS |
| ☐ FLOOR PLANS | ☐ SETOUT PLAN |
| ☐ FURNITURE & EQUIPMENT | ☐ SITE PLAN |
| ☐ HYDRAULICS | ☐ STANDARDS |
| ☐ MASTER PLAN | |

CLIENT

CONTRACTOR

PROJECT MANAGER

Department of Energy and Public Works

DRAWN	DATE
Author	
DRAFTING CHECK	DATE
Checker	
DISCIPLINE DIRECTOR AUTHORISED FOR ISSUE	DATE
Ian Robinson	07/07/22
DISCIPLINE TEAM LEADER	DATE
Nick Dazeley	07/07/22

STATUS
Preliminary

Caloundra South Ambulance Station

BCA Floor Plan

Scale at A1: 1:200
Scale at A3: 1:400

Master Site Number	PSC Job Number	
	5857	
Drawing Number	Issue	Sheet No.
A-SD-23.02	1	

1 BCA Floor Plan
Scale at A1: 1:200

AMENDED IN RED
By: Andrew McKnight
Date: 29 November 2022

To provide a stormwater drainage plan certified by an RPEQ that will quantify Gross Pollutant Management provision. This is to include type and treatment (e.g. litter, coarse sediment and oil removal for ground level run-off).

PLANS AND DOCUMENTS referred to in the PDA DEVELOPMENT APPROVAL
Approval no: DEV2022/1351
Date: 30 January 2023

- LEGEND
- AF APRON FLASHING
 - BC BARGE CAPPING
 - DP DOWNPIPE
 - EG EAVES GUTTER
 - MF-P METAL FLASHING - PAN
 - MRP MECHANICAL ROOF PENETRATION
 - MRS METAL ROOF SHEETING
 - PRC PARAPET CAPPING
 - VP VENT PIPE

Barcode

**PHILLIPS
SMITH
CONWELL**

46 Berwick Street
PO Box 479 Fortitude Valley
Queensland 4006 Australia
T +617 3257 1167
pscarch@psc-architects.com.au

Verify all dimensions & check levels on site before commencing work. Do not scale from the drawing. The drawing is copyright & remains the property of the architect & shall not be reproduced or copied in any form or by any means without the written permission of the architect.

AMD	SUBJECT	INT	DATE
1	CONSULTANT ISSUE	IB/IR	12.07.22
2	REVIEW ISSUE	IB/IR	12.08.22

DRAWING INDEX SYSTEM
Building & Asset Services ePlan Room use only

☐ CEILING PLANS	☐ MISCELLANEOUS DETAILS
☐ CONSTRUCTION DETAILS	☐ OTHER
☐ ELEVATIONS	☐ PLAY STRUCTURES
☐ EXTERNAL WORKS	☐ ROOF PLANS
☐ FITOUTS	☐ SECTIONS
☐ FLOOR PLANS	☐ SETOUT PLAN
☐ FURNITURE & EQUIPMENT	☐ SITE PLAN
☐ HYDRAULICS	☐ STANDARDS
☐ MASTER PLAN	

CLIENT



CONTRACTOR

PROJECT MANAGER



**Queensland
Government**

Department of
Energy and Public Works

DRAWN

DATE

DRAFTING CHECK

DATE

DISCIPLINE DIRECTOR
AUTHORISED FOR ISSUE

DATE

Ian Robinson

DISCIPLINE TEAM LEADER

DATE

Nick Dazeley

STATUS

Preliminary

Caloundra South Ambulance Station

Roof Plan



0 1 2 3 4 5 8m

Scale at A1

1 : 100

Scale at A3

1 : 200

Master Site Number

5857


Drawing Number


A-SD-24.01

Issue


2

Sheet No.

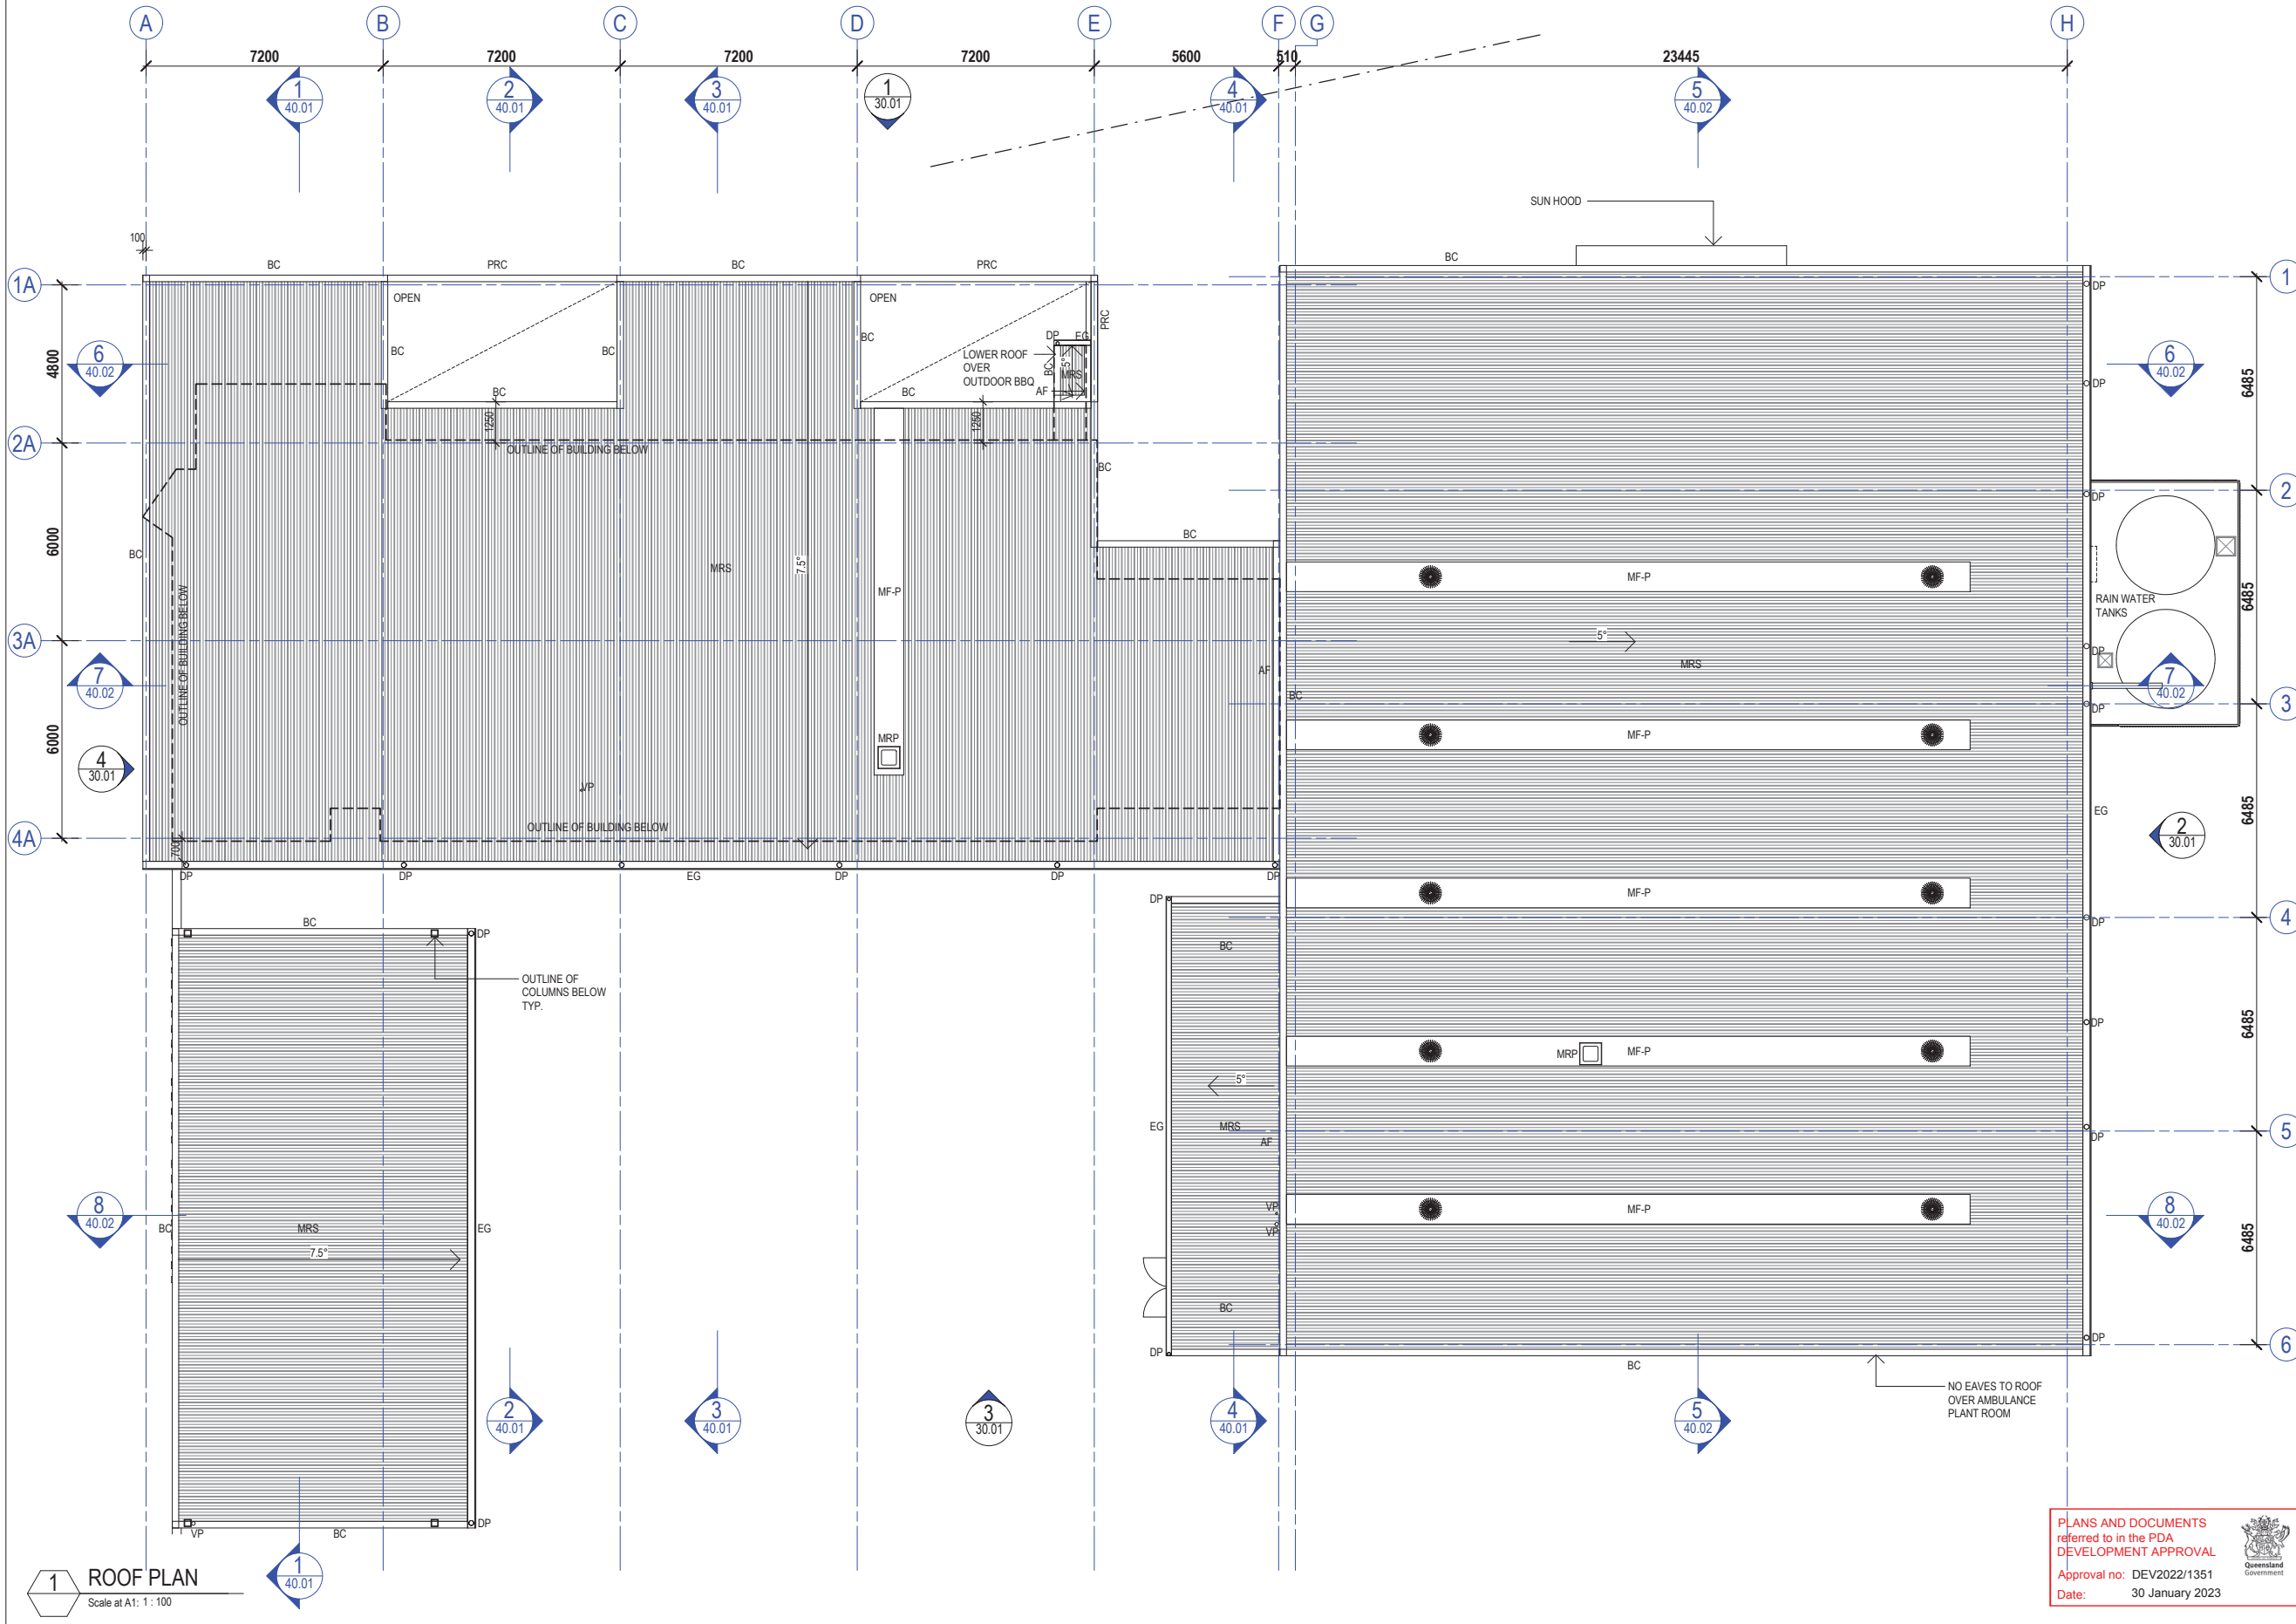


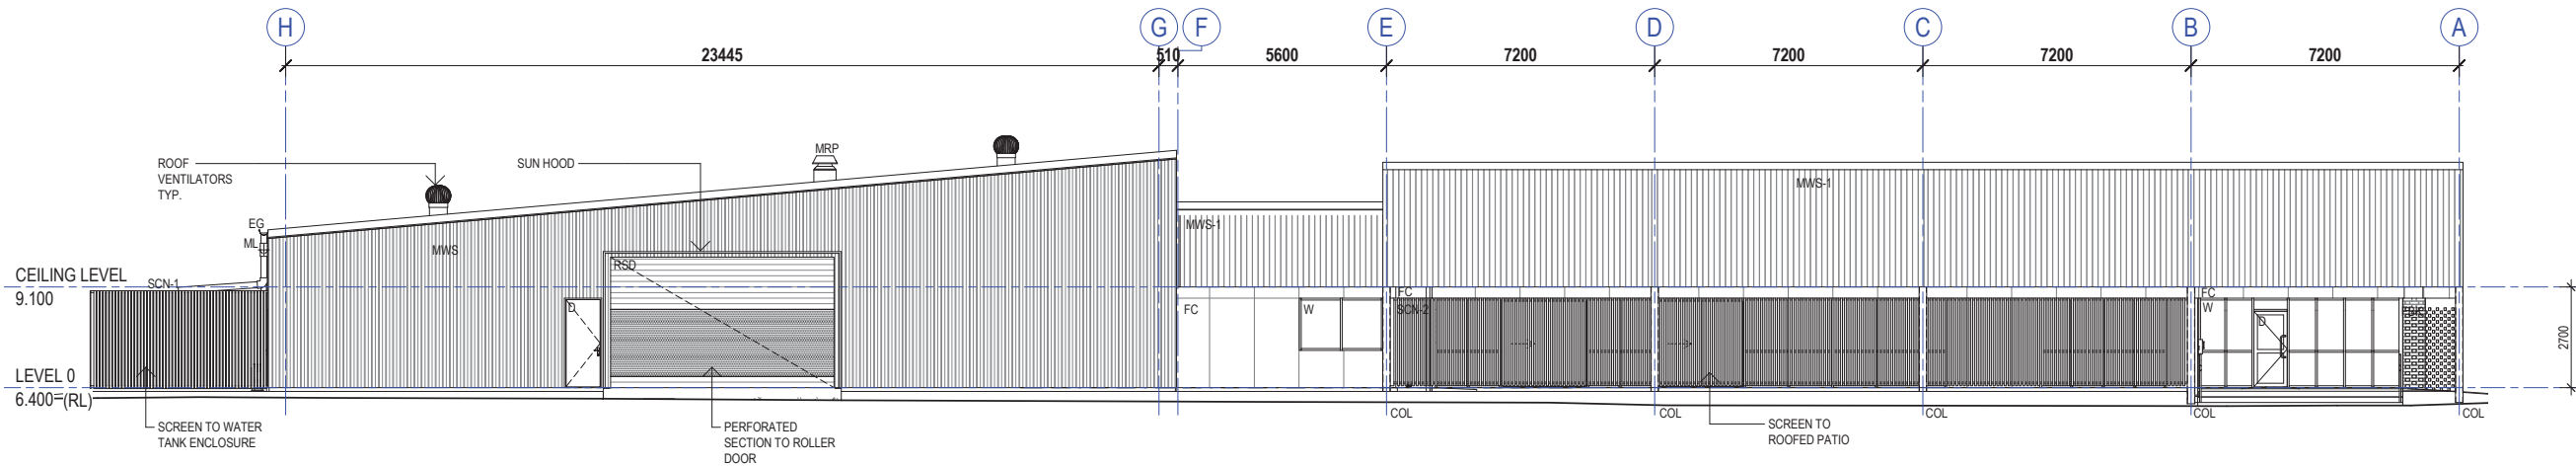


1 NORTH ELEVATION
23.01 Scale at A1: 1 : 100

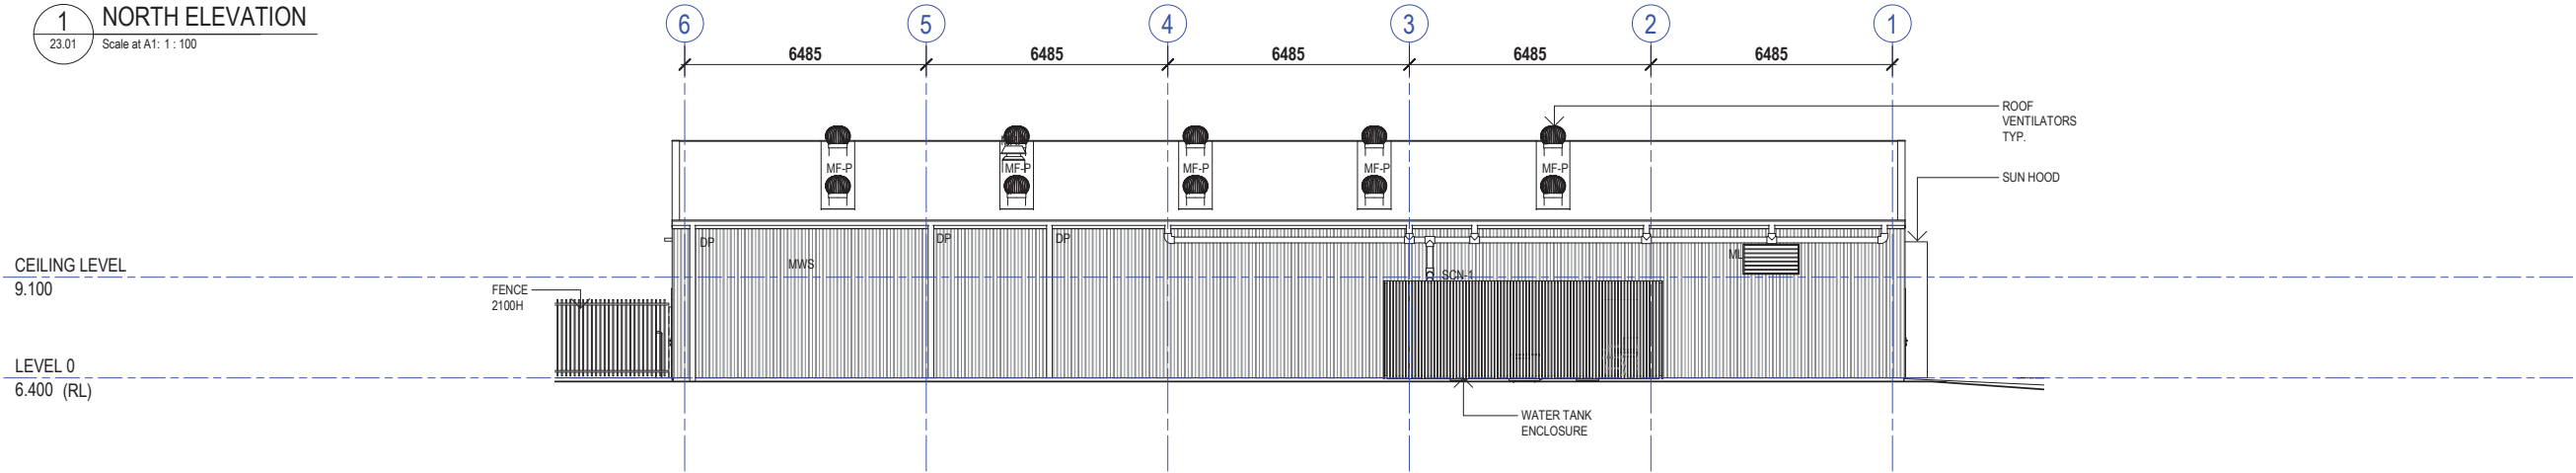

2 EAST ELEVATION
23.01 Scale at A1: 1 : 100

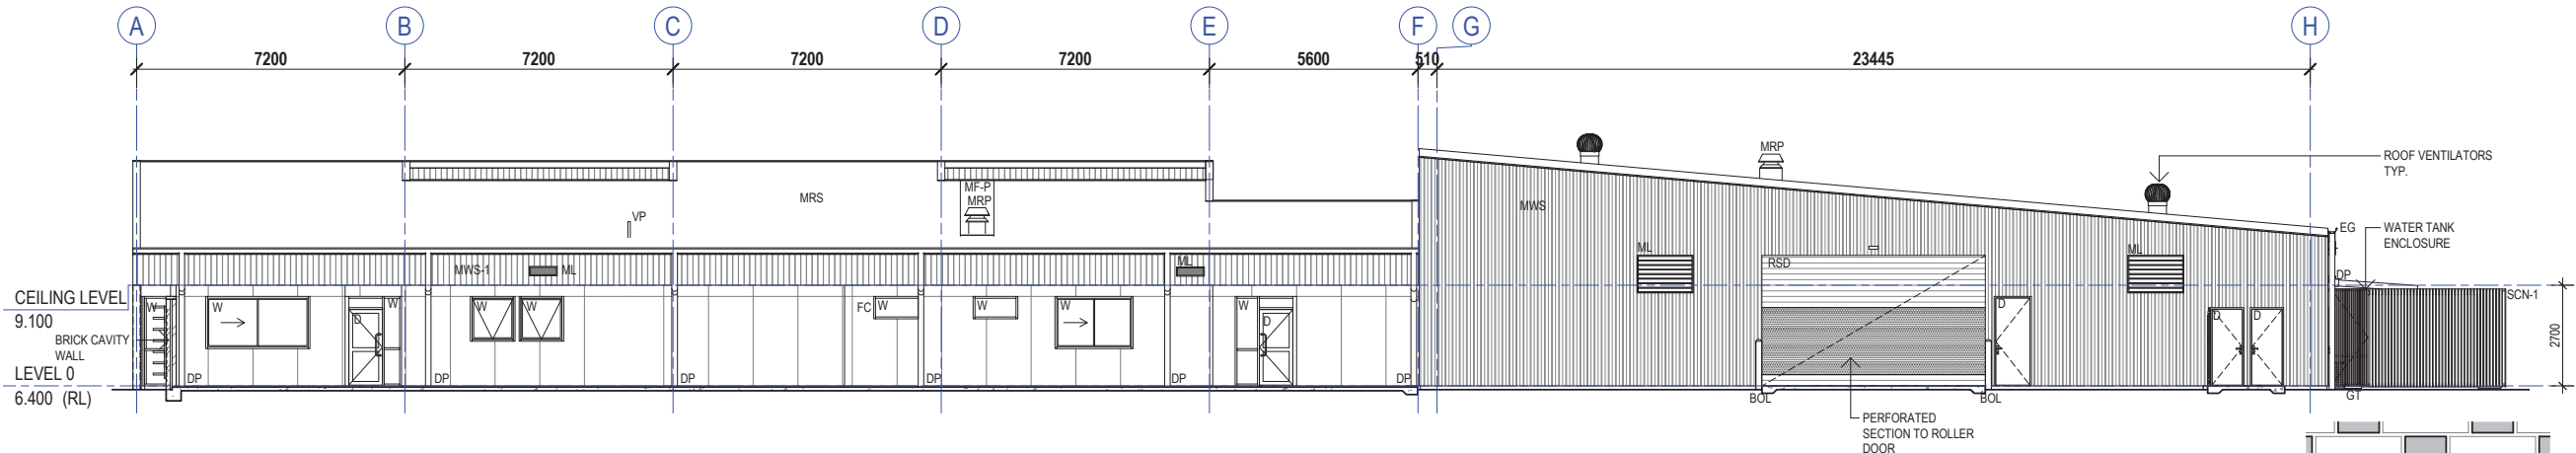


3 SOUTH ELEVATION
23.01 Scale at A1: 1 : 100

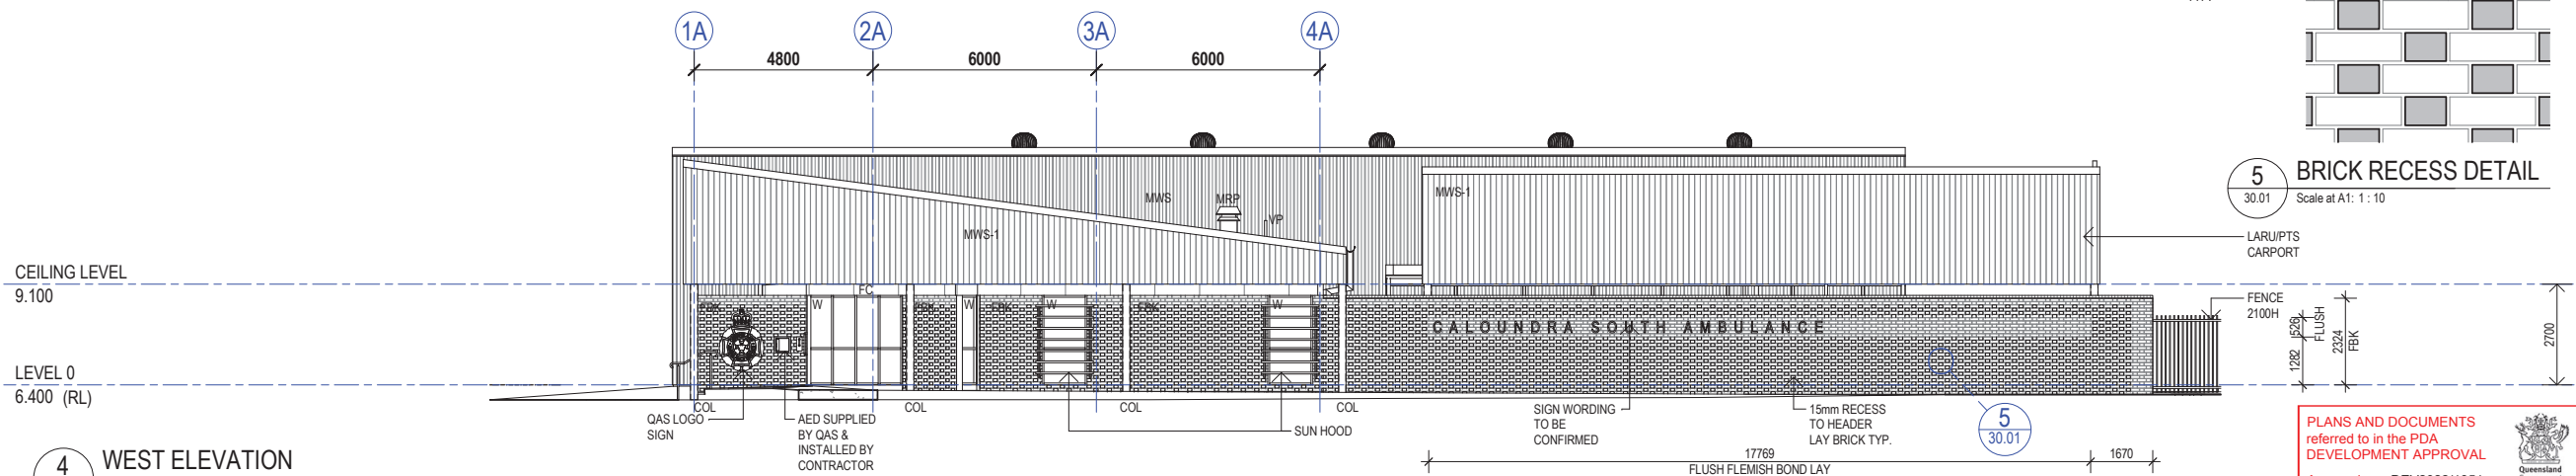

4 WEST ELEVATION
23.01 Scale at A1: 1 : 100

5 BRICK RECESS DETAIL
30.01 Scale at A1: 1 : 10

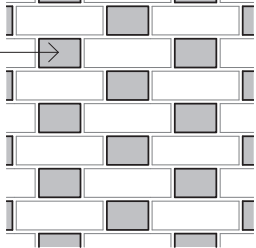

Barcode

PHILLIPS
SMITH
CONWELL

46 Berwick Street
PO Box 479 Fortitude Valley
Queensland 4006 Australia
T +617 3257 1167
pscarch@psc-architects.com.au

Verify all dimensions & check levels on site before commencing work. Do not scale from the drawing. The drawing is copyright & remains the property of the architect & shall not be reproduced or copied in any form or by any means without the written permission of the architect.

AMD	SUBJECT	INT	DATE
1	REVIEW ISSUE	IB/IR	12.08.22

DRAWING INDEX SYSTEM

Building & Asset Services ePlan Room use only

☐ CEILING PLANS
☐ CONSTRUCTION DETAILS
☐ ELEVATIONS
☐ EXTERNAL WORKS
☐ FITOUTS
☐ FLOOR PLANS
☐ FURNITURE & EQUIPMENT
☐ HYDRAULICS
☐ MASTER PLAN

☐ MISCELLANEOUS DETAILS
☐ OTHER
☐ PLAY STRUCTURES
☐ ROOF PLANS
☐ SECTIONS
☐ SETOUT PLAN
☐ SITE PLAN
☐ STANDARDS

CLIENT

CONTRACTOR

PROJECT MANAGER

Department of
Energy and Public Works

DRAWN	DATE
DRAFTING CHECK	DATE
DISCIPLINE DIRECTOR AUTHORISED FOR ISSUE	DATE
Ian Robinson DISCIPLINE TEAM LEADER	DATE

Nick Dazeley

STATUS

Preliminary

Caloundra South Ambulance Station

Building Elevations

0 1 2 3 4 5 8m

Scale at A1

Scale at A3

As indicated


1:200

Master Site Number	PSC Job Number
	5857
Drawing Number	Issue
A-SD-30.01	1
Sheet No.	


PLANS AND DOCUMENTS referred to in the PDA DEVELOPMENT APPROVAL

Approval no: DEV2022/1351


Date: 30 January 2023

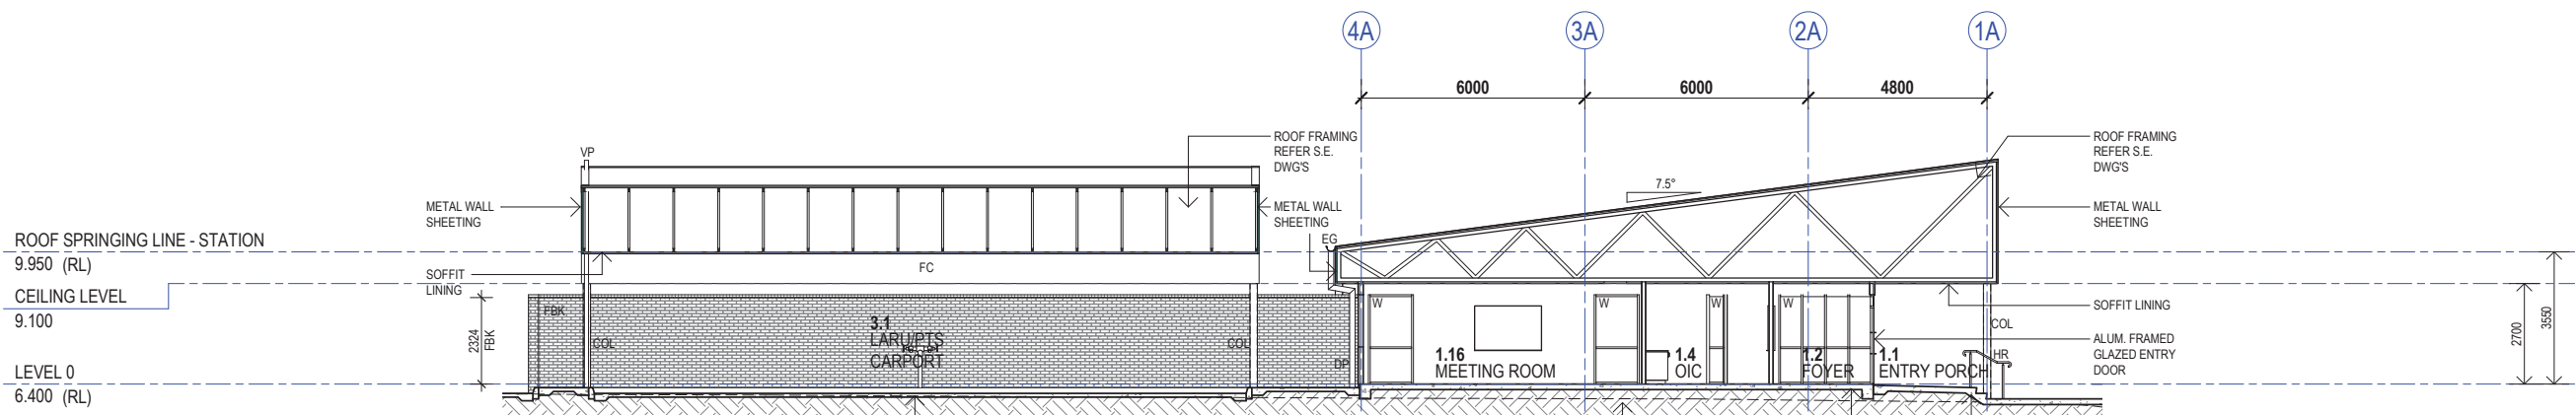


1 SECTION 1
20.01 Scale at A1: 1 : 100

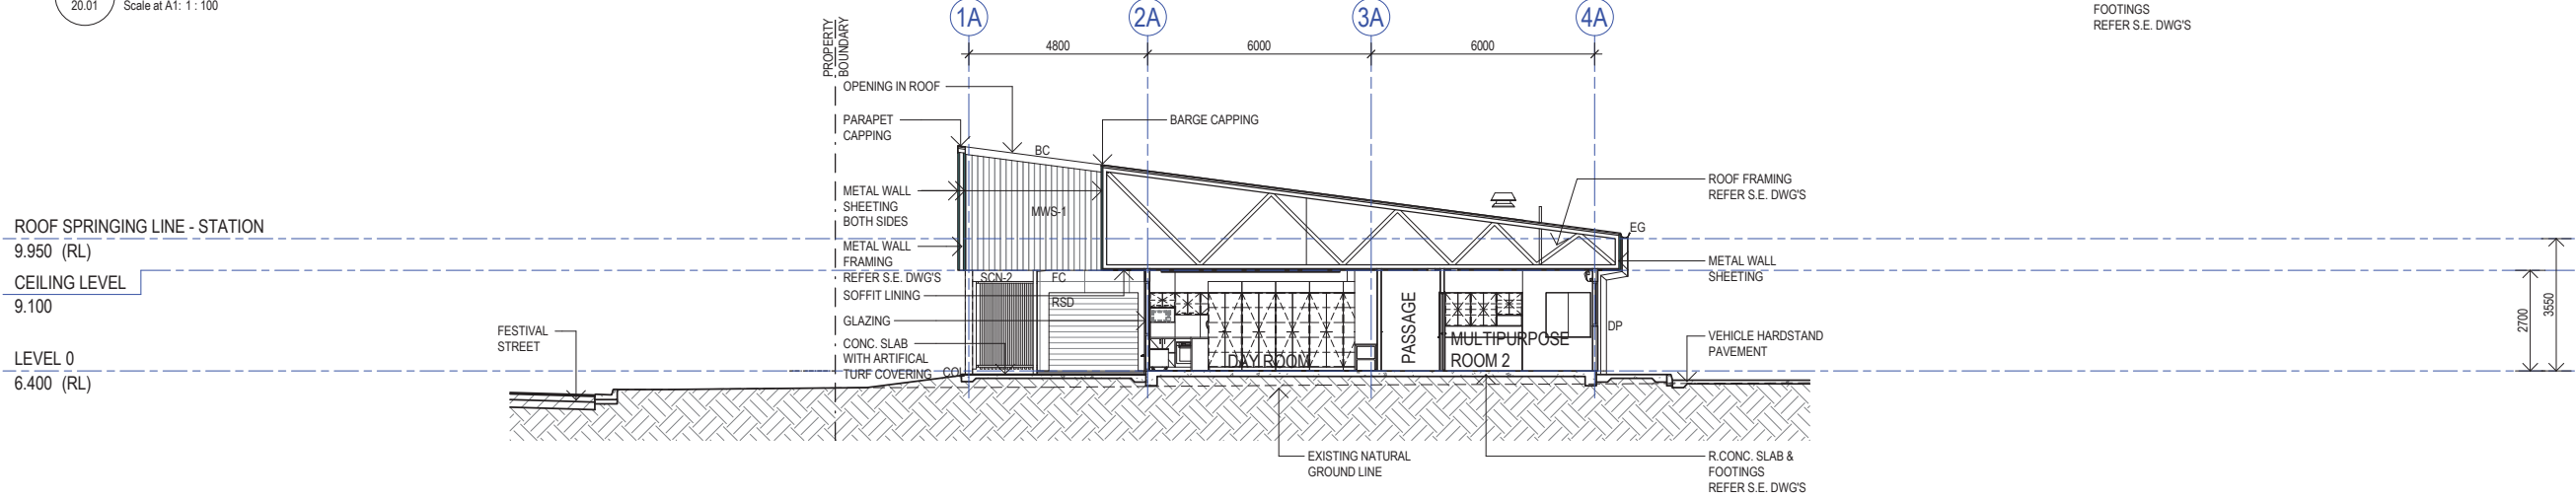

2 SECTION 2
20.01 Scale at A1: 1 : 100

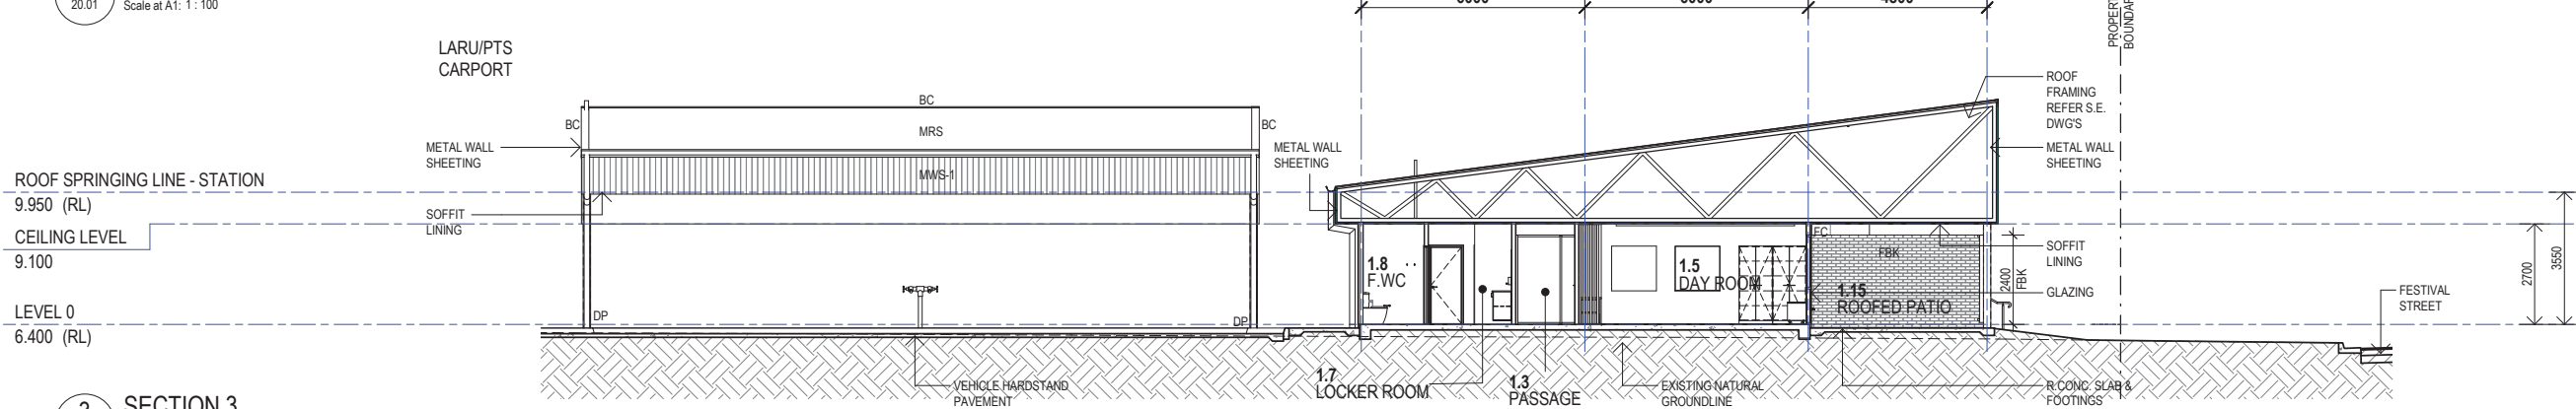

3 SECTION 3
20.01 Scale at A1: 1 : 100

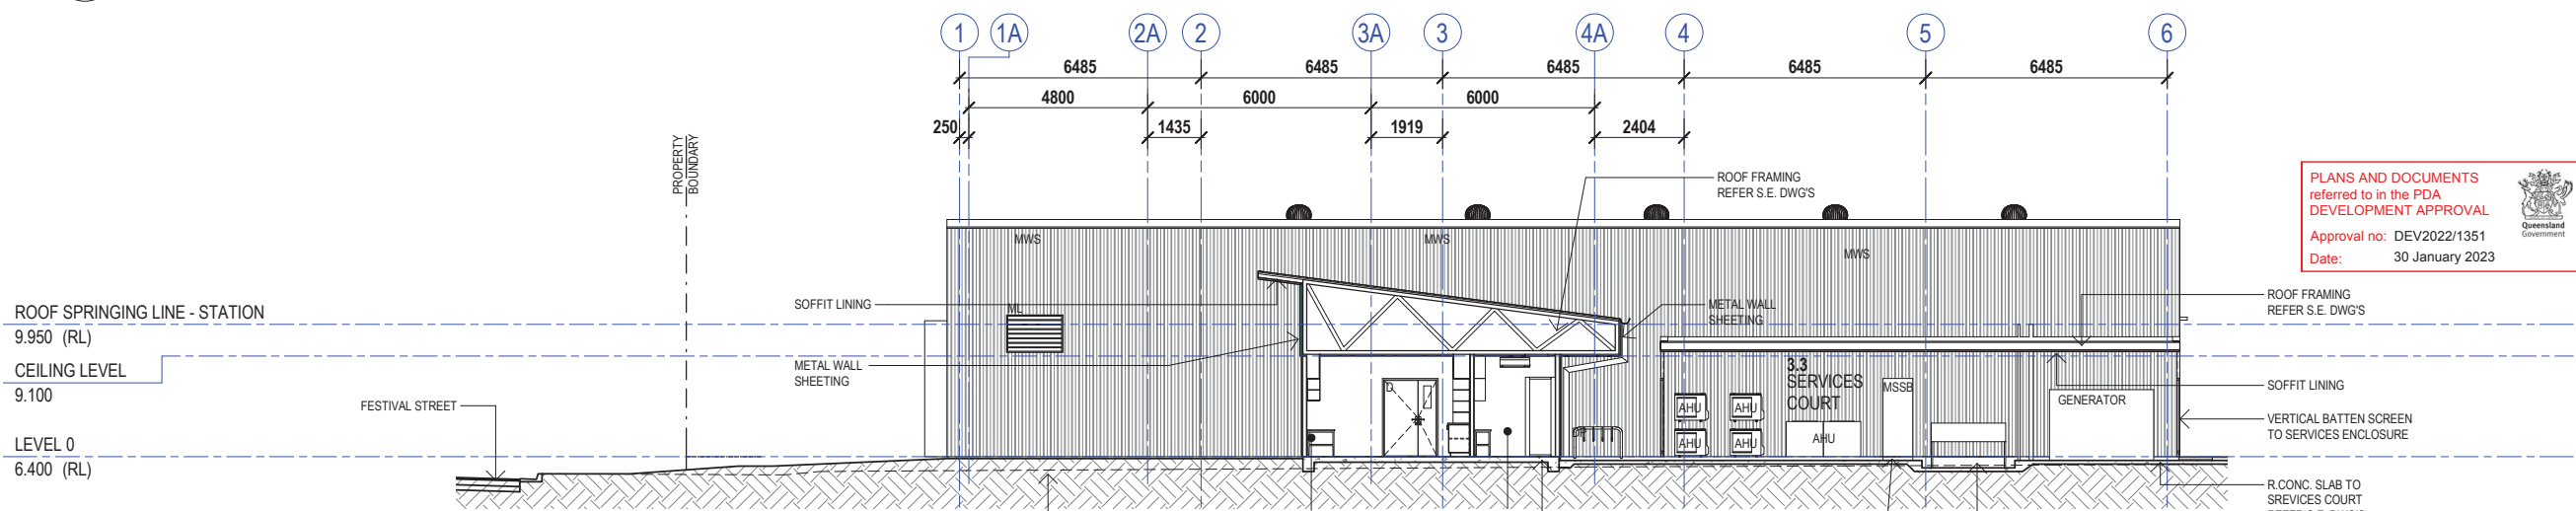

4 SECTION 4
20.01 Scale at A1: 1 : 100

Barcode

**PHILLIPS
SMITH
CONWELL**

46 Berwick Street
PO Box 479 Fortitude Valley
Queensland 4006 Australia
T +617 3257 1167
pscarch@psc-architects.com.au

Verify all dimensions & check levels on site before commencing work. Do not scale from the drawing. The drawing is copyright & remains the property of the architect & shall not be reproduced or copied in any form or by any means without the written permission of the architect.

AMD	SUBJECT	INT	DATE
1	PRELIMINARY ISSUE	IB/IR	08.03.22
2	PRELIMINARY ISSUE	IB/IR	16.03.22
3	PRELIMINARY ISSUE	IB/IR	29.03.22
4	PRELIMINARY ISSUE	IB/IR	08.04.22
5	PRELIMINARY ISSUE	IB/IR	22.06.22
6	REVIEW ISSUE	IB/IR	12.08.22

DRAWING INDEX SYSTEM
Building & Asset Services ePlan Room use only

☐ CEILING PLANS	☐ MISCELLANEOUS DETAILS
☐ CONSTRUCTION DETAILS	☐ OTHER
☐ ELEVATIONS	☐ PLAY STRUCTURES
☐ EXTERNAL WORKS	☐ ROOF PLANS
☐ FITOUTS	☐ SECTIONS
☐ FLOOR PLANS	☐ SETOUT PLAN
☐ FURNITURE & EQUIPMENT	☐ SITE PLAN
☐ HYDRAULICS	☐ STANDARDS
☐ MASTER PLAN	

CLIENT

Queensland Ambulance Service

CONTRACTOR

PROJECT MANAGER

Queensland Government
Department of Energy and Public Works

DRAWN **DATE**

IB

DRAFTING CHECK **DATE**

ND

DISCIPLINE DIRECTOR **DATE**

AUTHORISED FOR ISSUE

Ian Robinson

DISCIPLINE TEAM LEADER **DATE**

Nick Dazeley

STATUS

Preliminary


Caloundra South Ambulance Station

Building Sections

Scale at A1: 1 : 100 Scale at A3: 1:200

Master Site Number: 5857 PSC Job Number: 5857

Drawing Number: A-SD-40.01 Issue: 6 Sheet No.:

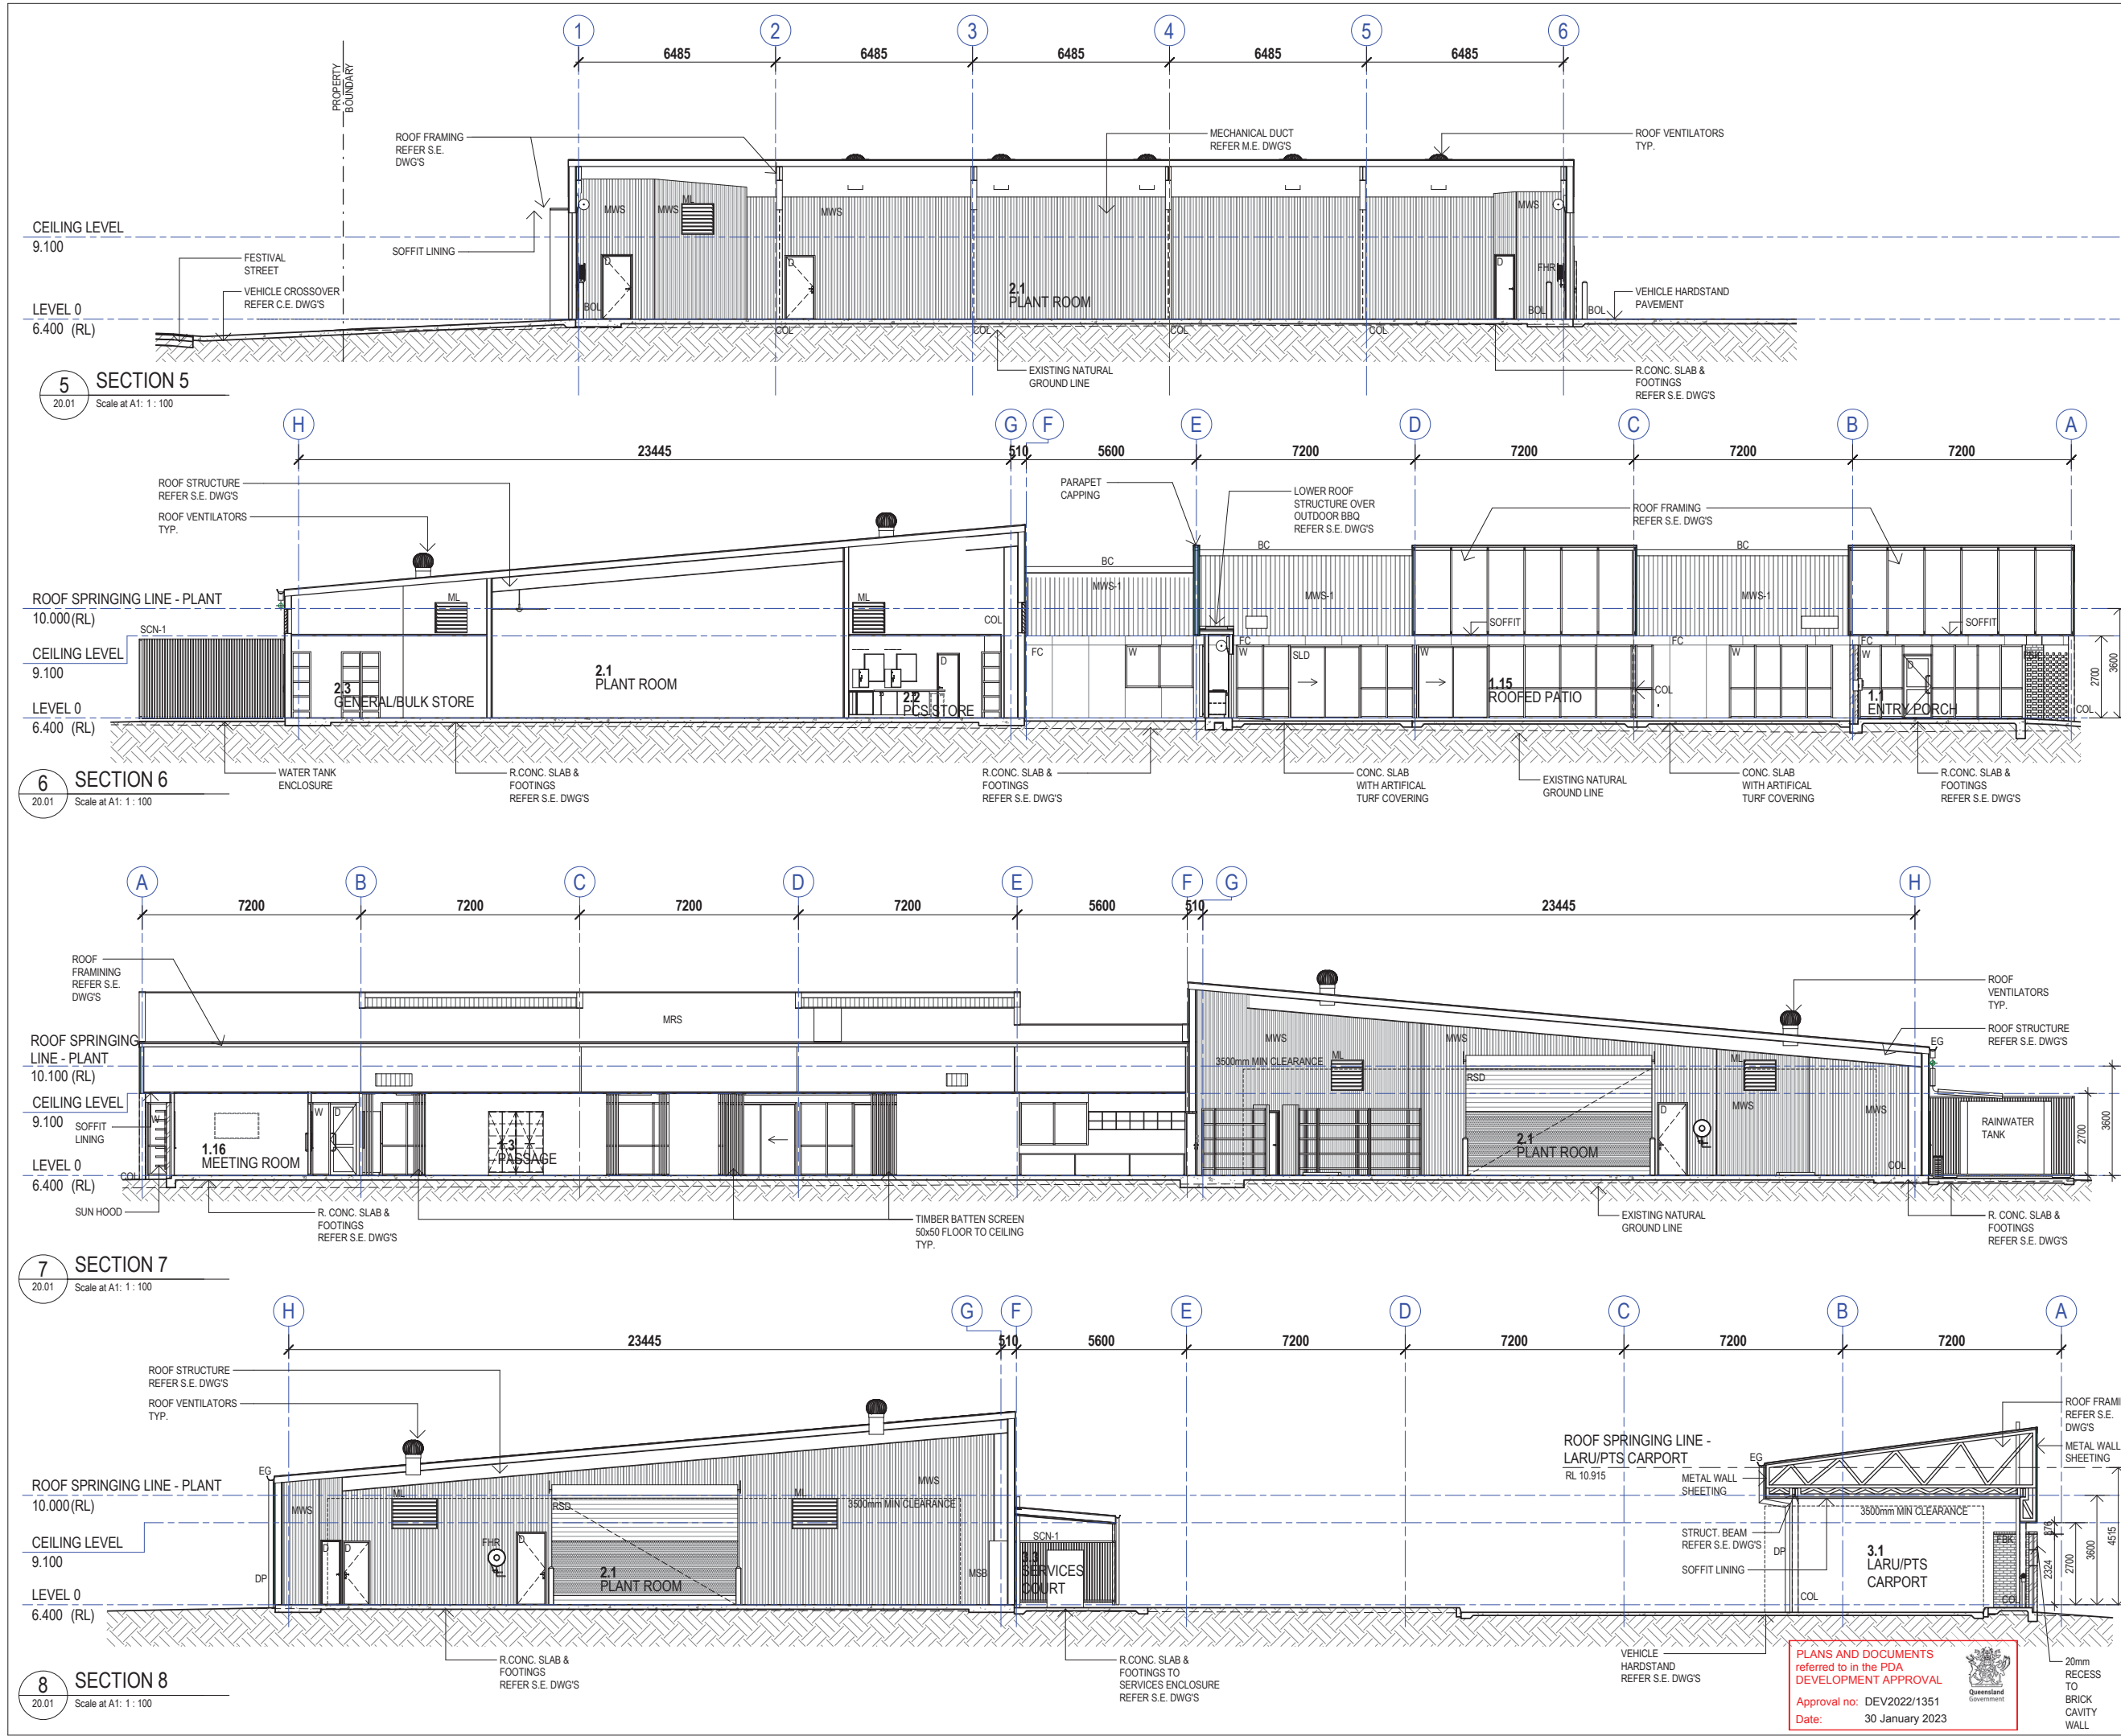

Barcode

**PHILLIPS
SMITH
CONWELL**

46 Berwick Street
PO Box 479 Fortitude Valley
Queensland 4006 Australia
T +617 3257 1167
pscarch@psc-architects.com.au

Verify all dimensions & check levels on site before commencing work. Do not scale from the drawing. The drawing is copyright & remains the property of the architect & shall not be reproduced or copied in any form or by any means without the written permission of the architect.

AMD	SUBJECT	INT	DATE
1	REVIEW ISSUE	IB/IR	12.08.22

DRAWING INDEX SYSTEM
Building & Asset Services ePlan Room use only

☐ CEILING PLANS	☐ MISCELLANEOUS DETAILS
☐ CONSTRUCTION DETAILS	☐ OTHER
☐ ELEVATIONS	☐ PLAY STRUCTURES
☐ EXTERNAL WORKS	☐ ROOF PLANS
☐ FITOUTS	☐ SECTIONS
☐ FLOOR PLANS	☐ SETOUT PLAN
☐ FURNITURE & EQUIPMENT	☐ SITE PLAN
☐ HYDRAULICS	☐ STANDARDS
☐ MASTER PLAN	

CLIENT

Queensland Government
Department of Energy and Public Works

CONTRACTOR

PROJECT MANAGER

Queensland Government
Department of Energy and Public Works

DRAWN	DATE
IB	
DRAFTING CHECK	DATE
ND	
DISCIPLINE DIRECTOR	DATE
AUTHORISED FOR ISSUE	
Ian Robinson	
DISCIPLINE TEAM LEADER	DATE
Nick Dazeley	

STATUS

Preliminary

Caloundra South Ambulance Station

Building Sections

0 1 2 3 4 5 6 7 8m

Scale at A1: 1:100 Scale at A3: 1:200

Master Site Number	PSC Job Number
	5857
Drawing Number	Issue
A-SD-40.02	1
Sheet No.	

PLANS AND DOCUMENTS
referred to in the PDA
DEVELOPMENT APPROVAL

Approval no: DEV2022/1351
Date: 30 January 2023

20mm RECESS TO BRICK CAVITY WALL

MATERIALS & FINISHES SCHEDULE		
Caloundra South QAS		
	Building Headers	XXX
	Amendments	TO BE CONFIRMED
DRAWING REFERENCE / LOCATION	ITEM	DESCRIPTION
0193 ROOF SAFETY SYSTEMS		
Roof Safety Systems	Type	Refer Brief and Specification - Roofs & Fall Protection Arrest System
0242 FENCING & BARRIERS		
Perimeter Fencing	External fence	2100mm high powdercoat spear head steel fence
		Maximum 1.8m high fence will be aluminium batten style fence comprising 50x10 aluminium battens on edge with 50mm spacings of battens, 80% open area.
0335 BRICK CONSTRUCTION		
Brickwork	Blockwork generally	Austral Brick Mineral Contours Colour: Feldspar Taupe
0431 CLADDING		
MWS	Metal Wall Cladding	Lysaght Klip-lok 0.48mm BMT concealed fix single length sheets. Colorbond finish: Monument
FC	FC external cladding	Hardies ExoTec Façade Panel system - 9mm compressed FC panels with 10mm expressed joints Colour: Dulux White Polar Quarter
0421 ROOFING		
MRS	Metal Roof Sheetting	Lysaght Klip-lok 0.48mm BMT concealed fix single length sheets. Colorbond finish: Surfmist.
	Flashings and cappings	Colorbond finish: Monument to match wall cladding colour. Refer Brief and Specification - Cappings and Trim
	Gutters, Downpipes & leaf guard	Refer Brief and Specification - Roof Fascia, Gutters and Downpipes Colorbond finish: Monument
	Gutters (station building)	Provide formed concealed eaves gutters to the station building. Provide with steel mesh gutter guard. Provide overflow downpipes directly downwards at frequent spacings.
	Roof ventilators	Refer Brief and Specification - Roofs
0315 CONCRETE FINISHES		
Driveway & Parking Areas.	Finish	Standard grey concrete. Nylon broom non-slip finish
Footpaths, Entry Slab	Finish	Boral 'Expose' Cherry Blossom decorative exposed aggregate finish concrete.
0451 WINDOWS AND GLAZED DOORS		
External windows & Glazed Doors	Type	Fixed and openable aluminium windows & glazed doors as indicated in plans and elevations.
		Refer Brief and Specification - Windows and Doors
		Front-glazed aluminium frame section, sized to suit application .
		Powdercoat finish to frames generally.
Internal sliding window	Location	Provide at Foyer wall adjoining Office
Internal glazed walls	Type	Aluminium framed glazing floor to ceiling
0453 DOORS & ACCESS PANELS		
Doors generally	Type	Refer Brief and Specification - Windows and Doors
Door Frames	Type	Refer Brief and Specification - Windows and Doors
0454 OVERHEAD DOORS		
Engine Room doors	Type	Roller Shutters Refer Refer Brief and Specification - Roller Shutters
		Colour: Colorbond Evening Haze
		Refer Mechanical Engineer for free area requirements.
0457 EXTERNAL SCREENS		
External window sunscreens	Type	Louvreclad Ascot Series aluminium fixed sunshade system. 470mm deep. Powdercoat finish. Colour: To match Colorbond Basalt
Hot exit roller door perimeter screen	Type	As for window sunscreen except: 670mm deep. Colour: Monument

MATERIALS & FINISHES SCHEDULE		
Caloundra South QAS		
	Building Headers	XXX
	Amendments	TO BE CONFIRMED
DRAWING REFERENCE / LOCATION	ITEM	DESCRIPTION
External Area screening	Type	Louvreclad Barossa Series aluminium rectangular blade system. Blade size: 60x45. Powdercoat finish. Colour: To match Colorbond Basalt
Utility Screening	Screens around services court, mechanical enclosure, rubbish bins	As per External Area screening
0461 GLAZING		
Glazing generally		Refer Brief and Specification - Windows and Doors
0471 THERMAL INSULATION		
Thermal Insulation generally	Type	To comply with Part J energy efficiency requirements.
Thermal Insulation - non-airconditioned spaces	Wall and Ceiling insulation to Plant Room	Refer Brief and Specification - Insulation
0511 LINING		
Wall linings	Type	Refer Brief and Specification - Internal Walls & Room Data Sheets. Colour: Dulux Polar White Quarter
Internal wall linings to the whole of the plant room.	Type	Lysaght Trimwall walling profile. Colour: Shale Grey
0527 ROOM DIVIDERS		
Operable walls	Type	Refer Brief and Specification - Internal Walls & Acoustic Report
0531 CEILINGS		
Ceilings - Flat	Type	Refer Brief and Specification - Ceilings and Room Data Sheets Colour: Flat white
Ceilings - Kitchen and Dayroom panels	Type	Atkar Au.diPanel perforated ceiling timber panel. Install panels with acoustic backing underneath the flush ceiling lining (sealed ceiling).
Soffits	Type	Refer Brief and Specification - Roof Soffits . Colour: Flat White
0531 JOINERY		
QAS standard joinery	Type	As per QAS Standard Details & Brief and Specifications - Joinery
		Refer 1:50 plans for locations
Non-standard joinery	Type	Refer 1:50 plans for descriptions and locations
Kitchen benchtops	Type	Corian seamless solid surface type.
Food locker sign holders	Type	Blueprint sign holder wall mount A5 size portrait JPM-47101B Melbourne Office Supplies
Timber bump rails - Dayroom	Type	Provide timber bump rail to wall behind recline chairs.
0552 METALWORK - FABRICATED		
Stainless steel corner protection	Type	Refer QAS Brief and Specification - Internal Walls
0573 FIRE EXTINGUISHERS AND BLANKETS		
Generally	Location	Refer Room Data Sheets
0574 WINDOW COVERINGS		
All external windows except Foyer, Writeup and Stairwell	Type	Luxaflex roller blinds. Confirm which rooms are to be provided with blackout fabric.
0581 SIGNAGE		
Signage generally	Type	Refer Brief and Specification - Signage
Caloundra South Ambulance signs	Type	Construct from stainless steel letters fixed with mounting lugs in front of the mounting wall.
0651 RESILIENT FINISHES		
Applied finish to Engine Room and adjacent areas	Type	Refer Brief and Specification - Resilient Floor Finishes - Epoxy Flooring
Vinyl Floor	Type	Refer Brief and Specification - Resilient Floor Finishes - Sheet Vinyl
Vinyl Floor - Wet Areas	Type	Refer Brief and Specification - Resilient Floor Finishes - Sheet Vinyl non-slip vinyl
Data Room vinyl floor	Type	Refer Brief and Specification - Resilient Floor Finishes - Sheet Vinyl anti-static vinyl
0652 CARPET		
Carpets generally	Type	Carpet tiles. Refer Brief and Specification - Carpet Tiles
		Colour from the manufacturers standard range.
0671 PAINTING		
Painting	Type, extent.	Refer Brief and Specification - Painting

Barcode

PHILLIPS
SMITH
CONWELL

46 Berwick Street
PO Box 479 Fortitude Valley
Queensland 4006 Australia
T +617 3257 1167
pscarch@psc-architects.com.au

Verify all dimensions & check levels on site before commencing work. Do not scale from the drawing. The drawing is copyright & remains the property of the architect & shall not be reproduced or copied in any form or by any means without the written permission of the architect.

AMD	SUBJECT	INT	DATE
1	REVIEW ISSUE	IB/IR	12.08.22

DRAWING INDEX SYSTEM
Building & Asset Services ePlan Room use only

☐ CEILING PLANS

☐ CONSTRUCTION DETAILS

☐ ELEVATIONS

☐ EXTERNAL WORKS

☐ FITOUTS

☐ FLOOR PLANS

☐ FURNITURE & EQUIPMENT

☐ HYDRAULICS

☐ MASTER PLAN

☐ MISCELLANEOUS DETAILS

☐ OTHER

☐ PLAY STRUCTURES

☐ ROOF PLANS

☐ SECTIONS

☐ SETOUT PLAN

☐ SITE PLAN

☐ STANDARDS

CLIENT



CONTRACTOR

PROJECT MANAGER



Queensland
Government

Department of
Energy and Public Works

DRAWN

DATE

IB

DRAFTING CHECK

DATE

ND

DISCIPLINE DIRECTOR
AUTHORISED FOR ISSUE

DATE

Ian Robinson

DISCIPLINE TEAM LEADER

DATE

Nick Dazeley

STATUS

Preliminary

Caloundra South Ambulance Station

Materials & Finishes Schedule

Scale at A1

Scale at A3

Master Site Number

PSC Job Number

5857

Drawing Number

Issue

Sheet No.

A-SD-80.01

1

MATERIALS & FINISHES SCHEDULE		
Caloundra South QAS		
	Building Headers	XXX
	Amendments	TO BE CONFIRMED
DRAWING REFERENCE / LOCATION	ITEM	DESCRIPTION
	Colour	Refer to this schedule
	External exposed steelwork	Provide durable paint finish over hot dip galvanised finish.
0811 SANITARY FIXTURES & 0812 TAPWARE		
Hydraulics fixtures	Location	Refer 1:50 plans
	Types	Refer <i>Brief and Specification - Plumbing Fixtures</i>
APPLIANCES & FIXTURES		
Generally	Type, extent.	Refer <i>Brief and Specification - Appliances/Accessories & Room Data Sheets</i>
BBQ	Electric bbq to external deck	"Cookout BBQ" Delux Electric Built-In 316 grade Stainless Steel BBQ
		Size: Cooking plate dimensions 619longx283wide
		Installation: Dropped into bench
Baby Change table	Type	Koala Kare KB110-SSRE stainless steel baby change table recessed into wall.
		Refer architectural drawings for location

Barcode

PHILLIPS
SMITH
CONWELL

46 Berwick Street
PO Box 479 Fortitude Valley
Queensland 4006 Australia
T +617 3257 1167
pscarch@psc-architects.com.au
Verify all dimensions & check levels on site before commencing work. Do not scale from the drawing. The drawing is copyright & remains the property of the architect & shall not be reproduced or copied in any form or by any means without the written permission of the architect.

AMD	SUBJECT	INT	DATE
1	REVIEW ISSUE	IB/IR	12.08.22

DRAWING INDEX SYSTEM
Building & Asset Services ePlan Room use only

☐ CEILING PLANS
☐ CONSTRUCTION DETAILS
☐ ELEVATIONS
☐ EXTERNAL WORKS
☐ FITOUTS
☐ FLOOR PLANS
☐ FURNITURE & EQUIPMENT
☐ HYDRAULICS
☐ MASTER PLAN

☐ MISCELLANEOUS DETAILS
☐ OTHER
☐ PLAY STRUCTURES
☐ ROOF PLANS
☐ SECTIONS
☐ SETOUT PLAN
☐ SITE PLAN
☐ STANDARDS

CLIENT



CONTRACTOR

PROJECT MANAGER



Queensland
Government
Department of
Energy and Public Works

DRAWN

DATE

IB

DRAFTING CHECK

DATE

ND

DISCIPLINE DIRECTOR
AUTHORISED FOR ISSUE

DATE

Ian Robinson

DISCIPLINE TEAM LEADER

DATE

Nick Dazeley

STATUS

Preliminary

Caloundra South Ambulance Station

Materials & Finishes Schedule

Scale at A1

Scale at A3

Master Site Number

PSC Job Number

5857

Drawing Number

Issue

Sheet No.

A-SD-80.02

1



VIEW OF OVERALL SITE

Refer to Approved Landscape Plan
for revised landscape intent

AMENDED IN RED
By: Andrew McKnight
Date: 29 November 2022

PLANS AND DOCUMENTS
referred to in the PDA
DEVELOPMENT APPROVAL
Approval no: DEV2022/1351
Date: 30 January 2023

Barcode

PHILLIPS
SMITH
CONWELL

46 Berwick Street
PO Box 479 Fortitude Valley
Queensland 4006 Australia
T +617 3257 1167
pscarch@psc-architects.com.au

Verify all dimensions & check levels on site before
commencing work. Do not scale from the drawing.
The drawing is copyright & remains the property of
the architect & shall not be reproduced or copied in
any form or by any means without the written
permission of the architect.

AMD	SUBJECT	INT	DATE
1	PRELIMINARY ISSUE	IB/IR	08.03.22
2	PRELIMINARY ISSUE	IB/IR	16.03.22
3	PRELIMINARY ISSUE	IB/IR	29.03.22
4	PRELIMINARY ISSUE	IB/IR	08.04.22
5	REVIEW ISSUE	IB/IR	12.08.22

DRAWING INDEX SYSTEM

Building & Asset Services ePlan Room use only

☐ CEILING PLANS

☐ CONSTRUCTION DETAILS

☐ ELEVATIONS

☐ EXTERNAL WORKS

☐ FITOUTS

☐ FLOOR PLANS

☐ FURNITURE & EQUIPMENT

☐ HYDRAULICS

☐ MASTER PLAN

☐ MISCELLANEOUS DETAILS

☐ OTHER

☐ PLAY STRUCTURES

☐ ROOF PLANS

☐ SECTIONS

☐ SETOUT PLAN

☐ SITE PLAN

☐ STANDARDS

CLIENT



CONTRACTOR

PROJECT MANAGER



Queensland
Government

Department of
Energy and Public Works

DRAWN

DATE

IB

DRAFTING CHECK

DATE

ND

DISCIPLINE DIRECTOR
AUTHORISED FOR ISSUE

DATE

Ian Robinson

DISCIPLINE TEAM LEADER

DATE

Nick Dazeley

STATUS

Preliminary

Caloundra South Ambulance Station

3D Perspective

Scale at A1

Scale at A3

Master Site Number

PSC Job Number

5857

Drawing Number


Issue

Sheet

A-SD-90.01

5

No.

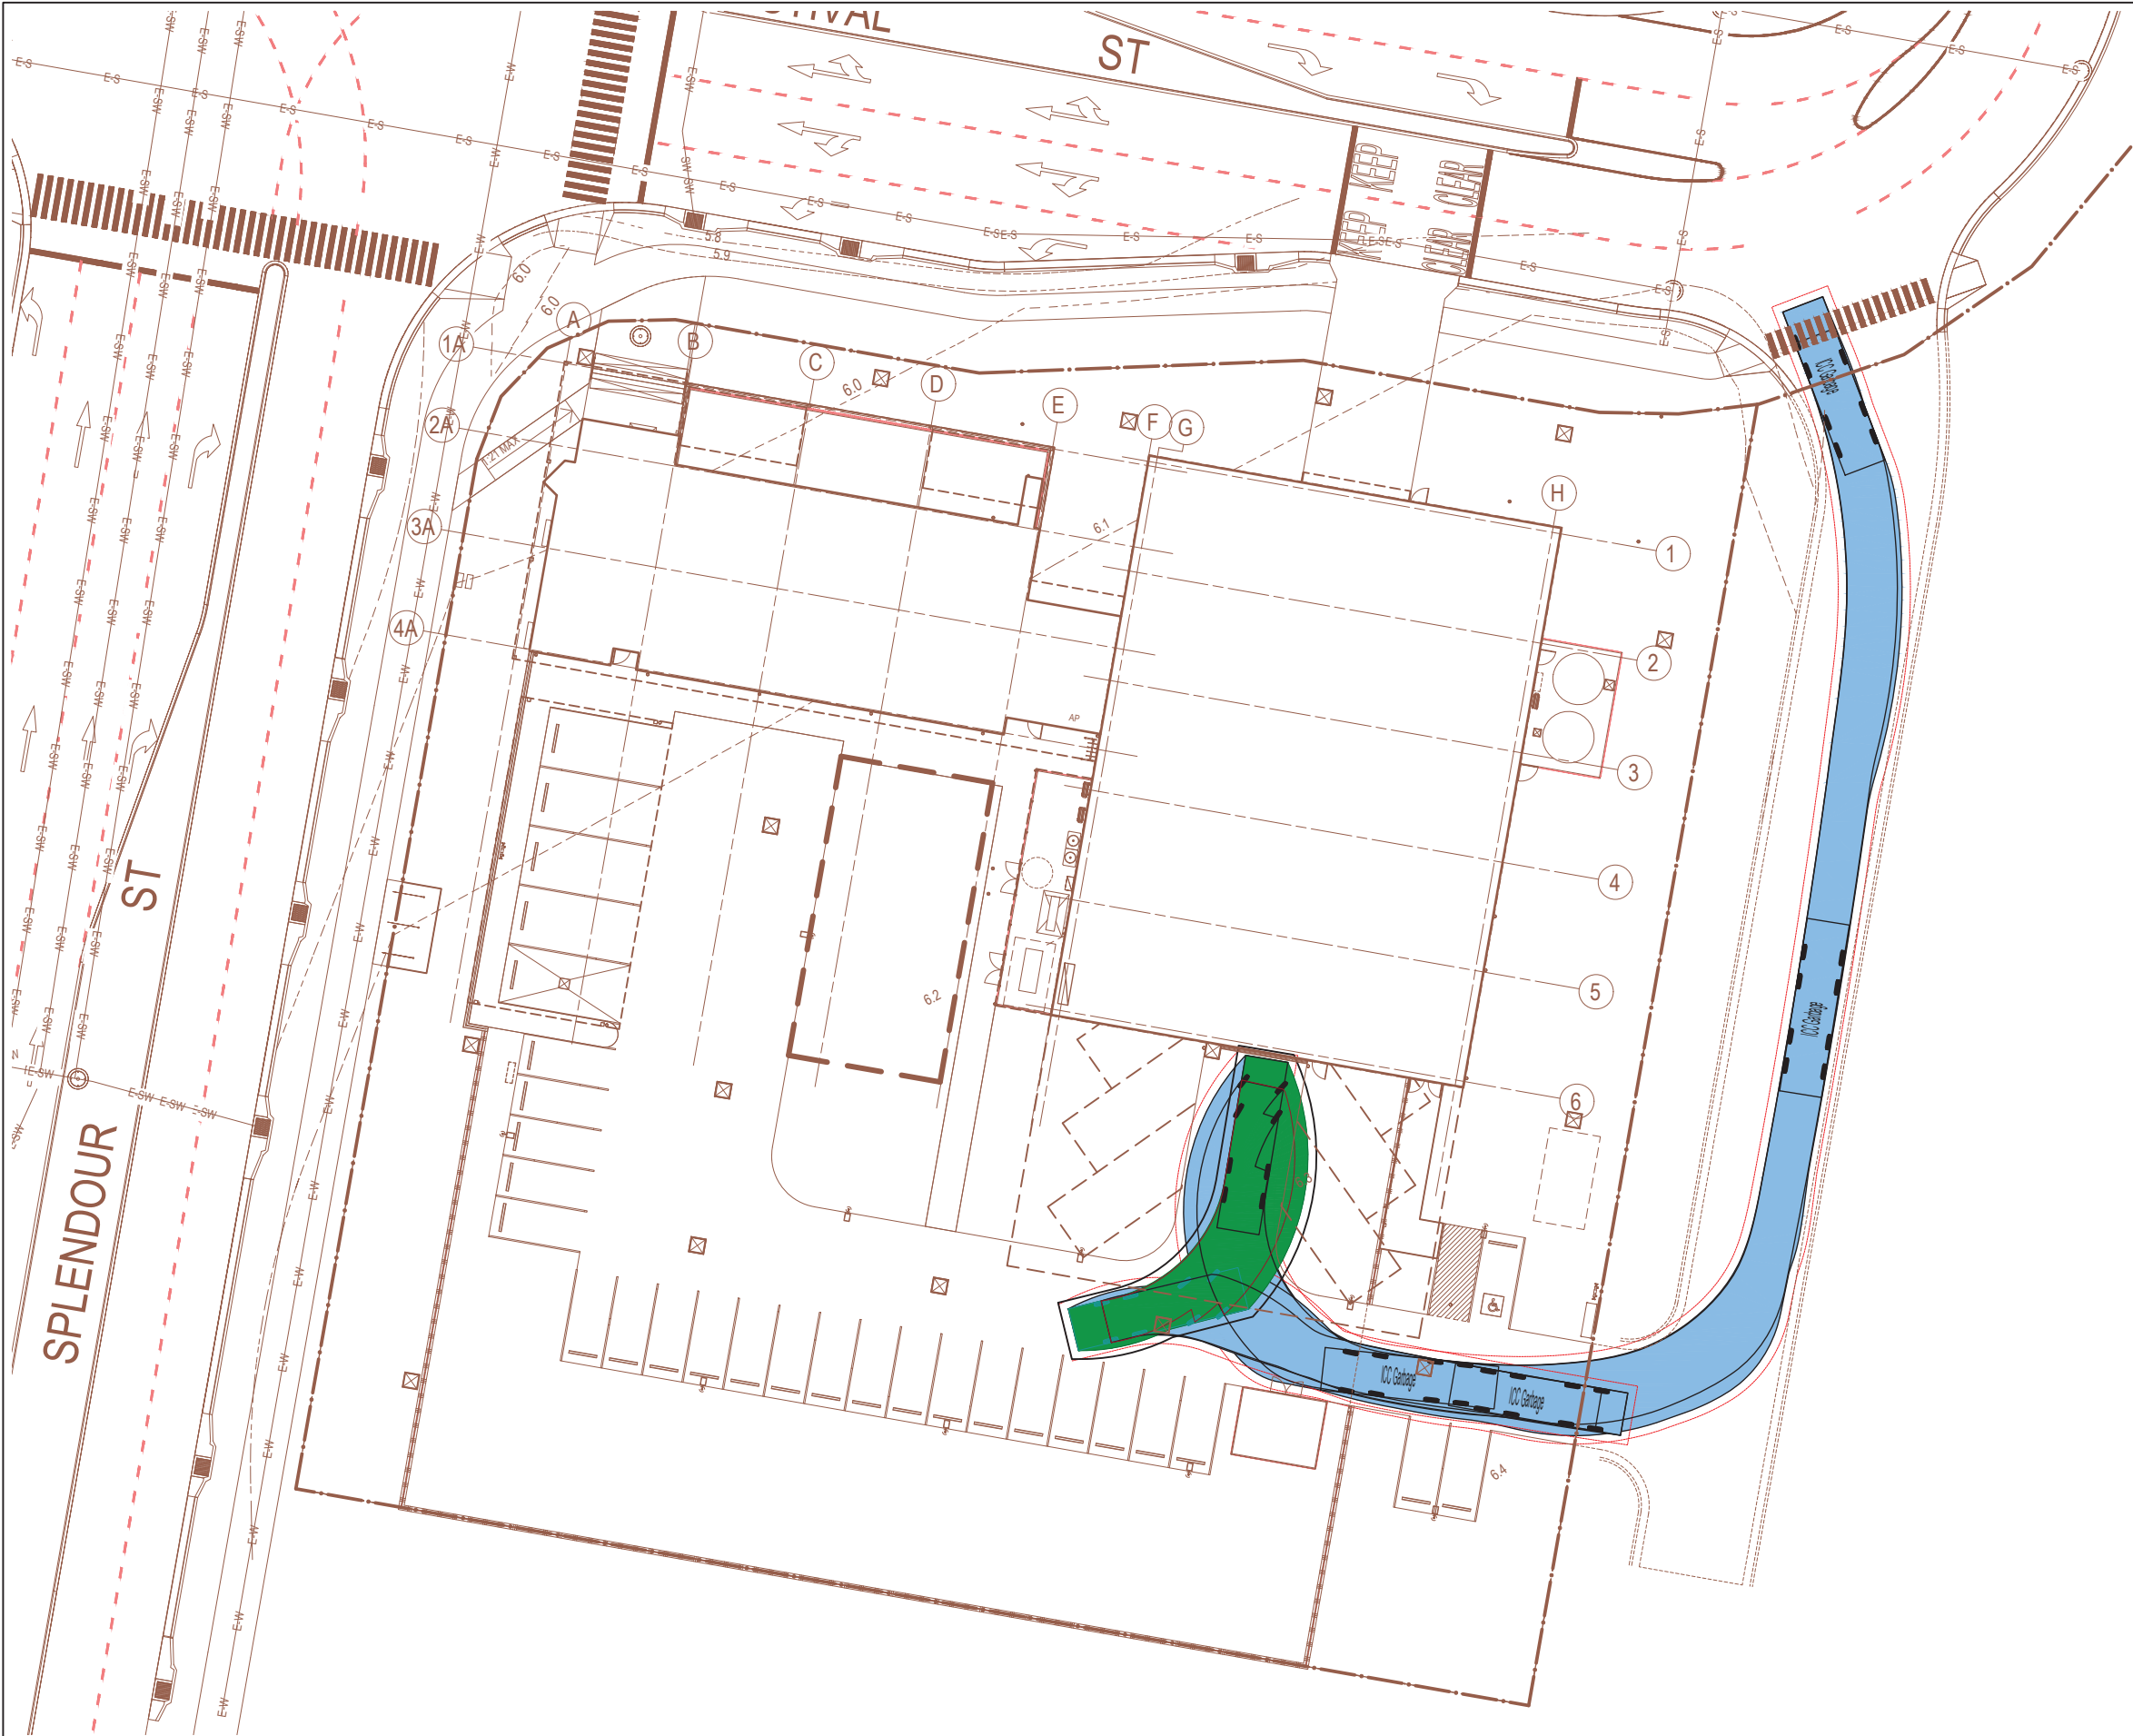


SCALE 1:250 @ A1
SCALE 1:500 @ A3

© COPYRIGHT of this design and plan is the property of ACOR Consultants (QLD) Pty Ltd, ACN 126 011 087 ABN 18 126 011 087, all rights reserved. It must not be used, modified, reproduced or copied wholly or in part without written permission from ACOR Consultants (QLD) Pty Ltd. ACOR Consultants is a trademark licensed to ACOR Consultants (QLD) Pty Ltd by ACOR Consultants Pty Ltd.

This drawing has been assigned an electronic code that signifies the drawing has been checked and approved by:

A	FOR INFORMATION	25.11.22	KG	PK
Issue	Description	Date	Drawn	Approved

 

ENGINEER'S CERTIFICATION
NAME:
RPEQ No:
SIGNED:



PHILLIPS
SMITH
CONWELL



ACOR Consultants (QLD) Pty Ltd
Level 7, 22 Cordelia Street
South Brisbane QLD 4101
T +61 7 3844 5900

Project: CALOUNDRA SOUTH AMBULANCE STATION
CNR SPLENDOUR ST & FESTIVAL ST
CALOUNDRA

THIS DRAWING IS TO BE
PRINTED IN COLOUR

NOT FOR CONSTRUCTION

PLANS AND DOCUMENTS
referred to in the PDA
DEVELOPMENT APPROVAL
Approval no: DEV2022/1351
Date: 30 January 2023



Drawn	Date	Scale	A1	Q.A. Check	Date
KG	NOV 2022	1:250		XX	DD.MM.YY
Designed	Project No.			Dwg. No.	Issue
KG				SKC01-001	A