

LUMINA OPEN SPACE
SOUTHPORT, QLD 4215
ELECTRICAL SERVICES



ELECTRICAL SERVICES DRAWING INDEX		
62.0010071	E-0000	COVER SHEET AND DRAWING INDEX
62.0010071	E-0001	LEGEND AND GENERAL NOTES
62.0010071	E-0100	SITE PLAN
62.0010071	E-0200	SCHEMATICS
62.0010071	E-0300	DETAILS
62.0010071	E-0301	DETAILS
62.0010071	E-0302	DETAILS
62.0010071	E-1001	LIGHTING LAYOUT SHEET 1
62.0010071	E-1002	LIGHTING LAYOUT SHEET 2
62.0010071	E-1003	LIGHTING LAYOUT SHEET 3
62.0010071	E-1004	LIGHTING LAYOUT SHEET 4
62.0010071	E-2001	POWER AND RETICULATION LAYOUT SHEET 1
62.0010071	E-2002	POWER AND RETICULATION LAYOUT SHEET 2
62.0010071	E-2003	POWER AND RETICULATION LAYOUT SHEET 3
62.0010071	E-2004	POWER AND RETICULATION LAYOUT SHEET 4
62.0010071	E-3001	ICT LAYOUT SHEET 1
62.0010071	E-3002	ICT LAYOUT SHEET 2
62.0010071	E-3003	ICT LAYOUT SHEET 3
62.0010071	E-3004	ICT LAYOUT SHEET 4

DESIGN DEVELOPMENT

NOT TO BE USED FOR CONSTRUCTION
COPYRIGHT OF THIS DRAWING IS VESTED IN INTROBA.
THE DRAWING SHALL NOT BE REPRODUCED OR COPIED IN WHOLE OR IN PART IN ANY
FORM WITHOUT THE PRIOR WRITTEN APPROVAL OF INTROBA.
CONTRACTOR MUST VISIT SITE BEFORE TENDERING

No.	DATE	REVISION	BY
1	06-04-23	50% DESIGN DEVELOPMENT DRAFT	DDS
2	18-04-23	50% DESIGN DEVELOPMENT	DDS
3	17-05-23	90% DESIGN DEVELOPMENT	VL
4	26-05-23	95% DESIGN DEVELOPMENT CLIENT ISSUE	VL
5	21-07-23	100% DESIGN DEVELOPMENT ISSUE	VL

Client:



Queensland
Government

Economic Development Queensland (EDQ)

Architect:



Hassell

Hassell LTD ABN 24 007 711 435
Level2, Pier 8/9,23 Hickson Rd
Sydney NSW 2000 Australia
T +61 2 9101 2000
F +61 2 9101 2100
sydney@hassellstudio.com

REFERENCE MODEL RECEIVED DATE:

Architecture Model 1 Received on: 17-07-23



Introba

Brisbane
Level 7, 200 Creek Street
Brisbane, QLD 4000

hello@introba.com
www.introba.com

LUMINA OPEN SPACE

SOUTHPORT, QLD 4215

 
 
 


ELECTRICAL SERVICES
COVER SHEET AND DRAWING INDEX







DRAWING REPRODUCTION
THIS SET OF DOCUMENTS CONTAINS DRAWINGS THAT HAVE BEEN CREATED IN COLOUR.
REPRODUCTIONS MUST BE MADE IN COLOUR TO AVOID LOSS OF INFORMATION.
FOR BLACK & WHITE PRINTING PLEASE CONTACT INTROBA FOR A REVISED SET OF
BLACK & WHITE SPECIFIC DOCUMENTS.




DRAWN	CS	DATE	21-07-23
DESIGN	DDS	SCALE	N.T.S
CHECKED	-	PLOT RATIO	1 / A1
APPROVED	-	PROJECT No	62.0010071
62.0010071-E-0000			5




Autodesk Docs://62.0010071 - Lumina Open Space/62.0010071_MEP_R22.rvt 21/07/2023 16:38:10

 
LEGEND OF SYMBOLS

 
 
 
 


 

 


 

 
 






POWER	
	WP2 DOUBLE SWITCHED SOCKET OUTLET 10A IP56
	32A ISOLATOR 3 PHASE RATING AS SHOWN
	3,20A,L SWITCHED SOCKET OUTLET 3 PHASE IP56 RATING AS SHOWN
	WP SWITCHED SOCKET OUTLET 10A IP56, CAPTIVE
	AV SWITCHED SOCKET OUTLET 10A IP56, CAPTIVE FOR AV



ELECTRICAL/COMMUNICATIONS PITS	
	C1 COMMUNICATIONS PIT TYPE 55 450x450 C/W CLASS B INFILL COVER TO AS 3996
	C2 COMMUNICATIONS PIT TYPE 77 600x600 C/W CLASS C INFILL COVER TO AS 3996
	EP EARTH ELECTRODE PIT C/W CLASS B INFILL COVER TO AS 3996
	NBN EXISTING NBN PIT
	P1 ELECTRICAL PIT TYPE 55 450x450 C/W CLASS B INFILL COVER TO AS 3996
	P2 ELECTRICAL PIT TYPE 77 600x600 C/W CLASS C INFILL COVER TO AS 3996

COMMUNICATIONS	
	AV DATA PROJECTOR IN WEATHER PROOF ENCLOSURE POLE MOUNTED ENCLOSURE AND POLE POWDER COATED TO MATCH
	LCD 70" LCD SCREEN 70" IN WEATHER PROOF ENCLOSURE IP65
	WAP WIRE ACCESS POINT, IP65 POLE MOUNTED AND POWDER COATED TO MATCH POLE

ELECTRICAL EQUIPMENT	
	ELECTRICAL DISTRIBUTION BOARD
	ENERGEX PILLAR
	LED DRIVER ENCLOSURE, PLINTH MOUNTED IN GARDEN

CONDUITS	
<varies>	
	C HD COMMUNICATIONS CONDUIT (QTY) C (DIAMETER)
	E HD ELECTRICAL CONDUIT (QTY) P (DIAMETER)

SCHEMATICS	
	COMBINED FUSE SWITCH.
	ON LOAD ISOLATOR.
	CONTROL SWITCH.
	MINIATURE CIRCUIT BREAKER (MCB).
	MOULDED CASE CIRCUIT BREAKER (MCCB).
	NON-AUTO CIRCUIT BREAKER.
	CIRCUIT BREAKER WITH RCD PROTECTION (30mA RATING).
	SINGLE PHASE BUSBAR OR CABLE.
	3 PHASE BUSBAR OR CABLE.
	CT CURRENT TRANSFORMER.
	FCL FAULT CURRENT LIMITER.
	BUSBAR MOUNTED FUSE.
	KWH AUTHORITY METER.
	C CONTACTOR COIL.
	CONTACTS.
	N/O - NORMALLY OPEN.
	N/C - NORMALLY CLOSED.
	eg. No. 6. SUB-MAIN CABLE REFERENCE.
	EM AUTHORITY ENERGY METER.
	M MULTI FUNCTION CHECK METER.
	SD SURGE DIVERTER.

SECURITY				
CCTV-2	4X2 MP MULTIDIRECTIONAL CAMERA WITH IR FOR 360° COVERAGE, COLOUR MATCH TO POLE (ANTHRACITE DB703 OR MATCHING)	AXIS COMMUNICATIONS	P3727-PL	
CCTV-1	FIXED 8 MP MINI DOME CAMERA ATTACHED TO LIGHTING POLE, COLOUR MATCH TO POLE (ANTHRACITE DB703 OR MATCHING)	AXIS COMMUNICATIONS	M3088-V	


GENERAL NOTES:

- FOR FINAL LOCATION OF ALL OUTLETS, LUMINAIRES & OTHER EQUIPMENT REFER TO ARCHITECTURAL DRAWINGS.
- ALL SSO's SHALL BE INSTALLED TO ARCHITECTS SETOUT.
- PROVIDE CABLE TRAYS FOR ALL POWER, CONTROL & COMMUNICATIONS CABLES RISING HORIZONTALLY & VERTICALLY THROUGHOUT THE BUILDING.
- ALL WIRING SHALL BE IN 2.5mm² PVC/PVC CABLE MINIMUM. A 4.0mm² PVC/PVC CABLE (MINIMUM)
- ALL WIRING SHALL BE CONCEALED UNLESS OTHERWISE SPECIFIED.
- VOLTAGE AS 230V / 400V UNLESS NOTED OTHERWISE.
- CIRCUITING:
 - 12 SSO - MAXIMUM PER CIRCUIT.
 - 16 LIGHTING POINTS - MAXIMUM PER CIRCUIT.

ABBREVIATIONS

AB	ABOVE BENCH.
AV	RESERVED FOR AUDIOVISUAL DEVICES.
BWU	BOILING WATER UNIT.
CL	CLEANERS OUTLET.
VM	VENDING MACHINE.
VPJ	VIDEO PROJECTION UNIT.
WAP	WIRELESS ACCESS POINT.
WP	WEATHERPROOF.
24HR	24 HOUR SECURITY CIRCUIT.

LUMINAIRE SCHEDULE

ID	LIGHT SOURCE	LUMINOUS FLUX (ABSOLUTE LUMENS)	POWER (WATTS)	COLOUR TEMPERATURE	COLOUR RENDERING INDEX	CONTROL GEAR	DESCRIPTION	INSTALLATION	FINISH/COLOUR	SUPPLIER	MODEL	Image
NA	LED	NA	NA	NA	80	NA	LIGHTING POLE FOR P2-1 FITTINGS	NA	ANTHRACITE (DB703)	LAD GROUP	CN SERIES	
L1	LED	900 lm	13 W	2700 K	<varies>	DALI	LED STRIP LIGHT	MOUNTED UNDER SEATING	ANTHRACITE (DB703)	LUXSON ILLUMINATION	LANCE 18	
P1	LED	965 lm	12 W	2700 K	80	DALI	POLE LIGHT	POLE MOUNTED	ANTHRACITE (DB703)	LAD GROUP	CN SERIES	
P2-1	LED	1617 lm	18 W	2700 K	80	DALI	MEDIUM PROJECTOR	POLE MOUNTED	ANTHRACITE (DB703)	LAD GROUP	C165	
U1	LED	3000 lm	29 W	2700 K	RGBW	DALI	UPLIGHT	LOCATED IN LANDSCAPE	TBC	LAD GROUP	R200	
U2	LED	1200 lm	12 W	2700 K	RGBW	DALI	UPLIGHT	LOCATED IN LANDSCAPE	TBC	LAD GROUP	R130	
WL1	LED	509 lm	8 W	2700 K	80	DALI	WALL LIGHT	MOUNTED TO STRUCTURAL COLUMN	ANTHRACITE (DB703)	LAD GROUP	IFROUND	

*** ALL LIGHTING TO BE CONTROLLED VIA WIRELESS BLUETOOTH LIGHTING CONTROL SYSTEM WITH NODES REMOTE AND INTEGRAL TO LUMINAIRES

LIGHTING PROCUREMENT NOTES

- THE ELECTRICAL TRADE IS TO ENSURE LIGHTING IS ORDERED WITH SUFFICIENT TIME TO MEET PROGRAMME. SHOULD DELIVERY DELAYS ARISE THAT MAY IMPACT PROGRAMME THE ELECTRICAL TRADE SHALL PROVIDE WRITTEN ADVICE FROM THE LIGHTING SUPPLIER ADVISING DELIVERY TIMES. THE CONSULTANT WILL ADVISE A REPLACEMENT LUMINAIRE.
- ALTERNATIVE LIGHTING WILL NOT BE CONSIDERED DUE TO LATE ORDERING BY THE ELECTRICAL TRADE.
- SHOULD THE TRADE SUBMIT ALTERNATIVE LIGHTING AS A COST SAVING PROPOSITION, REFER TO THE ELECTRICAL SPECIFICATION FOR SUBMISSION REQUIREMENTS

DESIGN DEVELOPMENT

NOT TO BE USED FOR CONSTRUCTION

COPYRIGHT OF THIS DRAWING IS VESTED IN INTROBA. THE DRAWING SHALL NOT BE REPRODUCED OR COPIED IN WHOLE OR IN PART IN ANY FORM, WITHOUT THE PRIOR WRITTEN APPROVAL OF INTROBA.

CONTRACTOR MUST VISIT SITE BEFORE TENDERING

No.	DATE	REVISION	BY
1	06-04-23	50% DESIGN DEVELOPMENT DRAFT	DOS
2	18-04-23	50% DESIGN DEVELOPMENT	DOS
3	17-05-23	90% DESIGN DEVELOPMENT	VL
4	26-05-23	95% DESIGN DEVELOPMENT CLIENT ISSUE	VL
5	21-07-23	100% DESIGN DEVELOPMENT ISSUE	VL

Client:



Economic Development Queensland (EDQ)

Architect:



Hassell
Hassell LTD ABN 24 007 711 435
Level2, Pier 8/9,23 Hickson Rd
Sydney NSW 2000 Australia
T +61 2 9101 2000
F +61 2 9101 2100
sydney@hassellstudio.com

REFERENCE MODEL RECEIVED DATE:

Architecture Model 1 Received on: 17-07-23



Brisbane
Level 7, 200 Creek Street
Brisbane, QLD 4000

hello@introba.com
www.introba.com

LUMINA OPEN SPACE

SOUTHPORT, QLD
4215

ELECTRICAL SERVICES
LEGEND AND GENERAL NOTES

UP1

DRAWING REPRODUCTION

THIS SET OF DOCUMENTS CONTAINS DRAWINGS THAT HAVE BEEN CREATED IN COLOUR. REPRODUCTIONS MUST BE MADE IN COLOUR TO AVOID LOSS OF INFORMATION. FOR BLACK & WHITE PRINTING PLEASE CONTACT INTROBA FOR A REVISED SET OF BLACK & WHITE SPECIFIC DOCUMENTS.

DRAWN	CS	DATE	21-07-23
DESIGN	DOS	SCALE	N.T.S
CHECKED	-	PLOT RATIO	1 / A1
APPROVED	-	PROJECT No	62.0010071

62.0010071-E-0001

5

1. REFER TO DRAWING E-0001 FOR LEGEND AND GENERAL NOTES



NOT TO BE USED FOR CONSTRUCTION
 COPYRIGHT OF THIS DRAWING IS VESTED IN INTROBA.
 THE DRAWING SHALL NOT BE REPRODUCED OR COPIED IN WHOLE OR IN PART IN ANY
 FORM, WITHOUT THE PRIOR WRITTEN APPROVAL OF INTROBA.
CONTRACTOR MUST VISIT SITE BEFORE TENDERING

62.0010071-E-0100

5

Client:



Queensland
Government

Economic Development Queensland (EDQ)

Architect:

H

Hassell

Hassell LTD ABN 24 007 711 435
Level2, Pier 8/9,23 Hickson Rd
Sydney NSW 2000 Australia
T +61 2 9101 2000
F +61 2 9101 2100
svdnev@hassellstudio.com

REFERENCE MODEL RECEIVED DATE:
Architecture Model 1 Received on: 17-07-23

 **Introba**
Brisbane
Level 7, 200 Creek Street
Brisbane, QLD 4000

hello@introba.com
www.introba.com

LUMINA OPEN SPACE
SOUTHPORT, QLD
4215


ELECTRICAL SERVICES SITE PLAN

DRAWING REPRODUCTION

THIS SET OF DOCUMENTS CONTAINS DRAWINGS THAT HAVE BEEN CREATED IN COLOUR. REPRODUCTIONS MUST BE MADE IN COLOUR TO AVOID LOSS OF INFORMATION.

FOR BLACK & WHITE PRINTING PLEASE CONTACT INTROBA FOR A REVISED SET OF BLACK & WHITE SPECIFIC DOCUMENTS.

1. REFER TO DRAWING E-0001 FOR LEGEND AND GENERAL NOTES

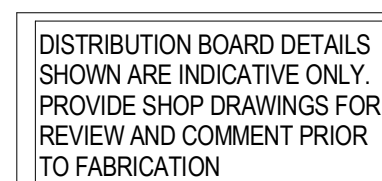

TYPICAL DISTRIBUTION BOARD ELEVATION



NOT TO BE USED FOR CONSTRUCTION

--	--	--

DRAWN	CS	DATE	21-07-23
DESIGN	DDS	SCALE	N.T.S
CHECKED	-	PLOT RATIO	1 / A1
APPROVED	-	PROJECT No	62.0010071

62.0010071-E-0200

5

No.	DATE	REVISION	BY
1	06-04-23	50% DESIGN DEVELOPMENT DRAFT	DDS
2	18-04-23	50% DESIGN DEVELOPMENT	DDS
3	17-05-23	90% DESIGN DEVELOPMENT	VL
4	26-05-23	95% DESIGN DEVELOPMENT CLIENT ISSUE	VL
5	21-07-23	100% DESIGN DEVELOPMENT ISSUE	VL

Client:



Economic Development Queensland (EDQ)

Architect:



Hassell

Hassell LTD ABN 24 007 711 435
Level2, Pier 8/9,23 Hickson Rd
Sydney NSW 2000 Australia
T +61 2 9101 2000
F +61 2 9101 2100
sydney@hassellstudio.com

REFERENCE MODEL RECEIVED DATE:

Architecture Model 1 Received on: 17-07-23



Brisbane
Level 7, 200 Creek Street
Brisbane, QLD 4000

hello@introba.com
www.introba.com

**LUMINA OPEN
SPACE**

 
SOUTHPORT, QLD
4215

ELECTRICAL SERVICES
SCHEMATICS


DRAWING REPRODUCTION

THIS SET OF DOCUMENTS CONTAINS DRAWINGS THAT HAVE BEEN CREATED IN COLOUR.
REPRODUCTIONS MUST BE MADE IN COLOUR TO AVOID LOSS OF INFORMATION.


FOR BLACK & WHITE PRINTING PLEASE CONTACT INFOBA FOR A REVISED SET OF
BLACK & WHITE SPECIFIC DOCUMENTS.




SCALE 1 : 50

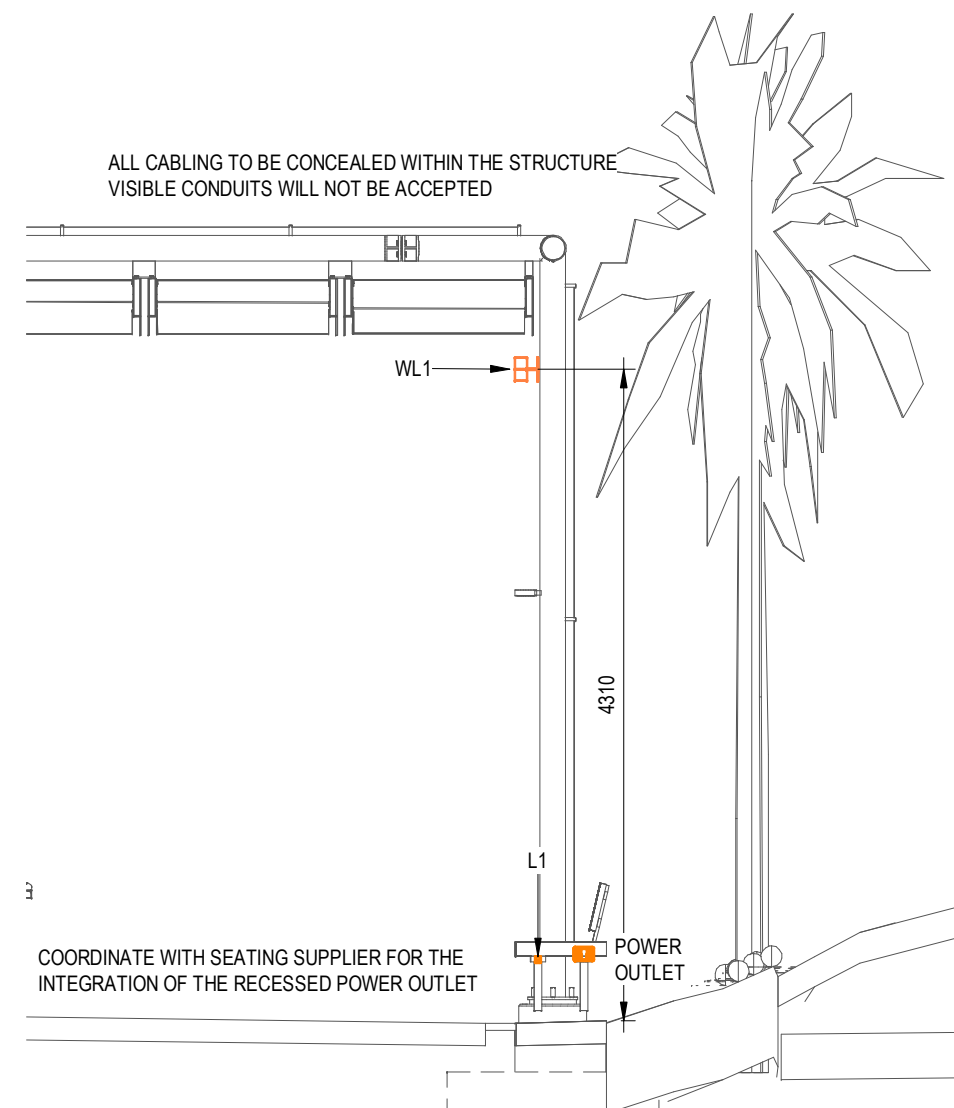

SCALE 1 : 50

 

SCALE 1 : 50

 

SCALE 1 : 50



NOT TO BE USED FOR CONSTRUCTION

THE DRAWING SHALL NOT BE REPRODUCED OR COPIED IN WHOLE OR IN PART IN ANY FORM, WITHOUT THE PRIOR WRITTEN APPROVAL OF INTROBA.

CONTRACTOR MUST VISIT SITE BEFORE TENDERING

CONTRACTOR MUST VISIT SITE BEFORE TENDERING

CONTRACTOR MUST VISIT SITE BEFORE TENDERING

62 0010071 E 0300

E

Client:


Queensland
Government

Economic Development Queensland (EDQ)

REFERENCE MODEL RECEIVED DATE:

Architecture Model 1 Received on: 17-07-23



Introba

Brisbane
Level 7, 200 Creek Street
Brisbane, QLD 4000

hello@introba.com
www.introba.com


ELECTRICAL SERVICES DETAILS

DRAWING REPRODUCTION

THIS SET OF DOCUMENTS CONTAINS DRAWINGS THAT HAVE BEEN CREATED IN COLOUR.
REPRODUCTIONS MUST BE MADE IN COLOUR TO AVOID LOSS OF INFORMATION.

FOR BLACK & WHITE PRINTING PLEASE CONTACT INTERBA FOR A REVISED SET OF
DRAWINGS.

DRAWN	CS	DATE	21-07-23
DESIGN	DDS	SCALE	N.T.S
CHECKED	-	PLOT RATIO	1 / A1
APPROVED	-	PROJECT No	62.0010071
62.0010071-E-0300			5

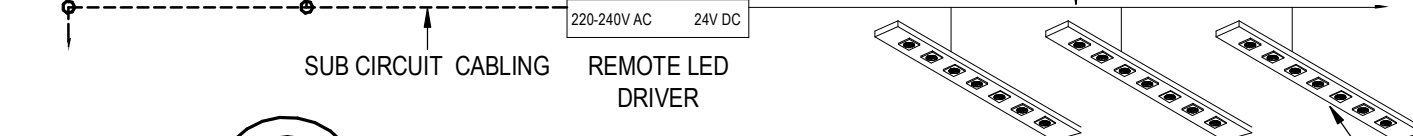

TYPICAL WIRELESS BLUETOOTH LIGHTING CONTROL SYSTEM

[illegible]

Architecture Model 1 Received on: 17-07-23



LUMINA OPEN SPACE

SOUTHPORT, QLD 4215

ELECTRICAL SERVICES DETAILS

DESIGN

DRAWINGS OF THIS DRAWING IS YET TO BE INTEGRAL TO THE
 THE DRAWING SHALL NOT BE REPRODUCED OR COPIED IN WHOLE OR IN PART IN A
 FORM WITHOUT THE WRITTEN APPROVAL OF THE GROUP.
 CONTRACTOR MUST VISIT SITE BEFORE TENDERING
DRAWING REPRODUCTION
 THIS SET OF DOCUMENTS CONTAINS DRAWINGS THAT HAVE BEEN CREATED IN COLOUR
 REPRODUCTIONS MUST BE MADE IN COLOUR TO AVOID LOSS OF INFORMATION.
 FOR BLACK & WHITE PRINTING PLEASE CONTACT INTEGRAL GROUP FOR A REVISION
 SET OF BLACK & WHITE SPECIFIC DOCUMENTS.


DRAWN	Author	DATE	21-07-23
DESIGN	Designer	SCALE	N.T.S
CHECKED	Checker	PLOT RATIO	1 / A1
APPROVED	Approver	PROJECT No	62.0010071
62.0010071-E-0301			3





ENTERPRISE GRADE PROJECTOR
BARCO F70-4K8 OR APPROVED EQUAL



PROJECTOR ENCLOSURE EXAMPLE
PROIETTA AF6 OR SIMILAR

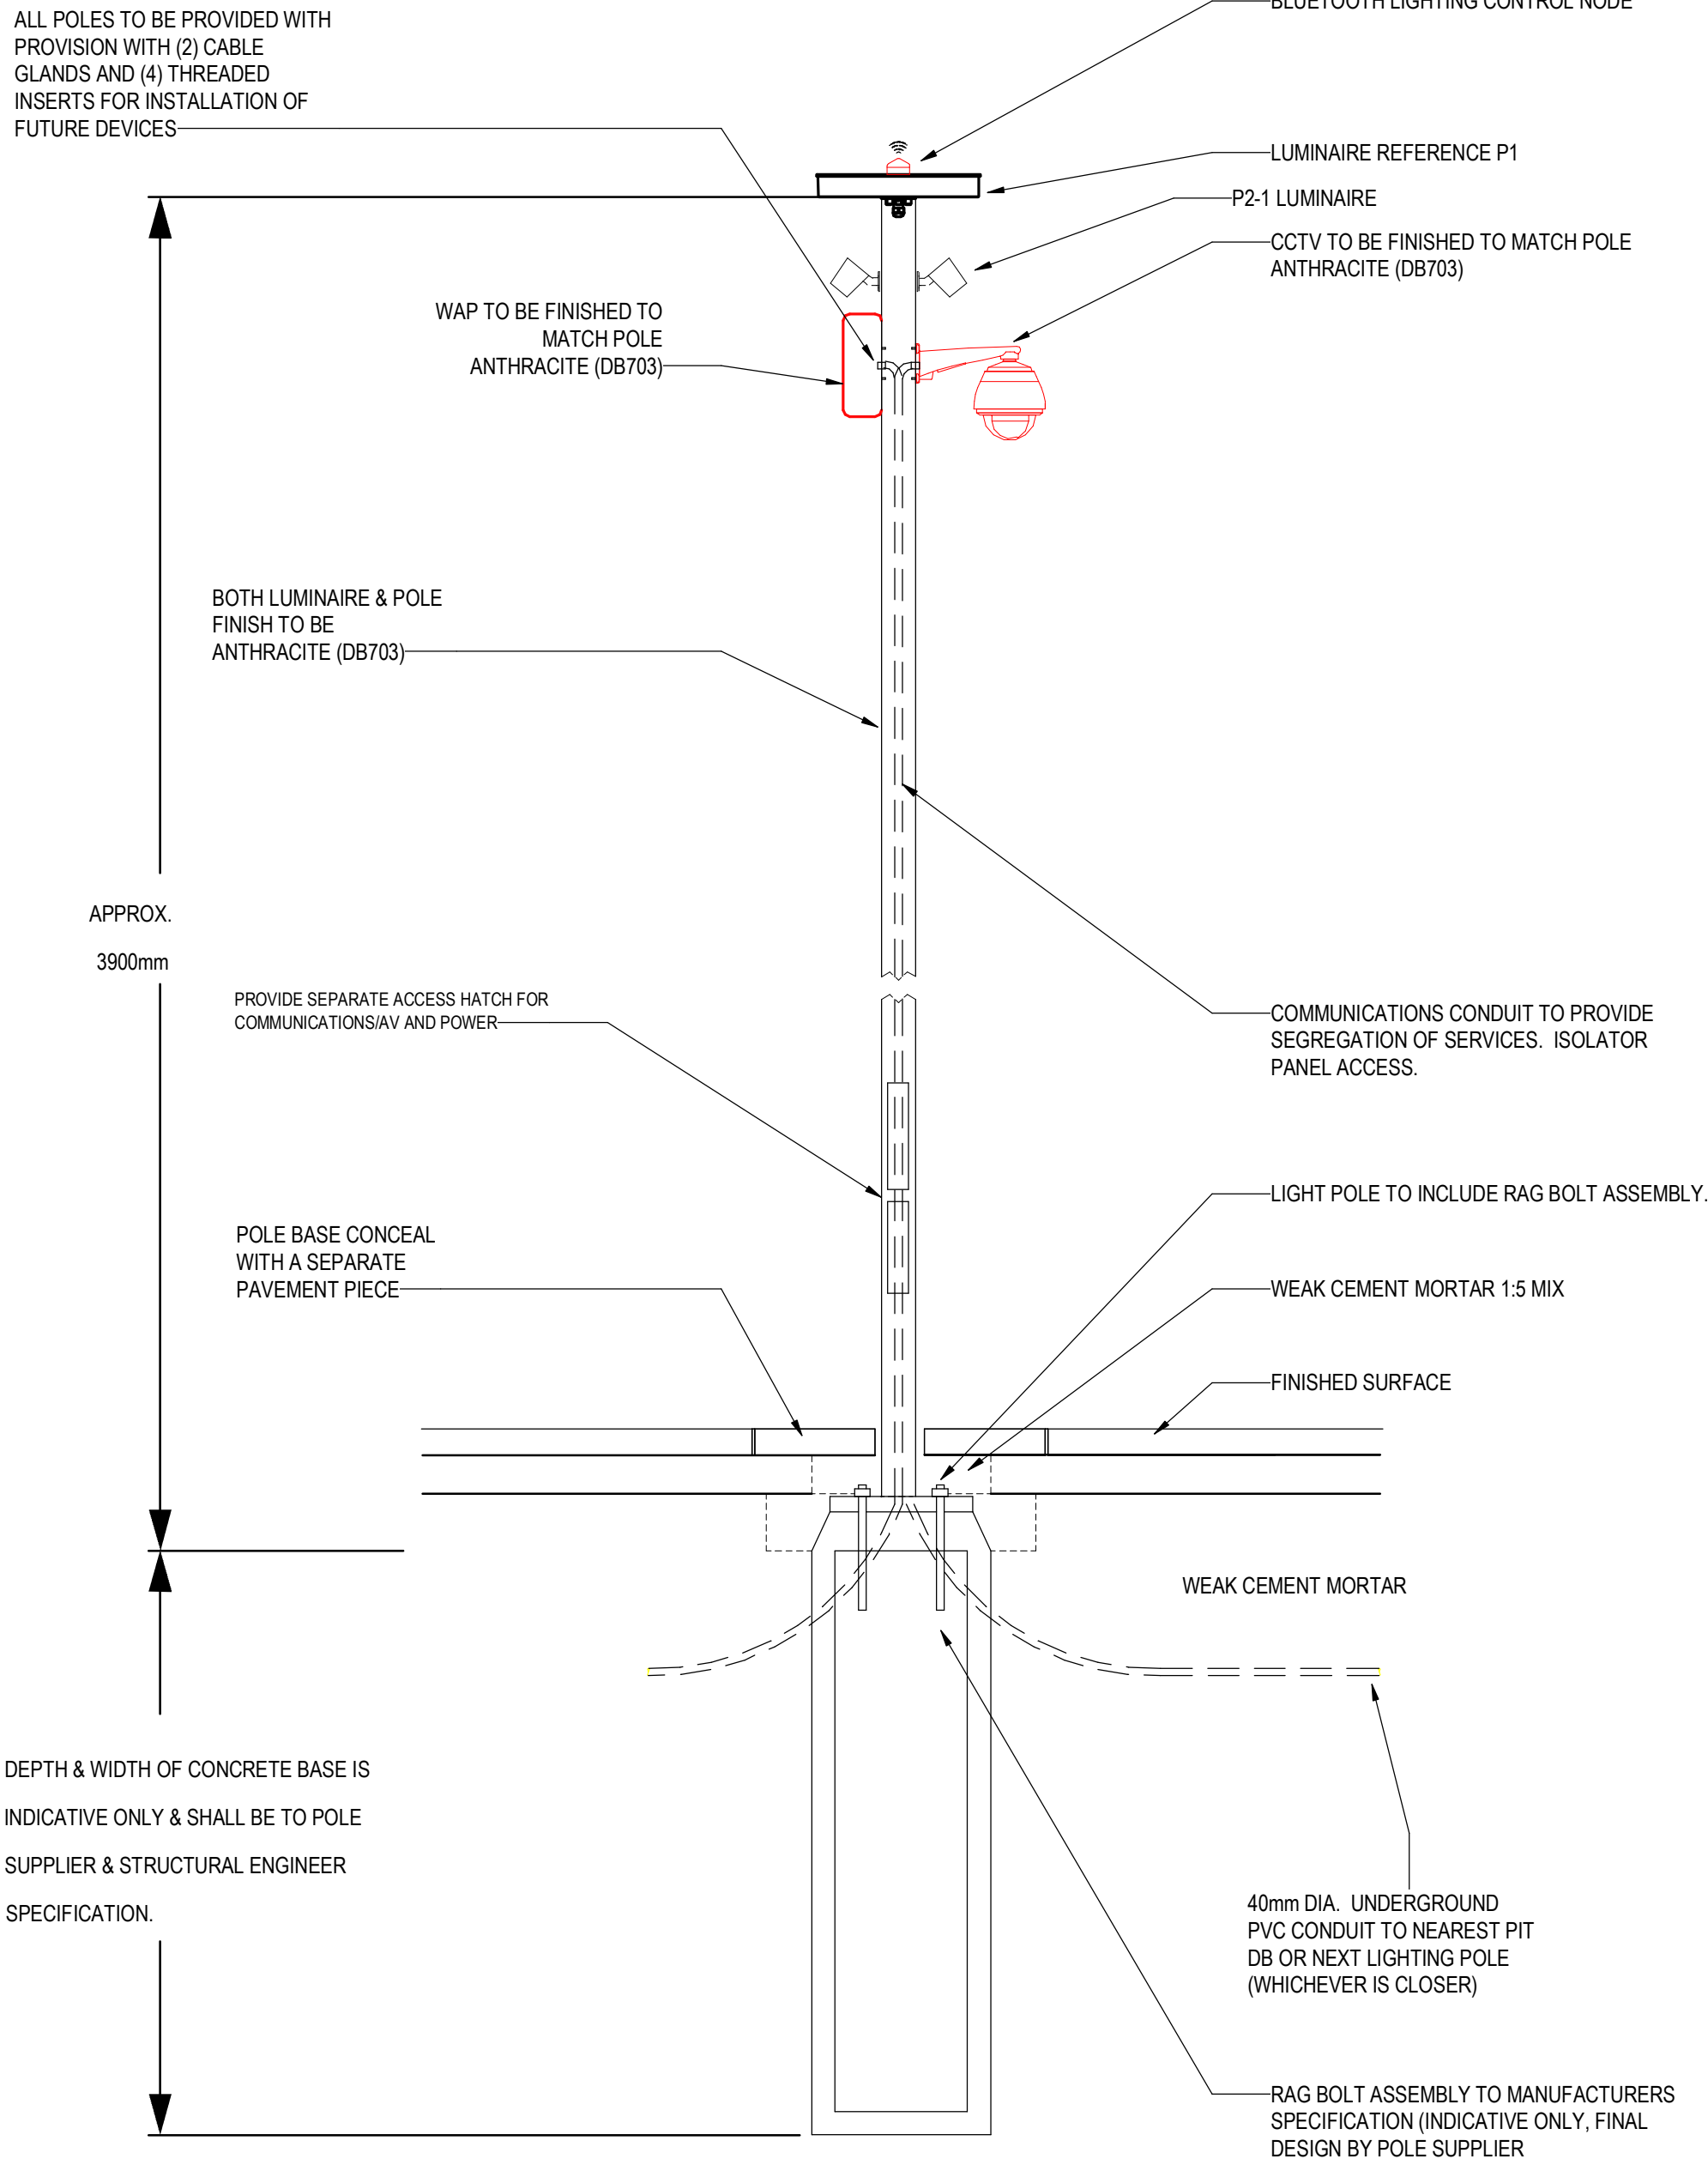

TYPICAL POLE DETAIL

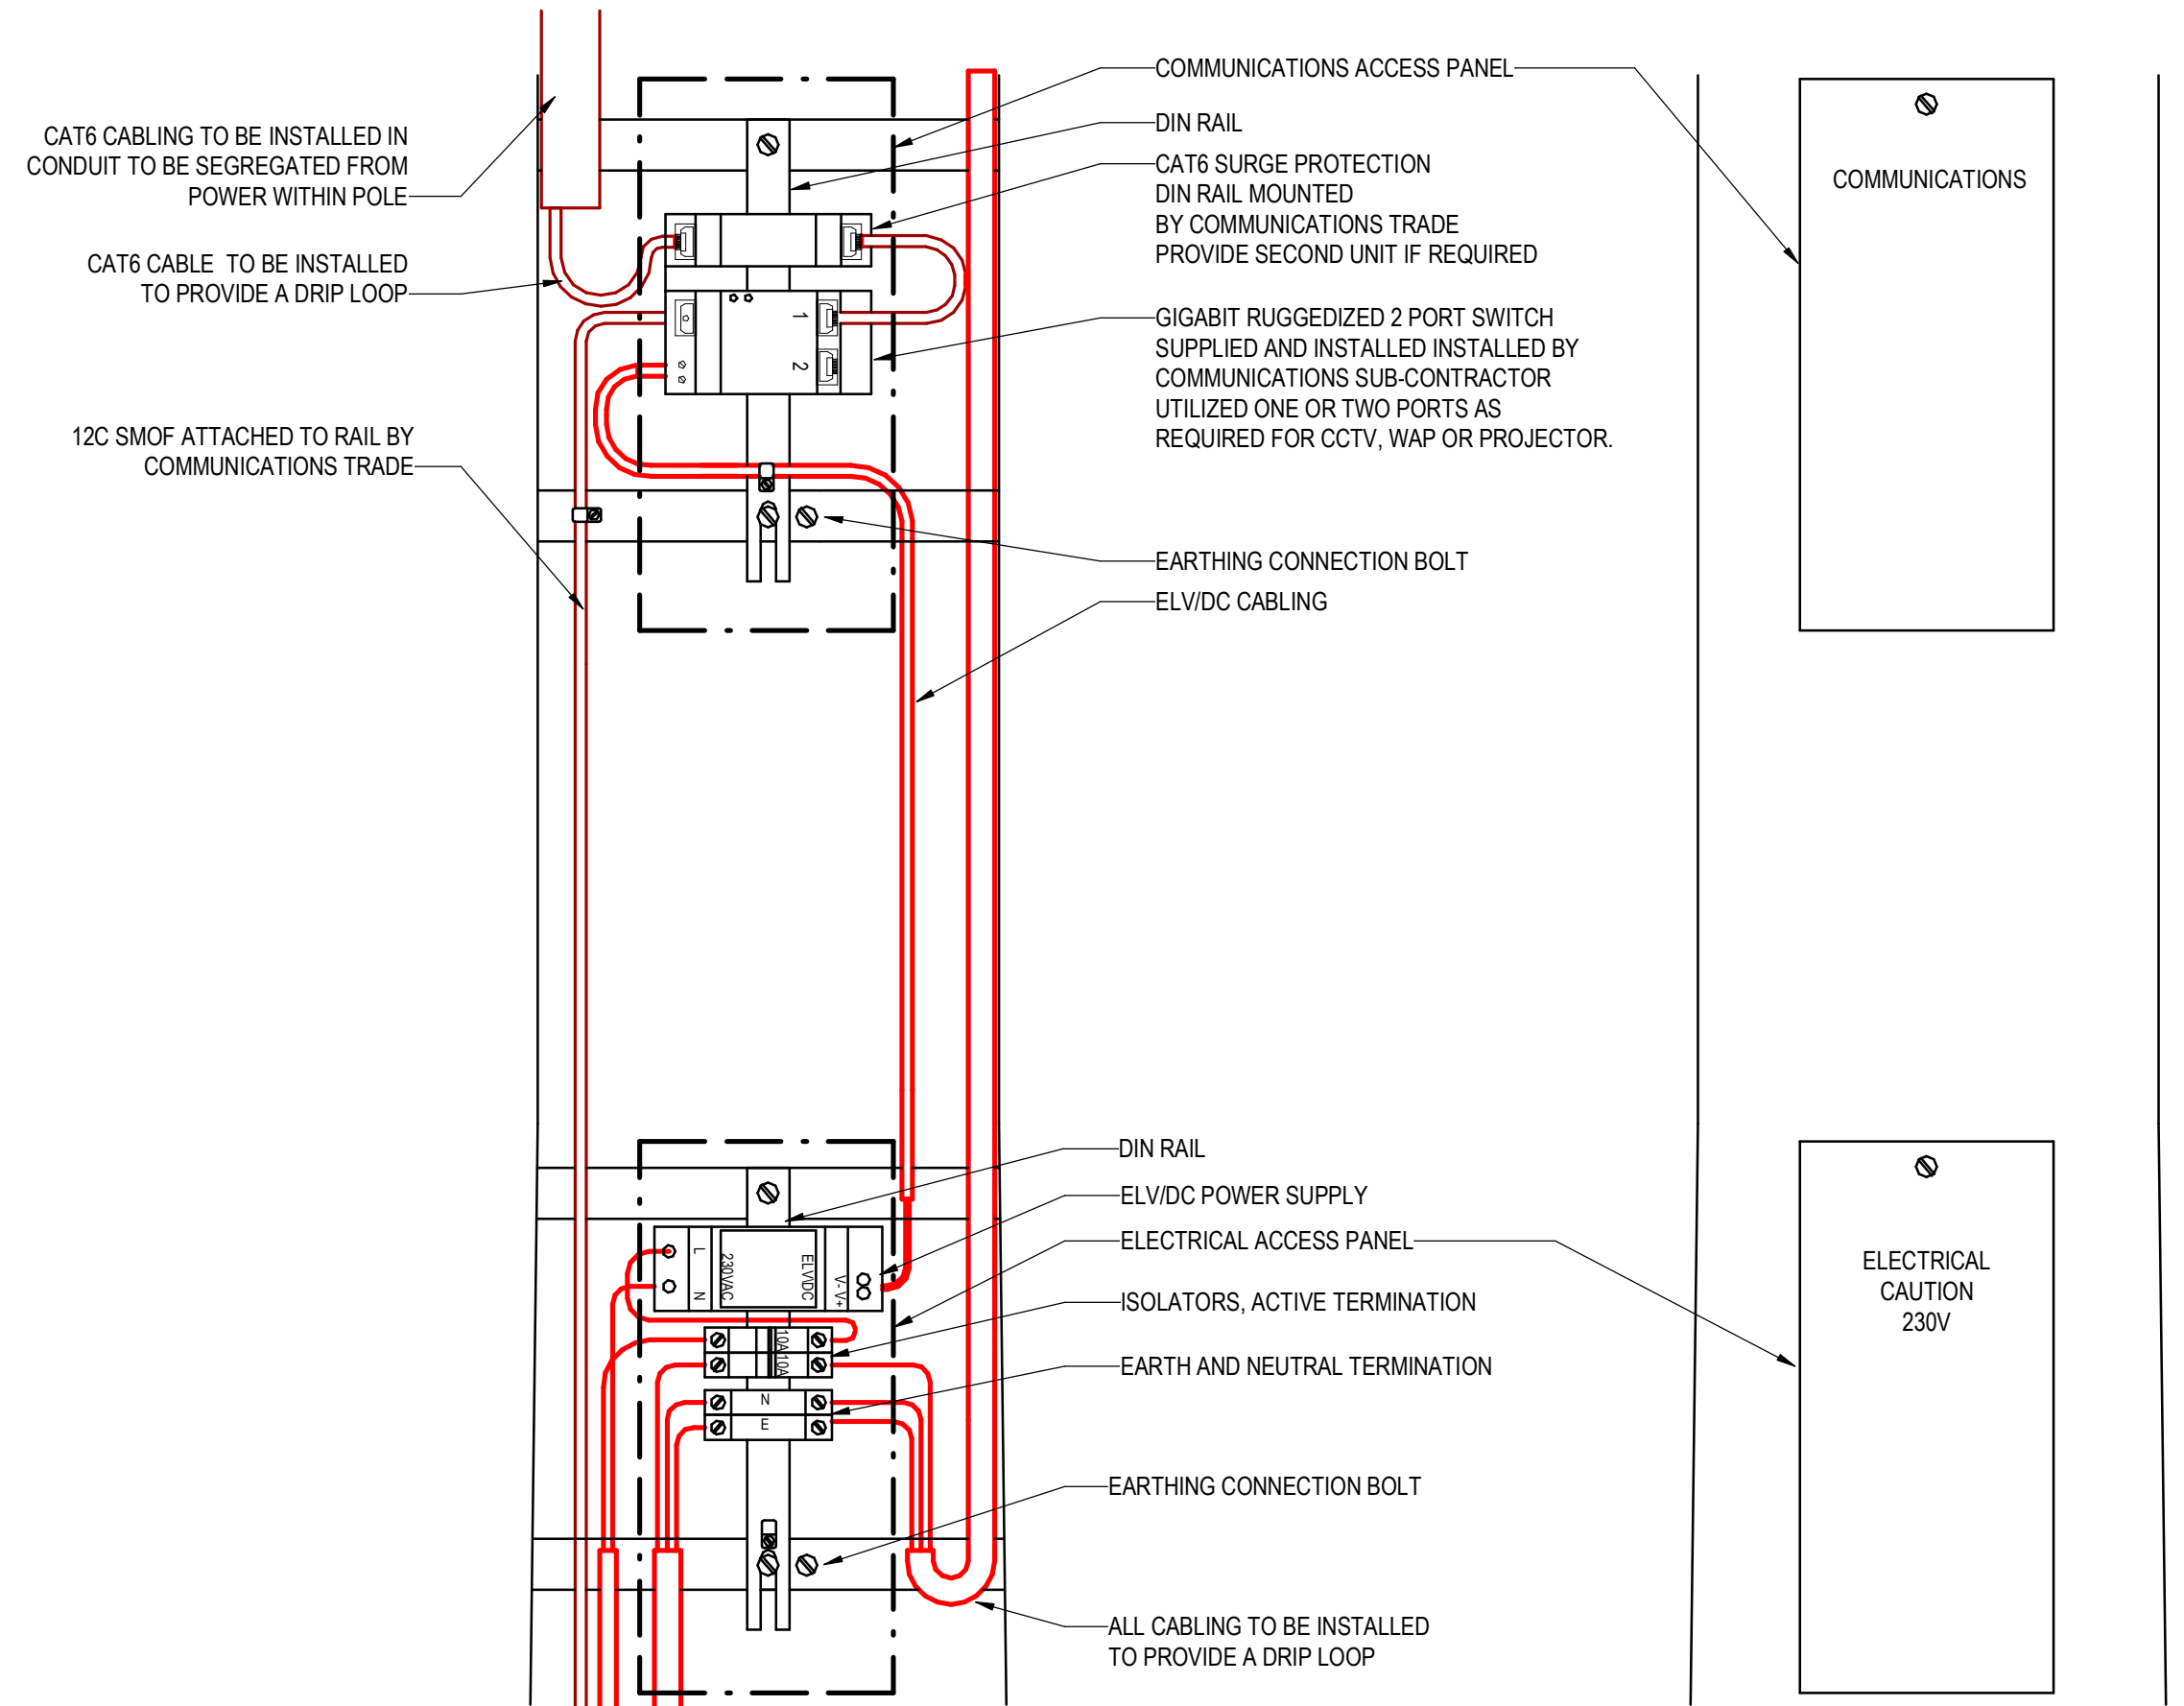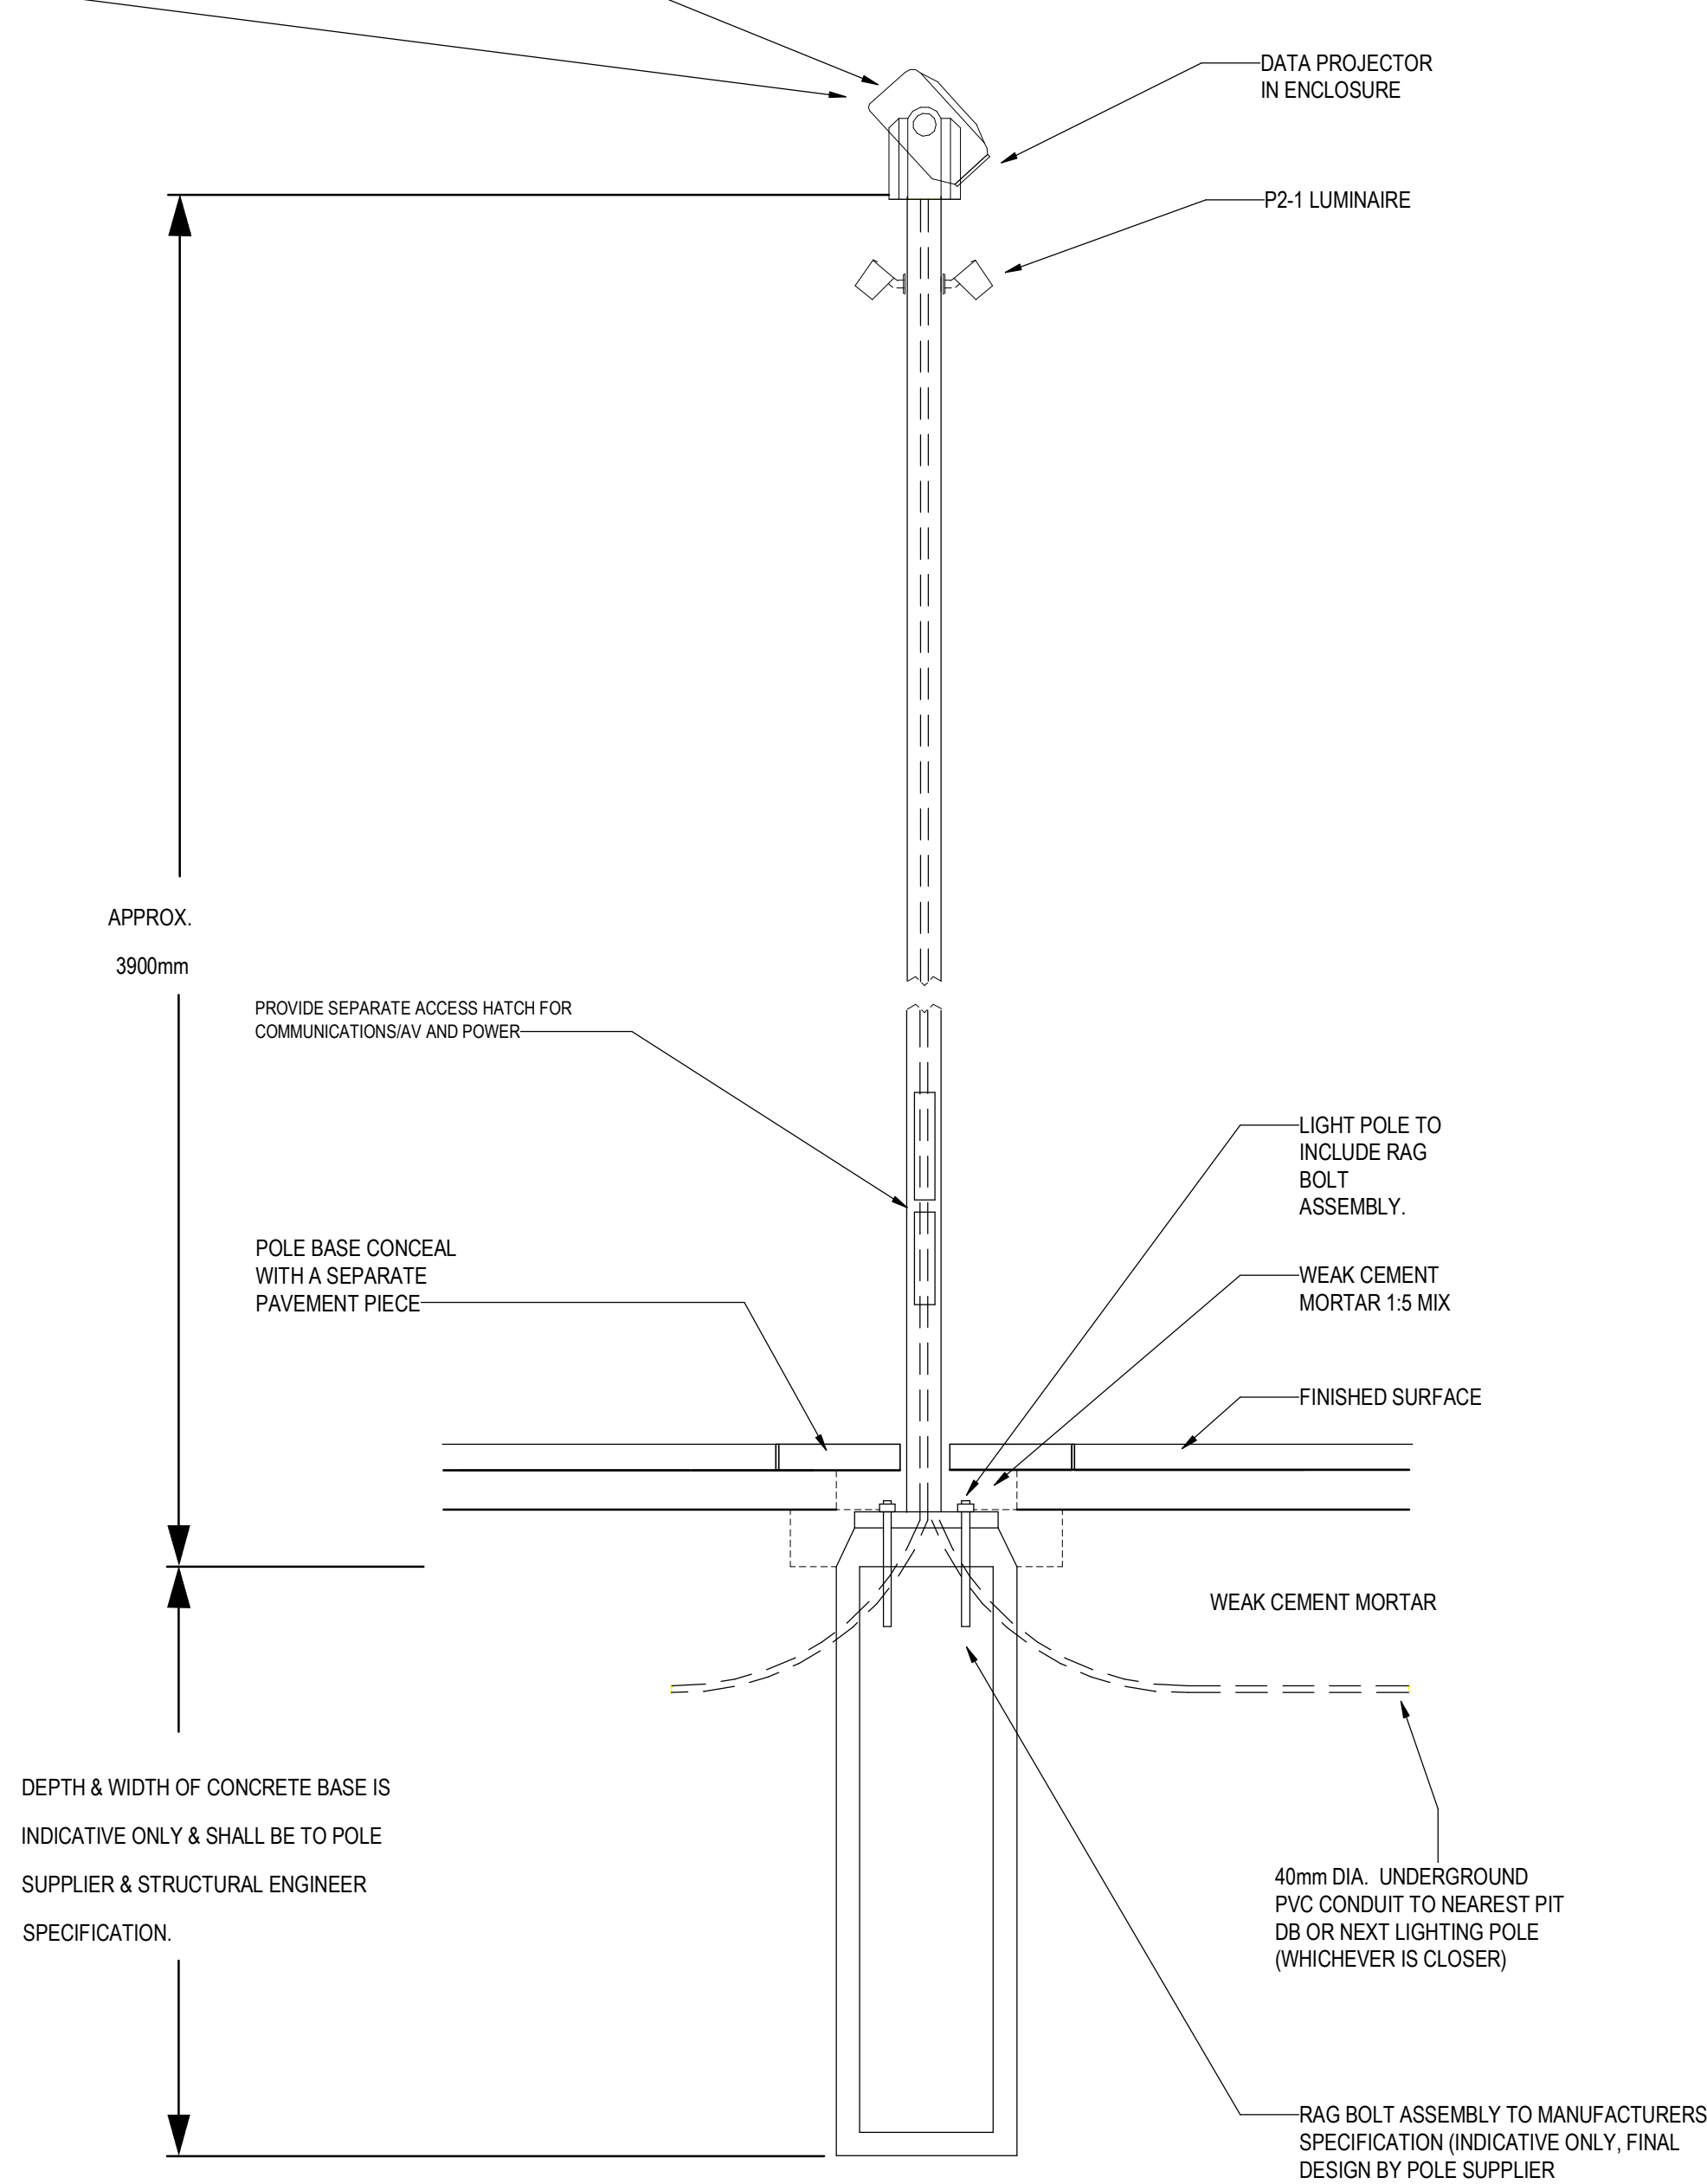

TYPICAL WIRING DETAIL

No.	DATE	REVISION	BY
1	17-05-23	90% DESIGN DEVELOPMENT	VL
2	26-05-23	95% DESIGN DEVELOPMENT CLIENT ISSUE	VL
3	21-07-23	100% DESIGN DEVELOPMENT ISSUE	VL

REFERENCE MODEL RECEIVED DATE:
Architecture Model 1 Received on: 17-07-23

INTEGRAL
Brisbane Design Studio
Level 7, 200 Creek St
Brisbane, QLD 4000
t: +61 7 3917 8888
e: brisbane@integralgroup.com
www.integralgroup.com
Registered: Integral Group Queensland Pty Ltd ABN 91 142 888 773

LUMINA OPEN SPACE

SOUTHPORT, QLD 4215


ELECTRICAL SERVICES
DETAILS

DESIGN
DEVELOPMENT
THE DRAWING SHEET MAY BE REPRODUCED OR COPIED IN PART IN ANY FORM WITHOUT THE WRITTEN APPROVAL OF INTEGRAL GROUP.
CONTRACTOR MUST VISIT SITE BEFORE TENDERING
DRAWING REPRODUCTION
THIS SET OF DOCUMENTS CONTAINS DRAWINGS THAT HAVE BEEN CREATED IN COLOUR. REPRODUCTIONS MUST BE MADE IN COLOUR TO AVOID LOSS OF INFORMATION.
FOR BLACK & WHITE PRINTING PLEASE CONTACT INTEGRAL GROUP FOR A REvised SET OF BLACK & WHITE SPECIFIC DOCUMENTS.

DRAWN	Author	DATE	21-07-23
DESIGN	Designer	SCALE	N.T.S
CHECKED	Checker	PLOT RATIO	1 / A1
APPROVED	Approver	PROJECT No	62.0010071
62.0010071-E-0302			3

NOTES

1. REFER TO DRAWING E-0001 FOR LEGEND AND GENERAL NOTES

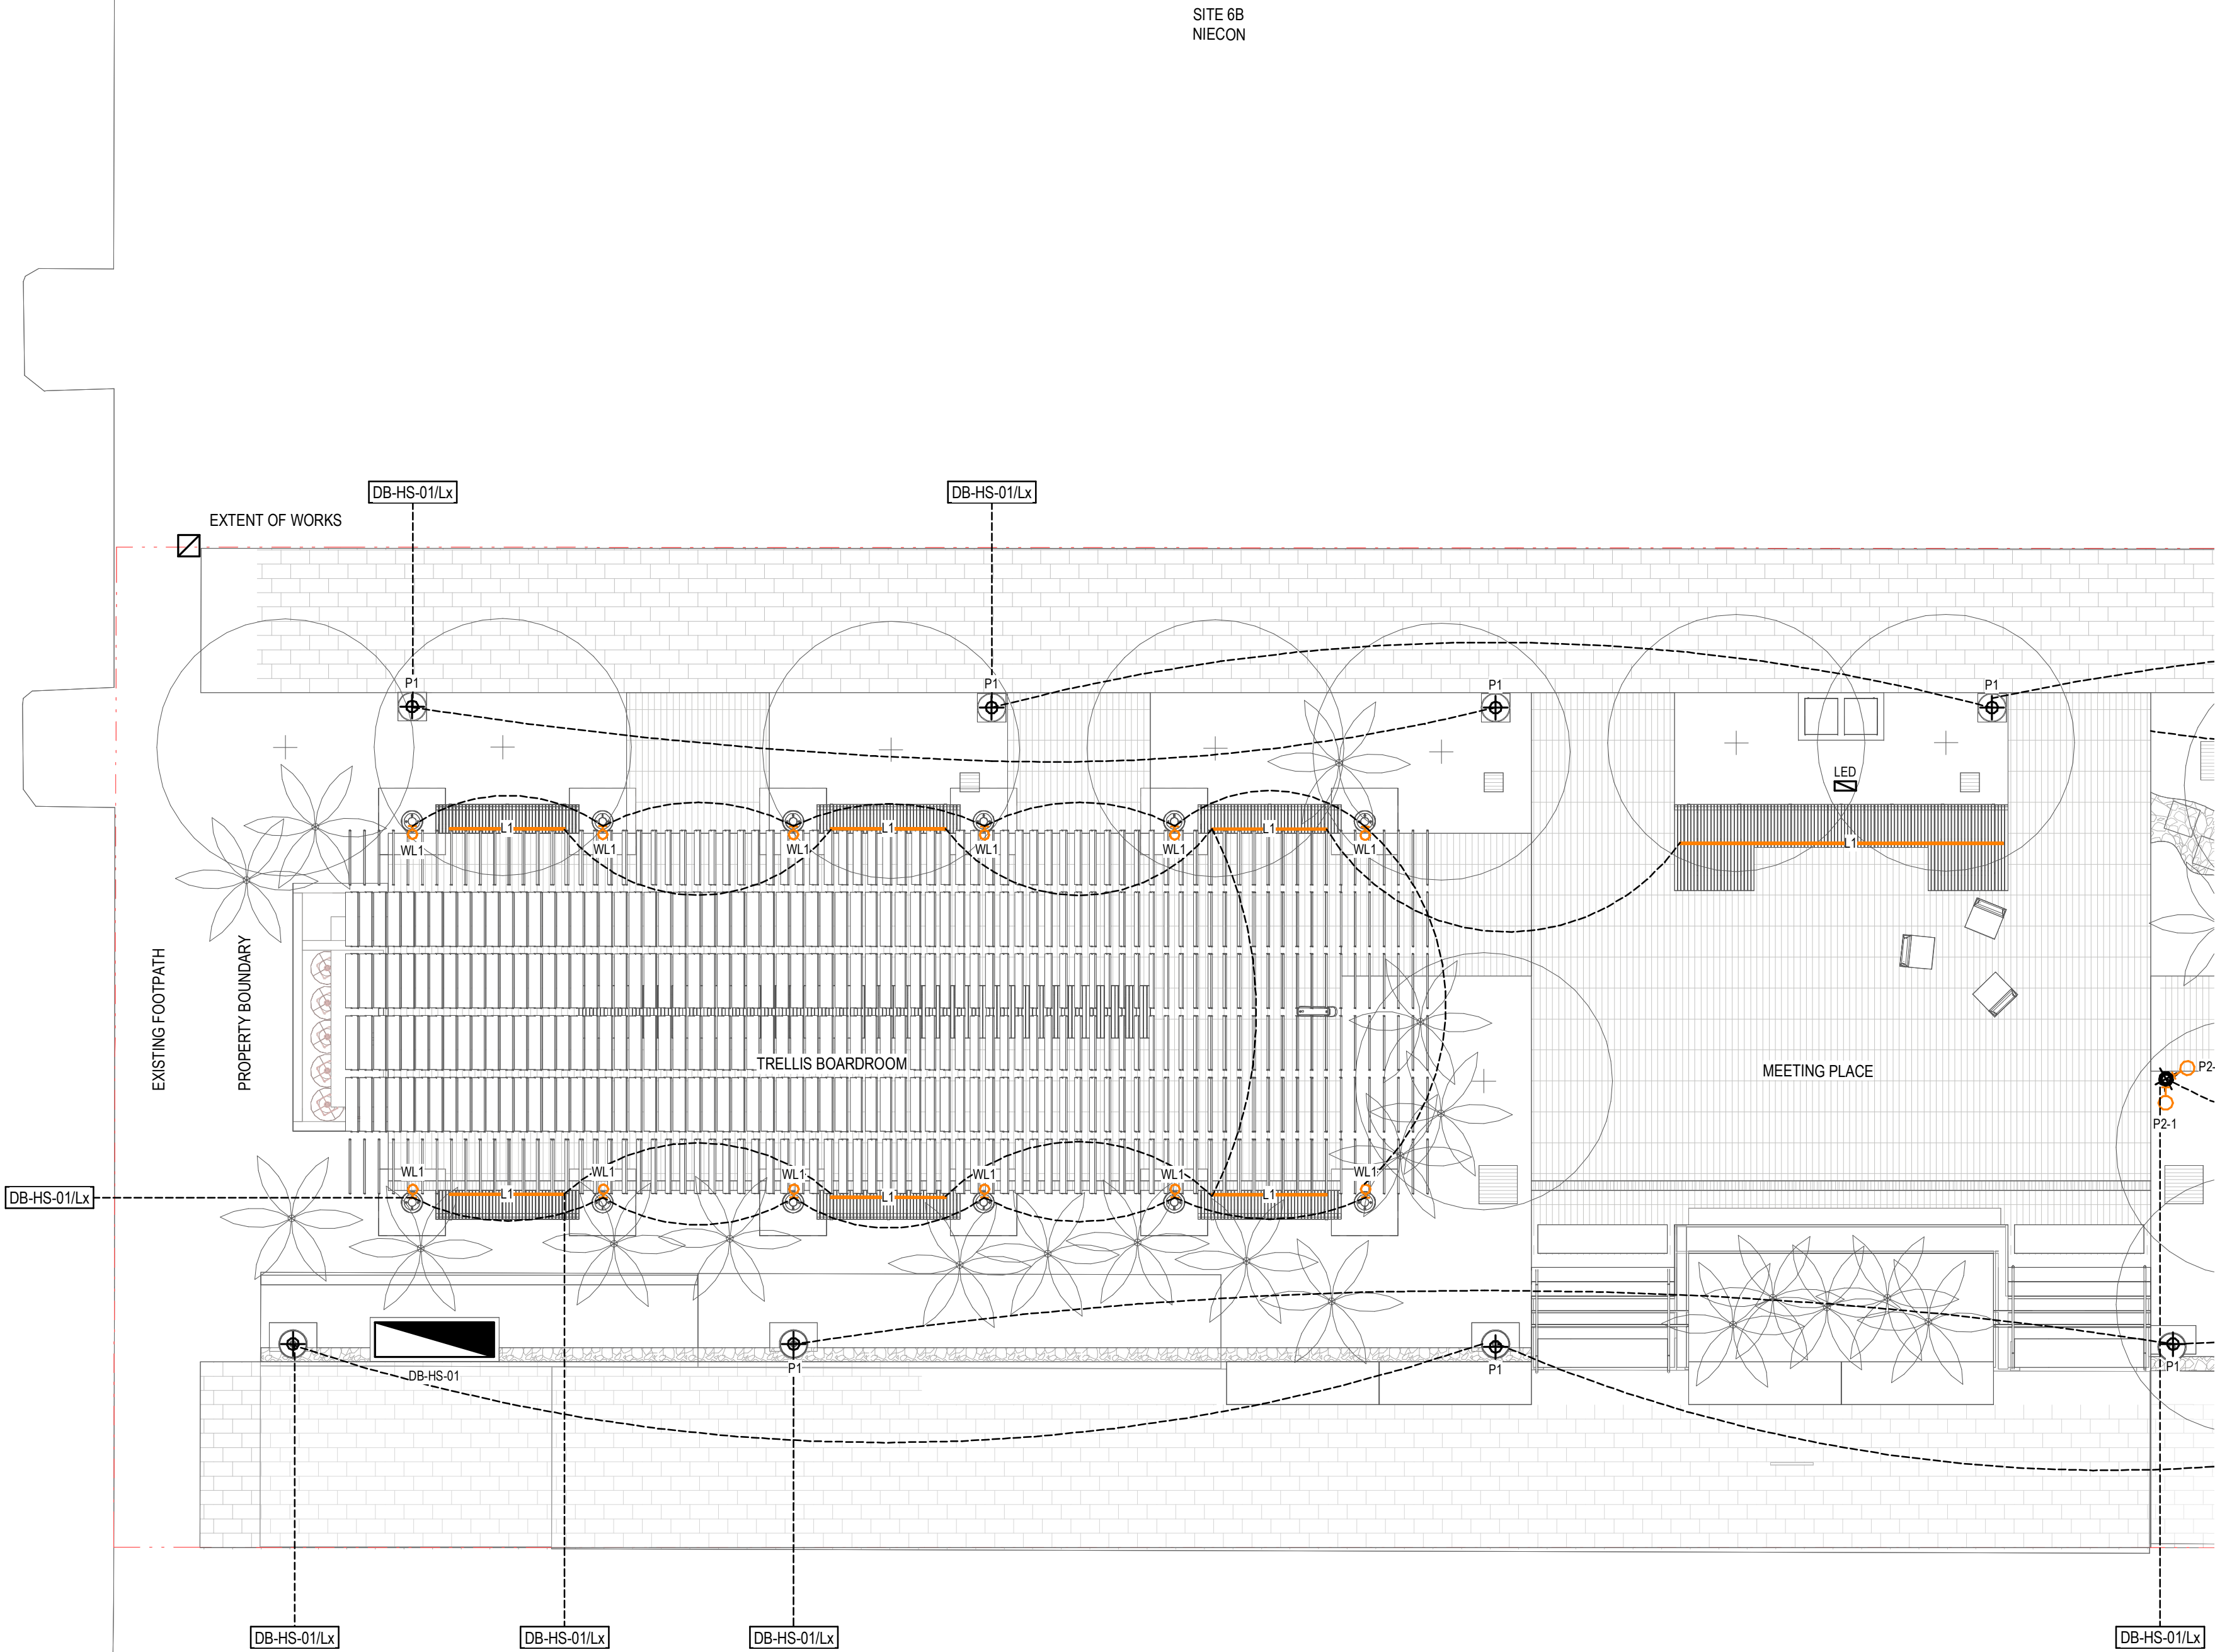


DESIGN DEVELOPMENT

NOT TO BE USED FOR CONSTRUCTION

COPYRIGHT OF THIS DRAWING IS VESTED IN INTROBA. THE DRAWING SHALL NOT BE REPRODUCED OR COPIED IN WHOLE OR IN PART IN ANY FORM WITHOUT THE PRIOR WRITTEN APPROVAL OF INTROBA.

CONTRACTOR MUST VISIT SITE BEFORE TENDERING

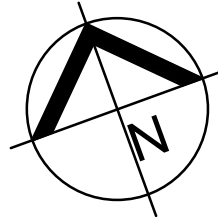

No.	DATE	REVISION	BY
1	17-05-23	90% DESIGN DEVELOPMENT	VL
2	26-05-23	95% DESIGN DEVELOPMENT CLIENT ISSUE	VL
3	21-07-23	100% DESIGN DEVELOPMENT ISSUE	VL

Client:




Economic Development Queensland (EDQ)


Architect:



Hassell
Hassell LTD ABN 24 007 711 435
Level 2, Pier 8/9, 23 Hickson Rd
Sydney NSW 2000 Australia
T +61 2 9101 2000
F +61 2 9101 2100
sydney@hassellstudio.com

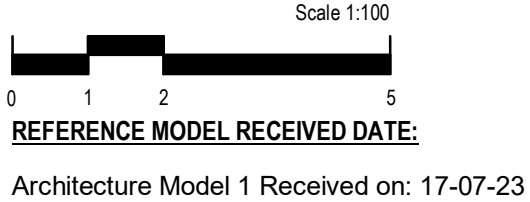

Key Plan:

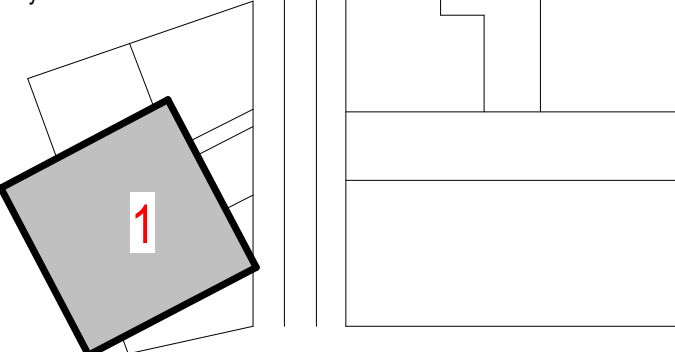

Introba
Brisbane
Level 7, 200 Creek Street
Brisbane, QLD 4000

hello@introba.com
www.introba.com

LUMINA OPEN SPACE
SOUTHPORT, QLD
4215

ELECTRICAL SERVICES
LIGHTING LAYOUT SHEET 1

DRAWING REPRODUCTION
THIS SET OF DOCUMENTS CONTAINS DRAWINGS THAT HAVE BEEN CREATED IN COLOUR. REPRODUCTIONS MUST BE MADE IN COLOUR TO AVOID LOSS OF INFORMATION. FOR BLACK & WHITE PRINTING PLEASE CONTACT INTROBA FOR A REVISED SET OF BLACK & WHITE SPECIFIC DOCUMENTS.

DRAWN	CS	DATE	21-07-23
DESIGN	DDS	SCALE	1 : 100 @A1
CHECKED	-	PLOT RATIO	1 / A1
APPROVED	-	PROJECT No	62.0010071

62.0010071-E-1001

3

NOTES


1. REFER TO DRAWING E-0001 FOR LEGEND AND GENERAL NOTES

FOR CONTINUATION REFER TO DRAWING E-1001

FOR CONTINUATION REFER TO DRAWING E-1003

DESIGN DEVELOPMENT

NOT TO BE USED FOR CONSTRUCTION
COPYRIGHT OF THIS DRAWING IS VESTED IN INTROBA.
THE DRAWING SHALL NOT BE REPRODUCED OR COPIED IN WHOLE OR IN PART IN ANY
FORM WITHOUT THE PRIOR WRITTEN APPROVAL OF INTROBA.
CONTRACTOR MUST VISIT SITE BEFORE TENDERING

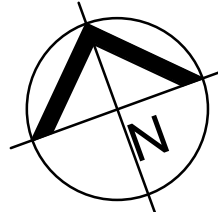

No.	DATE	REVISION	BY
1	17-05-23	90% DESIGN DEVELOPMENT	VL
2	26-05-23	95% DESIGN DEVELOPMENT CLIENT ISSUE	VL
3	21-07-23	100% DESIGN DEVELOPMENT ISSUE	VL

Client:




Economic Development Queensland (EDQ)

Architect:




Hassell

Hassell LTD ABN 24 007 711 435
Level2, Pier 8/9,23 Hickson Rd
Sydney NSW 2000 Australia
T +61 2 9101 2000
F +61 2 9101 2100
sydney@hassellstudio.com

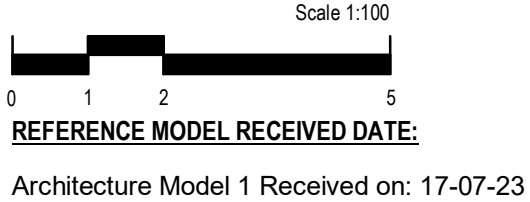

Key Plan:

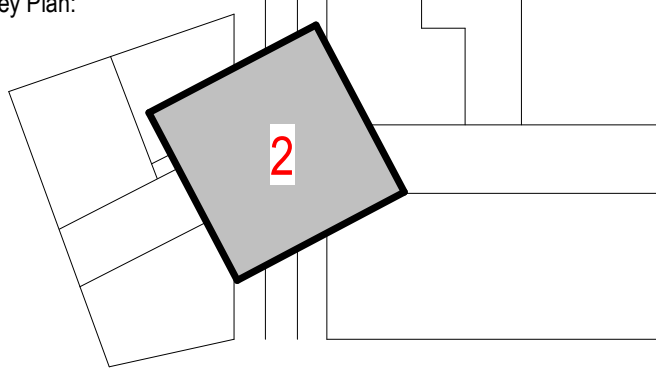

Brisbane
Level 7, 200 Creek Street
Brisbane, QLD 4000

hello@introba.com
www.introba.com

LUMINA OPEN SPACE

SOUTHPORT, QLD 4215

**ELECTRICAL SERVICES
LIGHTING LAYOUT SHEET 2**

DRAWING REPRODUCTION



THIS SET OF DOCUMENTS CONTAINS DRAWINGS THAT HAVE BEEN CREATED IN COLOUR.
REPRODUCTIONS MUST BE MADE IN COLOUR TO AVOID LOSS OF INFORMATION.
FOR BLACK & WHITE PRINTING PLEASE CONTACT INTROBA FOR A REVISED SET OF
BLACK & WHITE SPECIFIC DOCUMENTS.

DRAWN	CS	DATE	21-07-23
DESIGN	DDS	SCALE	1 : 100 @A1
CHECKED	-	PLOT RATIO	1 / A1
APPROVED	-	PROJECT No	62.0010071

62.0010071-E-1002

3

FOR CONTINUATION REFER TO DRAWING E-1002

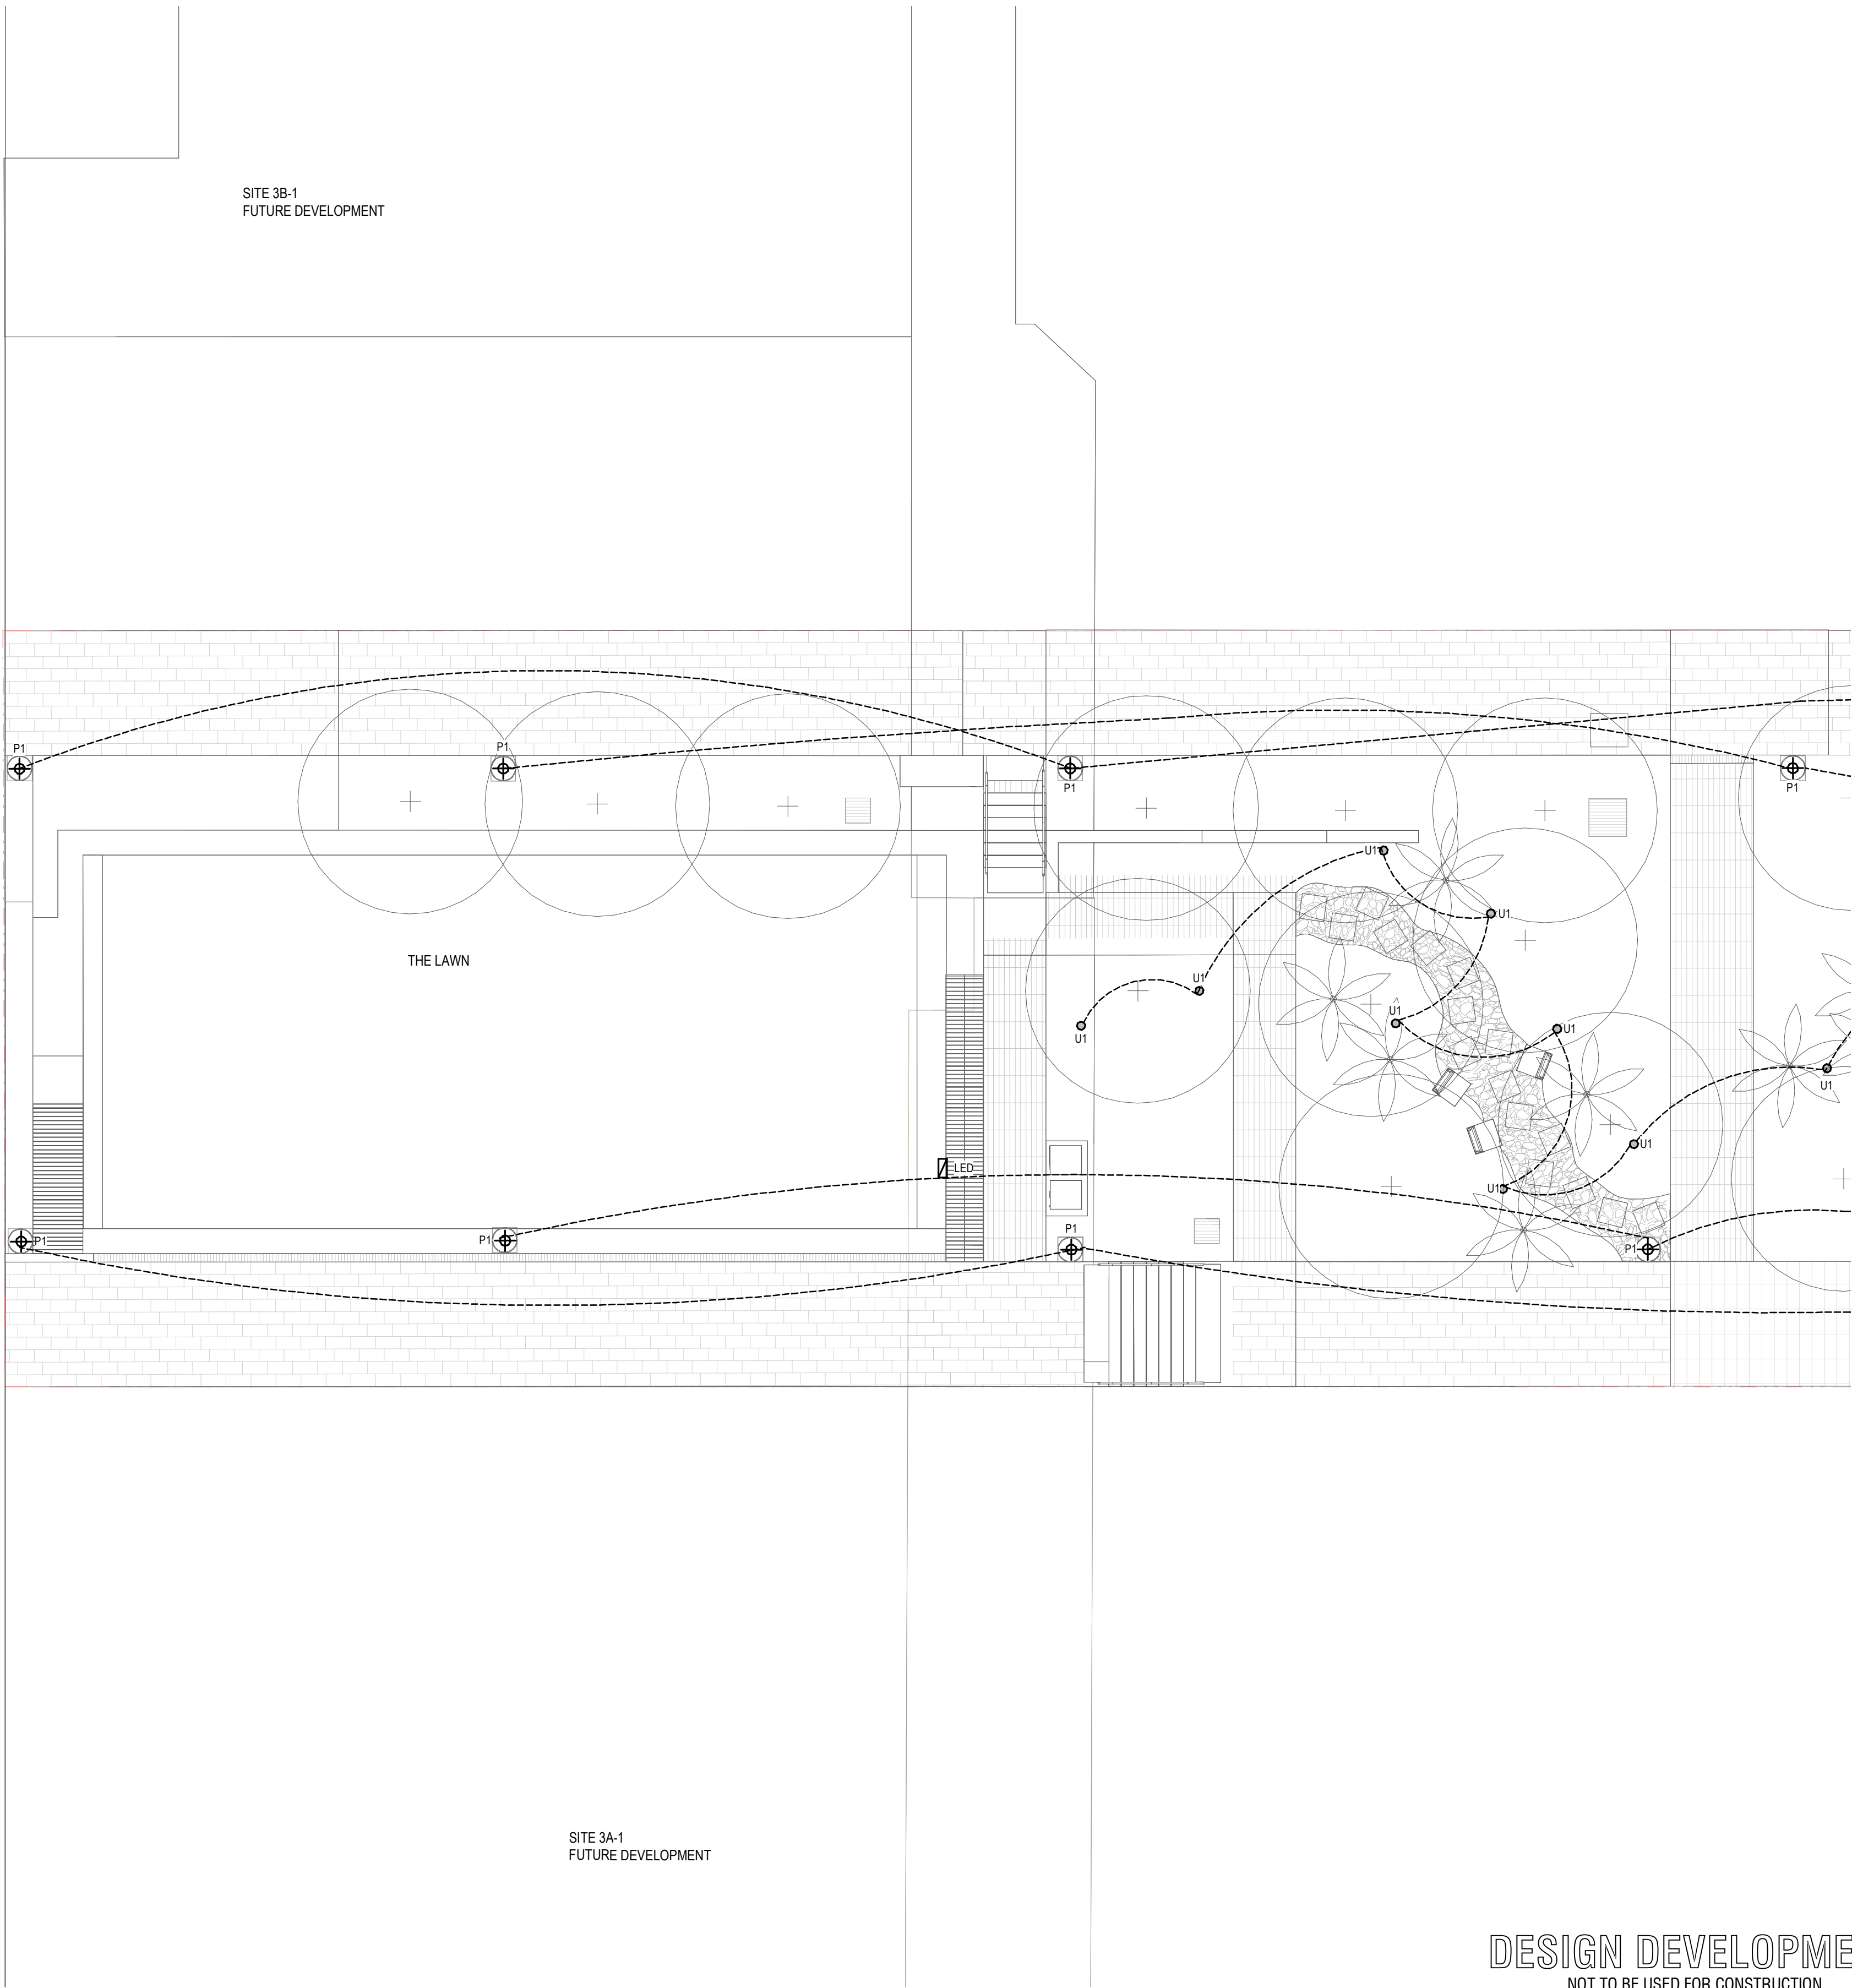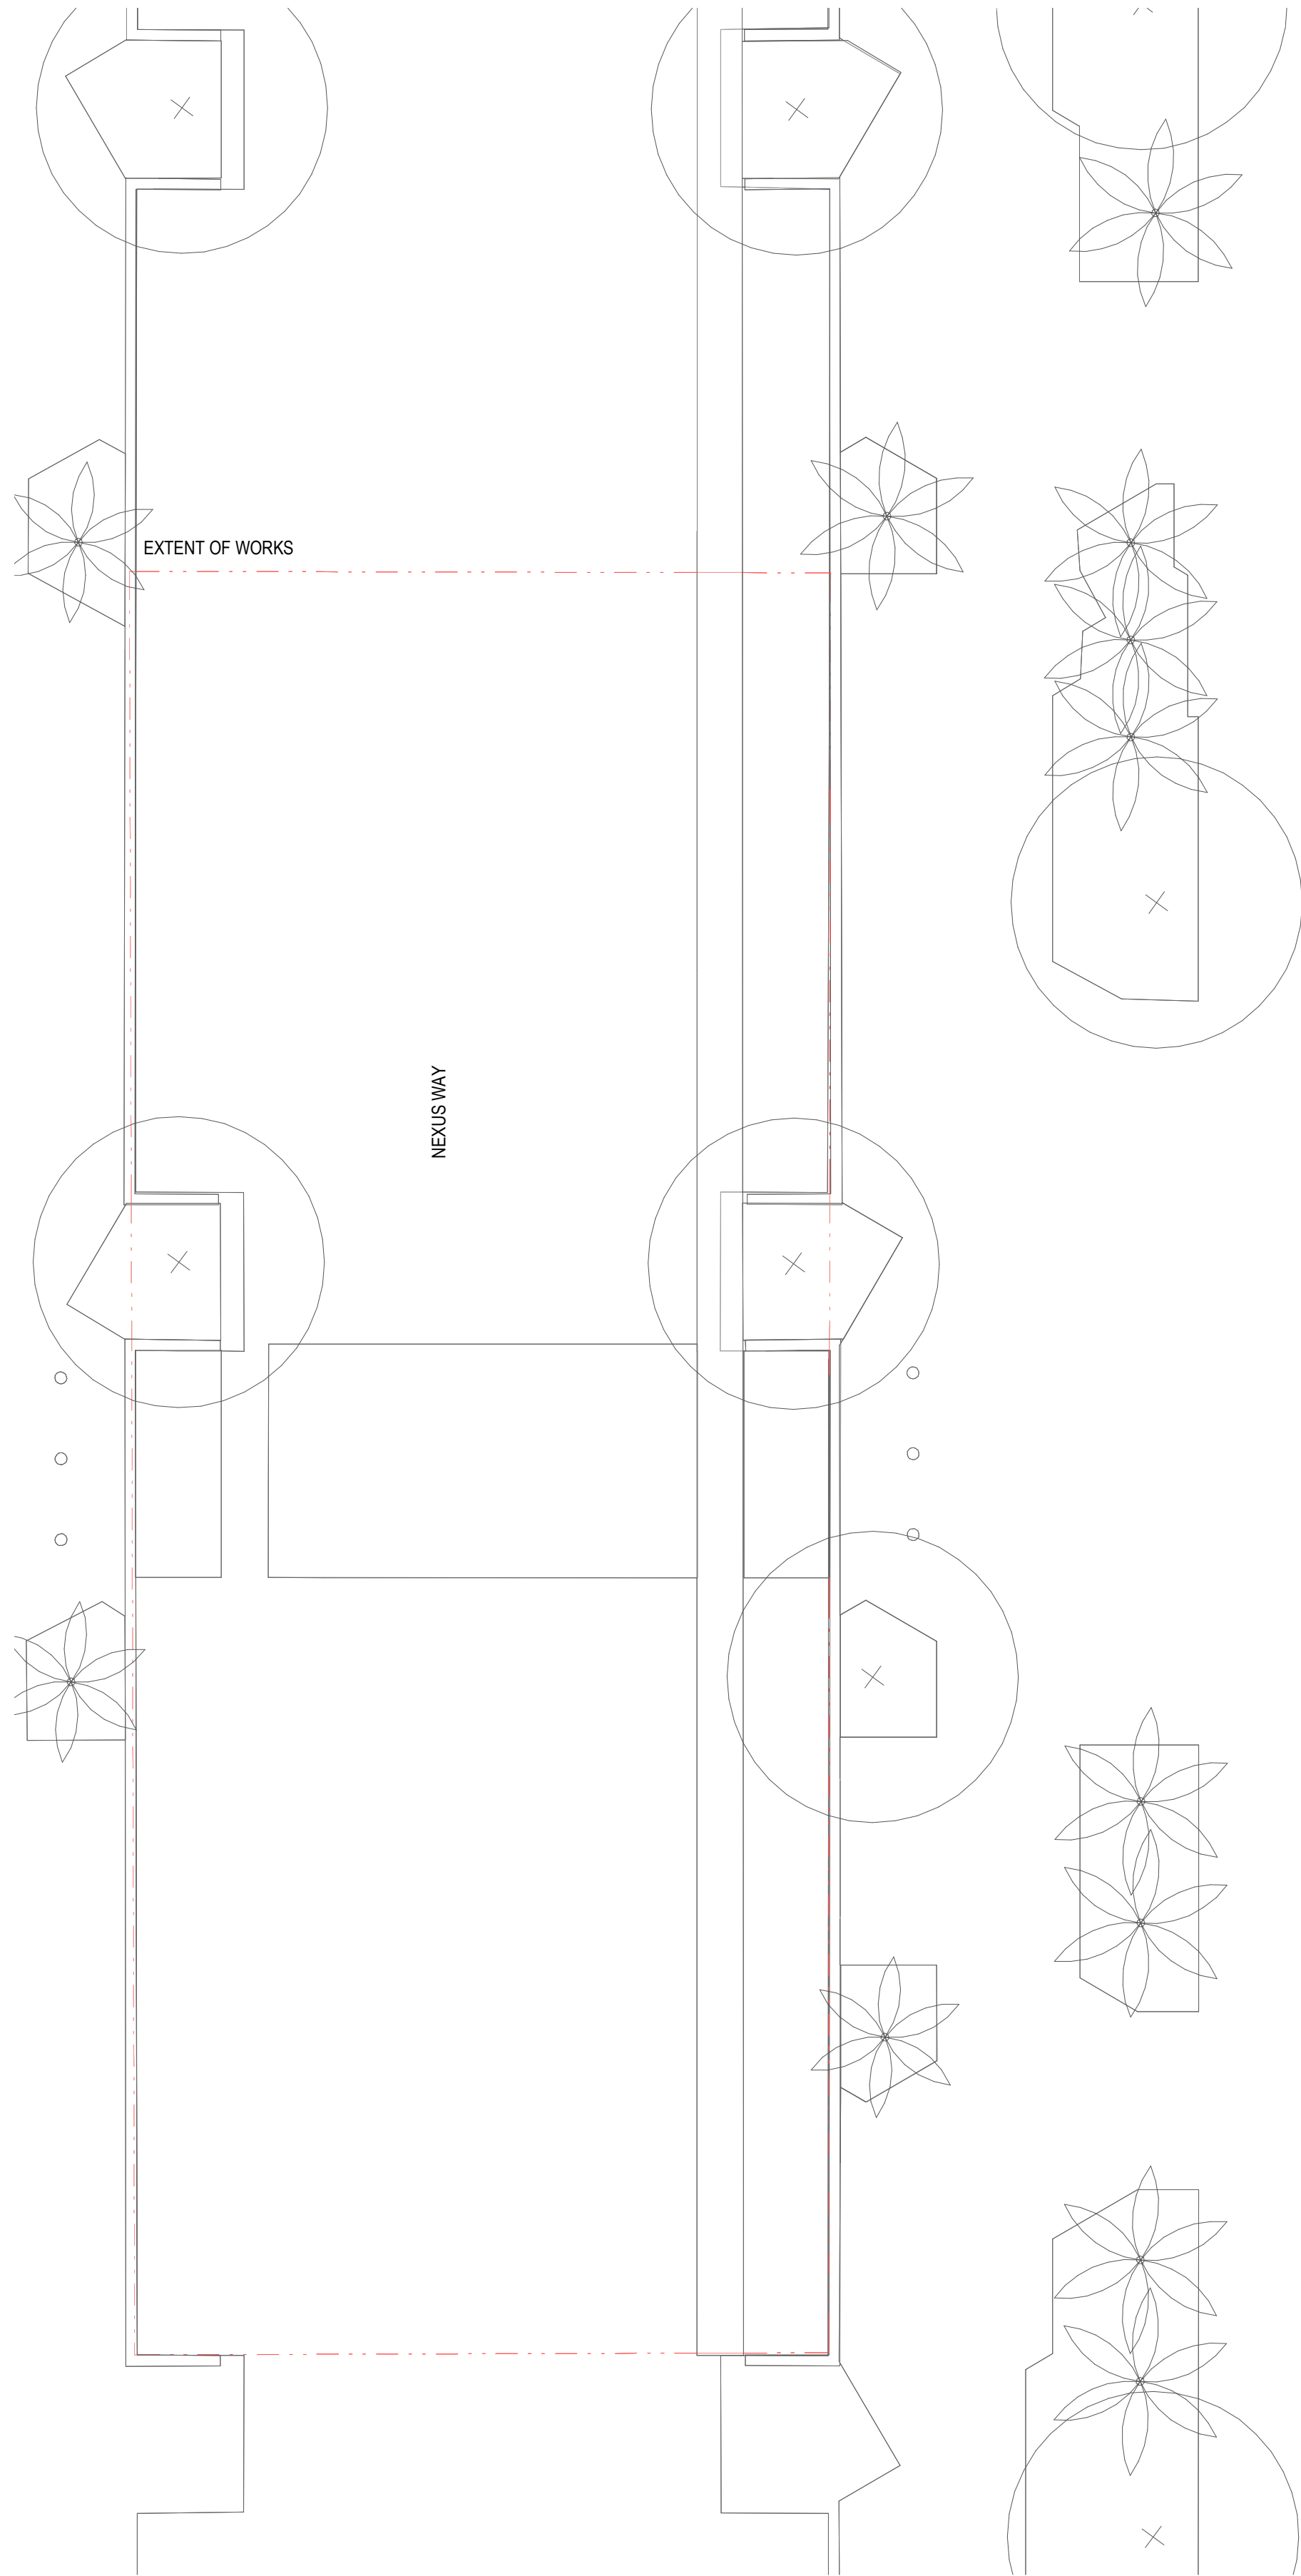

FOR CONTINUATION REFER TO DRAWING E-1004


DESIGN DEVELOPMENT

NOT TO BE USED FOR CONSTRUCTION

COPYRIGHT OF THIS DRAWING IS VESTED IN INTROBA.

THE DRAWING SHALL NOT BE REPRODUCED OR COPIED IN WHOLE OR IN PART IN ANY FORM, WITHOUT THE PRIOR WRITTEN APPROVAL OF INTROBA.

CONTRACTOR MUST VISIT SITE BEFORE TENDERING

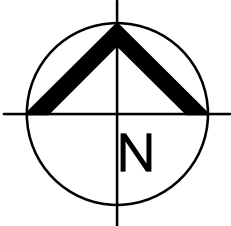

No.	DATE	REVISION	BY
1	17-05-23	90% DESIGN DEVELOPMENT	VL
2	26-05-23	95% DESIGN DEVELOPMENT CLIENT ISSUE	VL
3	21-07-23	100% DESIGN DEVELOPMENT ISSUE	VL

Client:



Queensland
Government

Economic Development Queensland (EDQ)


Architect:



Hassell

Hassell LTD ABN 24 007 711 435
Level2, Pier 8/9,23 Hickson Rd
Sydney NSW 2000 Australia
T +61 2 9101 2000
F +61 2 9101 2100
sydney@hassellstudio.com

 
Scale 1:100



REFERENCE MODEL RECEIVED DATE:

Architecture Model 1 Received on: 17-07-23

Key Plan:

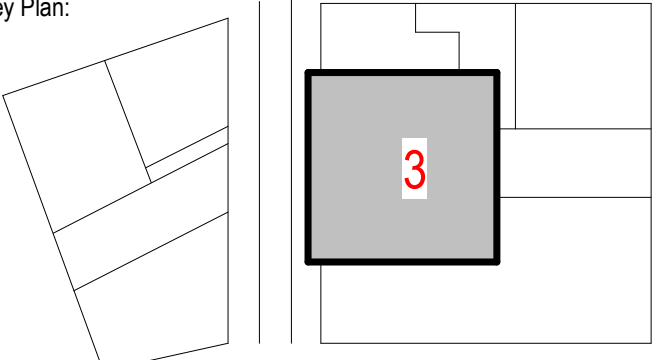

**Introba**

Brisbane
Level 7, 200 Creek Street
Brisbane, QLD 4000

hello@introba.com
www.introba.com

LUMINA OPEN SPACE


SOUTHPORT, QLD 4215

ELECTRICAL SERVICES
LIGHTING LAYOUT SHEET 3

DRAWING REPRODUCTION

THIS SET OF DOCUMENTS CONTAINS DRAWINGS THAT HAVE BEEN CREATED IN COLOUR. REPRODUCTIONS MUST BE MADE IN COLOUR TO AVOID LOSS OF INFORMATION. FOR BLACK & WHITE PRINTING PLEASE CONTACT INTROBA FOR A REVISED SET OF BLACK & WHITE SPECIFIC DOCUMENTS.

DRAWN	CS	DATE	21-07-23
DESIGN	DDS	SCALE	1 : 100 @A1
CHECKED	-	PLOT RATIO	1 / A1
APPROVED	-	PROJECT No	62.0010071
62.0010071-E-1003			3

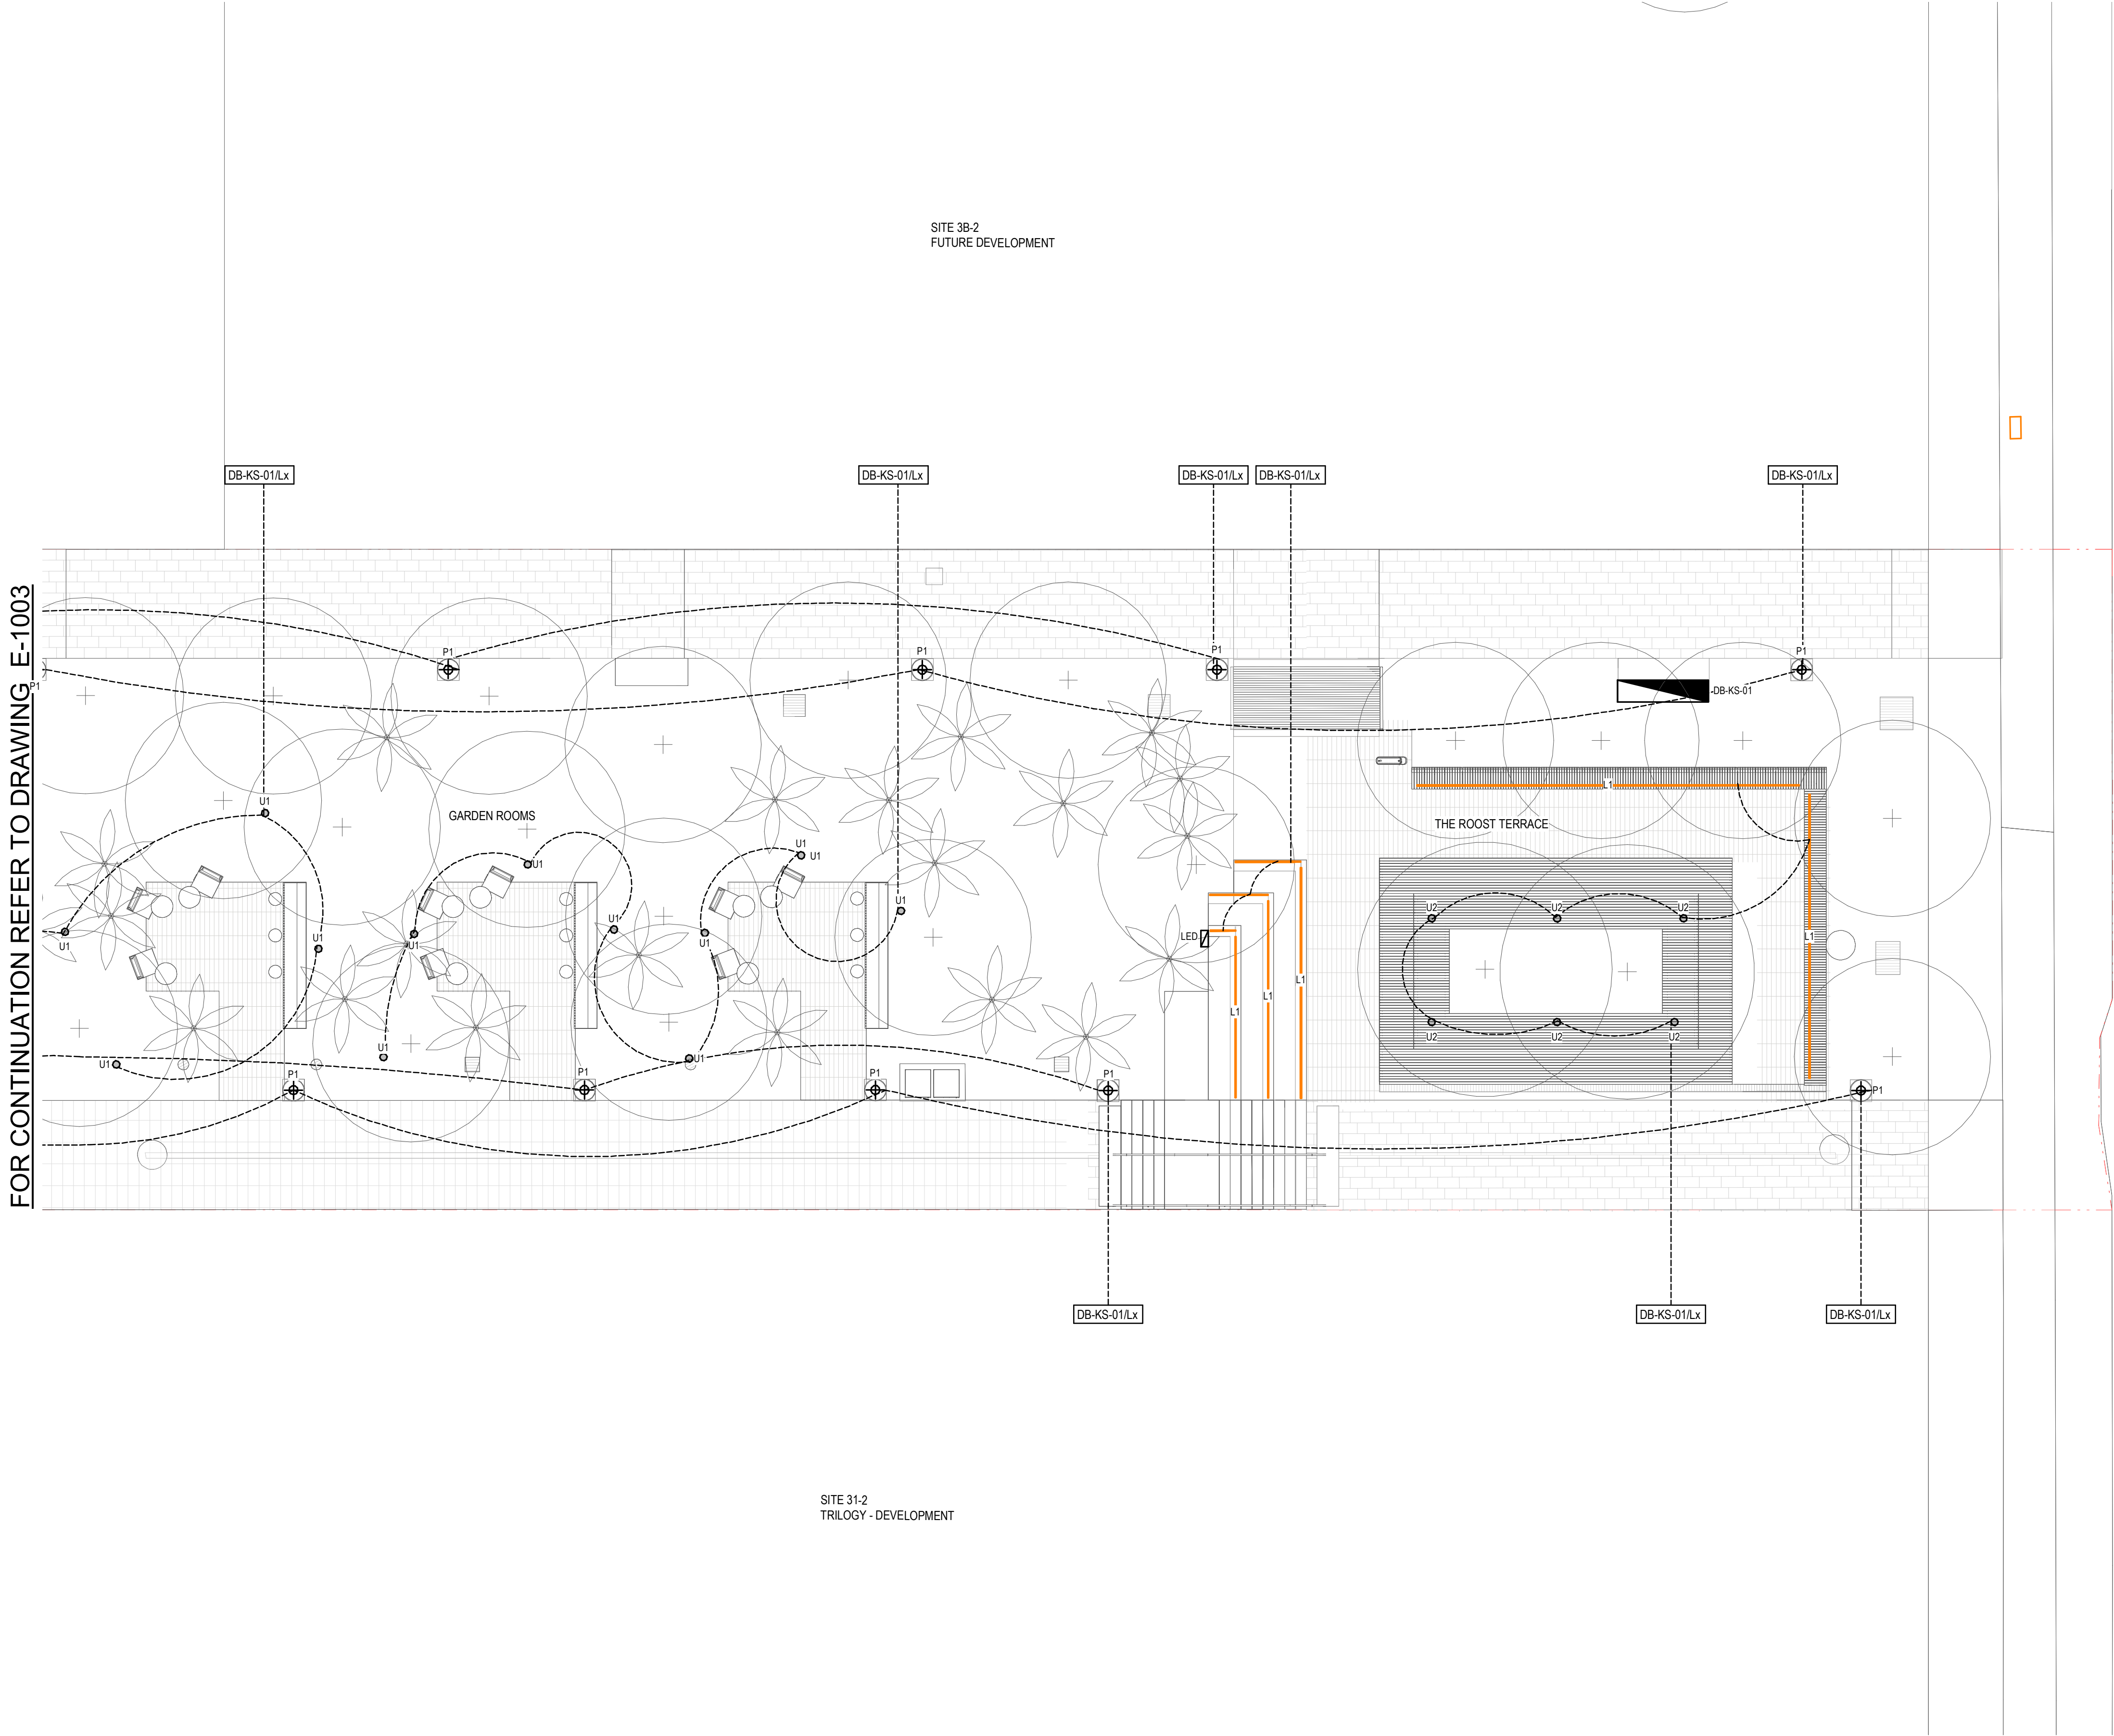


DESIGN DEVELOPMENT

NOT TO BE USED FOR CONSTRUCTION

COPYRIGHT OF THIS DRAWING IS VESTED IN INTROBA.
THE DRAWING SHALL NOT BE REPRODUCED OR COPIED IN WHOLE OR IN PART IN ANY
FORM WITHOUT THE PRIOR WRITTEN APPROVAL OF INTROBA.

CONTRACTOR MUST VISIT SITE BEFORE TENDERING

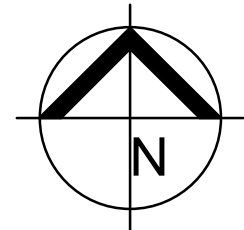

No.	DATE	REVISION	BY
1	17-05-23	90% DESIGN DEVELOPMENT	VL
2	26-05-23	95% DESIGN DEVELOPMENT CLIENT ISSUE	VL
3	21-07-23	100% DESIGN DEVELOPMENT ISSUE	VL

Client:



Economic Development Queensland (EDQ)

Architect:



Hassell


Hassell LTD ABN 24 007 711 435
Level2, Pier 8/9,23 Hickson Rd
Sydney NSW 2000 Australia
T +61 2 9101 2000
F +61 2 9101 2100
sydney@hassellstudio.com



REFERENCE MODEL RECEIVED DATE:

Architecture Model 1 Received on: 17-07-23

Key Plan:

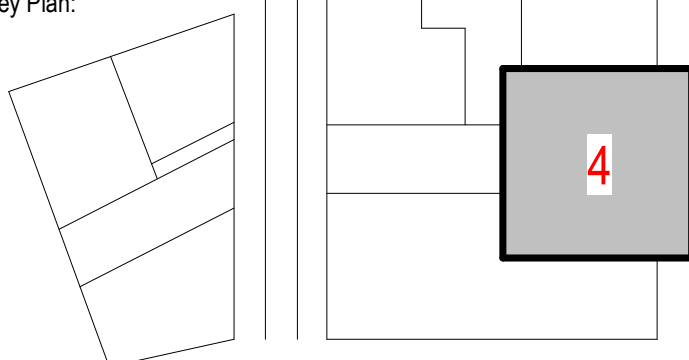

Brisbane
Level 7, 200 Creek Street
Brisbane, QLD 4000

hello@introba.com
www.introba.com

LUMINA OPEN
SPACE

SOUTHPORT, QLD
4215

ELECTRICAL SERVICES
LIGHTING LAYOUT SHEET 4

DRAWING REPRODUCTION

THIS SET OF DOCUMENTS CONTAINS DRAWINGS THAT HAVE BEEN CREATED IN COLOUR.
REPRODUCTIONS MUST BE MADE IN COLOUR TO AVOID LOSS OF INFORMATION.
FOR BLACK & WHITE PRINTING PLEASE CONTACT INTROBA FOR A REVISED SET OF
BLACK & WHITE SPECIFIC DOCUMENTS.


DRAWN	CS	DATE	21-07-23
DESIGN	DDS	SCALE	1 : 100 @A1
CHECKED	-	PLOT RATIO	1 / A1
APPROVED	-	PROJECT No	62.0010071

62.0010071-E-1004

3

NOTES

1. REFER TO DRAWING E-0001 FOR LEGEND AND GENERAL NOTES

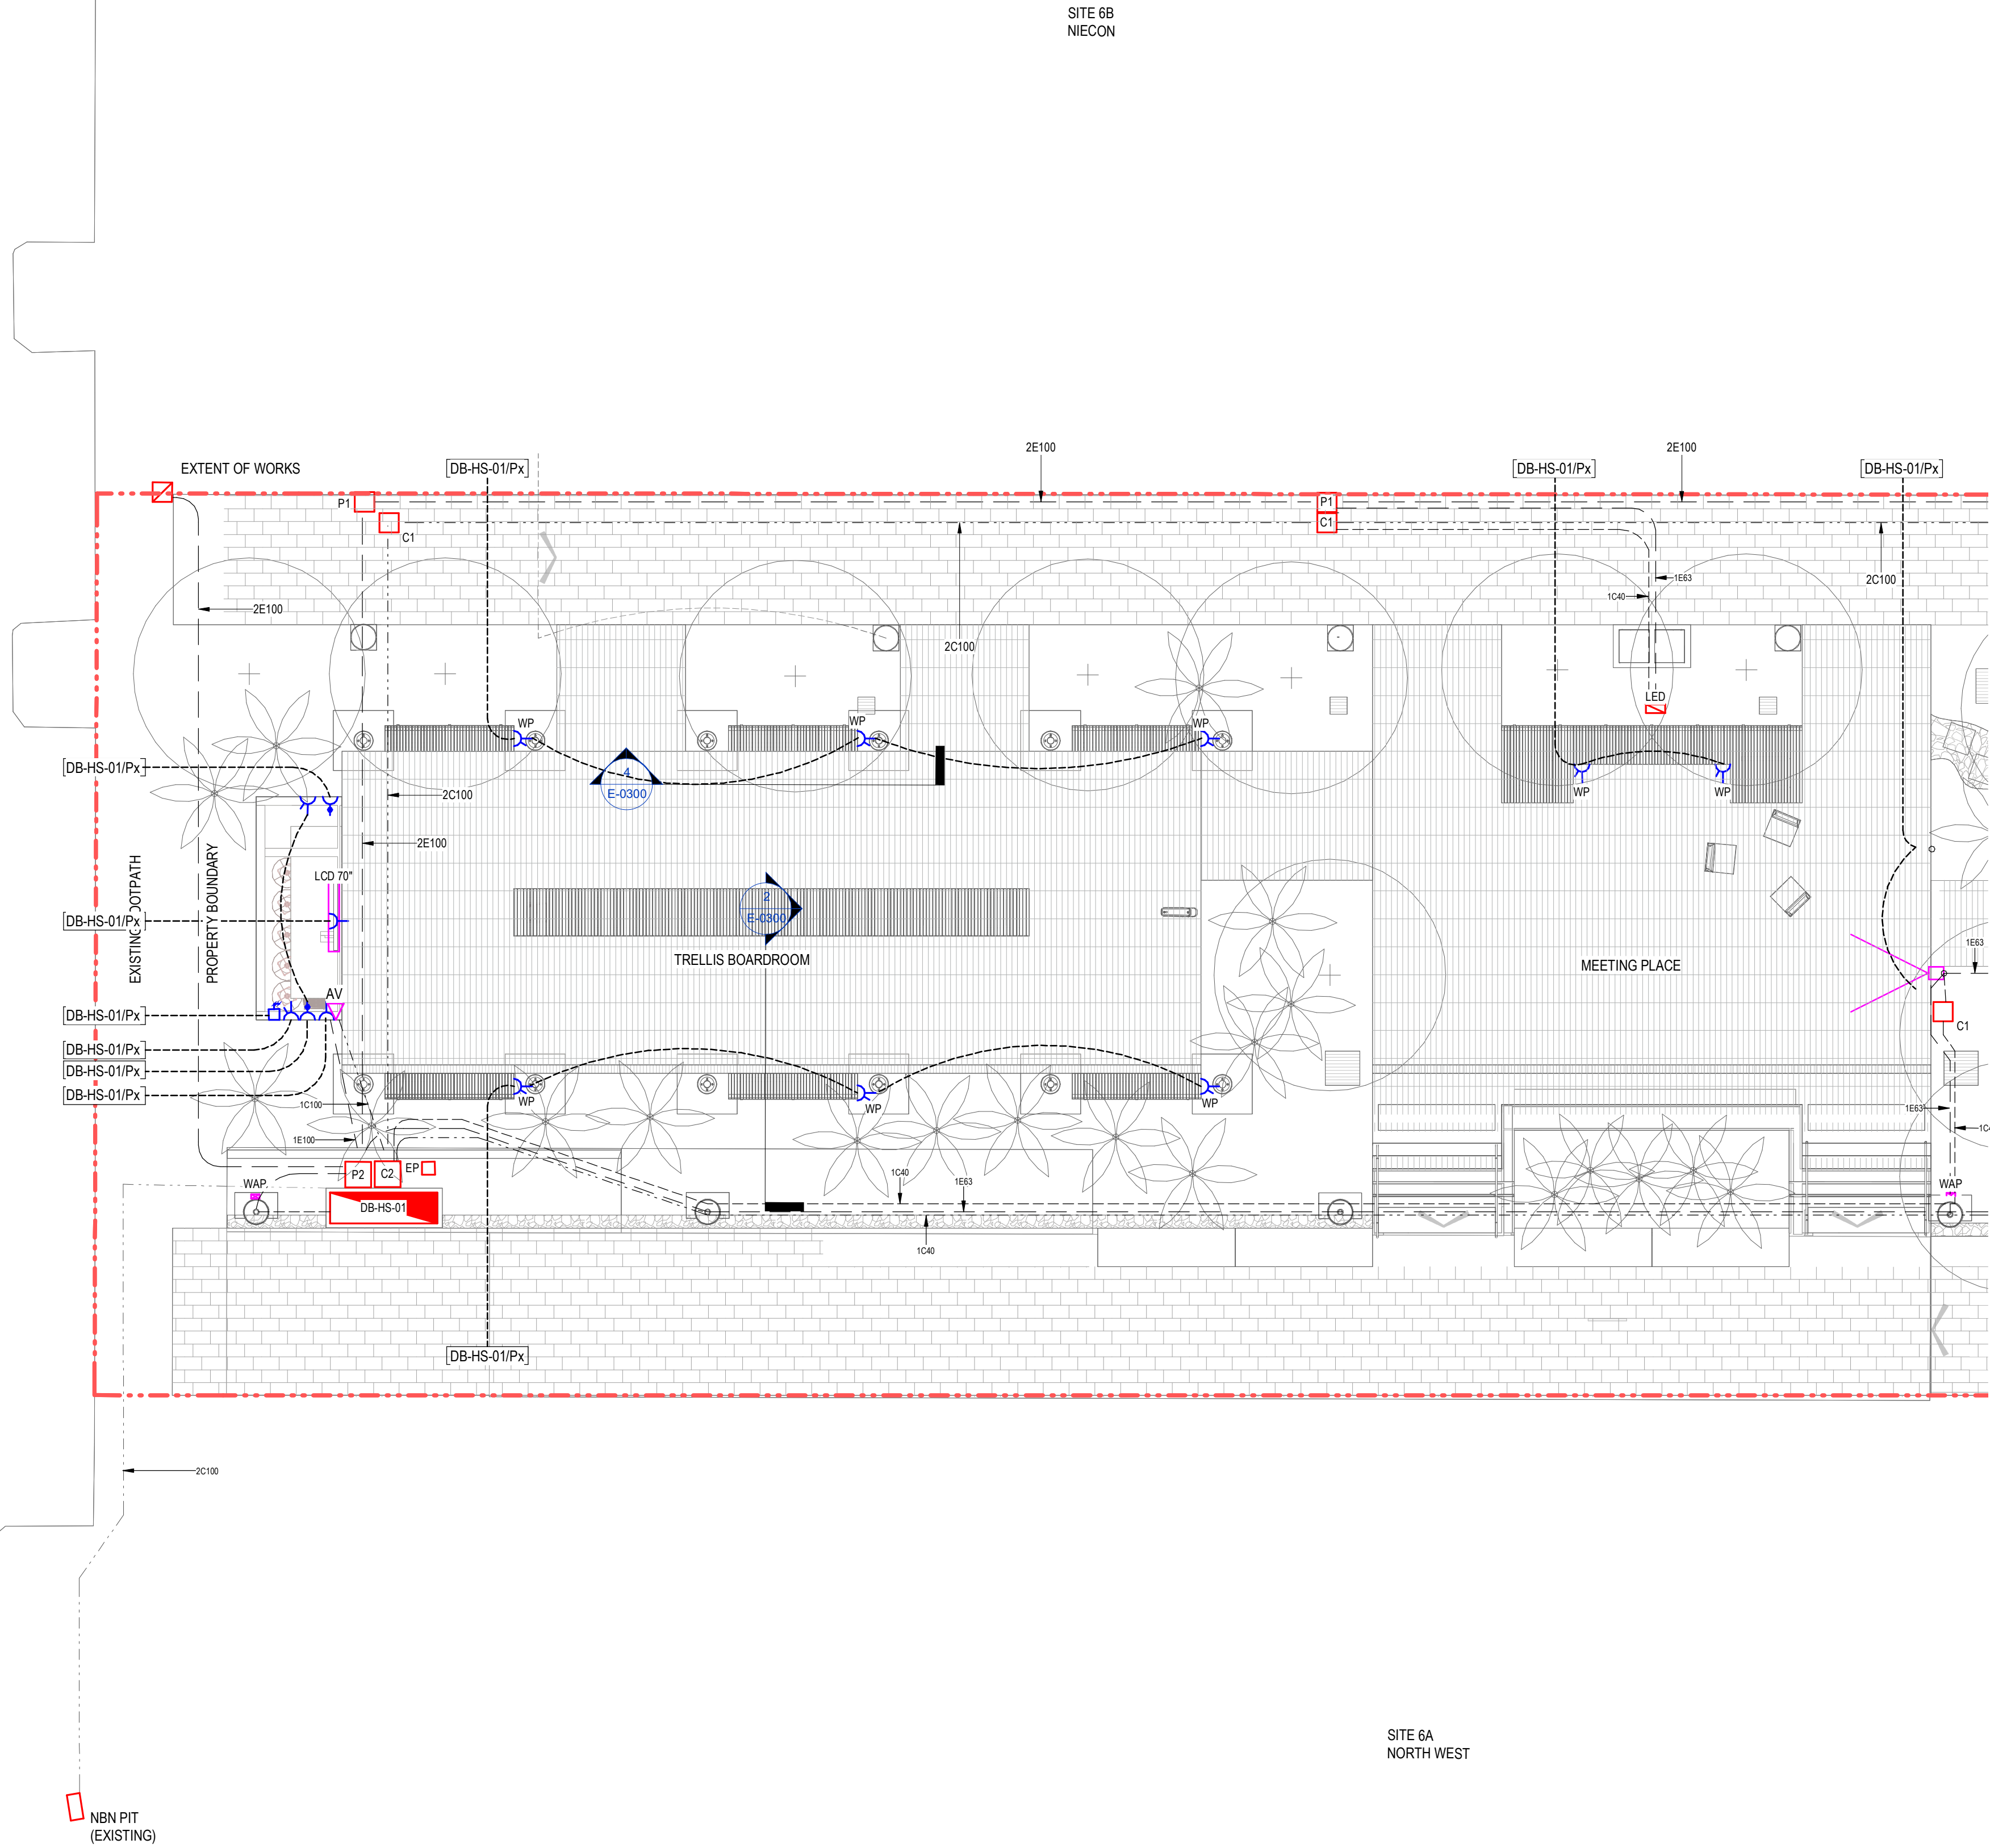


FOR CONTINUATION REFER TO DRAWING E-2002

DESIGN DEVELOPMENT

NOT TO BE USED FOR CONSTRUCTION

COPYRIGHT OF THIS DRAWING IS VESTED IN INTROBA. THE DRAWING SHALL NOT BE REPRODUCED OR COPIED IN WHOLE OR IN PART IN ANY FORM WITHOUT THE PRIOR WRITTEN APPROVAL OF INTROBA.

CONTRACTOR MUST VISIT SITE BEFORE TENDERING

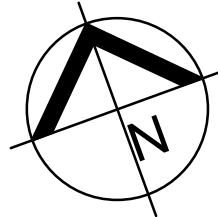

No.	DATE	REVISION	BY
1	06-04-23	50% DESIGN DEVELOPMENT DRAFT	DDS
2	18-04-23	50% DESIGN DEVELOPMENT	DDS
3	17-05-23	90% DESIGN DEVELOPMENT	VL
4	26-05-23	95% DESIGN DEVELOPMENT CLIENT ISSUE	VL
5	21-07-23	100% DESIGN DEVELOPMENT ISSUE	VL

Client:




Economic Development Queensland (EDQ)


Architect:



Hassell
Hassell LTD ABN 24 007 711 435
Level2, Pier 8/9,23 Hickson Rd
Sydney NSW 2000 Australia
T +61 2 9101 2000
F +61 2 9101 2100
sydney@hassellstudio.com

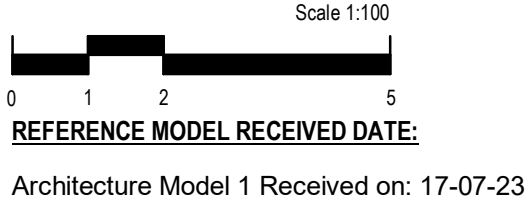

Key Plan:

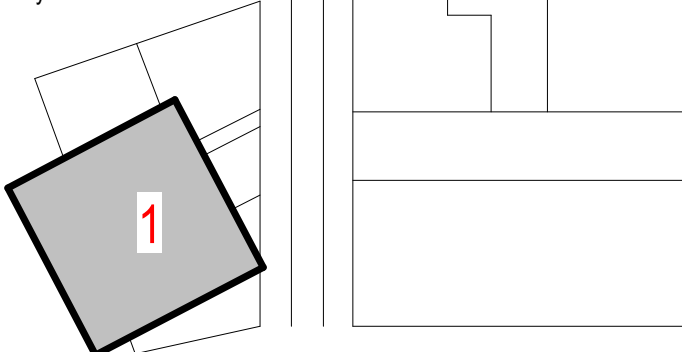

Introba
Brisbane
Level 7, 200 Creek Street
Brisbane, QLD 4000

hello@introba.com
www.introba.com

LUMINA OPEN SPACE
SOUTHPORT, QLD
4215

**ELECTRICAL SERVICES
POWER AND RETICULATION LAYOUT
SHEET 1**

DRAWING REPRODUCTION
THIS SET OF DOCUMENTS CONTAINS DRAWINGS THAT HAVE BEEN CREATED IN COLOUR. REPRODUCTIONS MUST BE MADE IN COLOUR TO AVOID LOSS OF INFORMATION. FOR BLACK & WHITE PRINTING PLEASE CONTACT INTROBA FOR A REVISED SET OF BLACK & WHITE SPECIFIC DOCUMENTS.

DRAWN	CS	DATE	21-07-23
DESIGN	DDS	SCALE	1 : 100 @A1
CHECKED	-	PLOT RATIO	1 / A1
APPROVED	-	PROJECT No	62.0010071

62.0010071-E-2001


5

SITE 6B
NIECON

SITE 6E
EVANS LONG - DESIGN PENDING


FOR CONTINUATION REFER TO DRAWING E-2001

FOR CONTINUATION REFER TO DRAWING E-2003

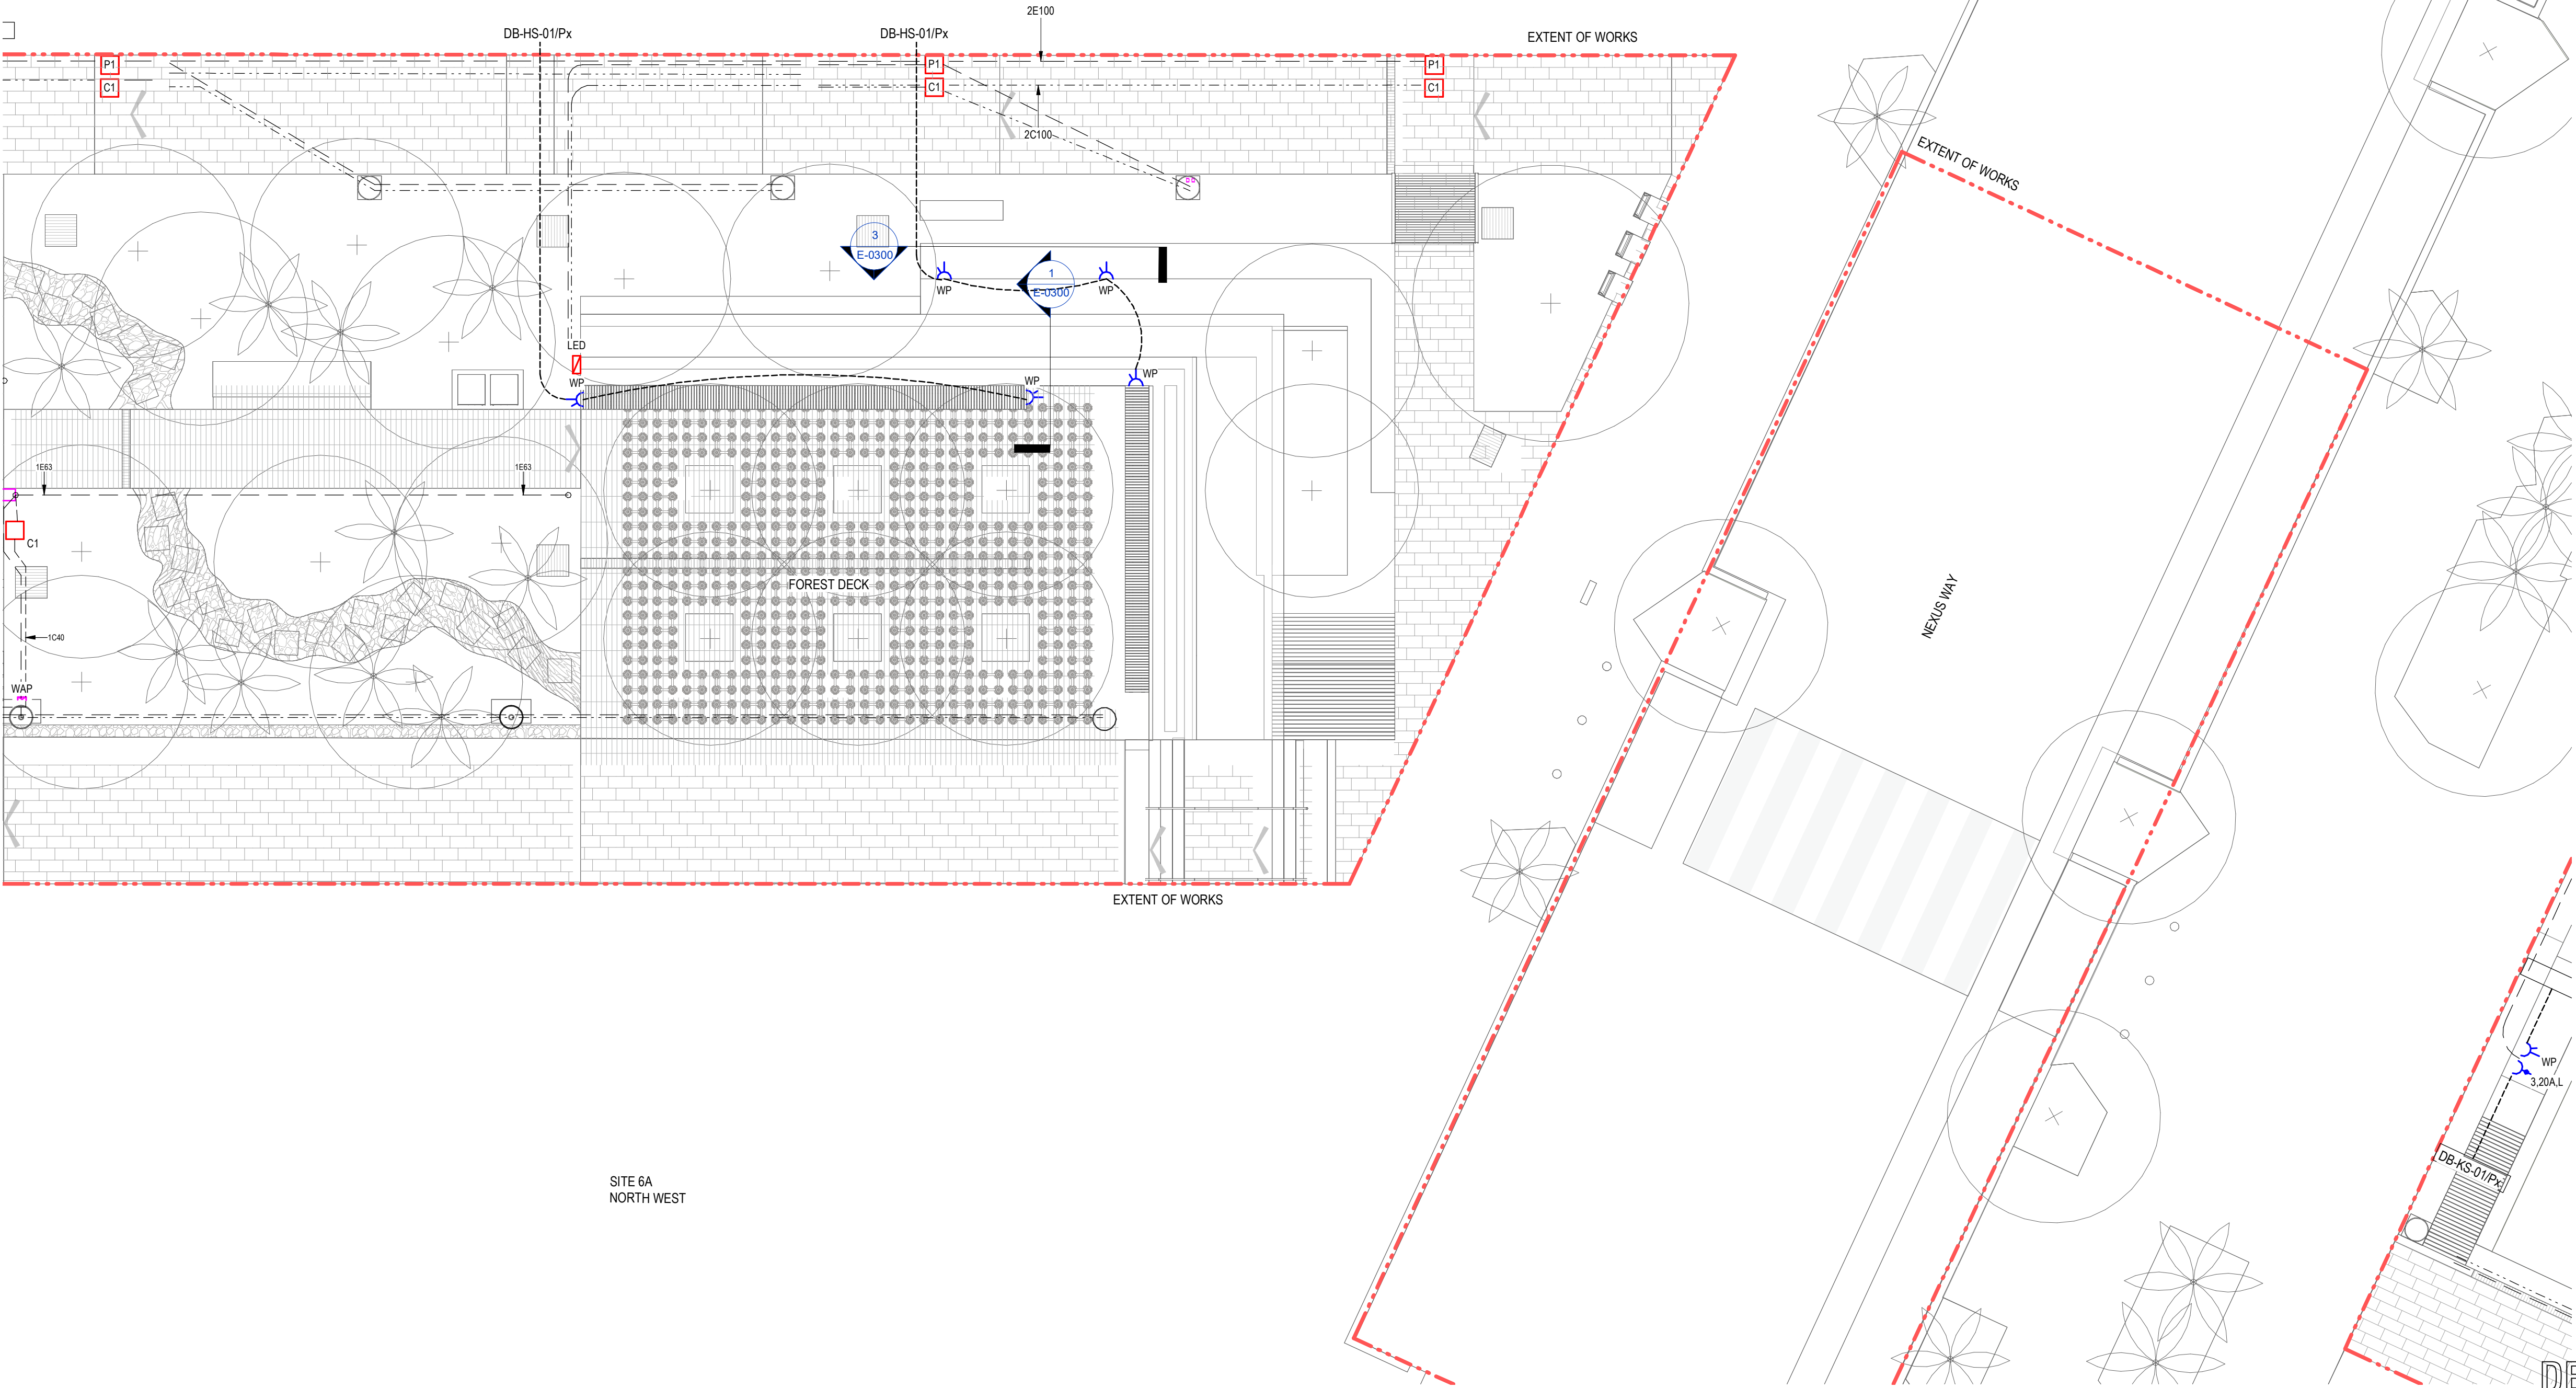

DESIGN DEVELOPMENT

NOT TO BE USED FOR CONSTRUCTION
COPYRIGHT OF THIS DRAWING IS VESTED IN INTROBA.
THE DRAWING SHALL NOT BE REPRODUCED OR COPIED IN WHOLE OR IN PART IN ANY
FORM WITHOUT THE PRIOR WRITTEN APPROVAL OF INTROBA.
CONTRACTOR MUST VISIT SITE BEFORE TENDERING

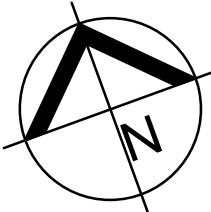

No.	DATE	REVISION	BY
1	06-04-23	50% DESIGN DEVELOPMENT DRAFT	DDS
2	18-04-23	50% DESIGN DEVELOPMENT	DDS
3	17-05-23	90% DESIGN DEVELOPMENT	VL
4	26-05-23	95% DESIGN DEVELOPMENT CLIENT ISSUE	VL
5	21-07-23	100% DESIGN DEVELOPMENT ISSUE	VL

Client:




Economic Development Queensland (EDQ)


Architect:



Hassell
Hassell LTD ABN 24 007 711 435
Level2, Pier 8/9,23 Hickson Rd
Sydney NSW 2000 Australia
T +61 2 9101 2000
F +61 2 9101 2100
sydney@hassellstudio.com

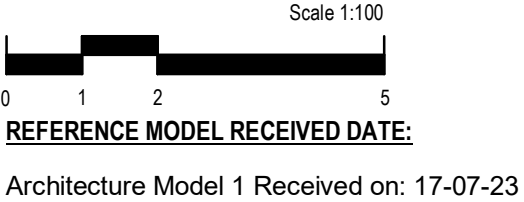

Key Plan:

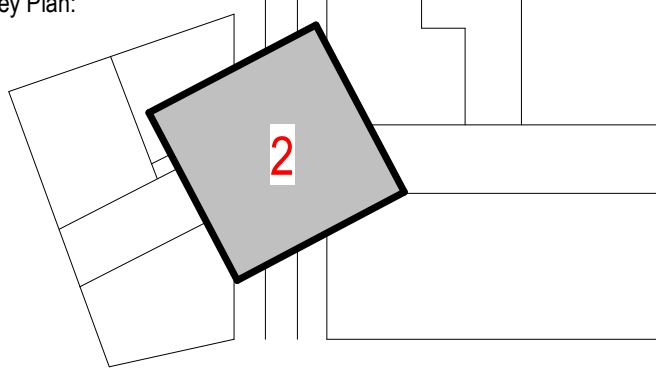

Introba
Brisbane
Level 7, 200 Creek Street
Brisbane, QLD 4000

hello@introba.com
www.introba.com

LUMINA OPEN SPACE
SOUTHPORT, QLD
4215

ELECTRICAL SERVICES
POWER AND RETICULATION LAYOUT
SHEET 2

DRAWING REPRODUCTION
THIS SET OF DOCUMENTS CONTAINS DRAWINGS THAT HAVE BEEN CREATED IN COLOUR.
REPRODUCTIONS MUST BE MADE IN COLOUR TO AVOID LOSS OF INFORMATION.
FOR BLACK & WHITE PRINTING PLEASE CONTACT INTROBA FOR A REVISED SET OF
BLACK & WHITE SPECIFIC DOCUMENTS.

DRAWN	CS	DATE	21-07-23
DESIGN	DDS	SCALE	1 : 100 @A1
CHECKED	-	PLOT RATIO	1 / A1
APPROVED	-	PROJECT No	62.0010071


62.0010071-E-2002

5



FOR CONTINUATION REFER TO DRAWING E-2004

NOT TO BE USED FOR CONSTRUCTION
 COPYRIGHT OF THIS DRAWING IS VESTED IN INTROBA.
 THE DRAWING SHALL NOT BE REPRODUCED OR COPIED IN WHOLE OR IN PART IN ANY
 FORM, WITHOUT THE PRIOR WRITTEN APPROVAL OF INTROBA.
CONTRACTOR MUST VISIT SITE BEFORE TENDERING

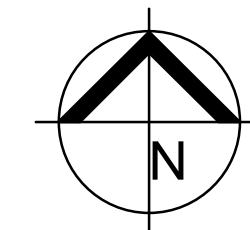


Client:


Queensland
Government

Economic Development Queensland (EDQ)



Key Plan:

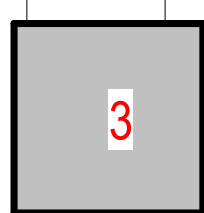

LUMINA OPEN SPACE
SOUTHPORT, QLD
4215


ELECTRICAL SERVICES
POWER AND RETICULATION LAYOUT
SHEET 3

DRAWING REPRODUCTION
 SET OF DOCUMENTS CONTAINS DRAWINGS THAT HAVE BEEN CREATED IN COLOUR. ANY REPRODUCTIONS MUST BE MADE IN COLOUR TO AVOID LOSS OF INFORMATION.
 FOR BLACK & WHITE PRINTING PLEASE CONTACT INTROBA FOR A REVISED SET OF BLACK & WHITE SPECIFIC DOCUMENTS.

DRAWN	CS	DATE	21-07-23
DESIGN	DDS	SCALE	1 : 100 @A1
CHECKED	-	PLOT RATIO	1 / A1
APPROVED	-	PROJECT No	62.0010071
62.0010071-E-2003			5


NOTESITES

1. REFER TO DRAWING E-0001 FOR LEGEND AND GENERAL NOTES

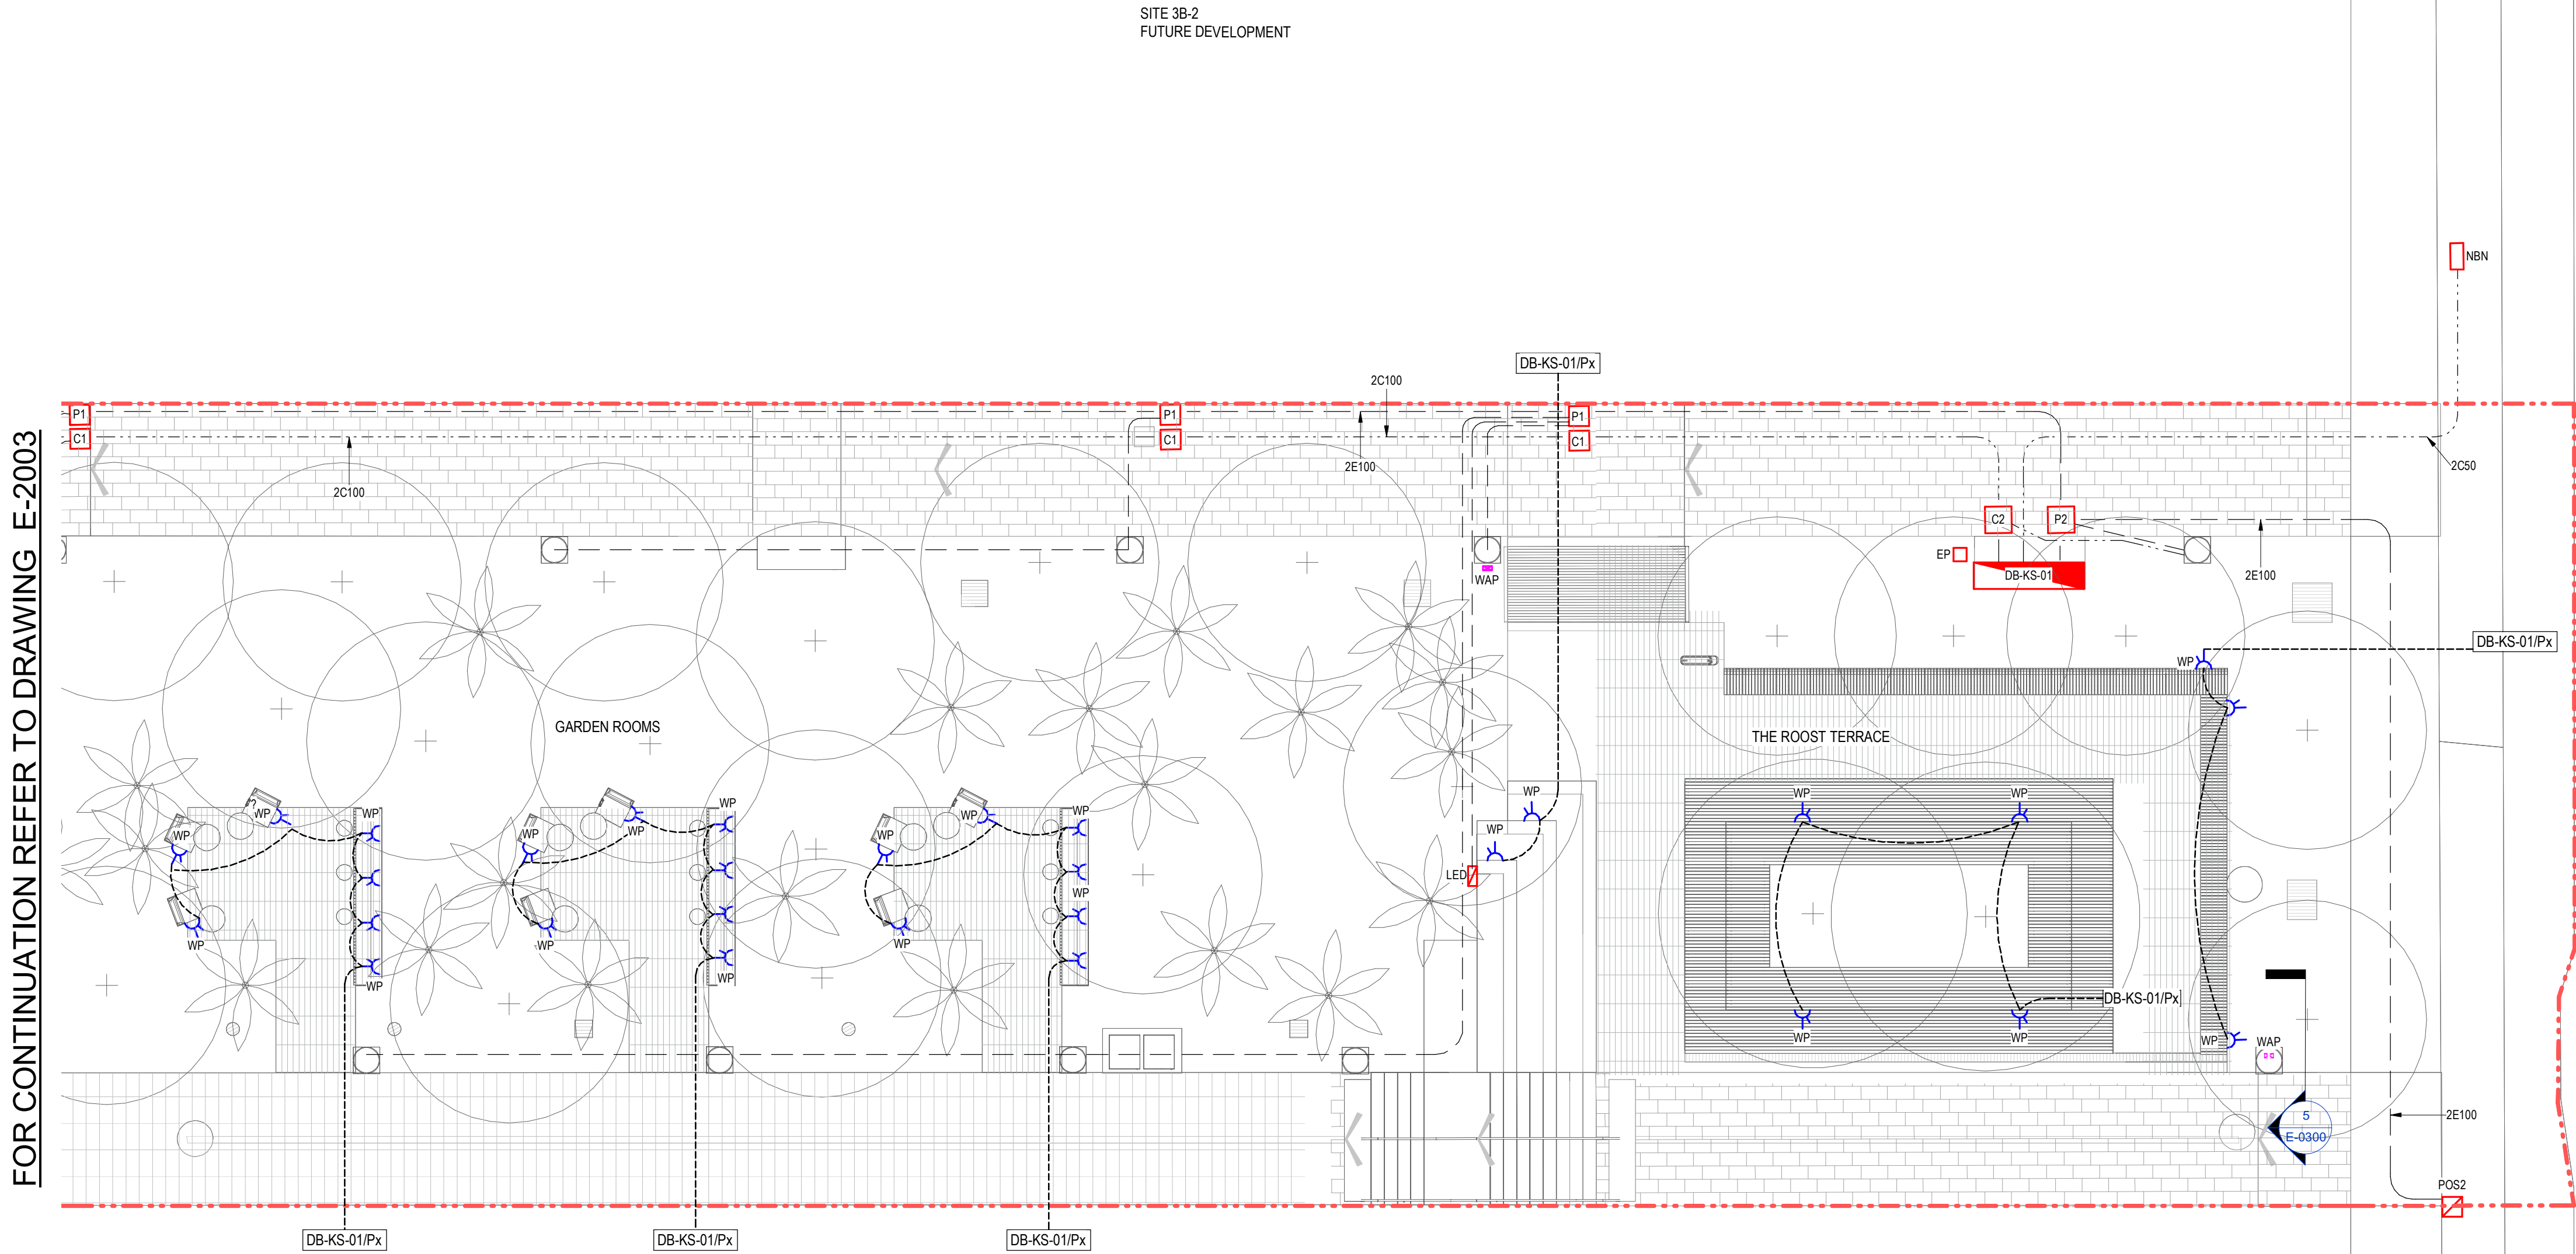

DESIGN DEVELOPMENT

NOT TO BE USED FOR CONSTRUCTION
COPYRIGHT OF THIS DRAWING IS VESTED IN INTROBA.
THE DRAWING SHALL NOT BE REPRODUCED OR COPIED IN WHOLE OR IN PART IN ANY
FORM WITHOUT THE PRIOR WRITTEN APPROVAL OF INTROBA.
CONTRACTOR MUST VISIT SITE BEFORE TENDERING

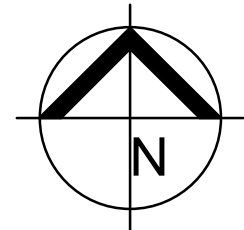

No.	DATE	REVISION	BY
1	06-04-23	50% DESIGN DEVELOPMENT DRAFT	DOS
2	18-04-23	50% DESIGN DEVELOPMENT	DOS
3	17-05-23	90% DESIGN DEVELOPMENT	VL
4	26-05-23	95% DESIGN DEVELOPMENT CLIENT ISSUE	VL
5	21-07-23	100% DESIGN DEVELOPMENT ISSUE	VL

Client:



Economic Development Queensland (EDQ)

Architect:



Hassell

Hassell LTD ABN 24 007 711 435
Level2, Pier 8/9,23 Hickson Rd
Sydney NSW 2000 Australia
T +61 2 9101 2000
F +61 2 9101 2100
sydney@hassellstudio.com


Scale 1:100



REFERENCE MODEL RECEIVED DATE:

Architecture Model 1 Received on: 17-07-23

Key Plan:

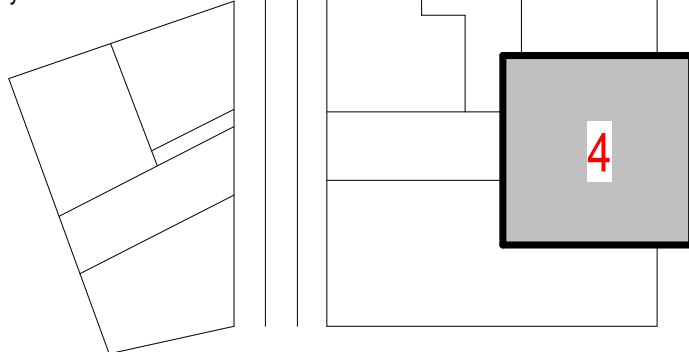

Brisbane
Level 7, 200 Creek Street
Brisbane, QLD 4000

hello@introba.com
www.introba.com

LUMINA OPEN SPACE

SOUTHPORT, QLD
4215

**ELECTRICAL SERVICES
POWER AND RETICULATION LAYOUT
SHEET 4**

DRAWING REPRODUCTION
THIS SET OF DOCUMENTS CONTAINS DRAWINGS THAT HAVE BEEN CREATED IN COLOUR.
REPRODUCTIONS MUST BE MADE IN COLOUR TO AVOID LOSS OF INFORMATION.
FOR BLACK & WHITE PRINTING PLEASE CONTACT INTROBA FOR A REVISED SET OF
BLACK & WHITE SPECIFIC DOCUMENTS.


DRAWN	CS	DATE	21-07-23
DESIGN	DOS	SCALE	1 : 100 @A1
CHECKED	-	PLOT RATIO	1 / A1
APPROVED	-	PROJECT No	62.0010071

62.0010071-E-2004

5


NOTES

1. REFER TO DRAWING E-0001 FOR LEGEND AND GENERAL NOTES

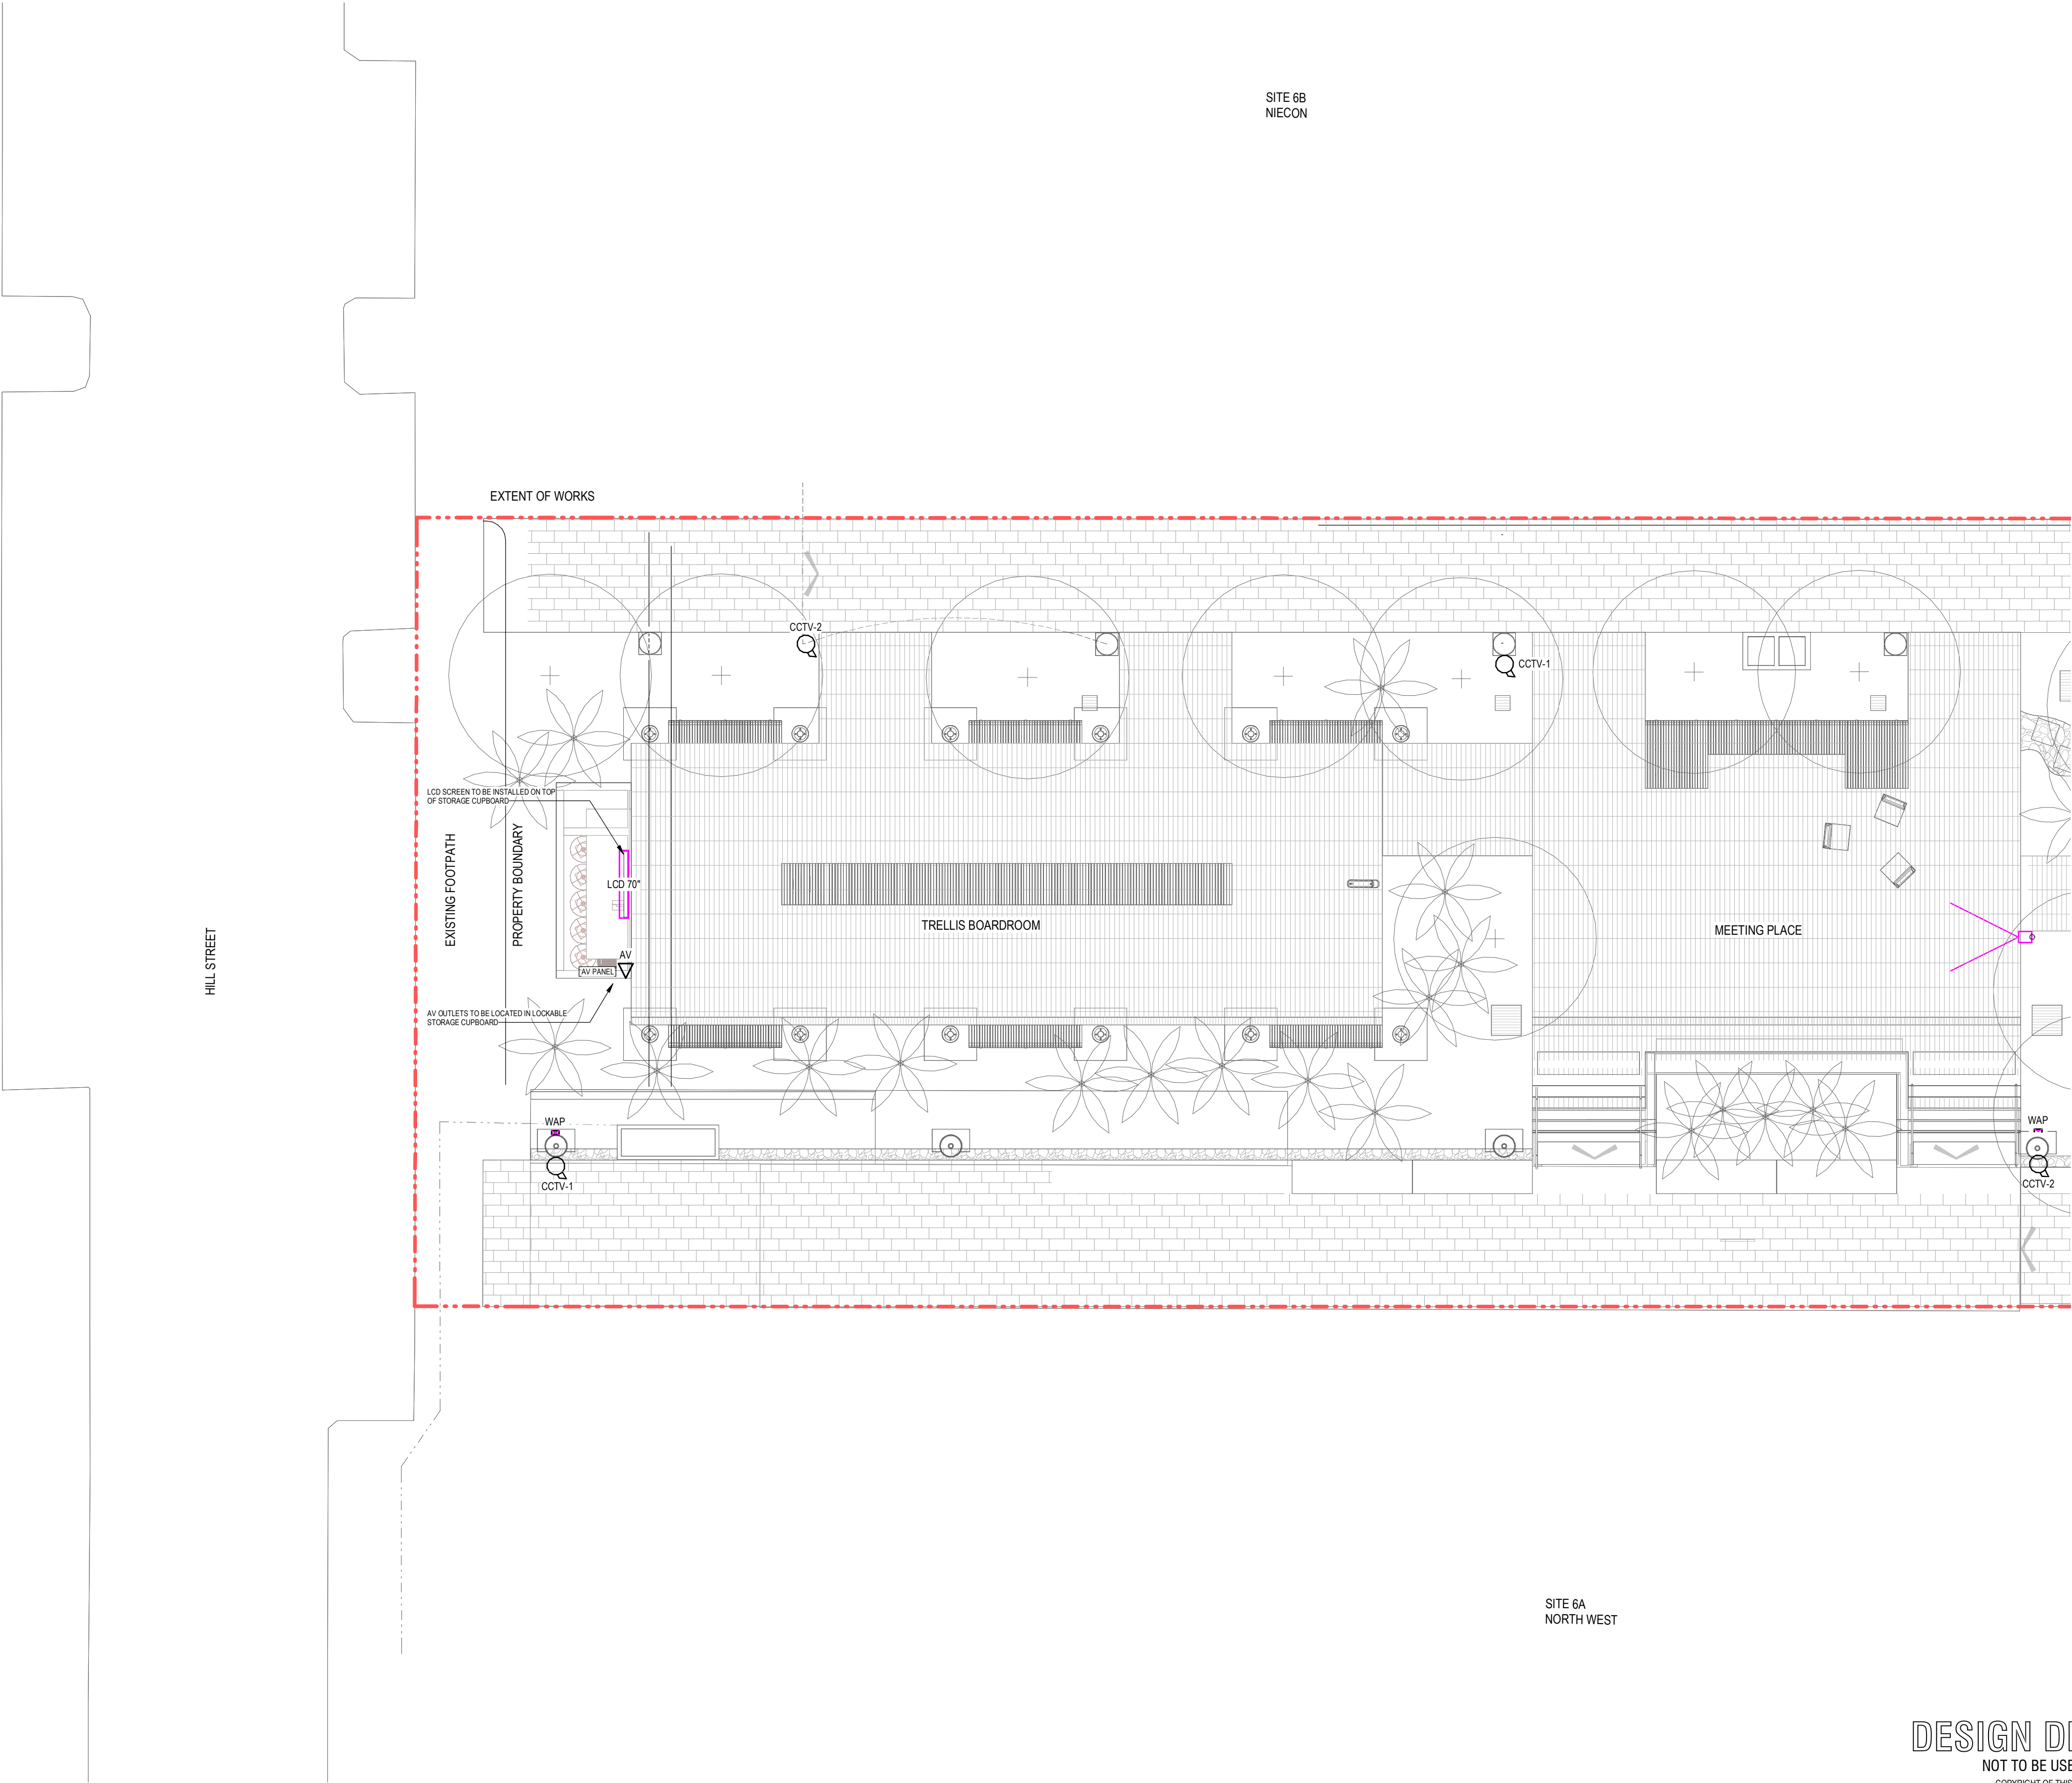

DESIGN DEVELOPMENT

NOT TO BE USED FOR CONSTRUCTION
COPYRIGHT OF THIS DRAWING IS VESTED IN INTROBA.
THE DRAWING SHALL NOT BE REPRODUCED OR COPIED IN WHOLE OR IN PART IN ANY FORM WITHOUT THE PRIOR WRITTEN APPROVAL OF INTROBA.
CONTRACTOR MUST VISIT SITE BEFORE TENDERING

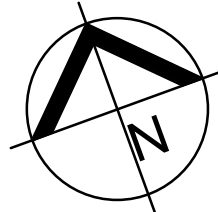

No.	DATE	REVISION	BY
1	17-05-23	90% DESIGN DEVELOPMENT	VL
2	26-05-23	95% DESIGN DEVELOPMENT CLIENT ISSUE	VL
3	21-07-23	100% DESIGN DEVELOPMENT ISSUE	VL

Client:




Economic Development Queensland (EDQ)


Architect:



Hassell
Hassell LTD ABN 24 007 711 435
Level2, Pier 8/9,23 Hickson Rd
Sydney NSW 2000 Australia
T +61 2 9101 2000
F +61 2 9101 2100
sydney@hassellstudio.com

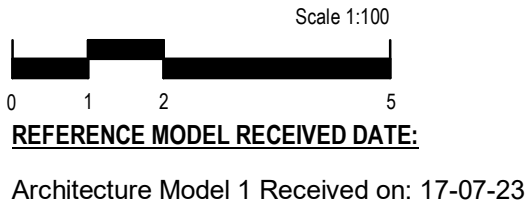

Key Plan:

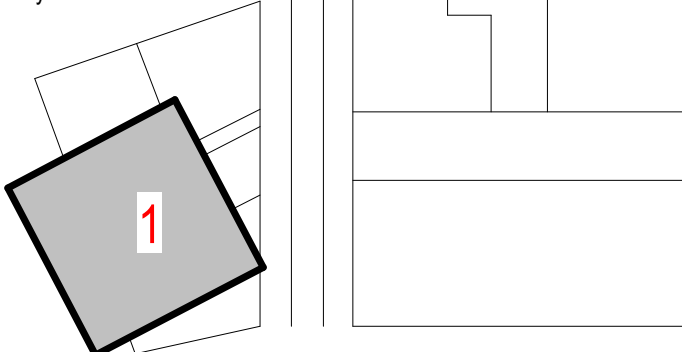

Introba
Brisbane
Level 7, 200 Creek Street
Brisbane, QLD 4000

hello@introba.com
www.introba.com

LUMINA OPEN SPACE
SOUTHPORT, QLD 4215

ELECTRICAL SERVICES
ICT LAYOUT SHEET 1

DRAWING REPRODUCTION
THIS SET OF DOCUMENTS CONTAINS DRAWINGS THAT HAVE BEEN CREATED IN COLOUR.
REPRODUCTIONS MUST BE MADE IN COLOUR TO AVOID LOSS OF INFORMATION.
FOR BLACK & WHITE PRINTING PLEASE CONTACT INTROBA FOR A REVISED SET OF BLACK & WHITE SPECIFIC DOCUMENTS.

DRAWN	CS	DATE	21-07-23
DESIGN	DDS	SCALE	1 : 100 @A1
CHECKED	-	PLOT RATIO	1 / A1
APPROVED	-	PROJECT No	62.0010071


62.0010071-E-3001

3

21/07/2023 16:40:35 Autodesk Docs://62.0010071 - Lumina Open Space/62.0010071_MEP_R22.rvt

SITE 6B
NIECON

SITE 6E
EVANS LONG - DESIGN PENDING

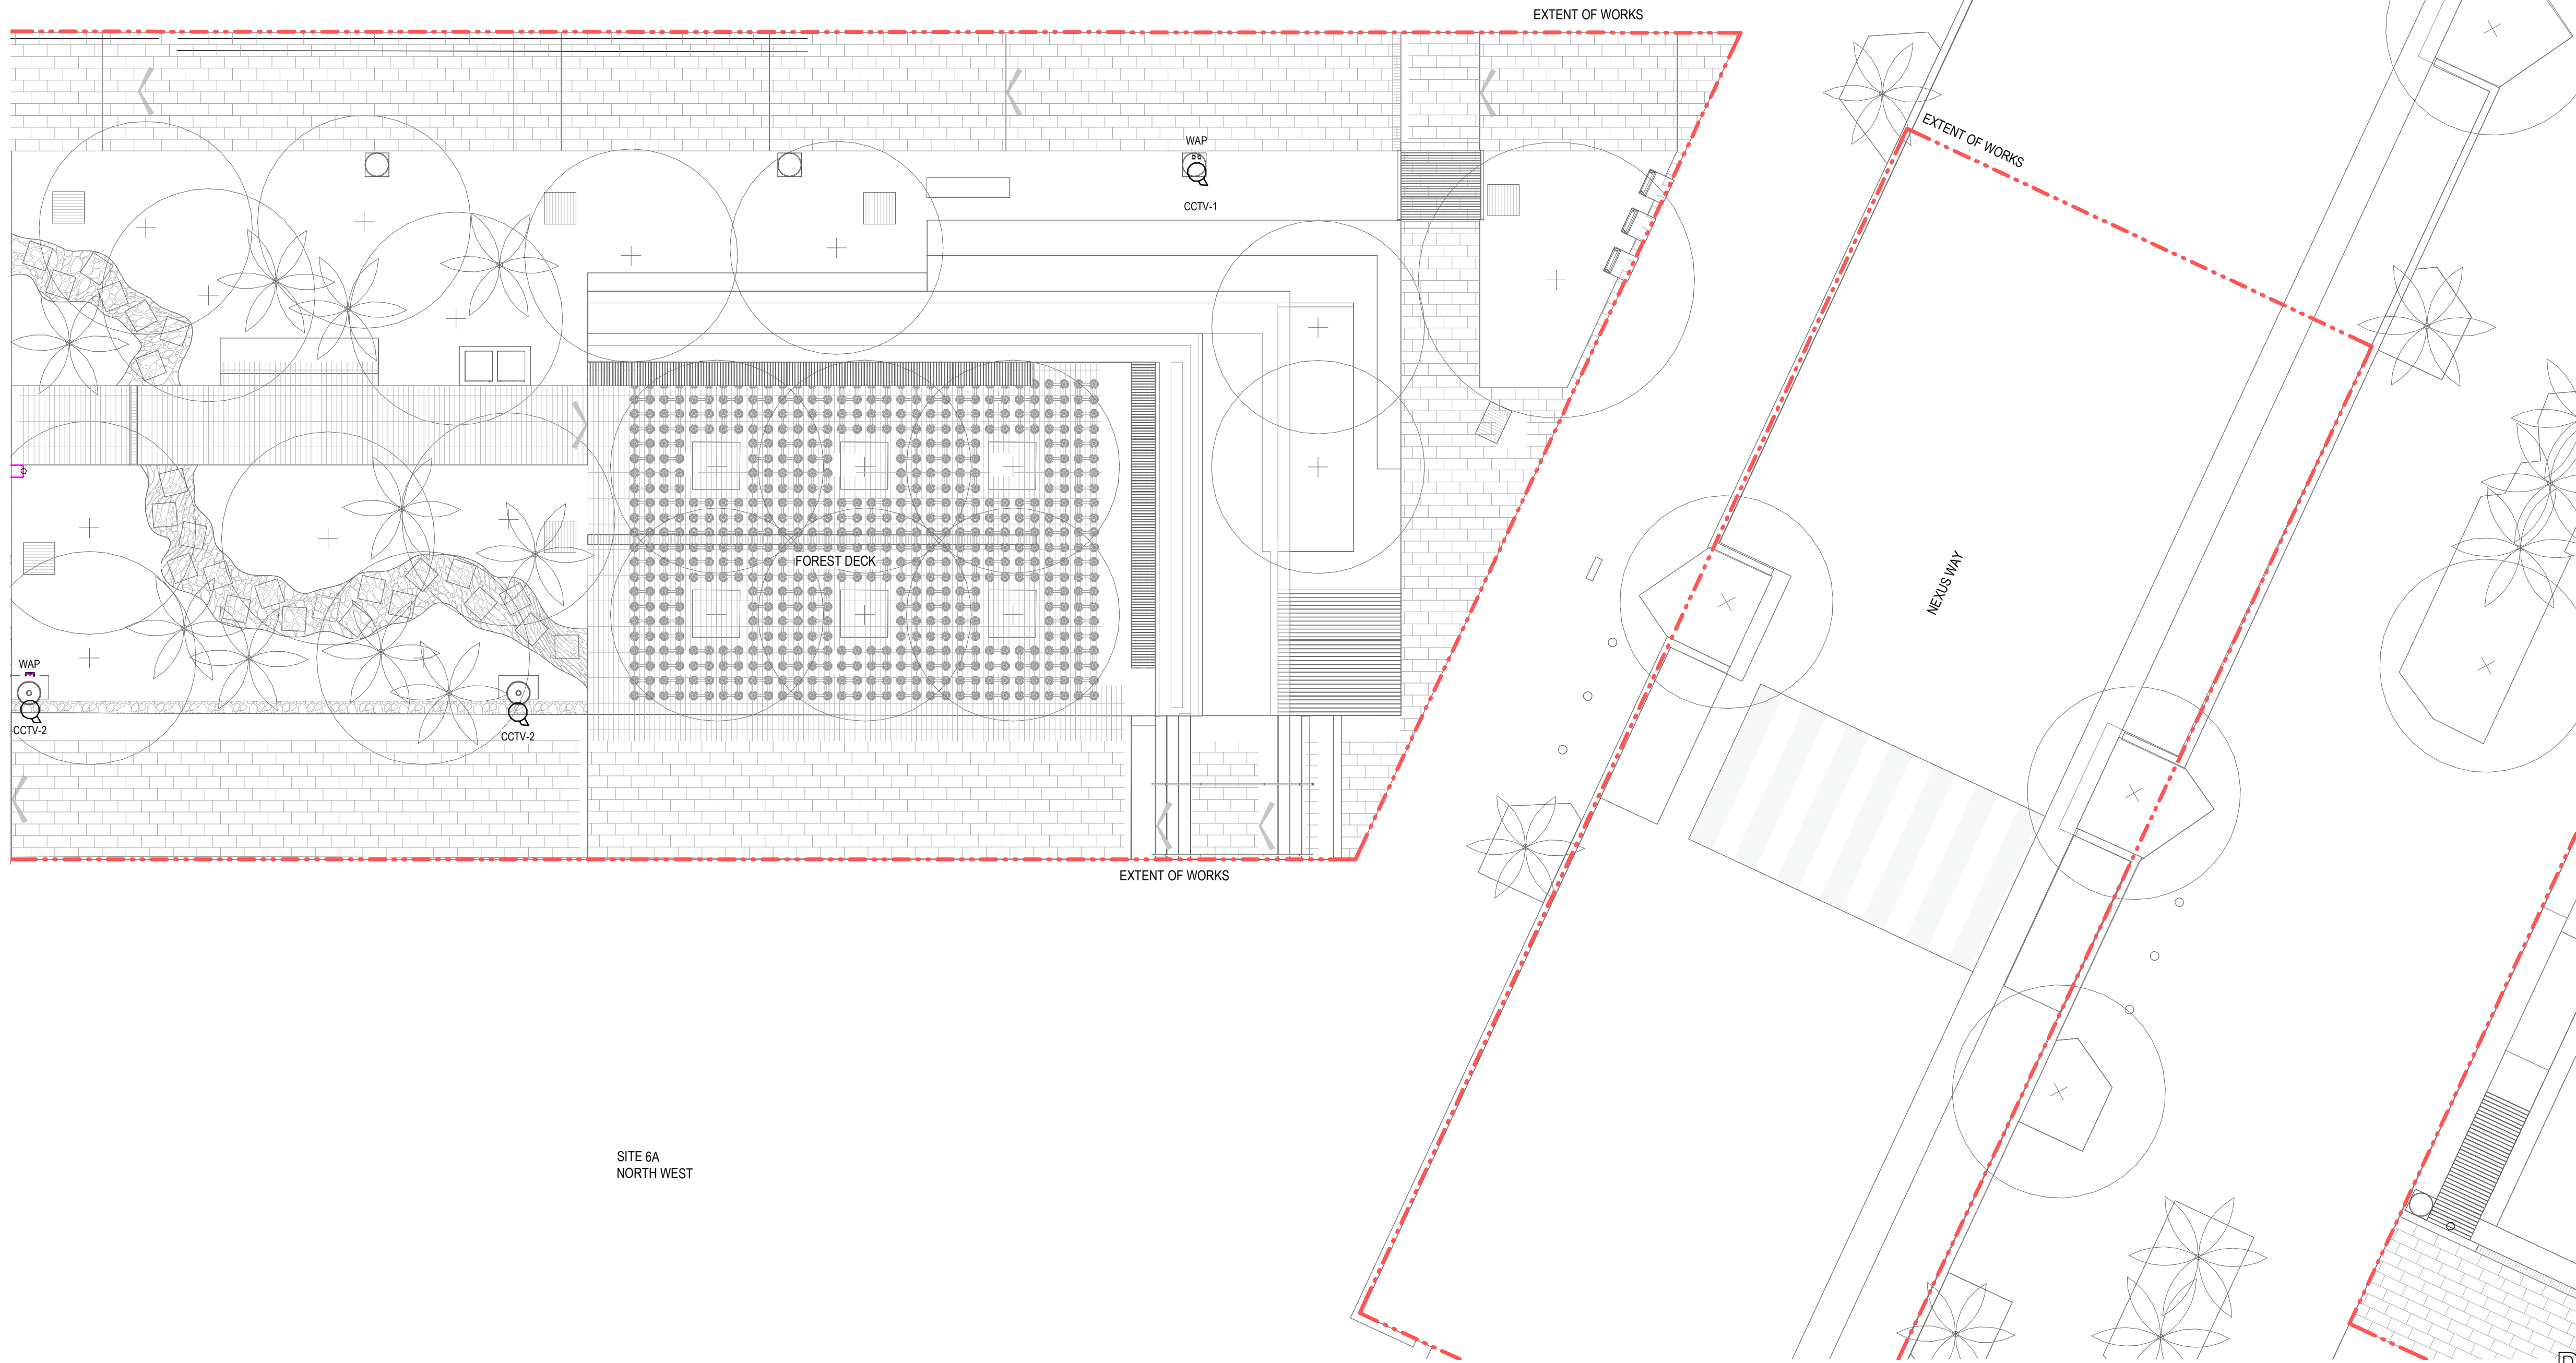


NOTES

1. REFER TO DRAWING E-0001 FOR LEGEND AND GENERAL NOTES

DESIGN DEVELOPMENT

NOT TO BE USED FOR CONSTRUCTION
COPYRIGHT OF THIS DRAWING IS VESTED IN INTROBA.
THE DRAWING SHALL NOT BE REPRODUCED OR COPIED IN WHOLE OR IN PART IN ANY FORM WITHOUT THE PRIOR WRITTEN APPROVAL OF INTROBA.
CONTRACTOR MUST VISIT SITE BEFORE TENDERING

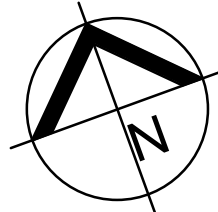

No.	DATE	REVISION	BY
1	17-05-23	90% DESIGN DEVELOPMENT	VL
2	26-05-23	95% DESIGN DEVELOPMENT CLIENT ISSUE	VL
3	21-07-23	100% DESIGN DEVELOPMENT ISSUE	VL

Client:



Economic Development Queensland (EDQ)


Architect:



Hassell
Hassell LTD ABN 24 007 711 435
Level2, Pier 8/9,23 Hickson Rd
Sydney NSW 2000 Australia
T +61 2 9101 2000
F +61 2 9101 2100
sydney@hassellstudio.com

Scale 1:100
0 1 2 5
REFERENCE MODEL RECEIVED DATE:
Architecture Model 1 Received on: 17-07-23

Key Plan:

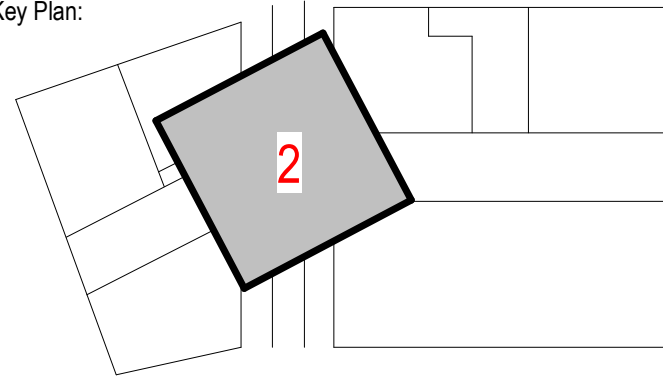

Introba
Brisbane
Level 7, 200 Creek Street
Brisbane, QLD 4000

hello@introba.com
www.introba.com

LUMINA OPEN SPACE
SOUTHPORT, QLD
4215


ELECTRICAL SERVICES
ICT LAYOUT SHEET 2

DRAWING REPRODUCTION
THIS SET OF DOCUMENTS CONTAINS DRAWINGS THAT HAVE BEEN CREATED IN COLOUR.
REPRODUCTIONS MUST BE MADE IN COLOUR TO AVOID LOSS OF INFORMATION.
FOR BLACK & WHITE PRINTING PLEASE CONTACT INTROBA FOR A REVISED SET OF
BLACK & WHITE SPECIFIC DOCUMENTS.

DRAWN	CS	DATE	21-07-23
DESIGN	DDS	SCALE	1 : 100 @A1
CHECKED	-	PLOT RATIO	1 / A1
APPROVED	-	PROJECT No	62.0010071

62.0010071-E-3002

3

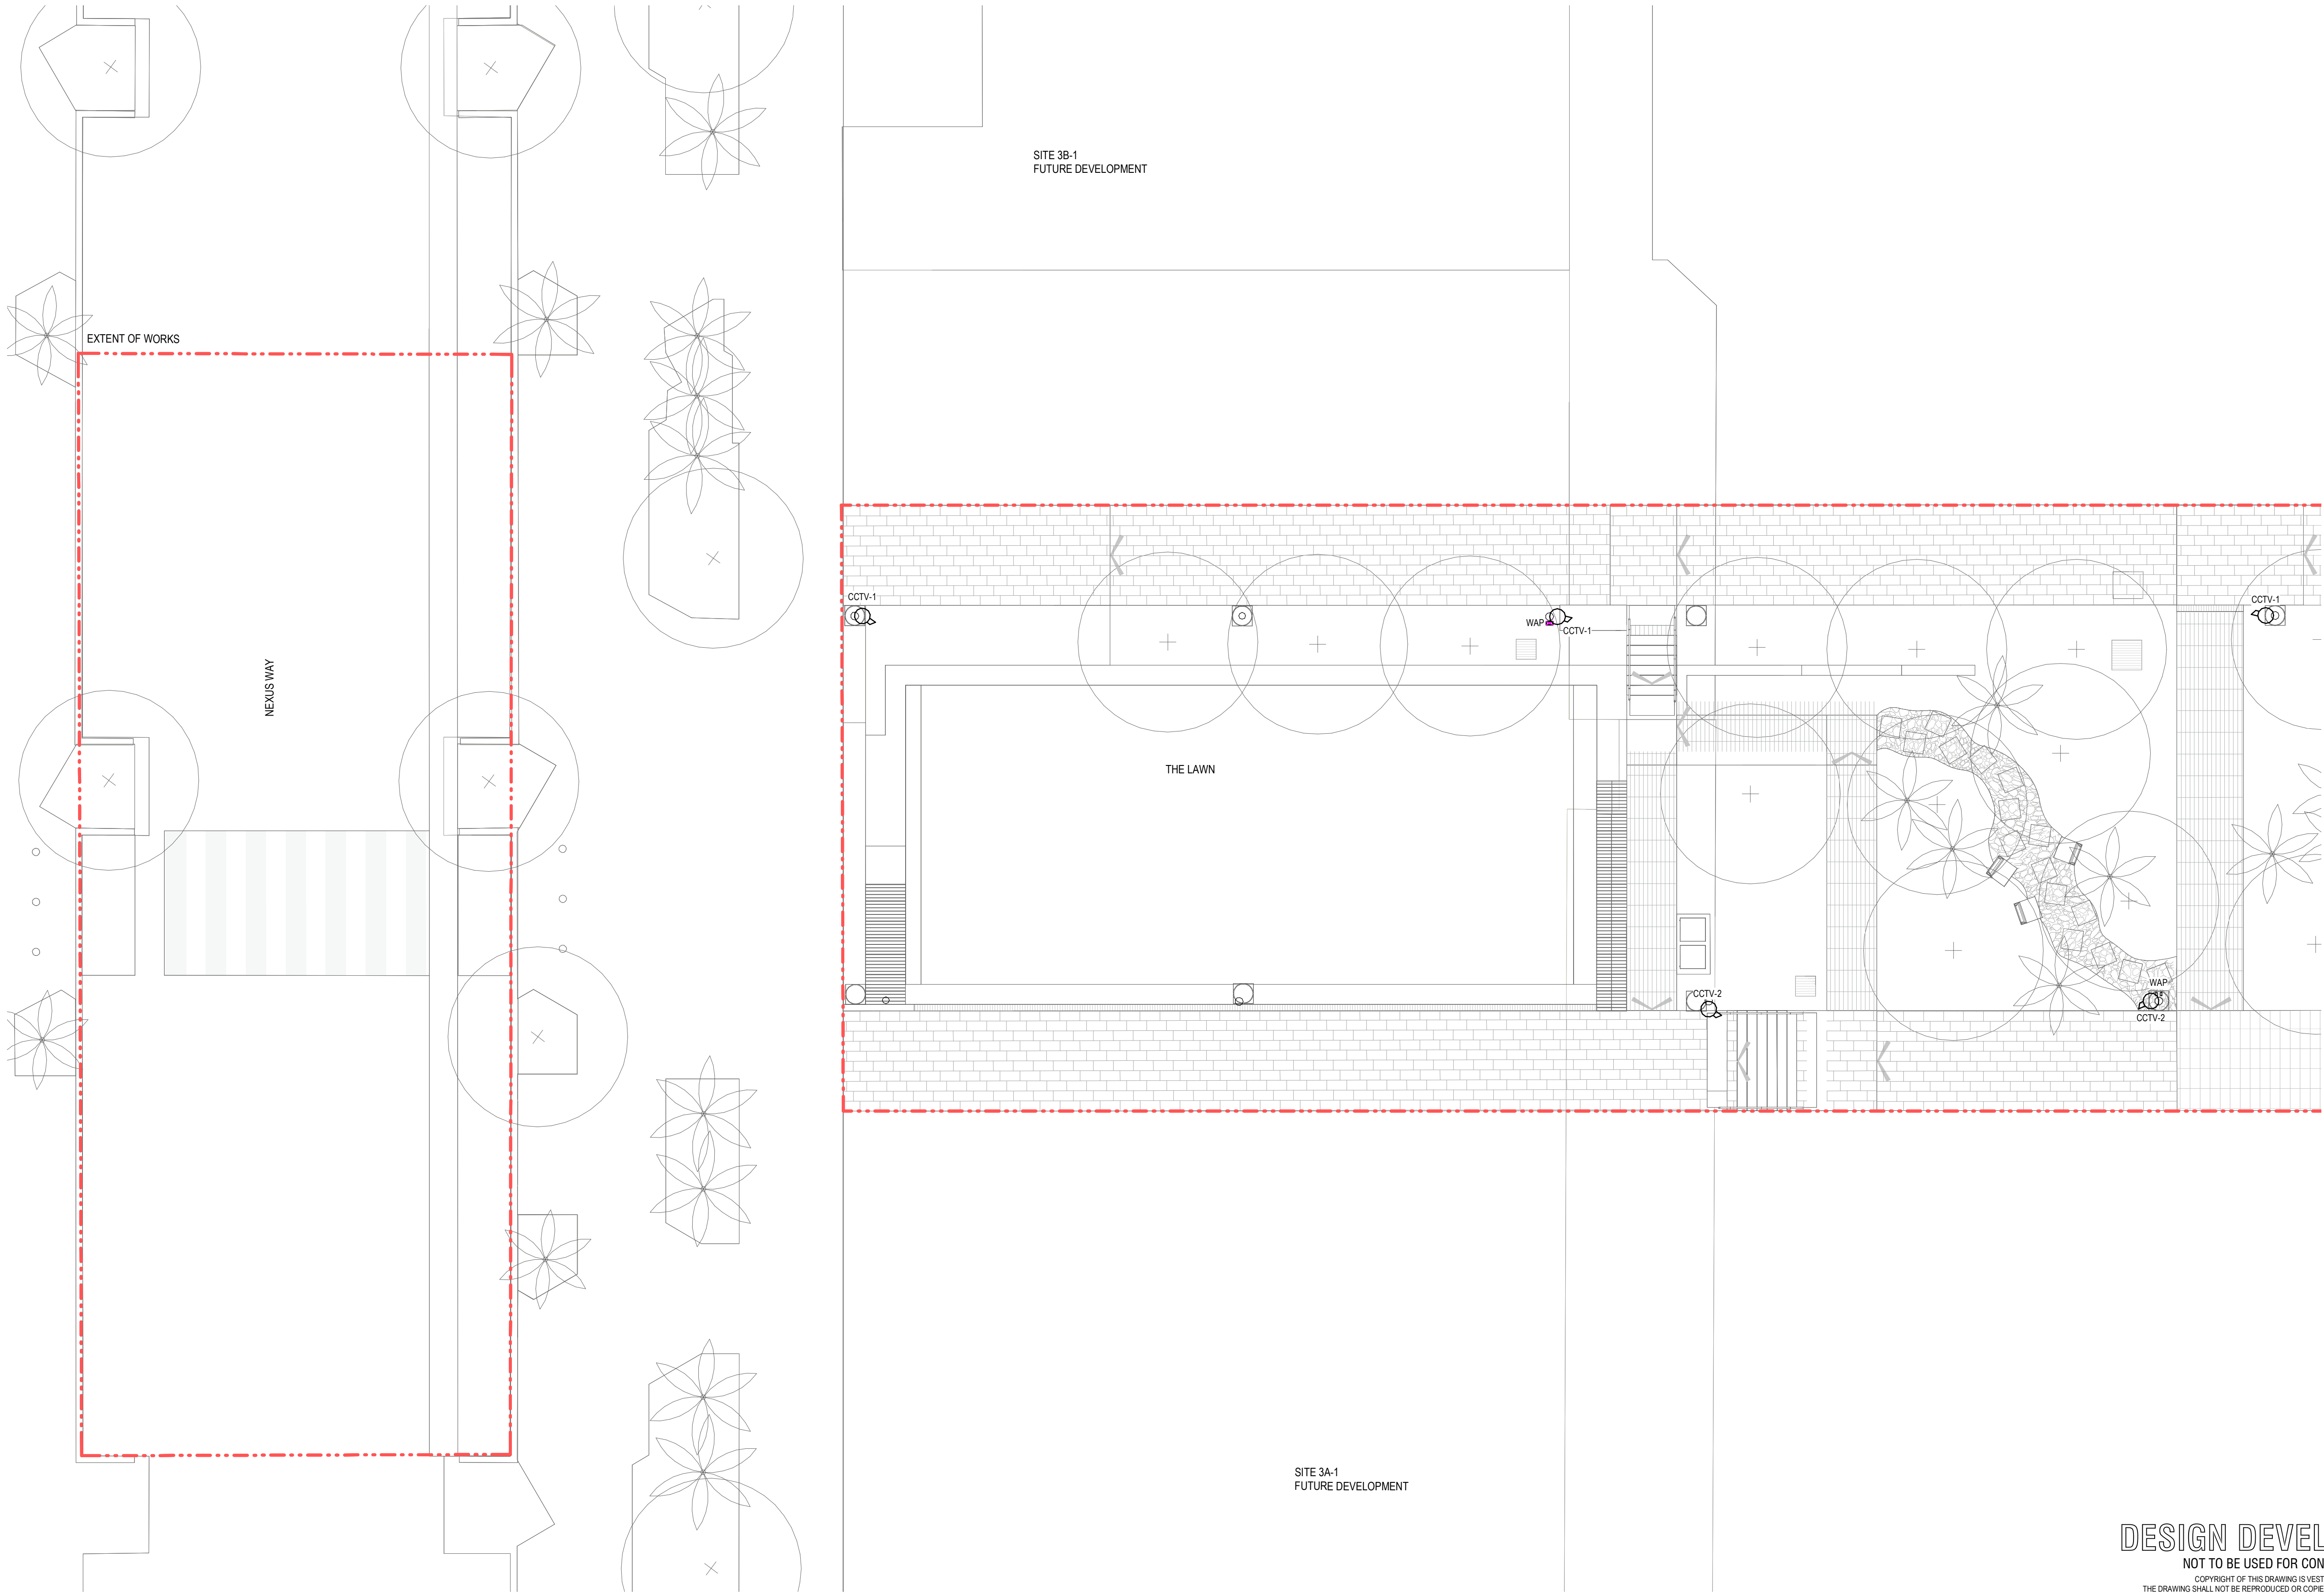


DESIGN DEVELOPMENT

NOT TO BE USED FOR CONSTRUCTION

COPYRIGHT OF THIS DRAWING IS VESTED IN INTROBA.

THE DRAWING SHALL NOT BE REPRODUCED OR COPIED IN WHOLE OR IN PART IN ANY FORM WITHOUT THE PRIOR WRITTEN APPROVAL OF INTROBA.

CONTRACTOR MUST VISIT SITE BEFORE TENDERING

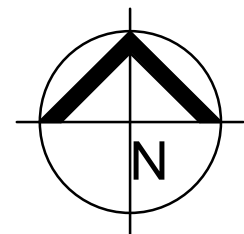

No.	DATE	REVISION	BY
1	17-05-23	90% DESIGN DEVELOPMENT	VL
2	26-05-23	95% DESIGN DEVELOPMENT CLIENT ISSUE	VL
3	21-07-23	100% DESIGN DEVELOPMENT ISSUE	VL

Client:




Economic Development Queensland (EDQ)

Architect:




Hassell

Hassell LTD ABN 24 007 711 435
Level2, Pier 8/9,23 Hickson Rd
Sydney NSW 2000 Australia
T +61 2 9101 2000
F +61 2 9101 2100
sydney@hassellstudio.com

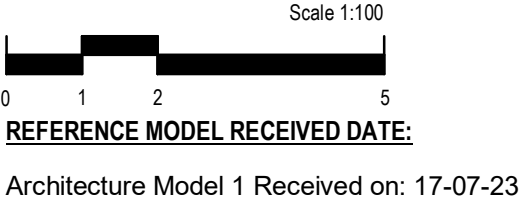

Key Plan:

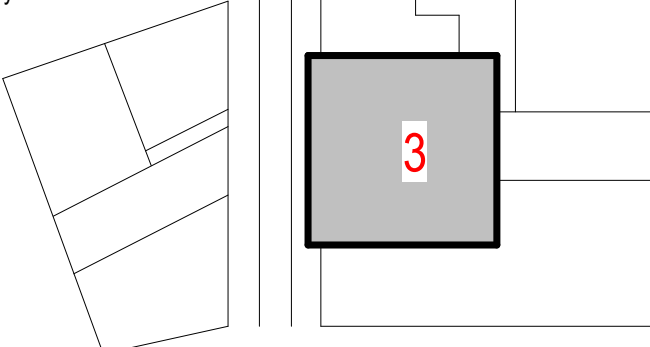

Introba

Brisbane
Level 7, 200 Creek Street
Brisbane, QLD 4000

hello@introba.com
www.introba.com

LUMINA OPEN SPACE

SOUTHPORT, QLD 4215

ELECTRICAL SERVICES

ICT LAYOUT SHEET 3

DRAWING REPRODUCTION

THIS SET OF DOCUMENTS CONTAINS DRAWINGS THAT HAVE BEEN CREATED IN COLOUR. REPRODUCTIONS MUST BE MADE IN COLOUR TO AVOID LOSS OF INFORMATION. FOR BLACK & WHITE PRINTING PLEASE CONTACT INTROBA FOR A REVISED SET OF BLACK & WHITE SPECIFIC DOCUMENTS.

DRAWN	CS	DATE	21-07-23
DESIGN	DDS	SCALE	1 : 100 @A1
CHECKED	-	PLOT RATIO	1 / A1
APPROVED	-	PROJECT No	62.0010071


62.0010071-E-3003

3

NOTES

1. REFER TO DRAWING E-0001 FOR LEGEND AND GENERAL NOTES


SITE 3B-2
FUTURE DEVELOPMENT

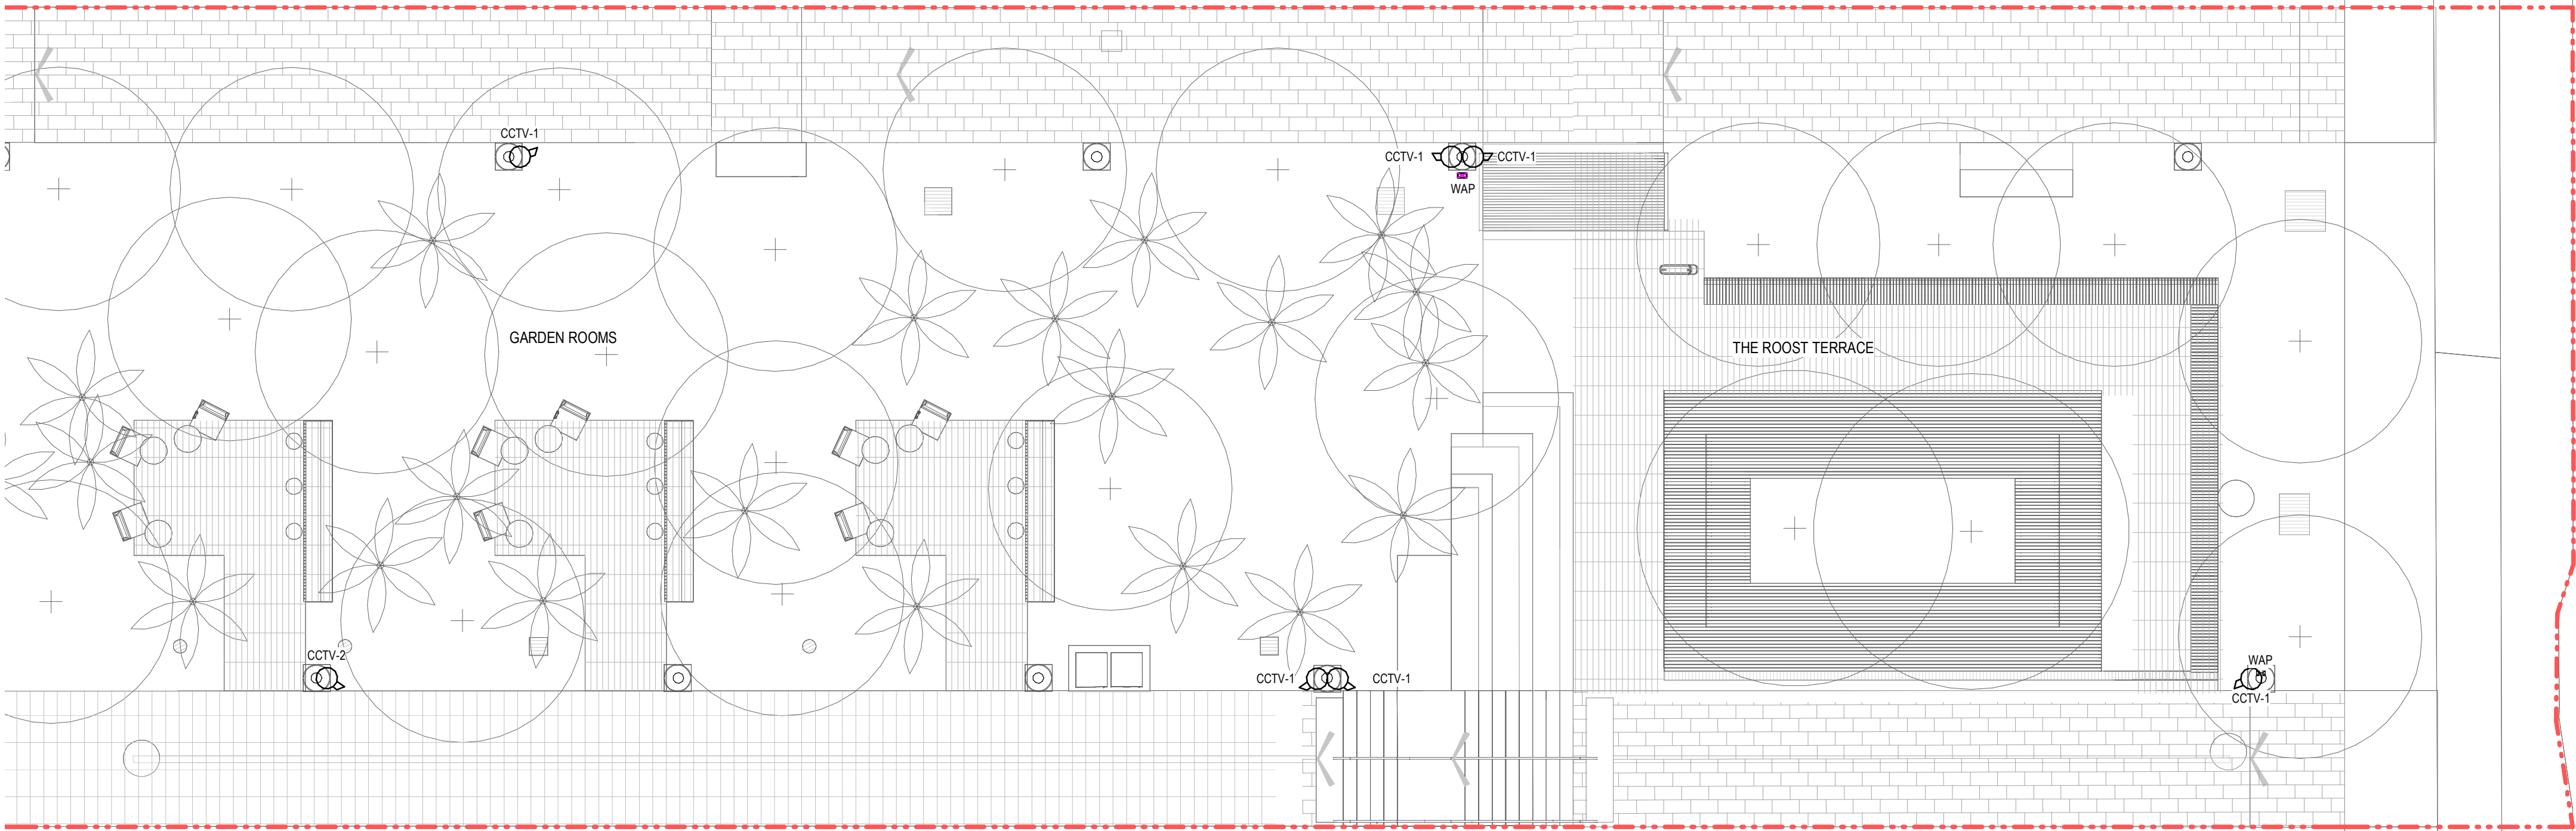

SITE 31-2
TRILOGY - DEVELOPMENT

DESIGN DEVELOPMENT

NOT TO BE USED FOR CONSTRUCTION
COPYRIGHT OF THIS DRAWING IS VESTED IN INTROBA.
THE DRAWING SHALL NOT BE REPRODUCED OR COPIED IN WHOLE OR IN PART IN ANY
FORM WITHOUT THE PRIOR WRITTEN APPROVAL OF INTROBA.
CONTRACTOR MUST VISIT SITE BEFORE TENDERING

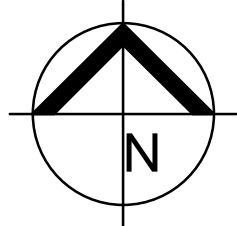

No.	DATE	REVISION	BY
1	26-05-23	95% DESIGN DEVELOPMENT CLIENT ISSUE	VL
2	21-07-23	100% DESIGN DEVELOPMENT ISSUE	VL

Client:




Economic Development Queensland (EDQ)


Architect:



Hassell
Hassell LTD ABN 24 007 711 435
Level2, Pier 8/9,23 Hickson Rd
Sydney NSW 2000 Australia
T +61 2 9101 2000
F +61 2 9101 2100
sydney@hassellstudio.com

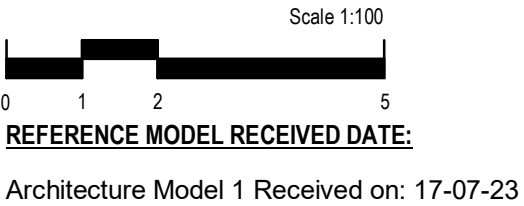

Key Plan:

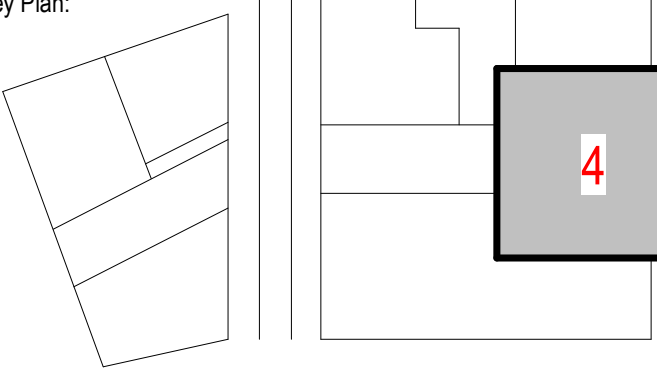

Introba
Brisbane
Level 7, 200 Creek Street
Brisbane, QLD 4000

hello@introba.com
www.introba.com

LUMINA OPEN SPACE
SOUTHPORT, QLD
4215

ELECTRICAL SERVICES
ICT LAYOUT SHEET 4

DRAWING REPRODUCTION
THIS SET OF DOCUMENTS CONTAINS DRAWINGS THAT HAVE BEEN CREATED IN COLOUR.
REPRODUCTIONS MUST BE MADE IN COLOUR TO AVOID LOSS OF INFORMATION.
FOR BLACK & WHITE PRINTING PLEASE CONTACT INTROBA FOR A REVISED SET OF
BLACK & WHITE SPECIFIC DOCUMENTS.

DRAWN	CS	DATE	21-07-23
DESIGN	DDS	SCALE	1 : 100 @A1
CHECKED	-	PLOT RATIO	1 / A1
APPROVED	-	PROJECT No	62.0010071

62.0010071-E-3004

2