



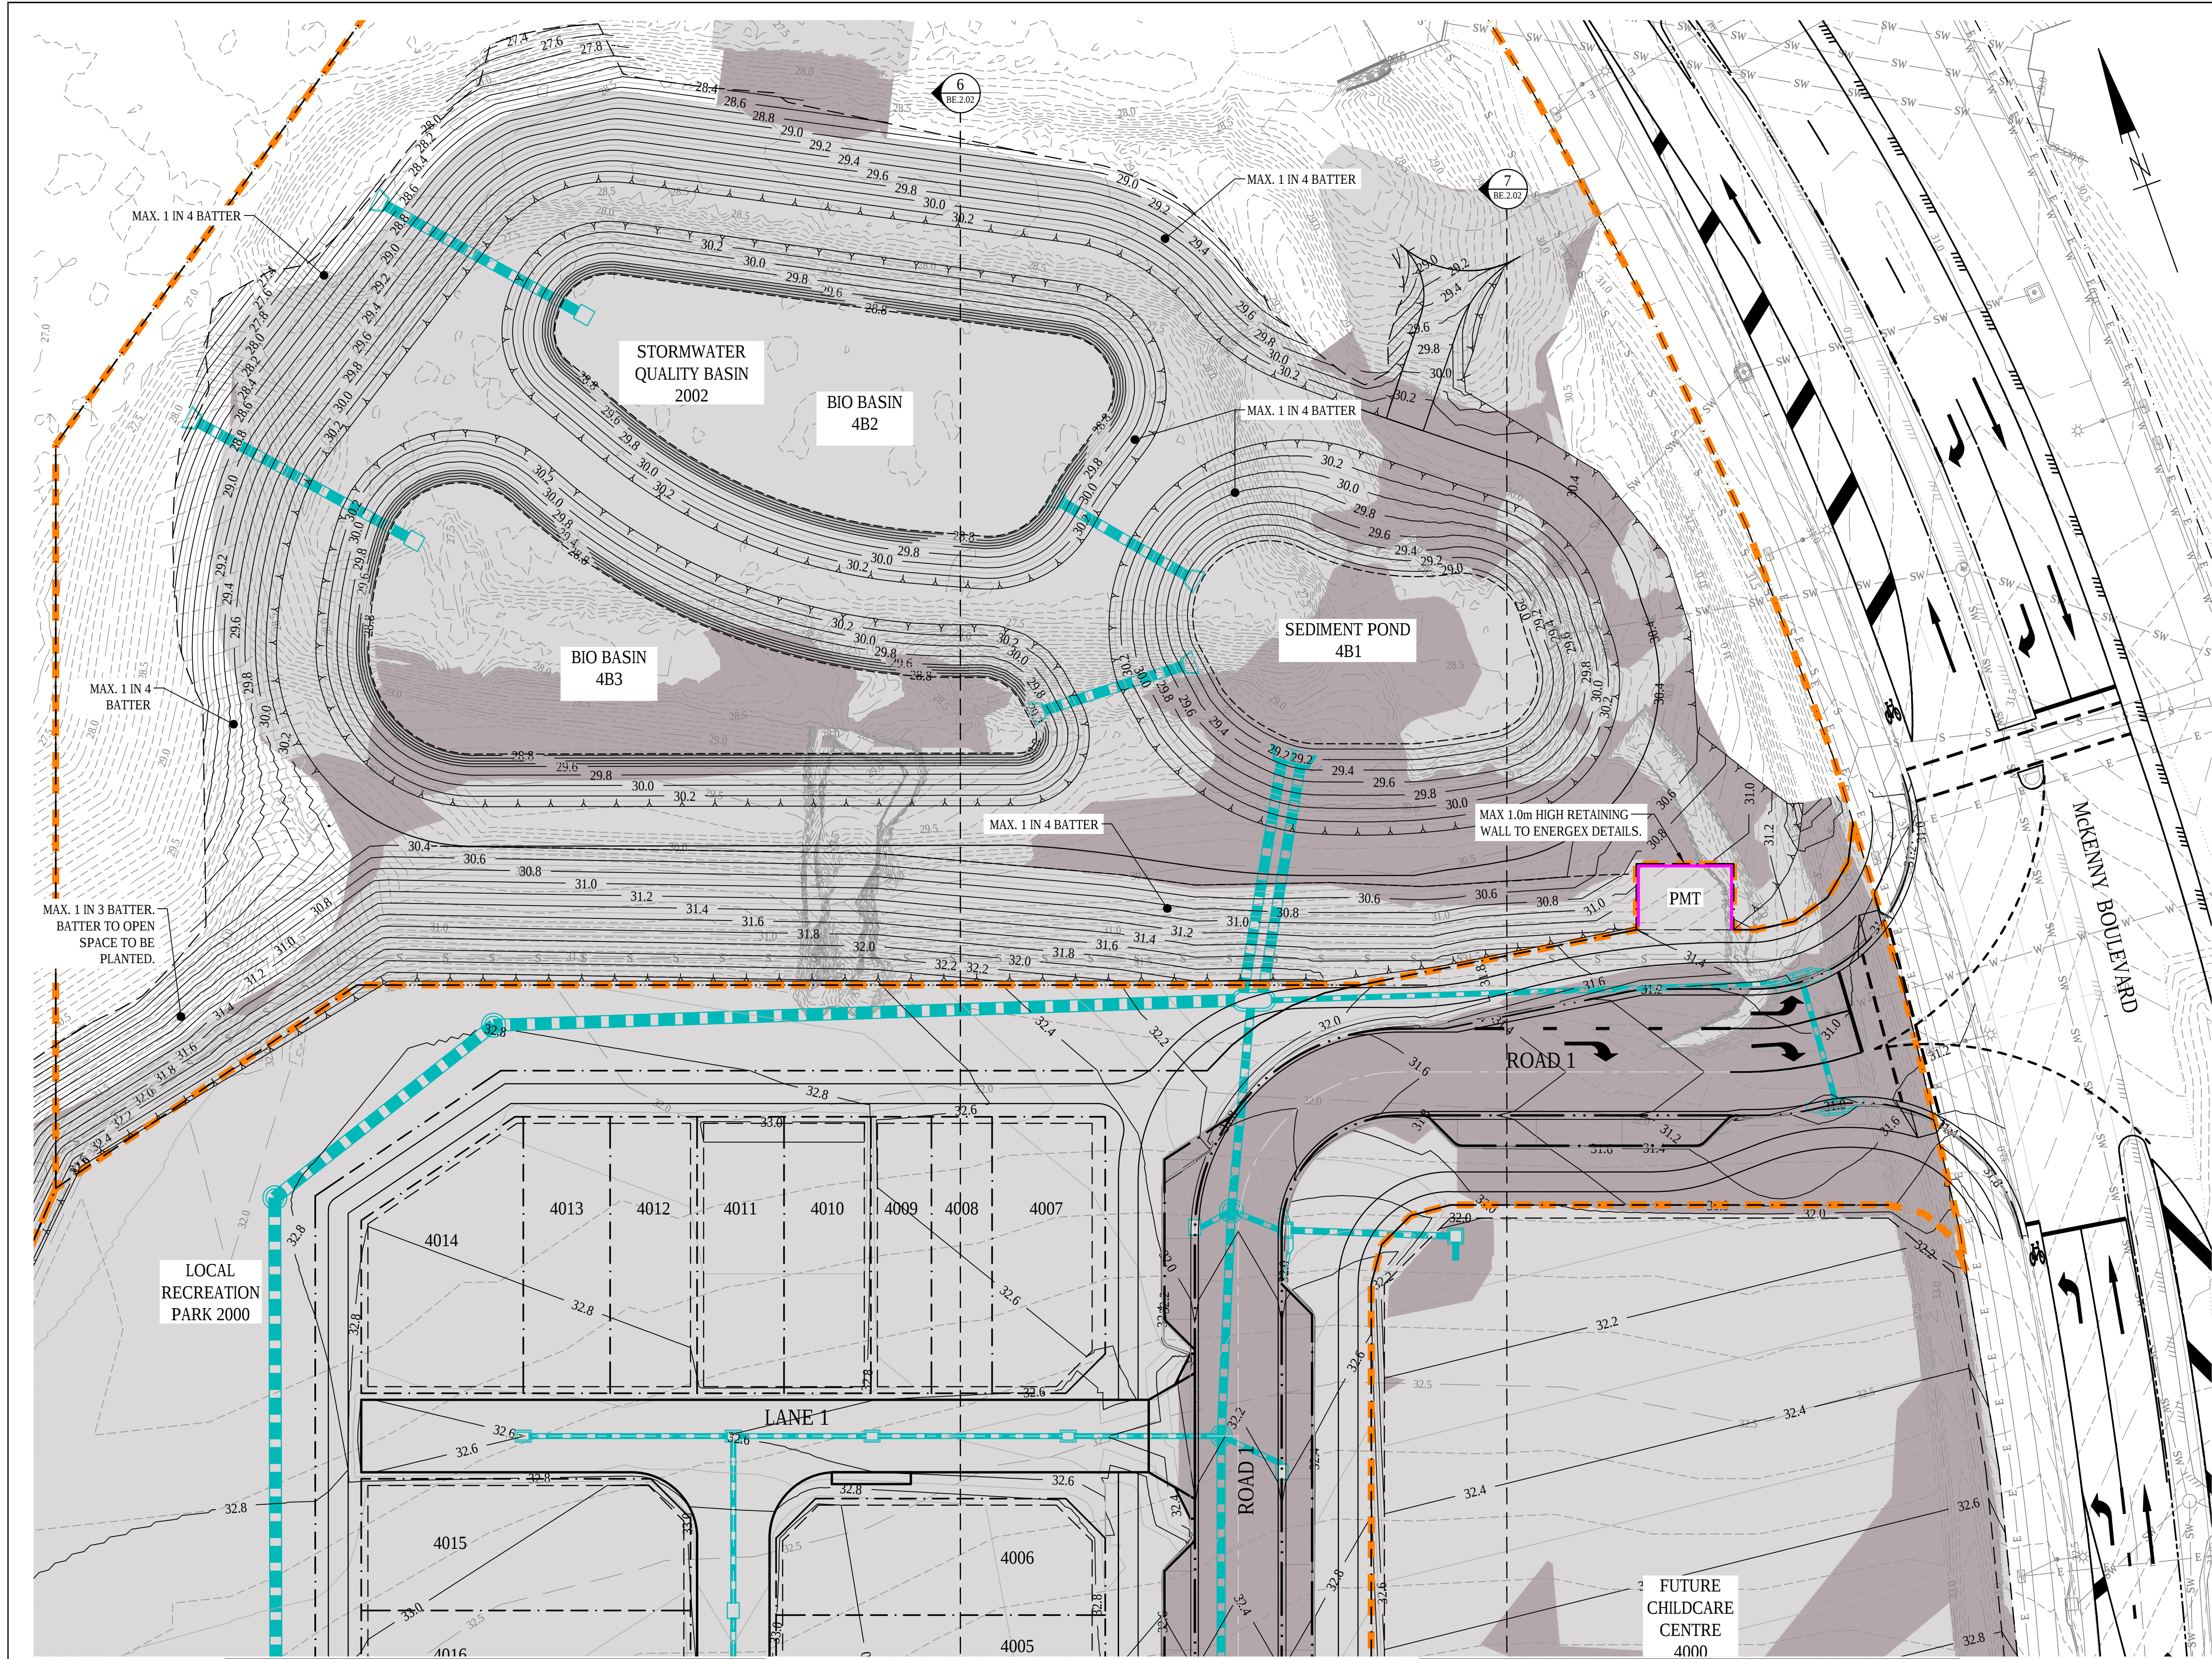


LEGEND			
EXISTING	PROPOSED		
	PROPERTY BOUNDARY		EASEMENT BOUNDARY
	CONTOUR		CONTOUR
	BUILDING		CONCRETE
	EDGE OF BITUMEN		KERB
	KERB AND CHANNEL		FLUSH KERB
	KERB RAMP		STORM WATER MAIN
	ROOFWATER		WATER MAIN
	SEWER MAIN		GAS MAIN
	TELECOMMUNICATIONS		OPTIC FIBRE
	U/G ELECTRICITY		O/H ELECTRICITY
	FENCE		TOP OF BATTER
	FACE OF BATTER		TOE OF BATTER
	SWALE DRAIN		RETAINING WALL
	CUT AREA		FILL AREA
	STAGE BOUNDARY		

PLANS AND DOCUMENTS referred to in the PDA DEVELOPMENT APPROVAL
Approval no: DEV2025/1667
Date: 23 October 2025

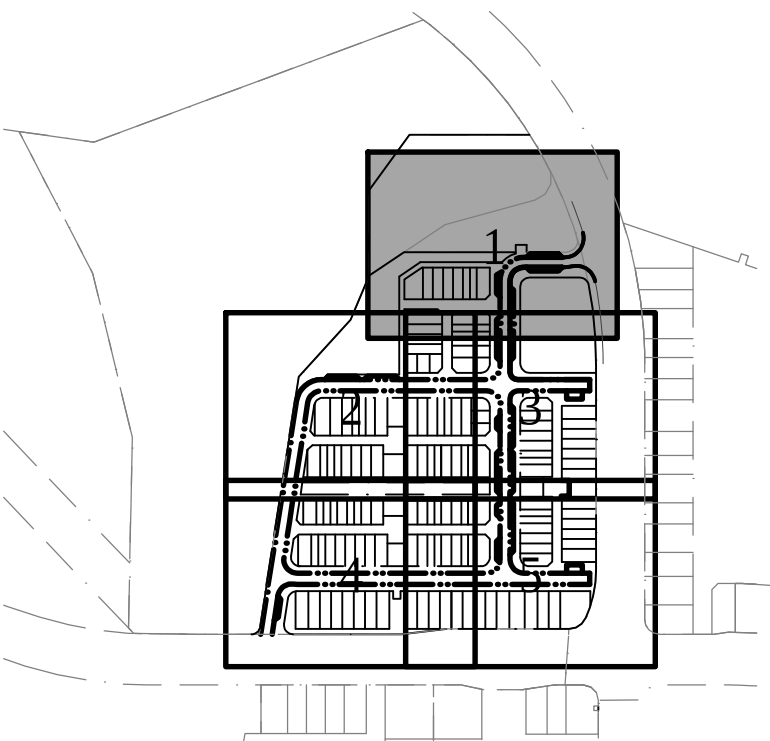

FOR CONTINUATION REFER DWG NO. BE.1.02

FOR CONTINUATION REFER DWG NO. BE.1.03

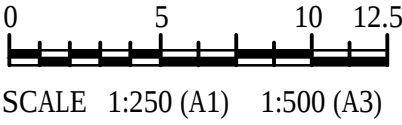

CONSULTANT: MPN CONSULTING PTY LTD
CONTACT:
TELEPHONE: (07) 3335 4555
DATE: _____

ISSUE	DATE	AMENDMENT	BY	APP
D	03.09.25	FOR APPROVAL	KC	LS
C	01.09.25	FOR APPROVAL	KC	LS
B	17.07.25	FOR APPROVAL	KC	LS
A	11.07.25	PRELIMINARY ISSUE	KC	LS

YARRABILBA PRECINT 4H
YARRABILBA, QLD 4207


SCALES: AS SHOWN
DESIGN: KC
DRAWN: ME
CHKD:
APPRD:
DATE:

CLIENT: Stockland
BULK EARTHWORKS PLAN
- SHEET 1

MPN CONSULTING



ABN: 39 062 191 799
P: 61 7 3335 4555
E: solutions@mpnc.au
Level 4, Building 3,
Kings Row Office Park,
42 McDougall Street, Milton, QLD, 4064
COPYRIGHT: THIS DESIGN AND PLANS ARE NOT TO BE USED OR REPRODUCED WHOLLY OR IN PART WITHOUT WRITTEN PERMISSION OF MPN CONSULTING PTY LIMITED 2023 ©

mpn JOB
10479
DRAWING No.
BE.1.01
REV
D

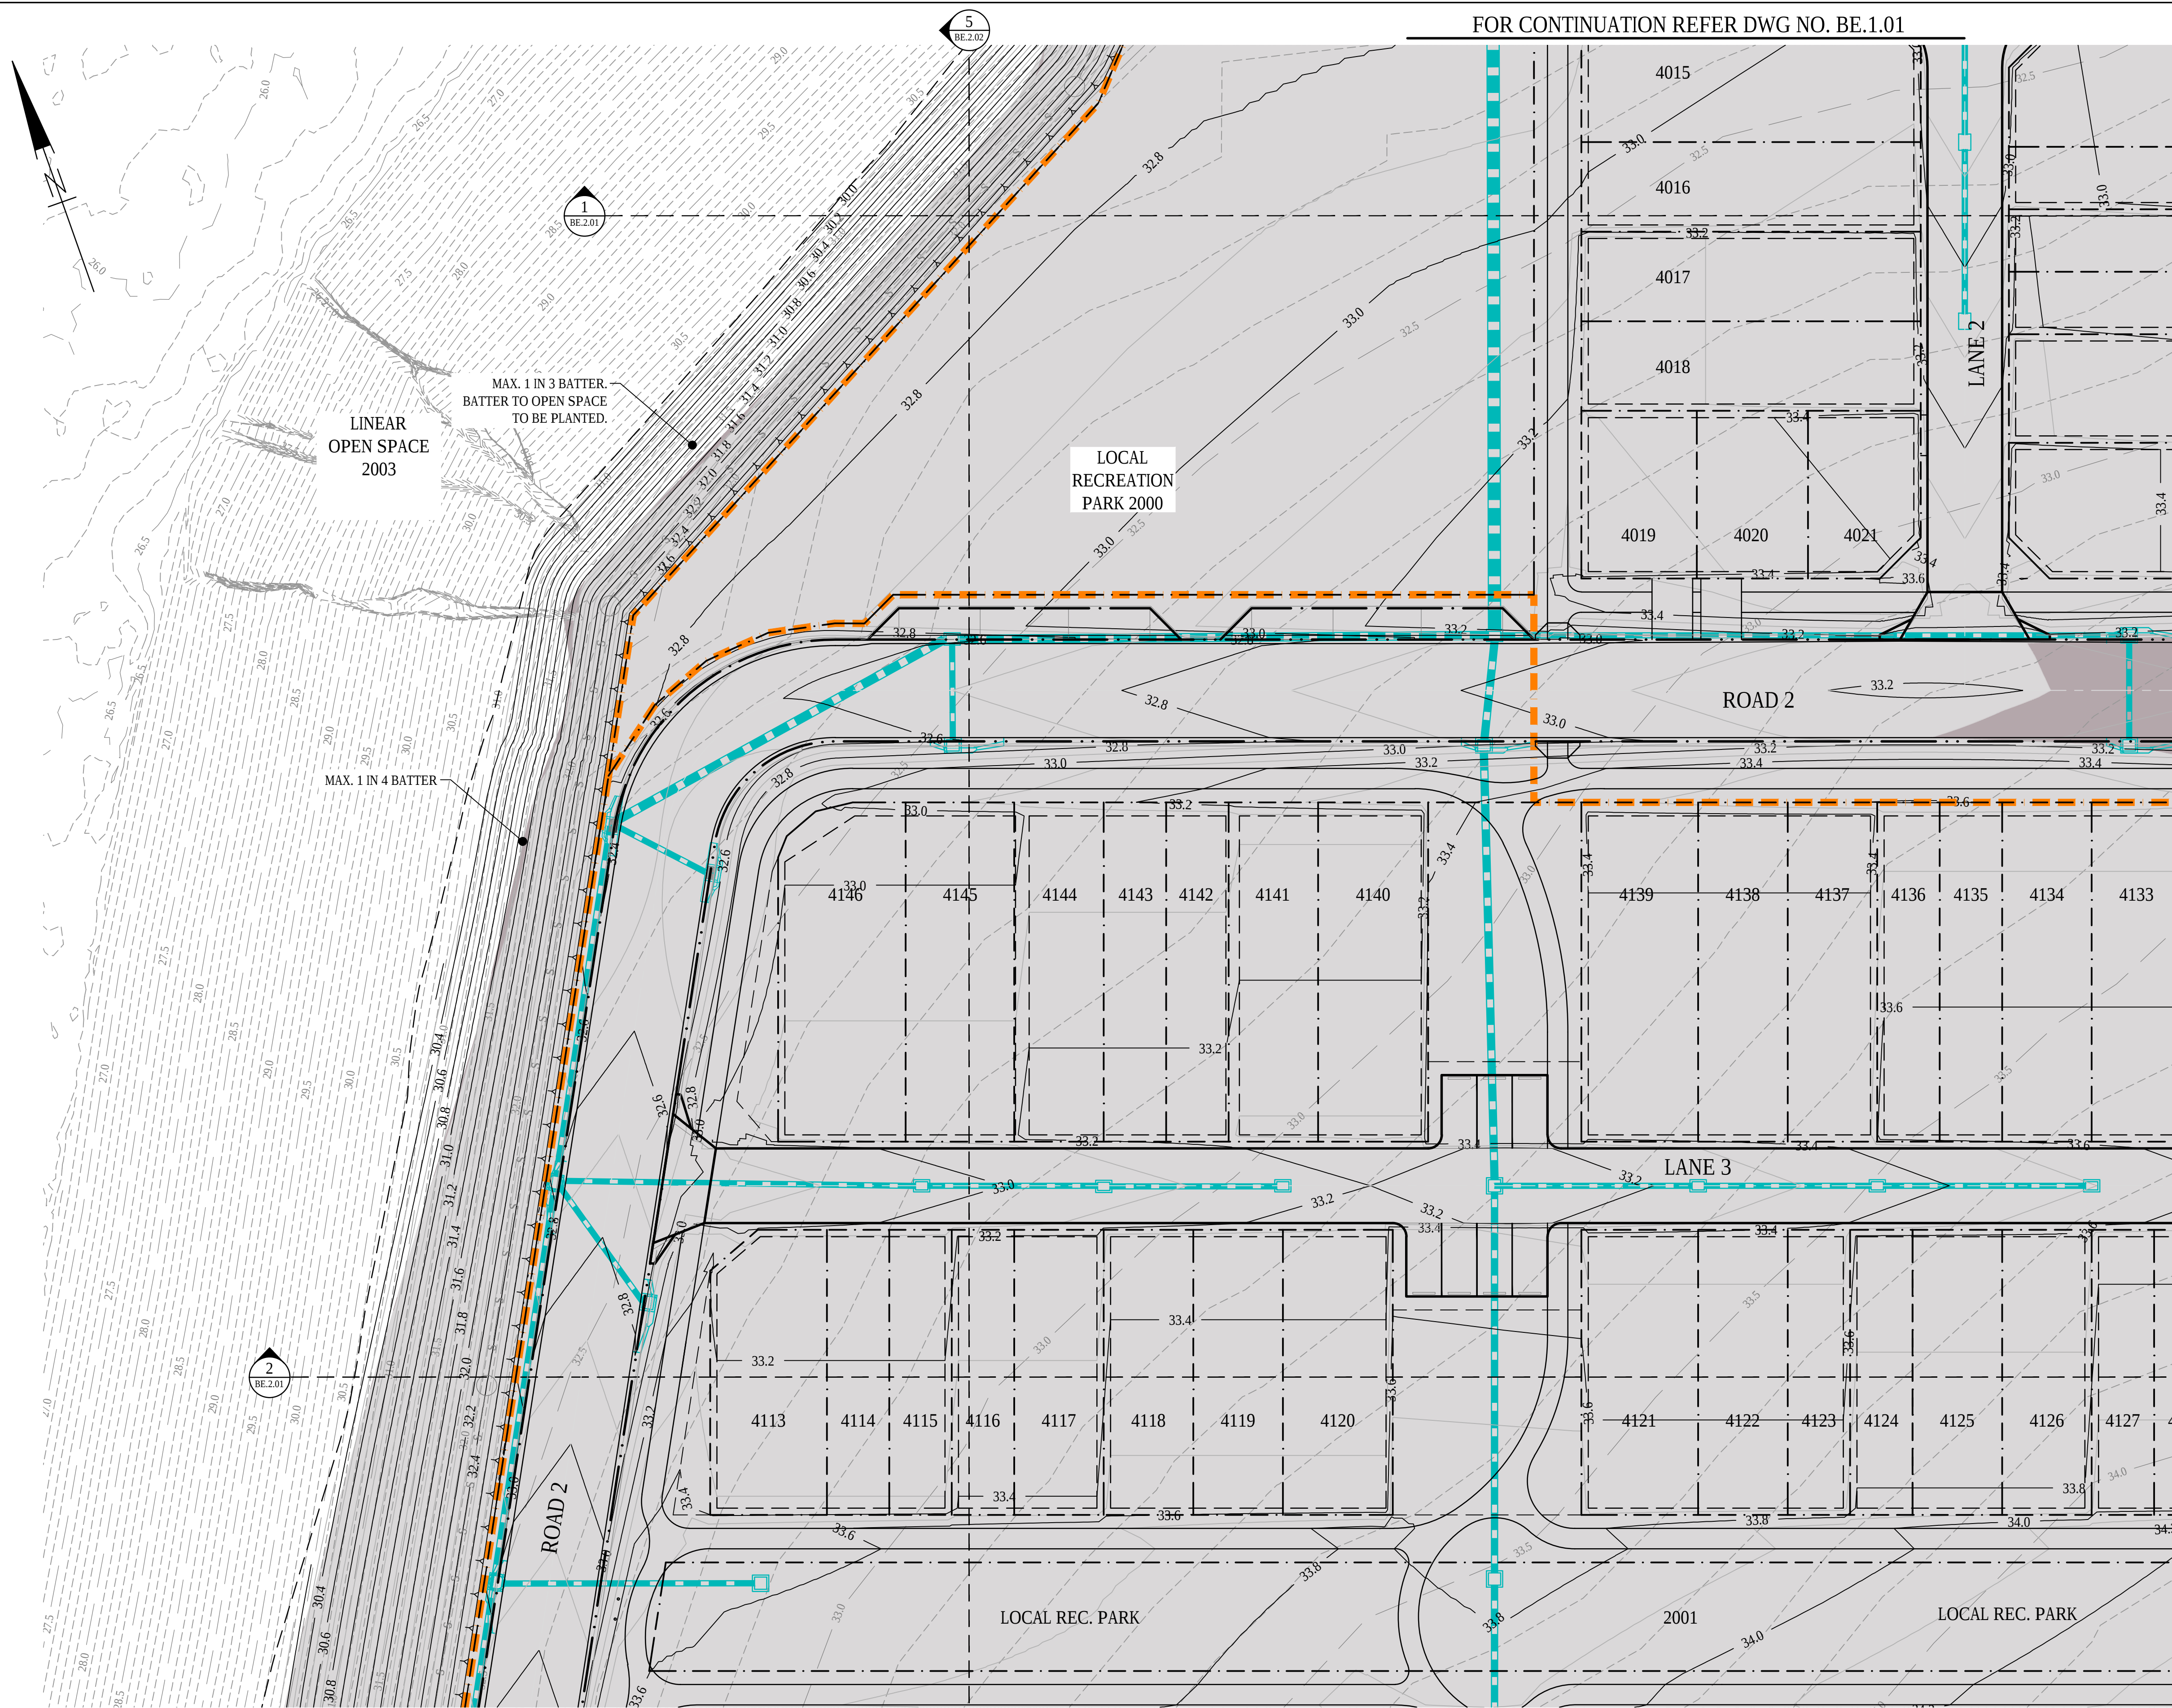

LEGEND			
EXISTING	PROPOSED		
	PROPERTY BOUNDARY		PROPERTY BOUNDARY
	EASEMENT BOUNDARY		EASEMENT BOUNDARY
	CONTOUR		CONTOUR
	BUILDING		BUILDING
	CONCRETE		CONCRETE
	EDGE OF BITUMEN		EDGE OF BITUMEN
	KERB		KERB
	KERB AND CHANNEL		KERB AND CHANNEL
	FLUSH KERB		FLUSH KERB
	KERB RAMP		KERB RAMP
	STORM WATER MAIN		STORM WATER MAIN
	ROOFWATER		ROOFWATER
	WATER MAIN		WATER MAIN
	SEWER MAIN		SEWER MAIN
	GAS MAIN		GAS MAIN
	TELECOMMUNICATIONS		TELECOMMUNICATIONS
	OPTIC FIBRE		OPTIC FIBRE
	U/G ELECTRICITY		U/G ELECTRICITY
	O/H ELECTRICITY		O/H ELECTRICITY
	FENCE		FENCE
	TOP OF BATTER		TOP OF BATTER
	FACE OF BATTER		FACE OF BATTER
	TOE OF BATTER		TOE OF BATTER
	SWALE DRAIN		SWALE DRAIN
	RETAINING WALL		RETAINING WALL
	CUT AREA		CUT AREA
	FILL AREA		FILL AREA
	STAGE BOUNDARY		STAGE BOUNDARY

PLANS AND DOCUMENTS referred to in the PDA DEVELOPMENT APPROVAL
Approval no: DEV2025/1667
Date: 23 October 2025

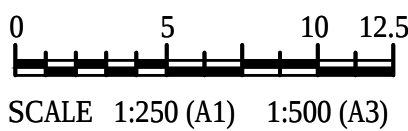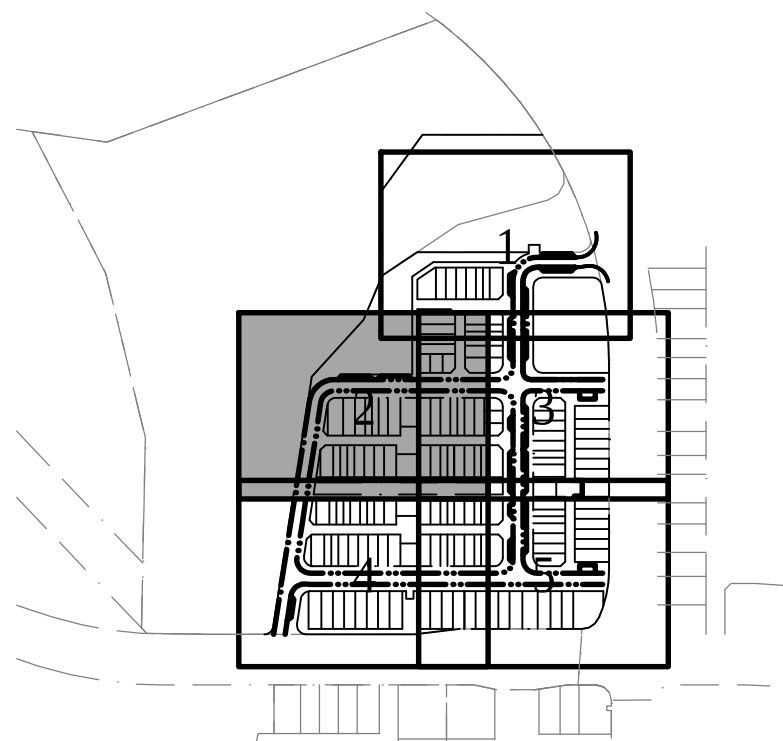

CONSULTANT: MPN CONSULTING PTY LTD
CONTACT:
TELEPHONE: (07) 3335 4555
DATE: -

ISSUE	DATE	AMENDMENT	BY	APP
D	03.09.25	FOR APPROVAL	KC	LS
C	01.09.25	FOR APPROVAL	KC	LS
B	17.07.25	FOR APPROVAL	KC	LS
A	11.07.25	PRELIMINARY ISSUE	KC	LS

YARRABILBA PRECINT 4H
YARRABILBA, QLD 4207

SCALES: AS SHOWN
DESIGN: KC
DRAWN: KC
CHKD:
APPRD:
DATE:


CLIENT: Stockland
BULK EARTHWORKS PLAN
- SHEET 2



ABN: 39 062 191 799
P: 61 7 3335 4555
E: solutions@mpncau
Level 4, Building 3,
Kings Row Office Park,
42 McDougall Street, Milton, QLD, 4064
COPYRIGHT: THIS DESIGN AND PLANS ARE NOT TO BE USED OR REPRODUCED WHOLLY OR IN PART WITHOUT WRITTEN PERMISSION OF MPN CONSULTING PTY LIMITED 2023 ©



mpn JOB
10479
DRAWING No.
BE.1.02
REV
D

FOR CONTINUATION REFER DWG NO. BE.1.03

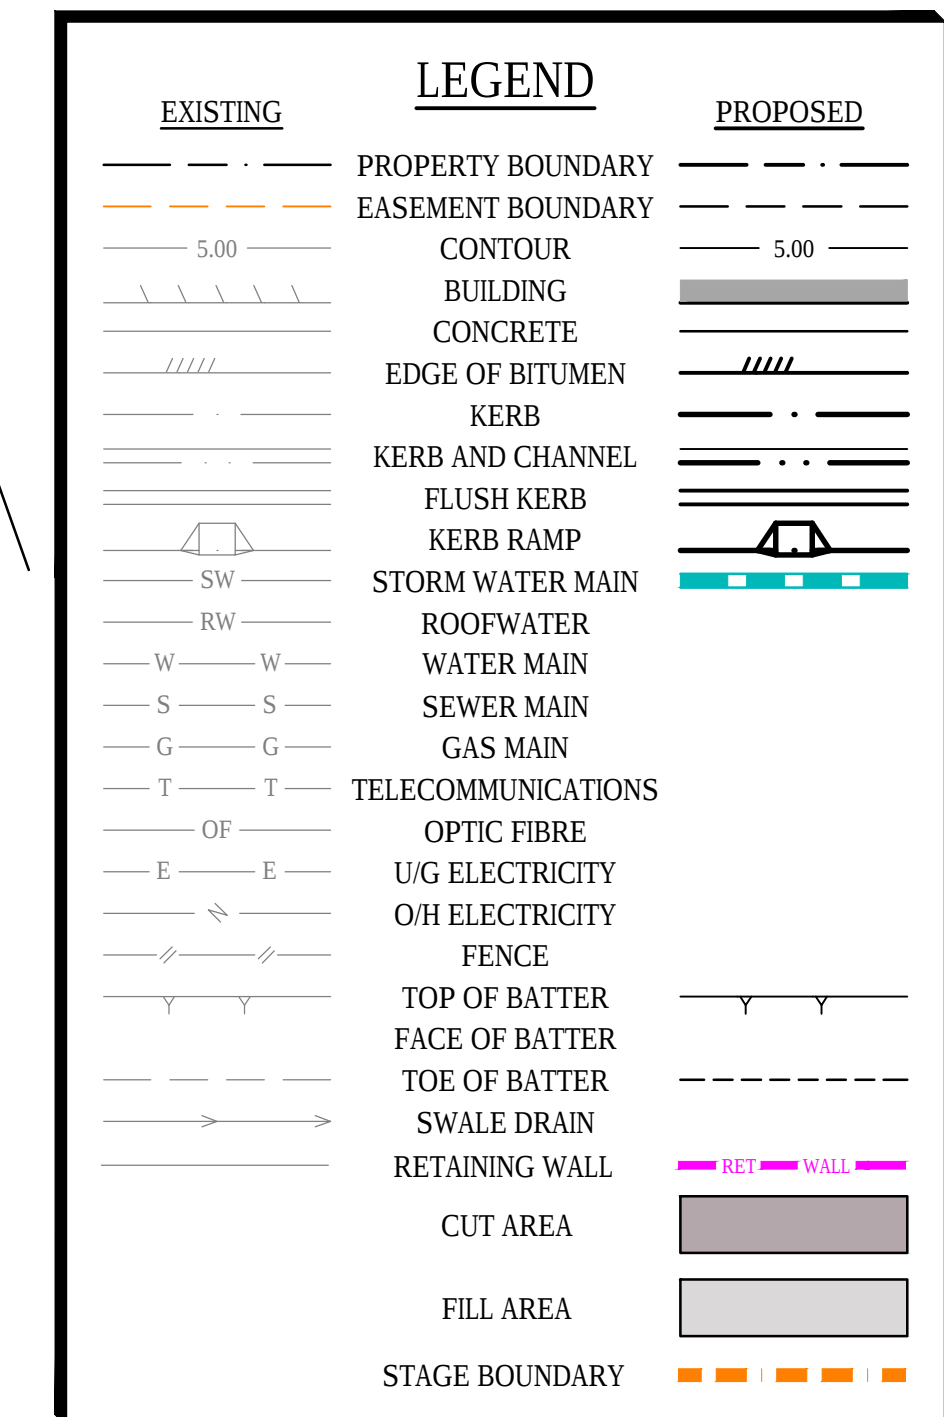

Queensland
Government

FOR CONTINUATION REFER DWG NO. BE.1.05

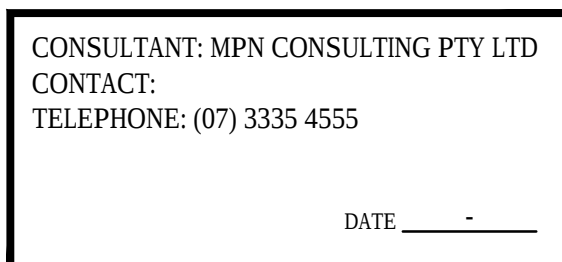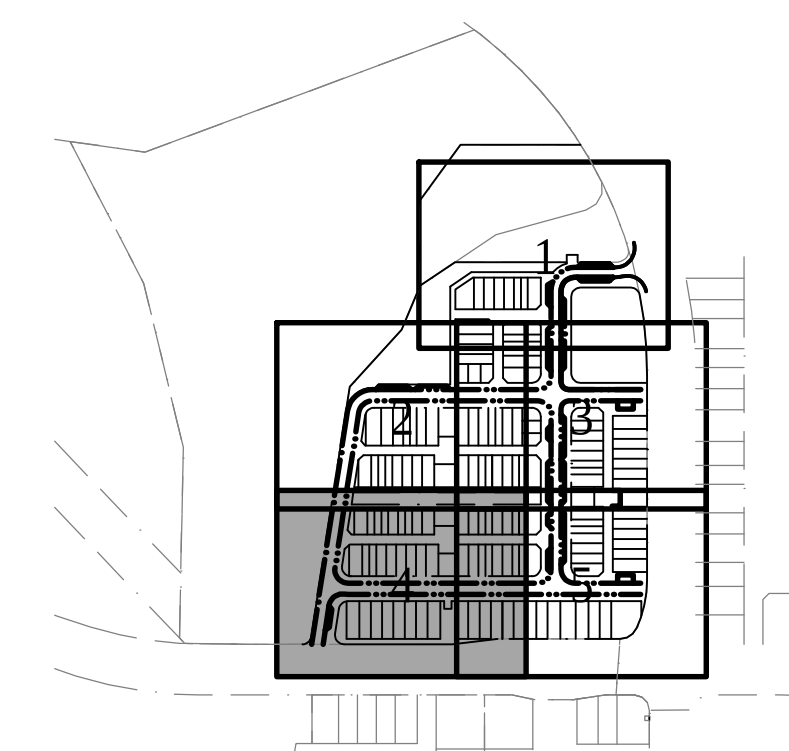

E	14.10.25	FOR APPROVAL	KC	LS
D	03.09.25	FOR APPROVAL	KC	LS
C	01.09.25	FOR APPROVAL	KC	LS
B	17.07.25	FOR APPROVAL	KC	LS
A	11.07.25	PRELIMINARY ISSUE	KC	LS
ISSUE	DATE	AMENDMENT	BY	APP

YARRABILBA PRECINT 4H

YARRABILBA, OLD 4207

SCALES:	AS SHOWN
DESIGN:	KC
DRAWN:	KC
CHKD:	
APPRD:	
DATE:	

CLIENT:  Stockland
BULK EARTHWORKS PLAN
- SHEET 4




COPYRIGHT: THIS DESIGN AND PLANS ARE NOT TO BE USED OR REPRODUCED WHOLLY OR IN PART WITHOUT WRITTEN PERMISSION OF MPN CONSULTING PTY LIMITED 2023

ABN: 39 062 191 799
P: 61 7 3335 4555
E: solutions@mpnc.au
Level 4, Building 3,
Kings Row Office Park,
Hall Street, Milton, QLD, 4064

mpn JOB
10479
DRAWING No.
BE.1.04

RE
F

FOR CONTINUATION REFER DWG NO. BE.1.03

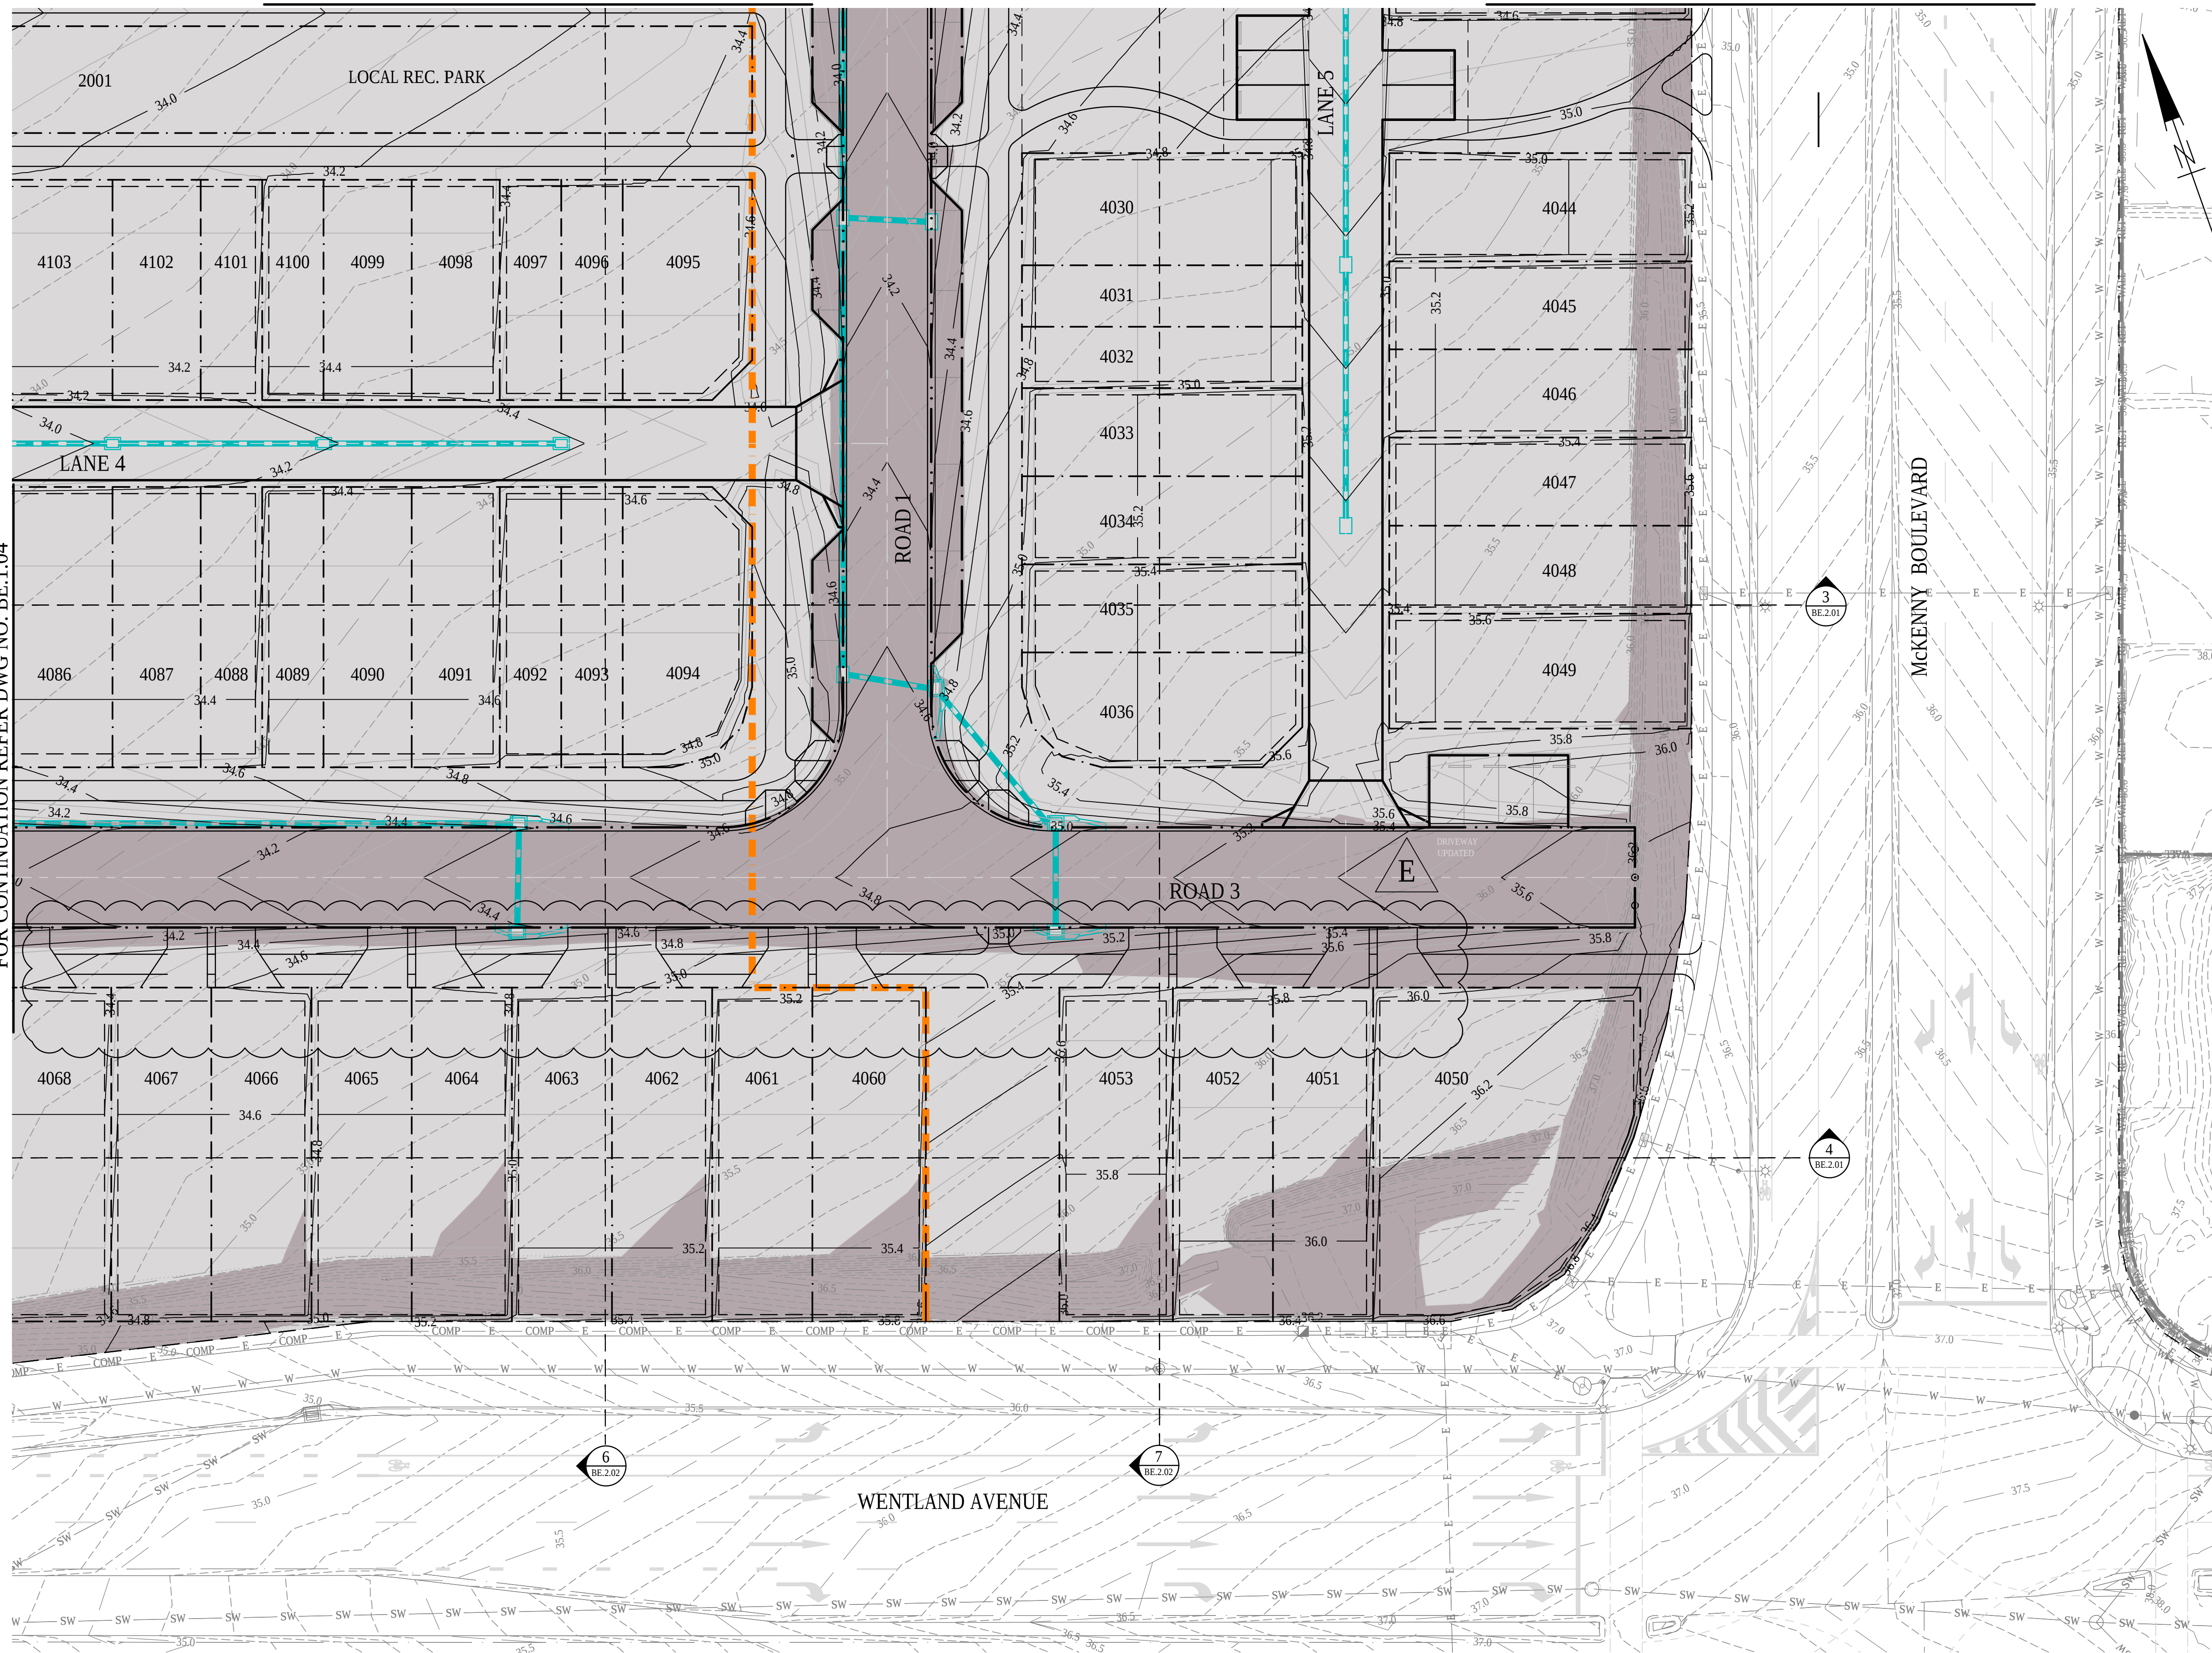

EXISTING	LEGEND	PROPOSED
— — — — —	PROPERTY BOUNDARY	— — — — —
— — — — —	EASEMENT BOUNDARY	— — — — —
5.00	CONTOUR	5.00
	BUILDING	
	CONCRETE	
— — — — —	EDGE OF BITUMEN	— — — — —
— — — — —	KERB	— — — — —
— — — — —	KERB AND CHANNEL	— — — — —
— — — — —	FLUSH KERB	— — — — —
— — — — —	KERB RAMP	
SW	STORM WATER MAIN	
RW	ROOFWATER	
W — W	WATER MAIN	
S — S	SEWER MAIN	
G — G	GAS MAIN	
T — T	TELECOMMUNICATIONS	
OF	OPTIC FIBRE	
E — E	U/G ELECTRICITY	
≡	O/H ELECTRICITY	
≡	FENCE	
Y — Y	TOP OF BATTER	— Y — Y —
— — — — —	FACE OF BATTER	— — — — —
— — — — —	TOE OF BATTER	— — — — —
→ — →	SWALE DRAIN	
— — — — —	RETAINING WALL	
	CUT AREA	
	FILL AREA	
	STAGE BOUNDARY	


PLANS AND DOCUMENTS
referred to in the PDA
DEVELOPMENT APPROVAL

Approval no: DEV2025/1667

Date: 23 October 2025



Queensland
Government

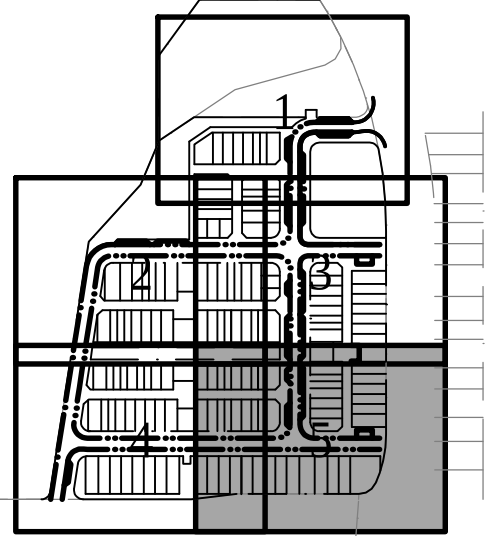

CONSULTANT: MPN CONSULTING PTY LTD
CONTACT:
TELEPHONE: (07) 3335 4555

DATE _____

E	14.10.25	FOR APPROVAL	KC	LS
D	03.09.25	FOR APPROVAL	KC	LS
C	01.09.25	FOR APPROVAL	KC	LS
B	17.07.25	FOR APPROVAL	KC	LS
A	11.07.25	PRELIMINARY ISSUE	KC	LS
ISSUE	DATE	AMENDMENT	BY	APP

YARRABILBA, QLD 4207

SCALES:	AS SHOWN
DESIGN:	KC
DRAWN:	KC
CHKD:	
APPRD:	
DATE:	

CLIENT:  **Stockland**

BULK EARTHWORKS PLAN
- SHEET 5





COPYRIGHT: THIS DESIGN AND PLANS ARE NOT TO BE USED OR REPRODUCED WHOLLY OR IN PART WITHOUT WRITTEN PERMISSION OF MPN CONSULTING PTY LIMITED 2023 ©

ABN: 39 062 191 799
P: 61 7 3335 4555
E: solutions@mpnc.au

Level 4, Building 3,
Kings Row Office Park,
Street, Milton, QLD, 4064

mpn JOB
10479
 DRAWING No.
BE.1.05

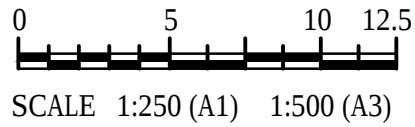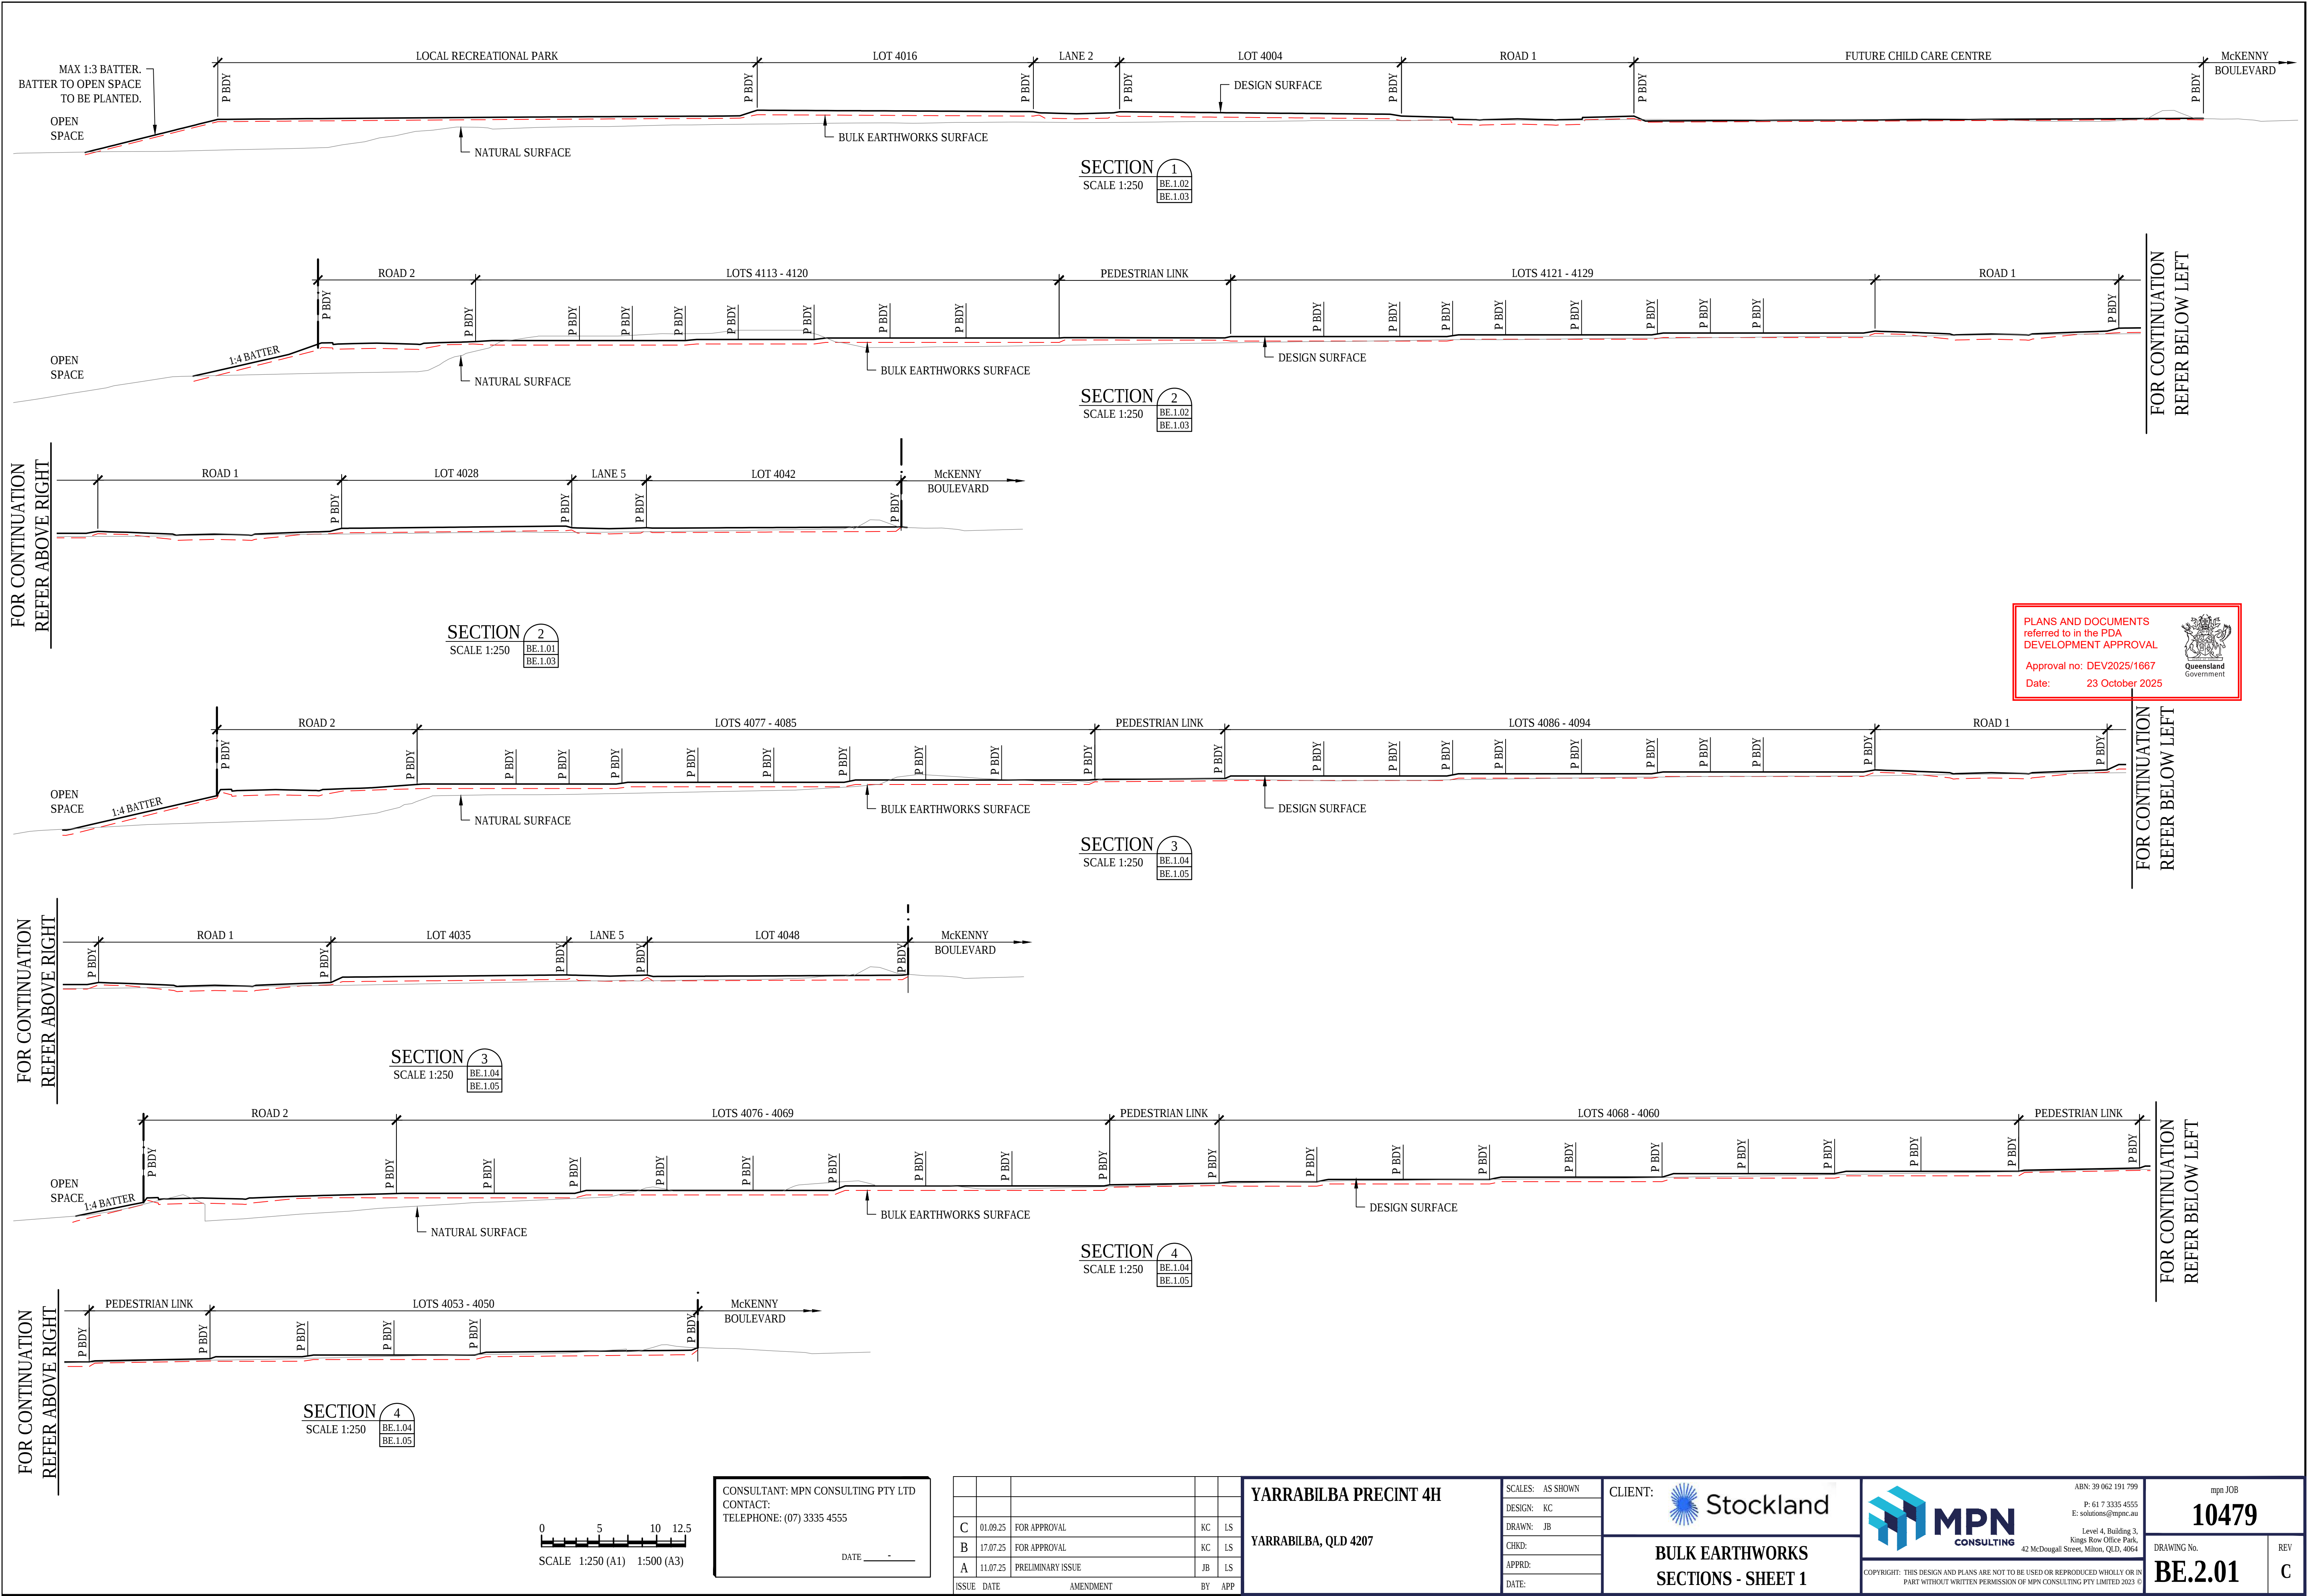

CONSULTANT: MPN CONSULTING PTY LTD
CONTACT:
TELEPHONE: (07) 3335 4555
DATE: -

C	01.09.25	FOR APPROVAL		KC	LS
B	17.07.25	FOR APPROVAL		KC	LS
A	11.07.25	PRELIMINARY ISSUE		JB	LS
ISSUE	DATE	AMENDMENT	BY	APP	


YARRABILBA PRECINT 4H
YARRABILBA, QLD 4207

SCALES: AS SHOWN
DESIGN: KC
DRAWN: JB
CHKD:
APPRD:
DATE:


CLIENT:  Stockland
BULK EARTHWORKS
SECTIONS - SHEET 1

 MPN CONSULTING
ABN: 39 062 191 799
P: 61 7 3335 4555
E: solutions@mpnc.au
Level 4, Building 3,
Kings Row Office Park,
42 McDougall Street, Milton, QLD, 4064
COPYRIGHT: THIS DESIGN AND PLANS ARE NOT TO BE USED OR REPRODUCED WHOLLY OR IN PART WITHOUT WRITTEN PERMISSION OF MPN CONSULTING PTY LIMITED 2023 ©


mpn JOB
10479
DRAWING No.
BE.2.01
REV
C

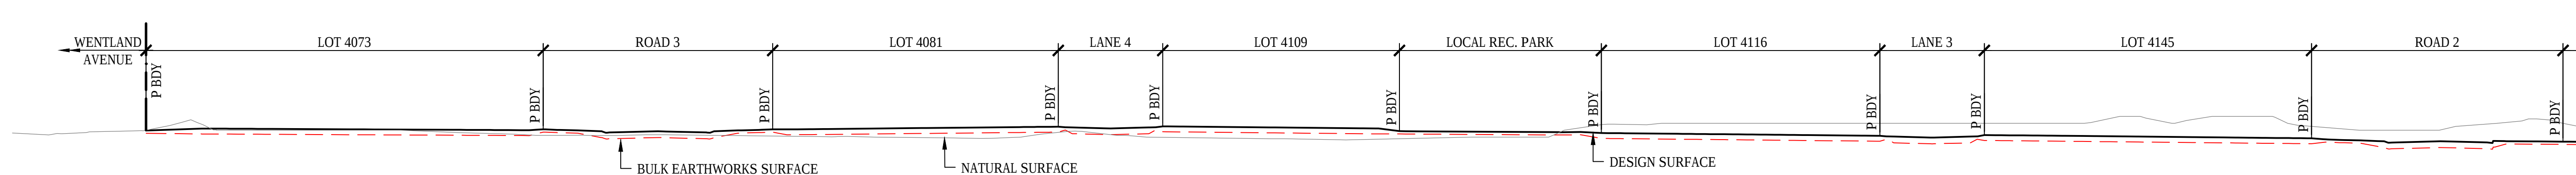


SECTION 5
SCALE 1:250
BE.1.02
BE.1.04

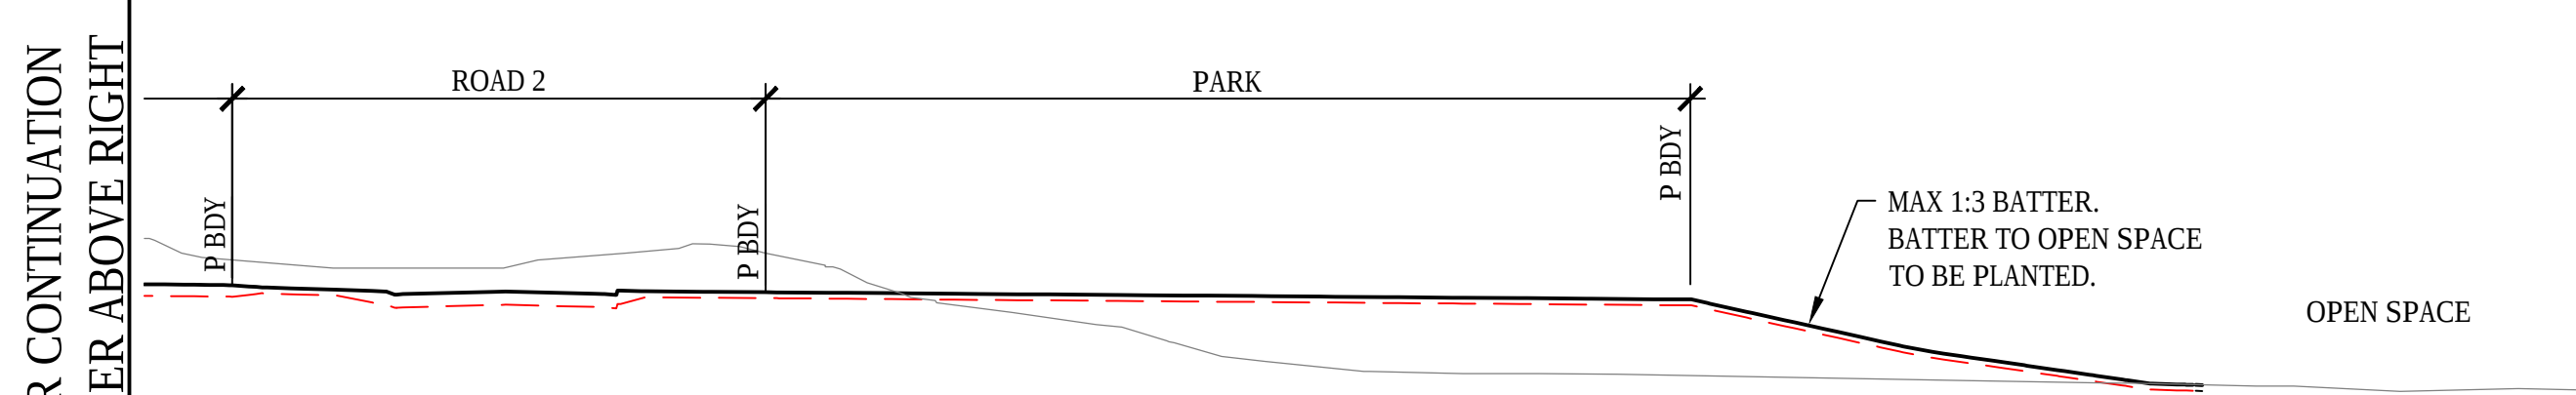


SECTION 5
SCALE 1:250
BE.1.02
BE.1.04

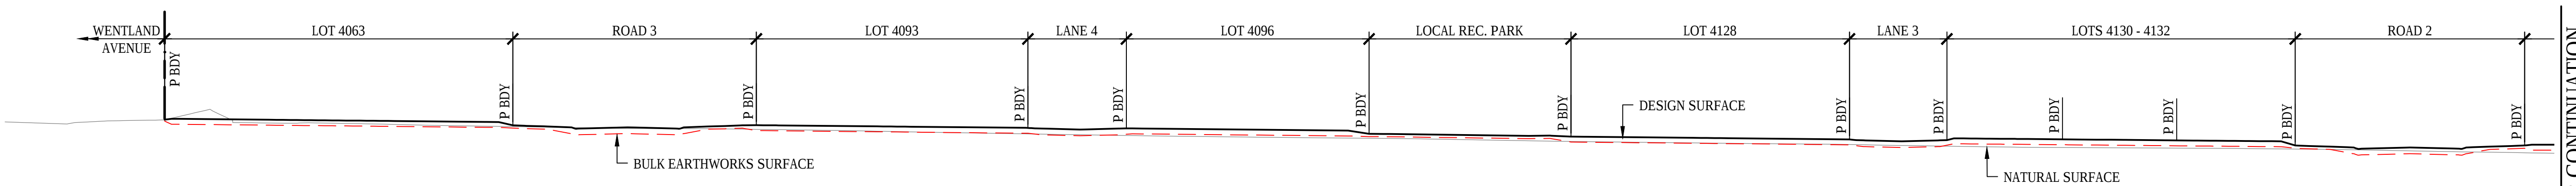


SECTION 6
SCALE 1:250
BE.1.01
BE.1.03
BE.1.05

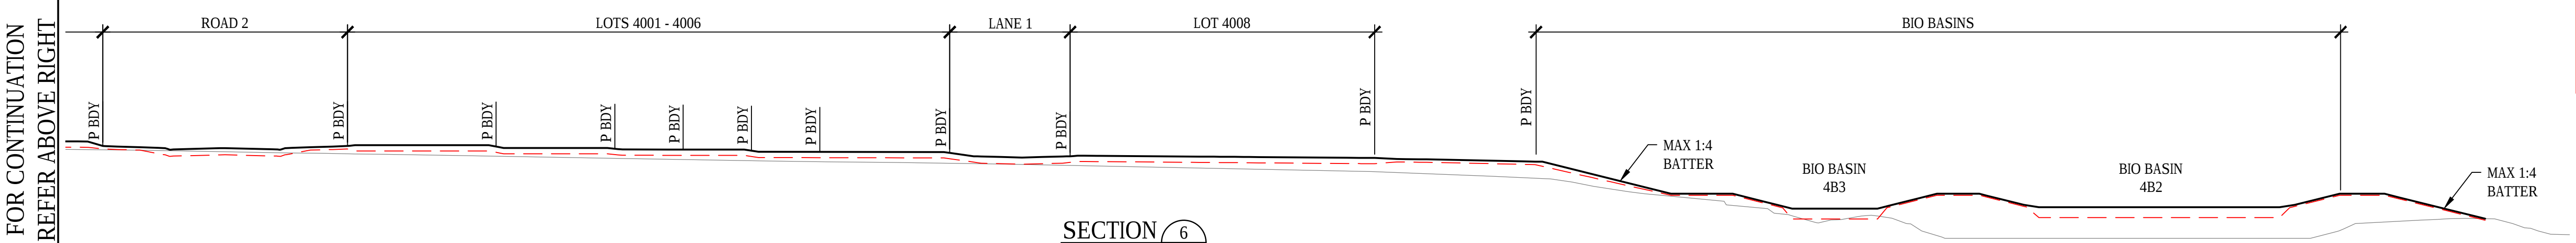

SECTION 6
SCALE 1:250
BE.1.01
BE.1.03
BE.1.05

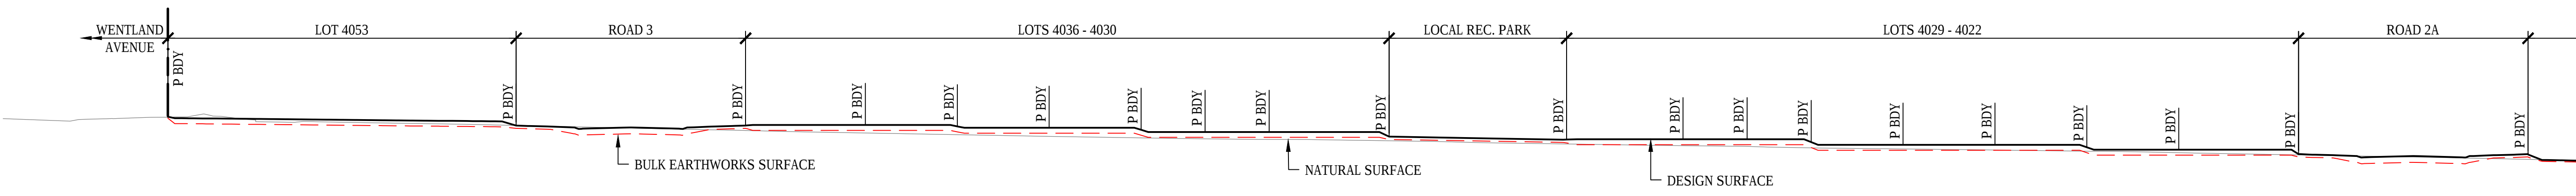


SECTION 7
SCALE 1:250
BE.1.01
BE.1.03
BE.1.05

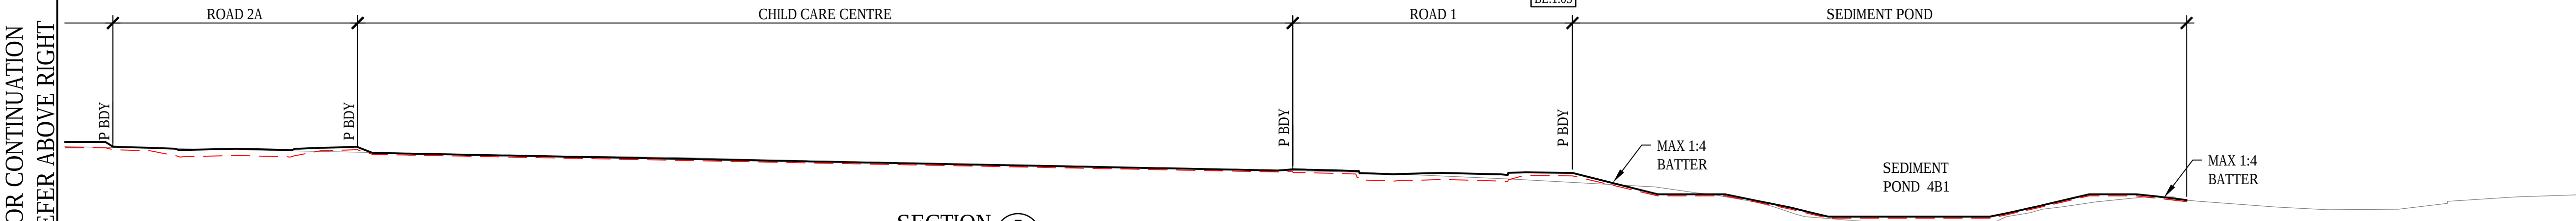

SECTION 7
SCALE 1:250
BE.1.01
BE.1.03
BE.1.05

PLANS AND DOCUMENTS
referred to in the PDA
DEVELOPMENT APPROVAL
Approval no: DEV2025/1667
Date: 23 October 2025

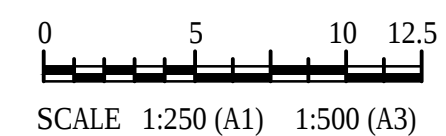

CONSULTANT: MPN CONSULTING PTY LTD
CONTACT:
TELEPHONE: (07) 3335 4555
DATE: -

C	01.09.25	FOR APPROVAL	KC	LS	
B	17.07.25	FOR APPROVAL	KC	LS	
A	11.07.25	PRELIMINARY ISSUE	JB	LS	
ISSUE	DATE	AMENDMENT	BY	APP	

YARRABILBA PRECINT 4H	
YARRABILBA, QLD 4207	
SCALES:	AS SHOWN
DESIGN:	KC
DRAWN:	JB
CHKD:	
APPRD:	
DATE:	

CLIENT: Stockland

**BULK EARTHWORKS
SECTIONS - SHEET 2**

MPN CONSULTING


ABN: 39 062 191 799
P: 61 7 3335 4555
E: solutions@mpnc.au
Level 4, Building 3,
Kings Row Office Park,
42 McDougall Street, Milton, QLD, 4064

COPYRIGHT: THIS DESIGN AND PLANS ARE NOT TO BE USED OR REPRODUCED WHOLLY OR IN PART WITHOUT WRITTEN PERMISSION OF MPN CONSULTING PTY LIMITED 2023 ©

mpn JOB
10479


DRAWING No.
BE.2.02

REV
C

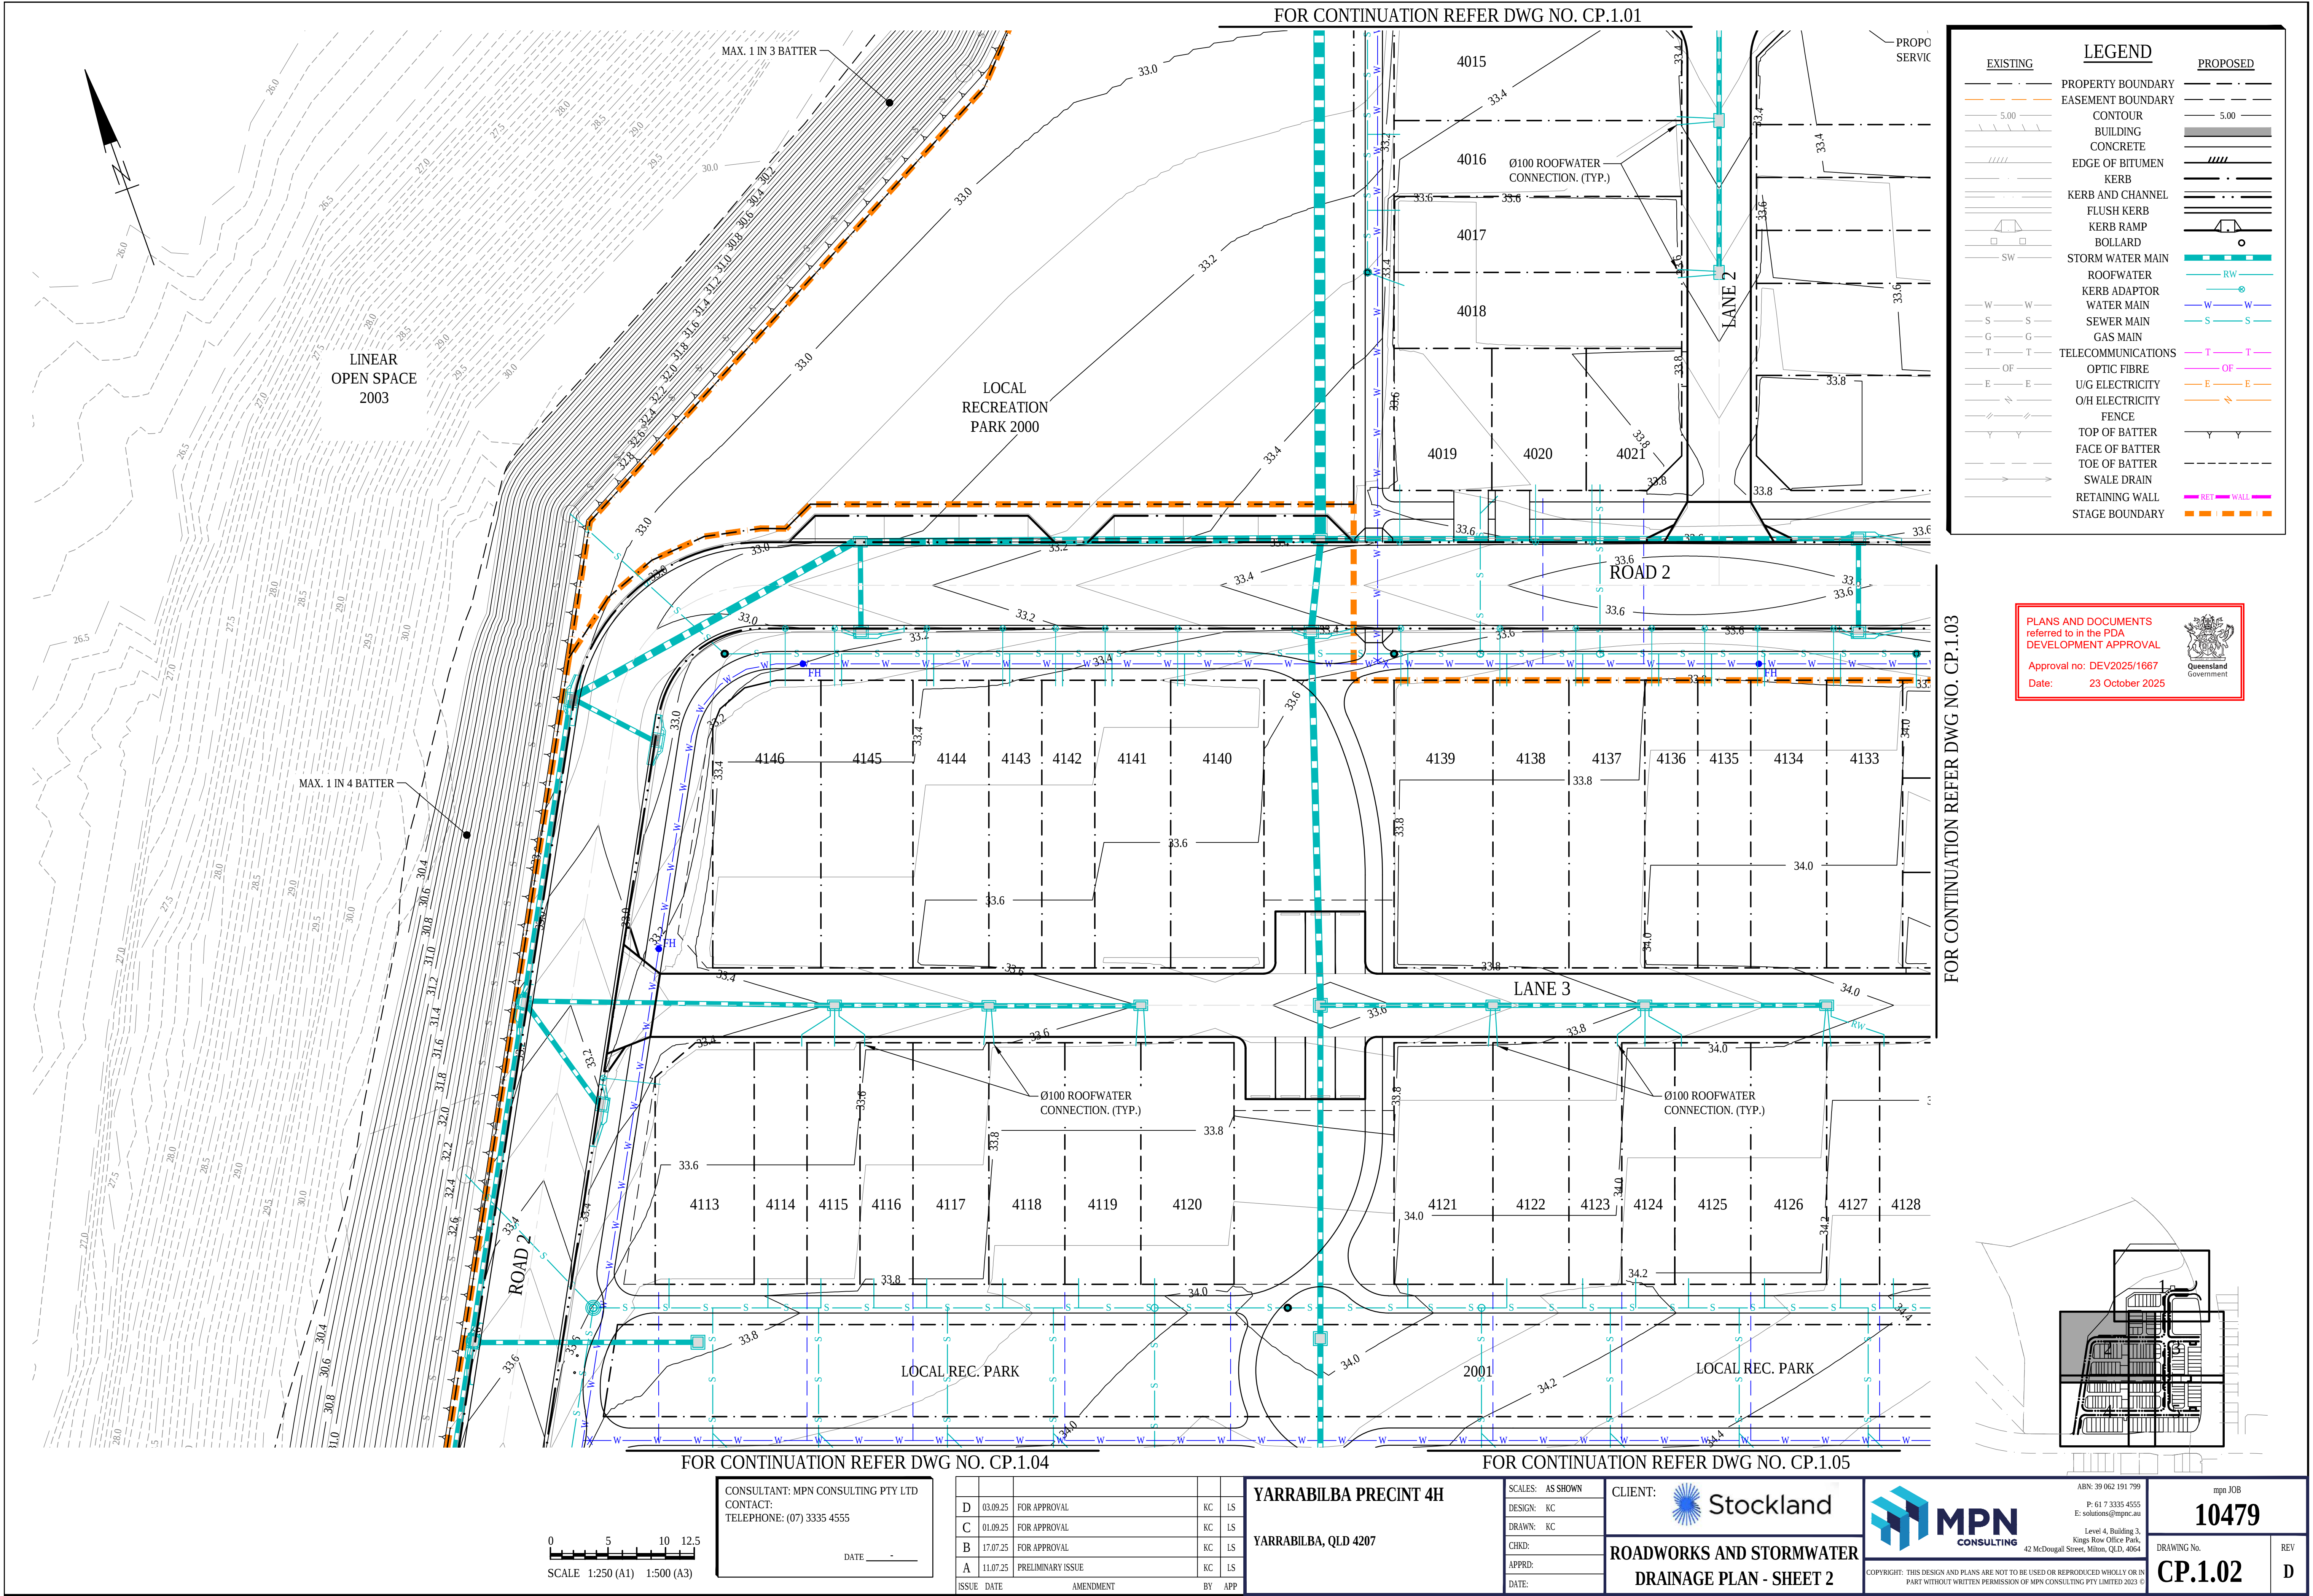

FOR CONTINUATION REFER DWG NO. CP.1.01


FOR CONTINUATION REFER DWG NO. CP.1.02

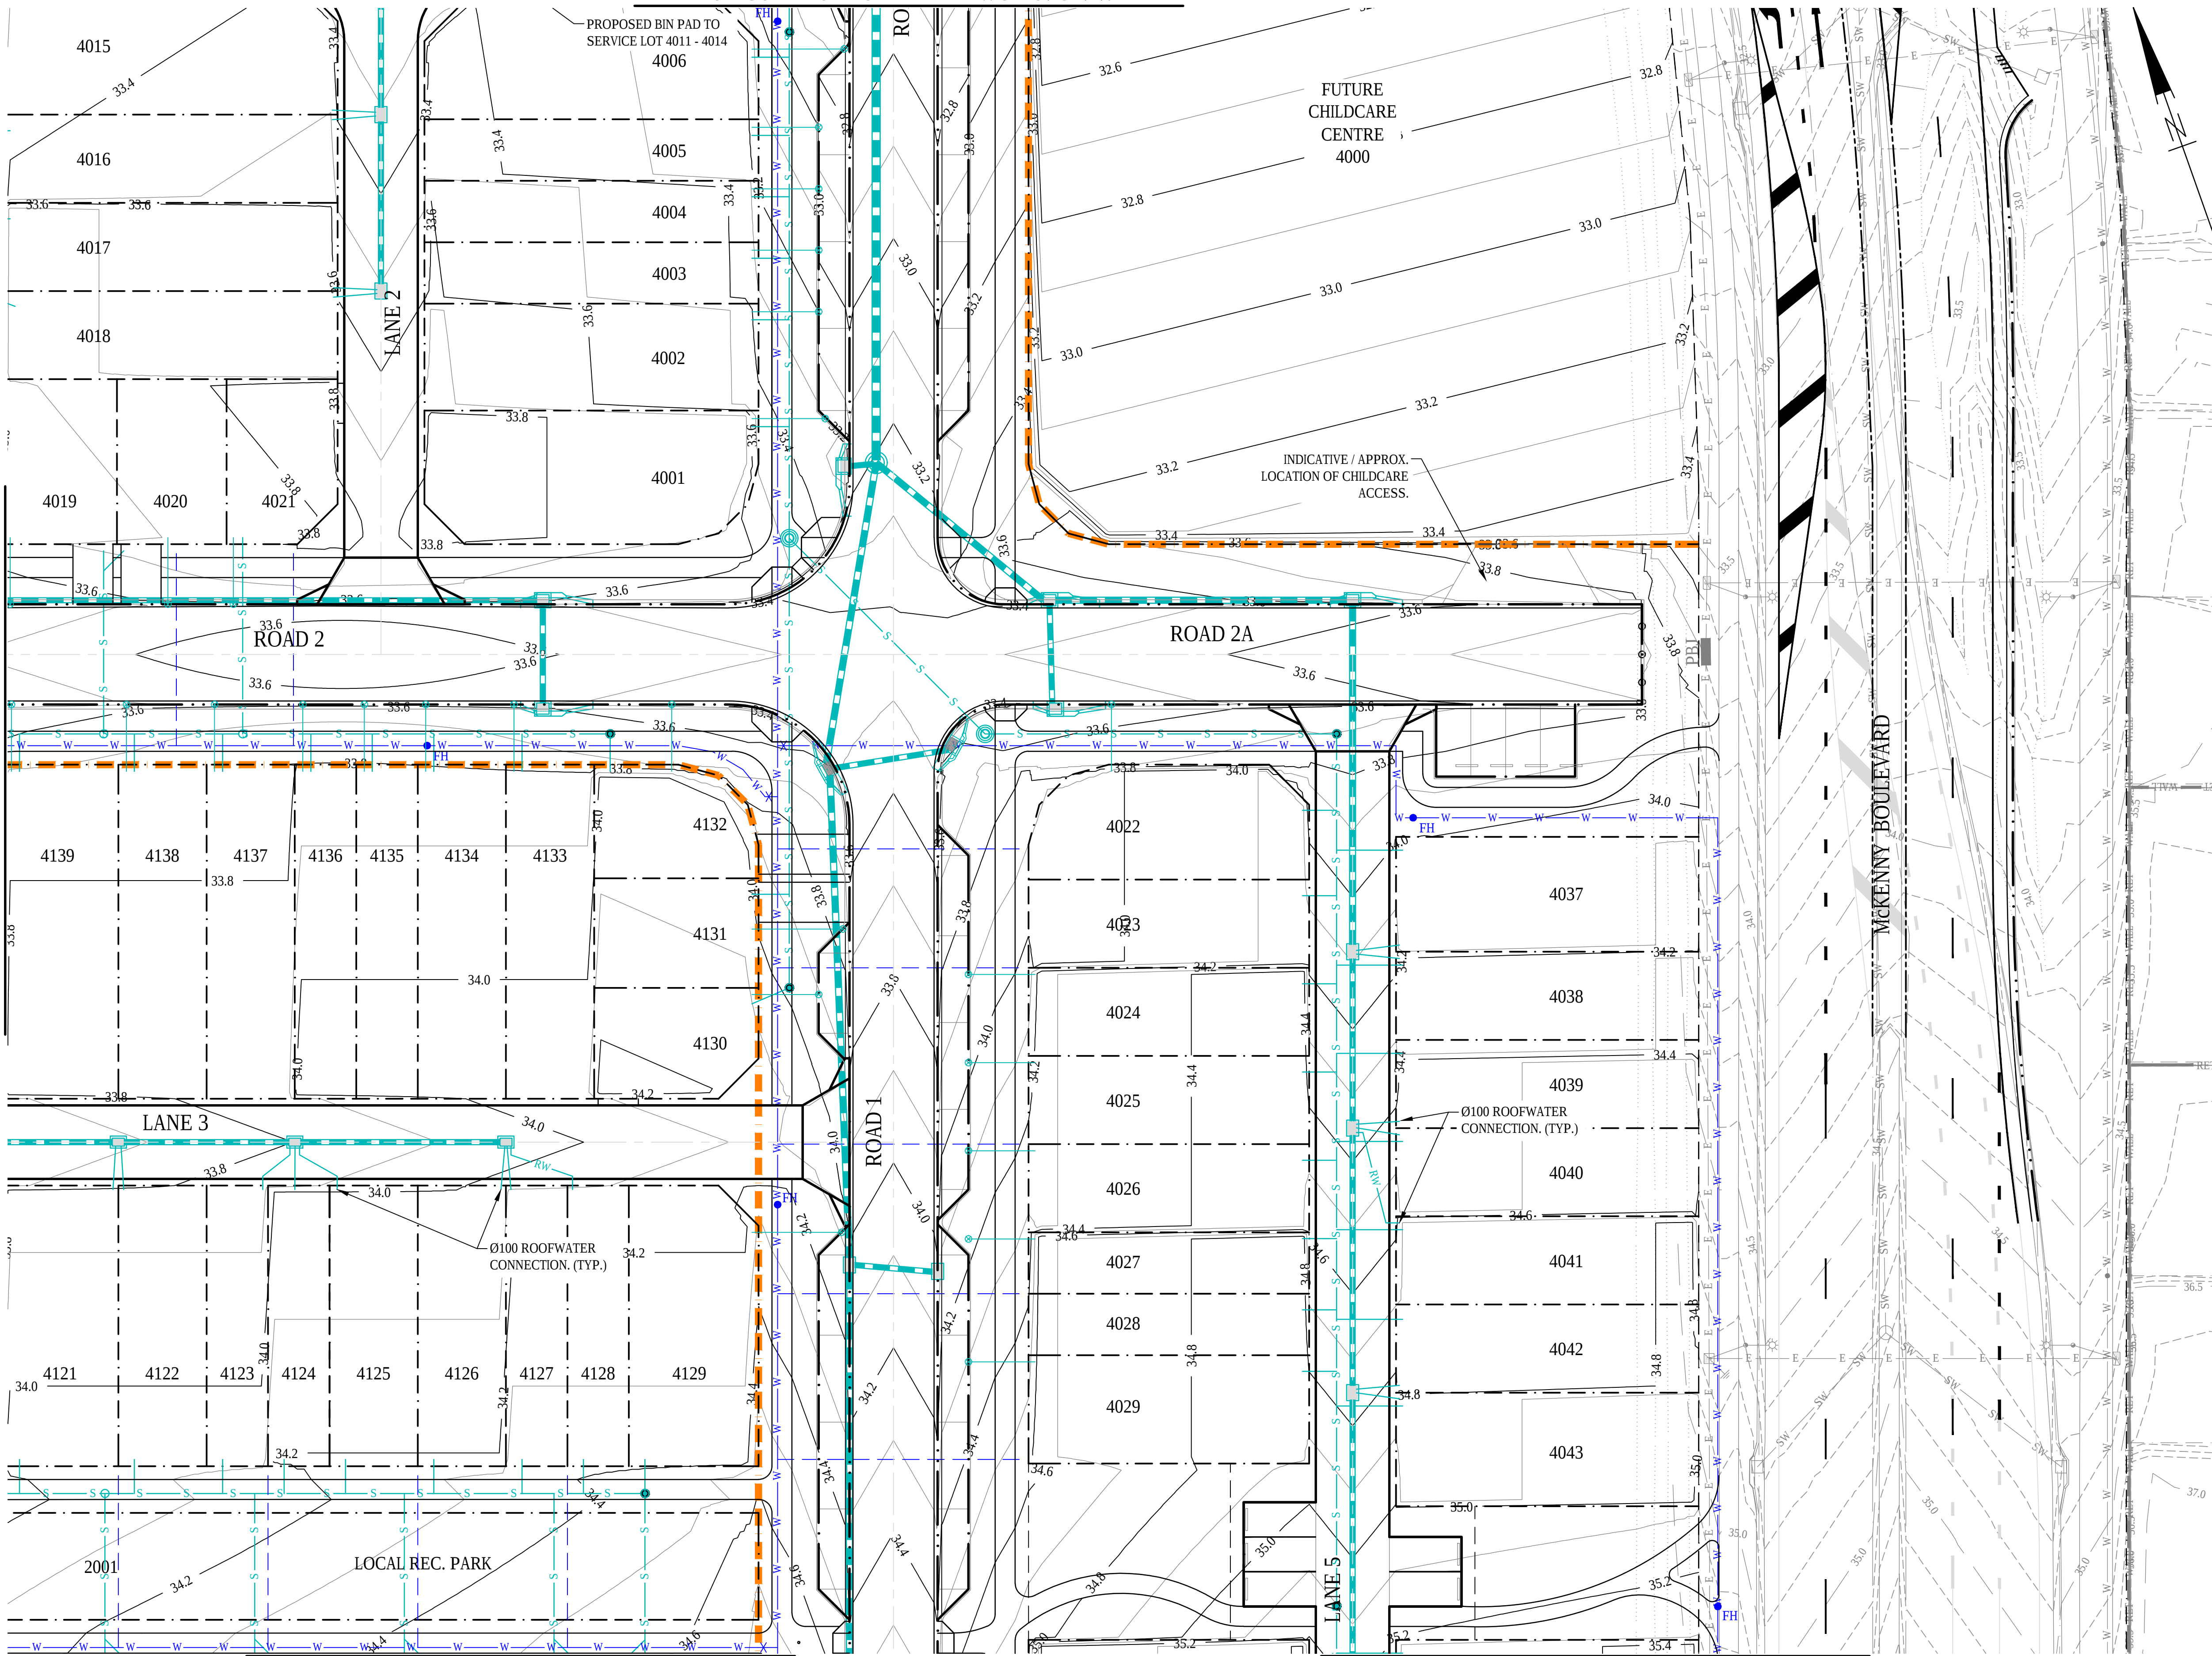

LEGEND


EXISTING		PROPOSED
---	PROPERTY BOUNDARY	---
---	EASEMENT BOUNDARY	---
---	CONTOUR	---
---	BUILDING	---
---	CONCRETE	---
---	EDGE OF BITUMEN	---
---	KERB	---
---	KERB AND CHANNEL	---
---	FLUSH KERB	---
---	KERB RAMP	---
---	BOLLARD	---
---	STORM WATER MAIN	---
---	ROOFWATER	---
---	KERB ADAPTOR	---
---	WATER MAIN	---
---	SEWER MAIN	---
---	GAS MAIN	---
---	TELECOMMUNICATIONS	---
---	OPTIC FIBRE	---
---	U/G ELECTRICITY	---
---	O/H ELECTRICITY	---
---	FENCE	---
---	TOP OF BATTER	---
---	FACE OF BATTER	---
---	TOE OF BATTER	---
---	SWALE DRAIN	---
---	RETAINING WALL	---
---	STAGE BOUNDARY	---

PLANS AND DOCUMENTS referred to in the PDA DEVELOPMENT APPROVAL
Approval no: DEV2025/1667
Date: 23 October 2025

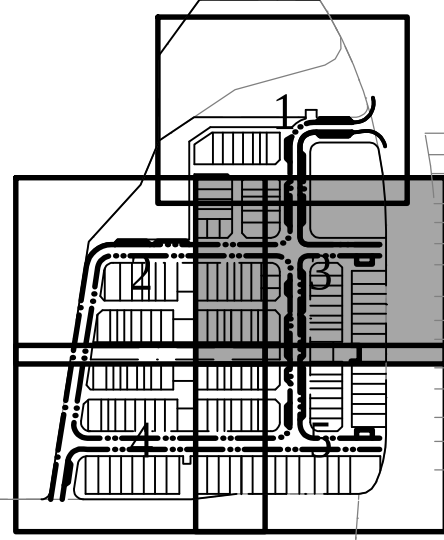

FOR CONTINUATION REFER DWG NO. CP.1.04

FOR CONTINUATION REFER DWG NO. CP.1.05

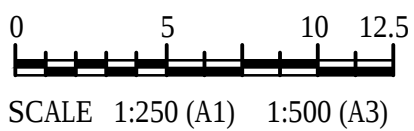

CONSULTANT: MPN CONSULTING PTY LTD
CONTACT:
TELEPHONE: (07) 3335 4555
DATE: -

D	03.09.25	FOR APPROVAL	KC	LS
C	01.09.25	FOR APPROVAL	KC	LS
B	17.07.25	FOR APPROVAL	KC	LS
A	11.07.25	PRELIMINARY ISSUE	KC	LS
ISSUE	DATE	AMENDMENT	BY	APP

YARRABILBA PRECINT 4H

YARRABILBA, QLD 4207

SCALES: AS SHOWN
DESIGN: KC
DRAWN: KC
CHKD:
APPRD:
DATE:

CLIENT: Stockland
ROADWORKS AND STORMWATER
DRAINAGE PLAN - SHEET 3



ABN: 39 062 191 799
P: 61 7 3335 4555
E: solutions@mpnc.au
Level 4, Building 3,
Kings Row Office Park,
42 McDougall Street, Milton, QLD, 4064

mpn JOB

10479


DRAWING No.

CP.1.03

REV

D

COPYRIGHT: THIS DESIGN AND PLANS ARE NOT TO BE USED OR REPRODUCED WHOLLY OR IN PART WITHOUT WRITTEN PERMISSION OF MPN CONSULTING PTY LIMITED 2023 ©

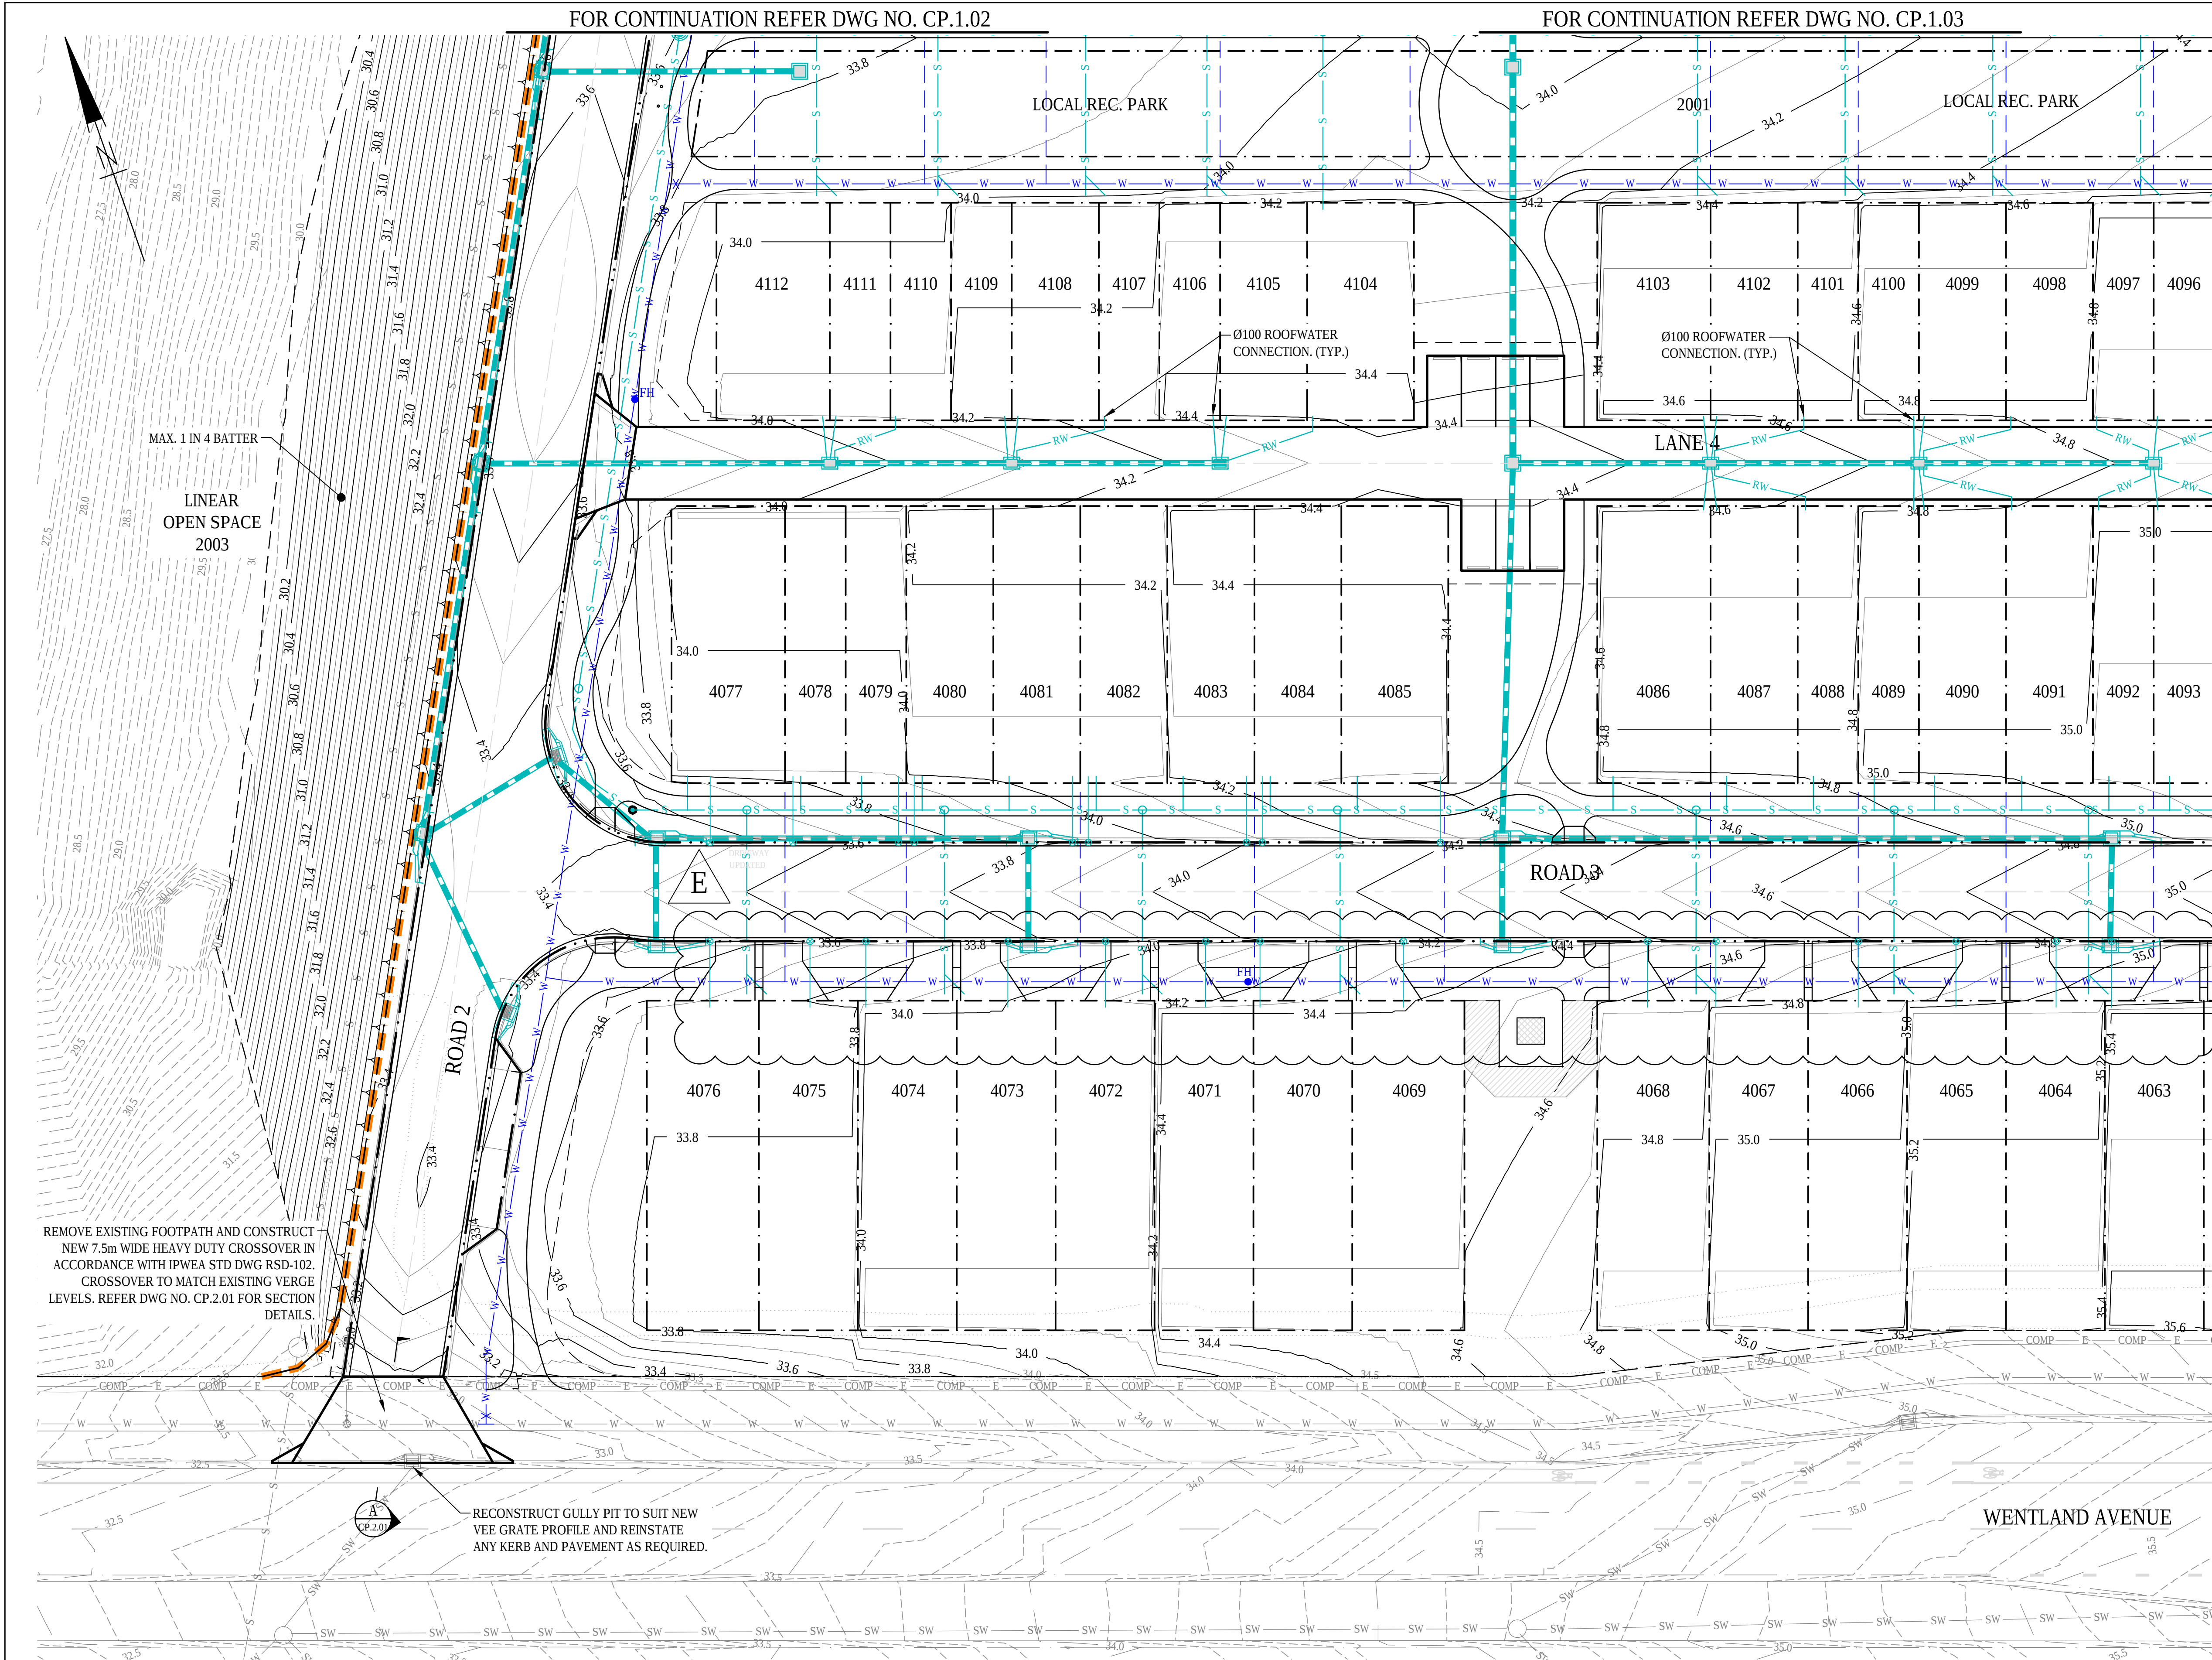



LEGEND

EXISTING	PROPOSED
PROPERTY BOUNDARY	PROPERTY BOUNDARY
EASEMENT BOUNDARY	EASEMENT BOUNDARY
CONTOUR	CONTOUR
BUILDING	BUILDING
CONCRETE	CONCRETE
EDGE OF BITUMEN	EDGE OF BITUMEN
KERB	KERB
KERB AND CHANNEL	KERB AND CHANNEL
FLUSH KERB	FLUSH KERB
KERB RAMP	KERB RAMP
BOLLARD	BOLLARD
STORM WATER MAIN	STORM WATER MAIN
ROOFWATER	ROOFWATER
KERB ADAPTOR	KERB ADAPTOR
WATER MAIN	WATER MAIN
SEWER MAIN	SEWER MAIN
GAS MAIN	GAS MAIN
TELECOMMUNICATIONS	TELECOMMUNICATIONS
OPTIC FIBRE	OPTIC FIBRE
U/G ELECTRICITY	U/G ELECTRICITY
O/H ELECTRICITY	O/H ELECTRICITY
FENCE	FENCE
TOP OF BATTER	TOP OF BATTER
FACE OF BATTER	FACE OF BATTER
TOE OF BATTER	TOE OF BATTER
SWALE DRAIN	SWALE DRAIN
RETAINING WALL	RETAINING WALL
STAGE BOUNDARY	STAGE BOUNDARY

PLANS AND DOCUMENTS referred to in the PDA DEVELOPMENT APPROVAL
Approval no: DEV2025/1667
Date: 23 October 2025



FOR CONTINUATION REFER DWG NO. CP.1.05

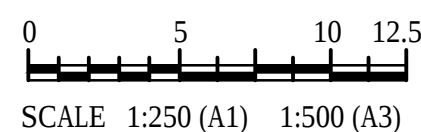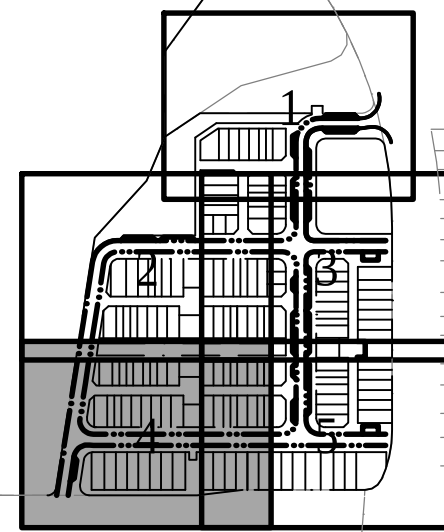

CONSULTANT: MPN CONSULTING PTY LTD
CONTACT:
TELEPHONE: (07) 3335 4555
DATE: -

E	14.10.25	FOR APPROVAL	KC	LS
D	03.09.25	FOR APPROVAL	KC	LS
C	01.09.25	FOR APPROVAL	KC	LS
B	17.07.25	FOR APPROVAL	KC	LS
A	11.07.25	PRELIMINARY ISSUE	KC	LS
ISSUE DATE		AMENDMENT	BY	APP

YARRABILBA PRECINT 4H
YARRABILBA, QLD 4207


SCALES: AS SHOWN
DESIGN: KC
DRAWN: KC
CHKD:
APPRD:
DATE:

CLIENT: **Stockland**
ROADWORKS AND STORMWATER
DRAINAGE PLAN - SHEET 4


MPN CONSULTING
ABN: 39 062 191 799
P: 61 7 3335 4555
E: solutions@mpnqc.au
Level 4, Building 3,
Kings Row Office Park,
42 McDougall Street, Milton, QLD, 4064

mpn JOB
10479
DRAWING No.
CP.1.04
REV
E

FOR CONTINUATION REFER DWG NO. CP.1.03

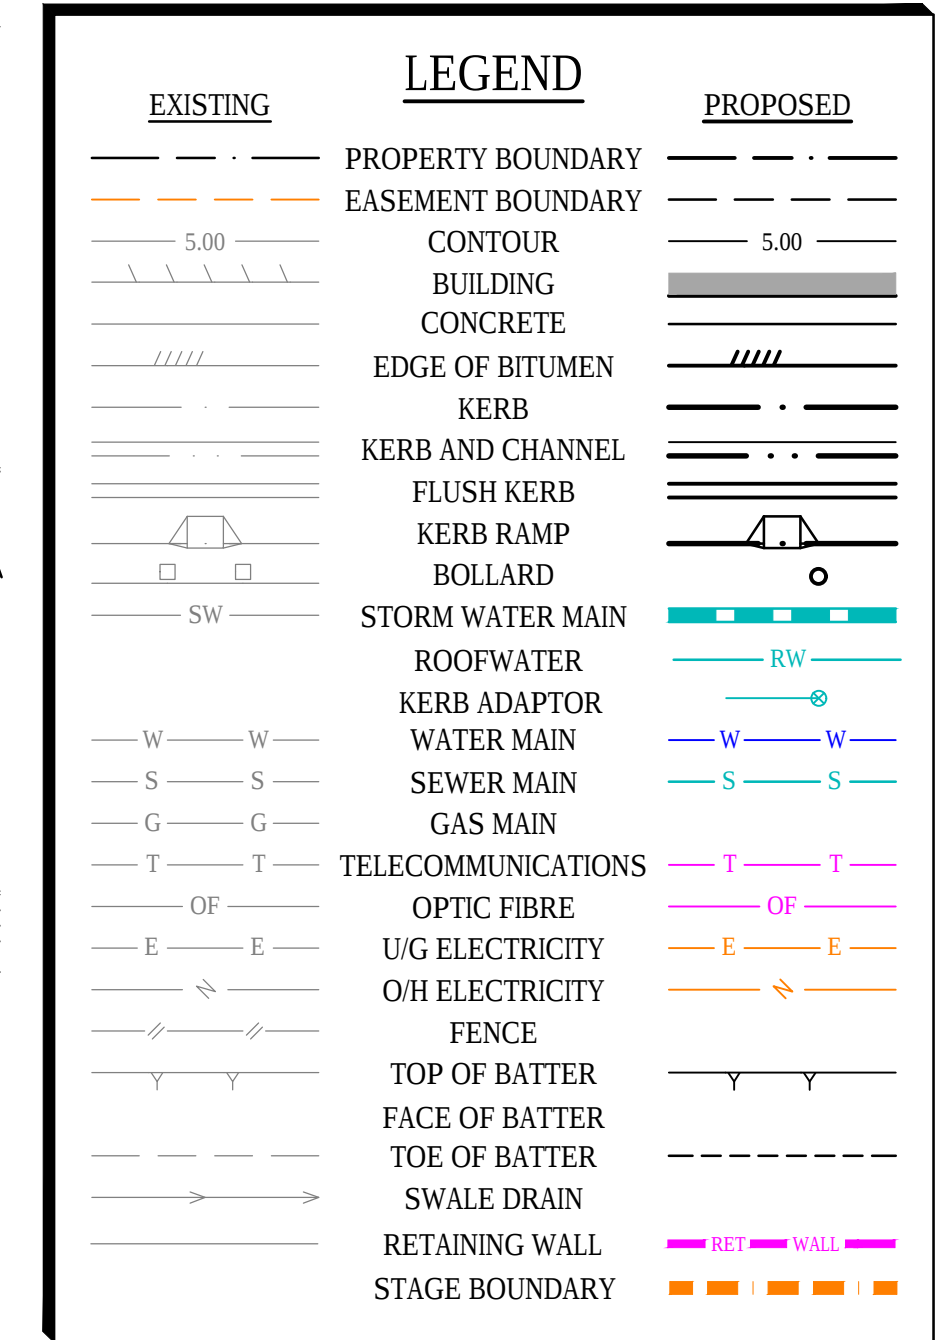

Queensland
Government

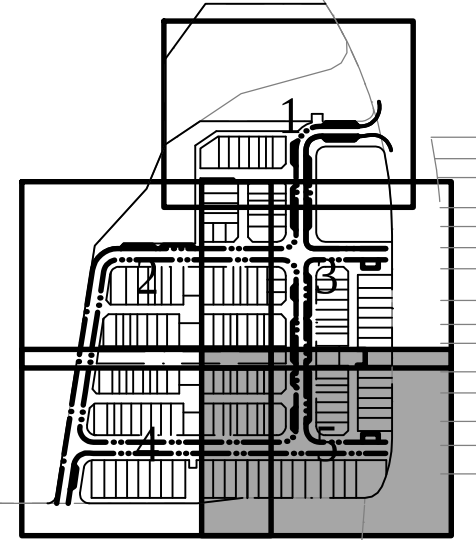

CONSULTANT: MPN CONSULTING PTY LTD
CONTACT:
TELEPHONE: (07) 3335 4555

DATE _____

YARRABILBA PRECINT 4H


YARRABILBA, QLD 4207

CLIENT:  **Stockland**


**ROADWORKS AND STORMWATER
DRAINAGE PLAN - SHEET 5**

ABN: 39 062 191 799
P: 61 7 3335 4555
E: solutions@mpnc.au
Level 4, Building 3,
Kings Row Office Park,
Street, Milton, QLD, 4064


mpn JOB
10479
 DRAWING No.
CP.1.05

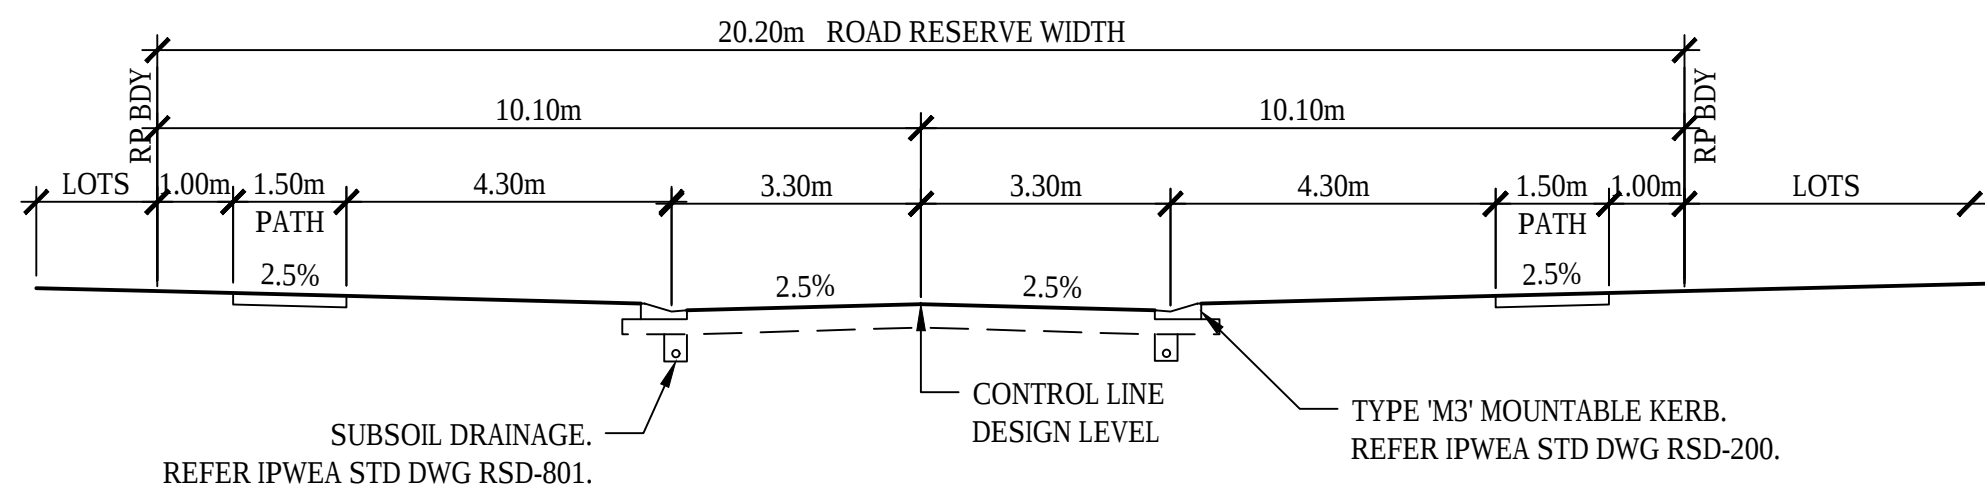


TYPICAL ROAD CROSS SECTION - ROAD 1 (EXCLUDING PARKING)
SCALE 1:100

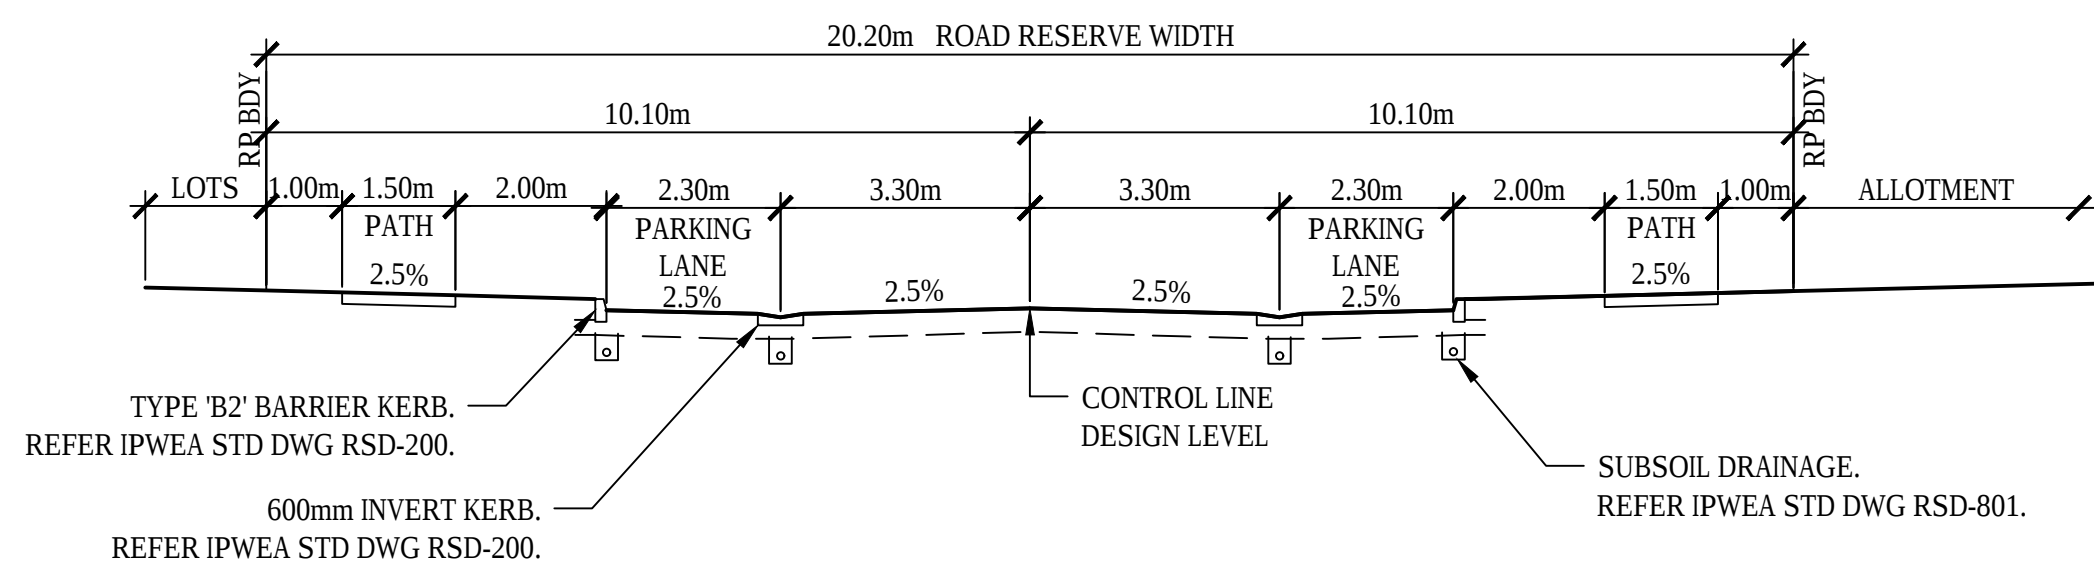


TYPICAL ROAD CROSS SECTION - ROAD 1 (INCLUDING PARKING)
SCALE 1:100

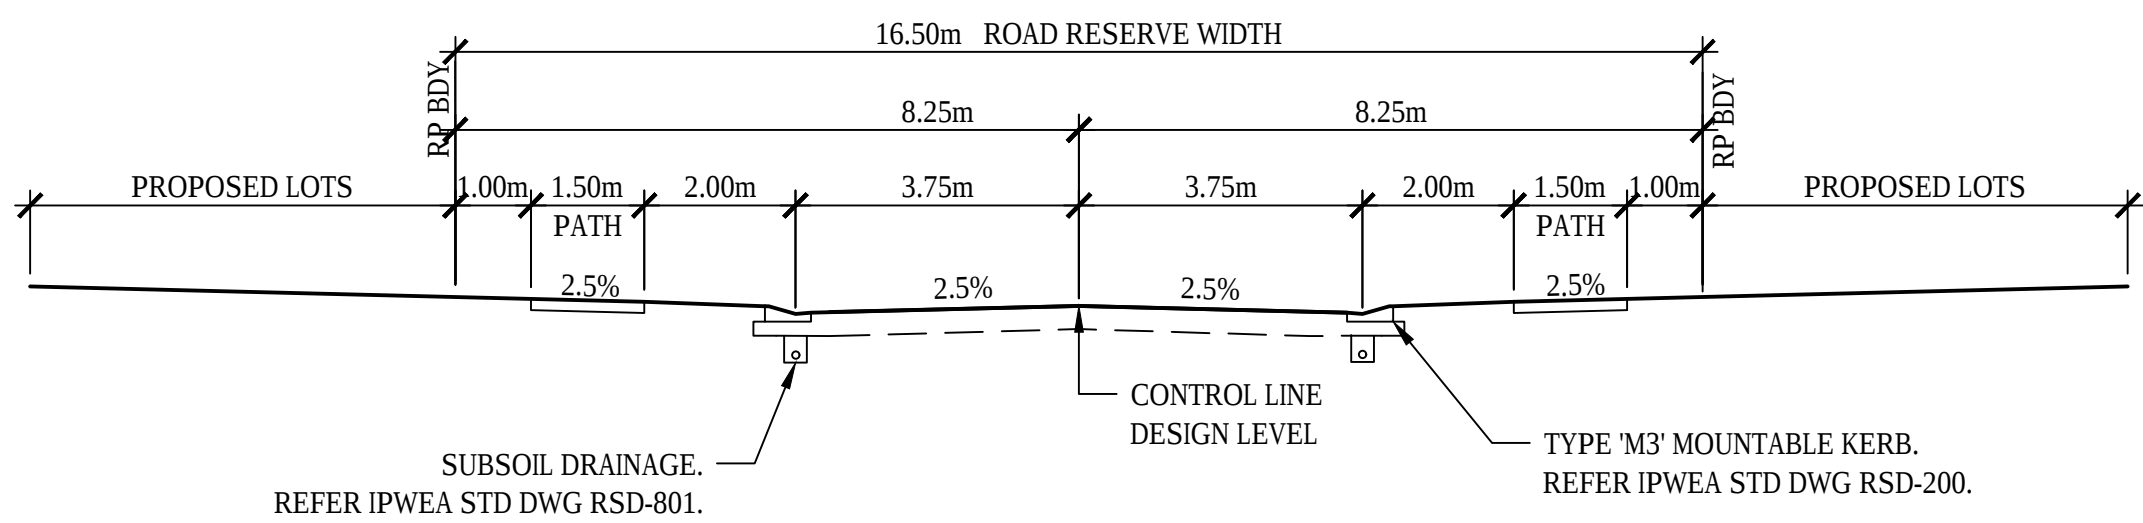


TYPICAL ROAD CROSS SECTION - ROAD 2 (ROAD 3 SIMILAR)
SCALE 1:100

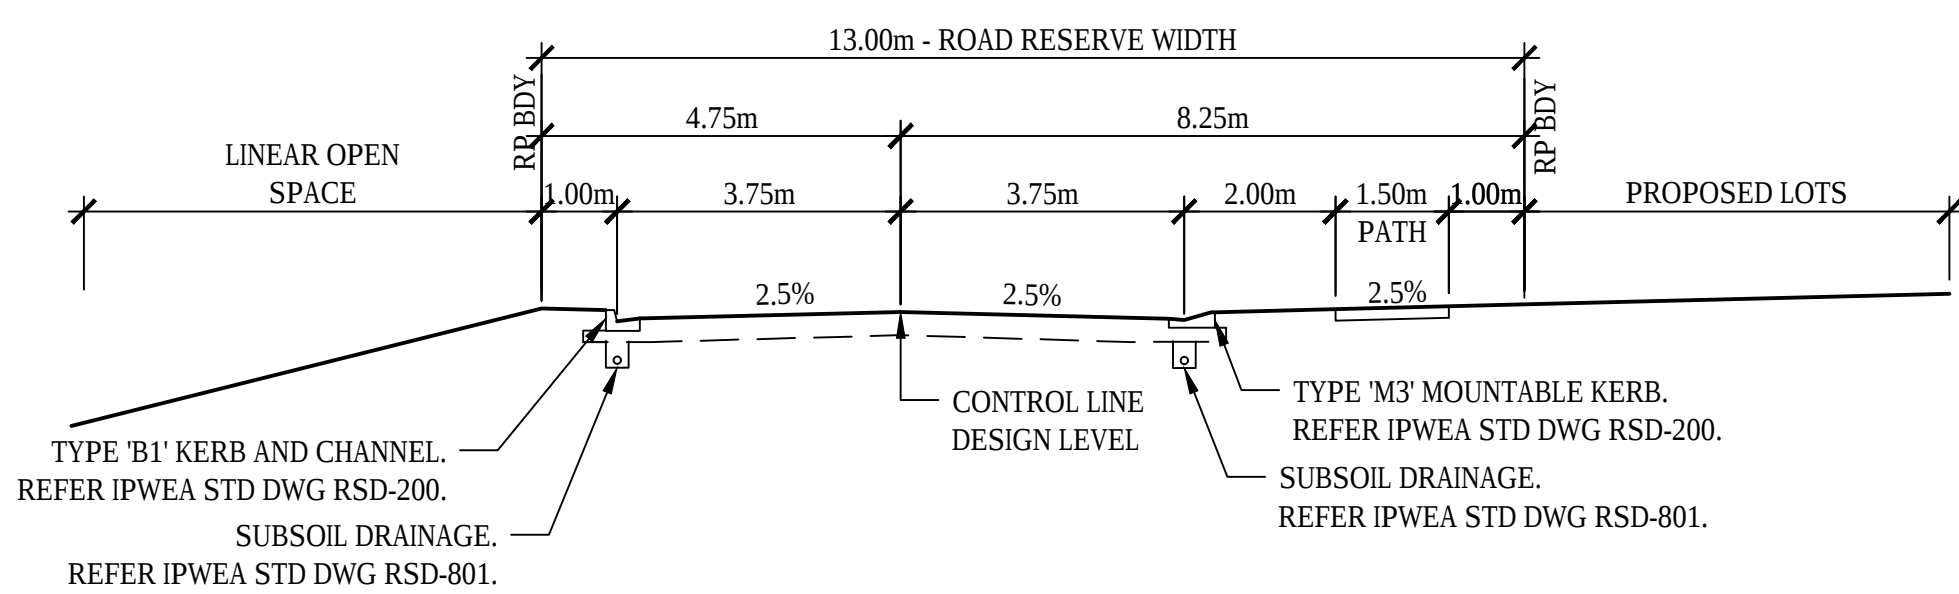


TYPICAL ROAD CROSS SECTION - ROAD 2 (ADJACENT LINEAR OPEN SPACE)
SCALE 1:100

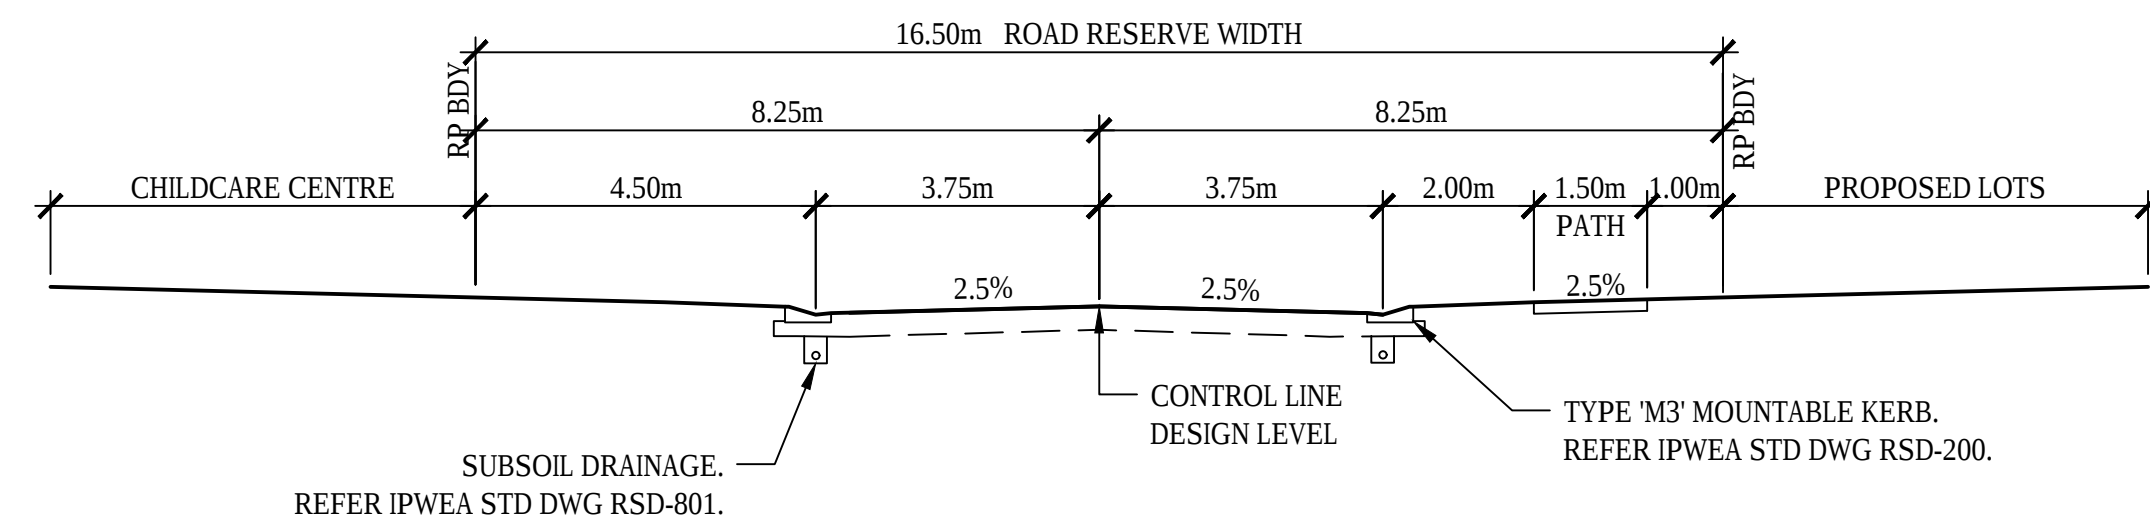


TYPICAL ROAD CROSS SECTION - ROAD 2A
SCALE 1:100

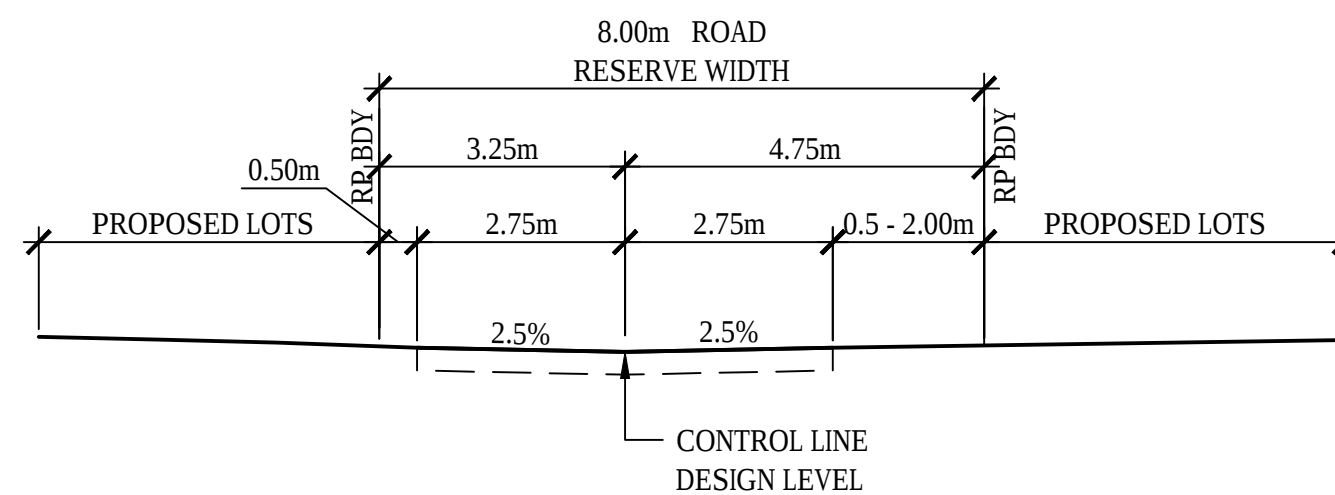

TYPICAL LANEWAY CROSS SECTION - LANE 1
SCALE 1:100

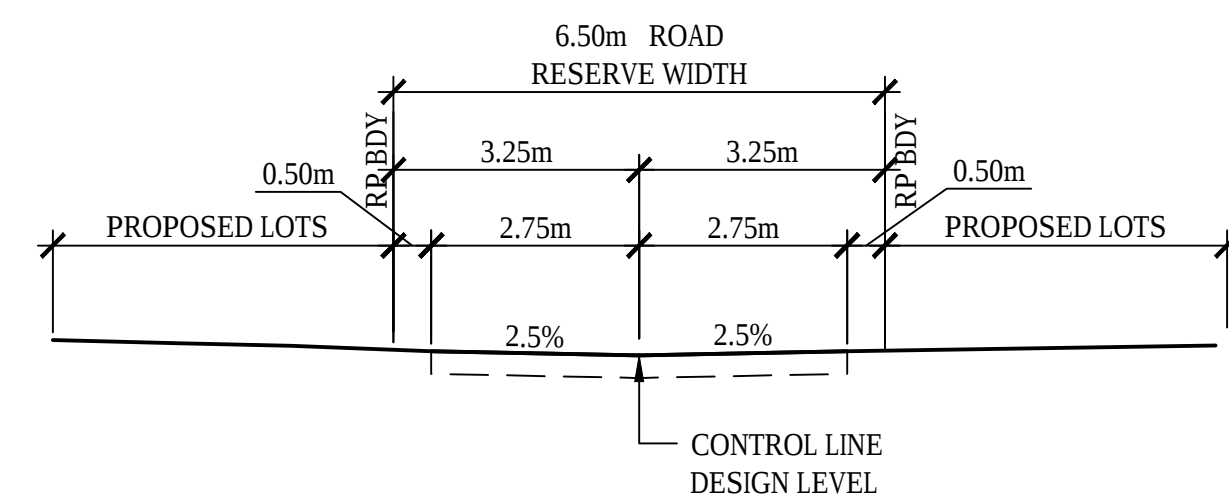


TYPICAL LANEWAY CROSS SECTION - LANE 2, 3, 4 AND 5
SCALE 1:100

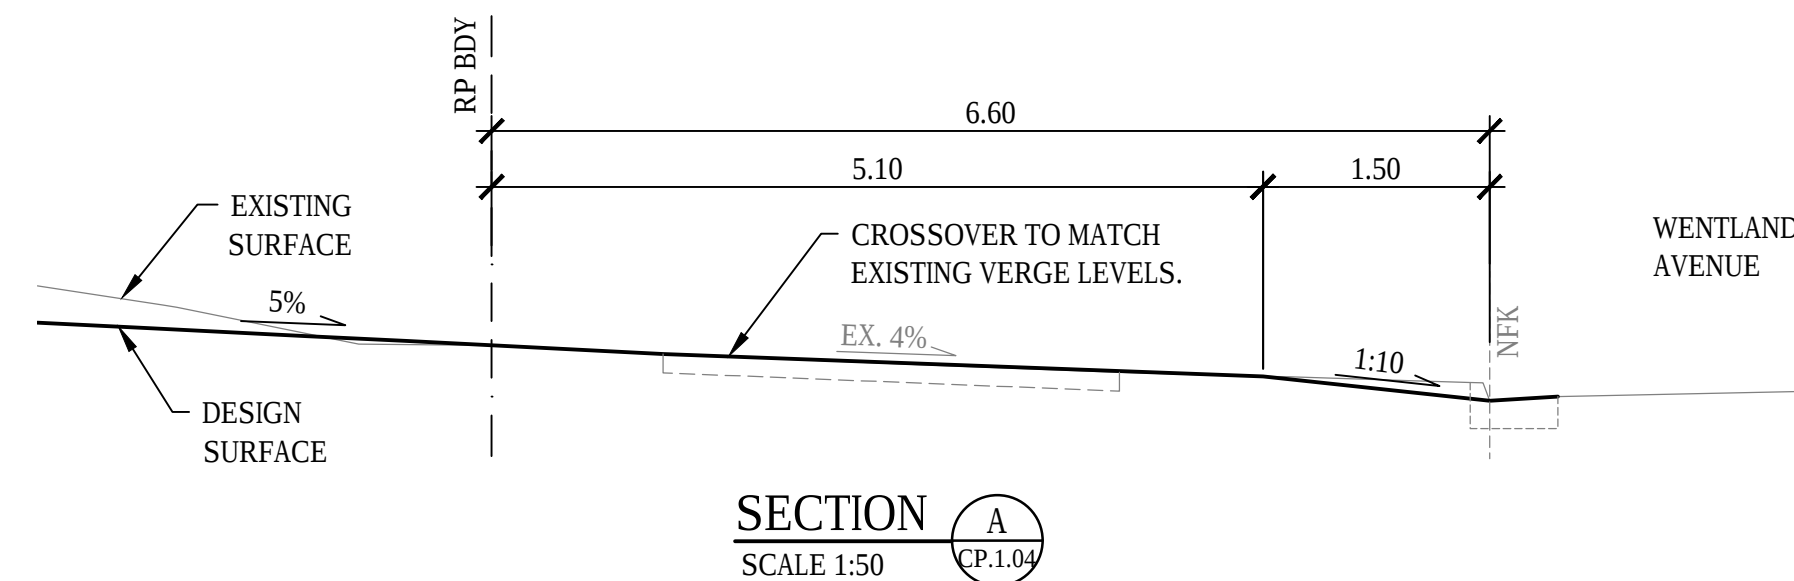


SECTION A
SCALE 1:50
CP.1.04

PLANS AND DOCUMENTS
referred to in the PDA
DEVELOPMENT APPROVAL
Approval no: DEV2025/1667
Date: 23 October 2025

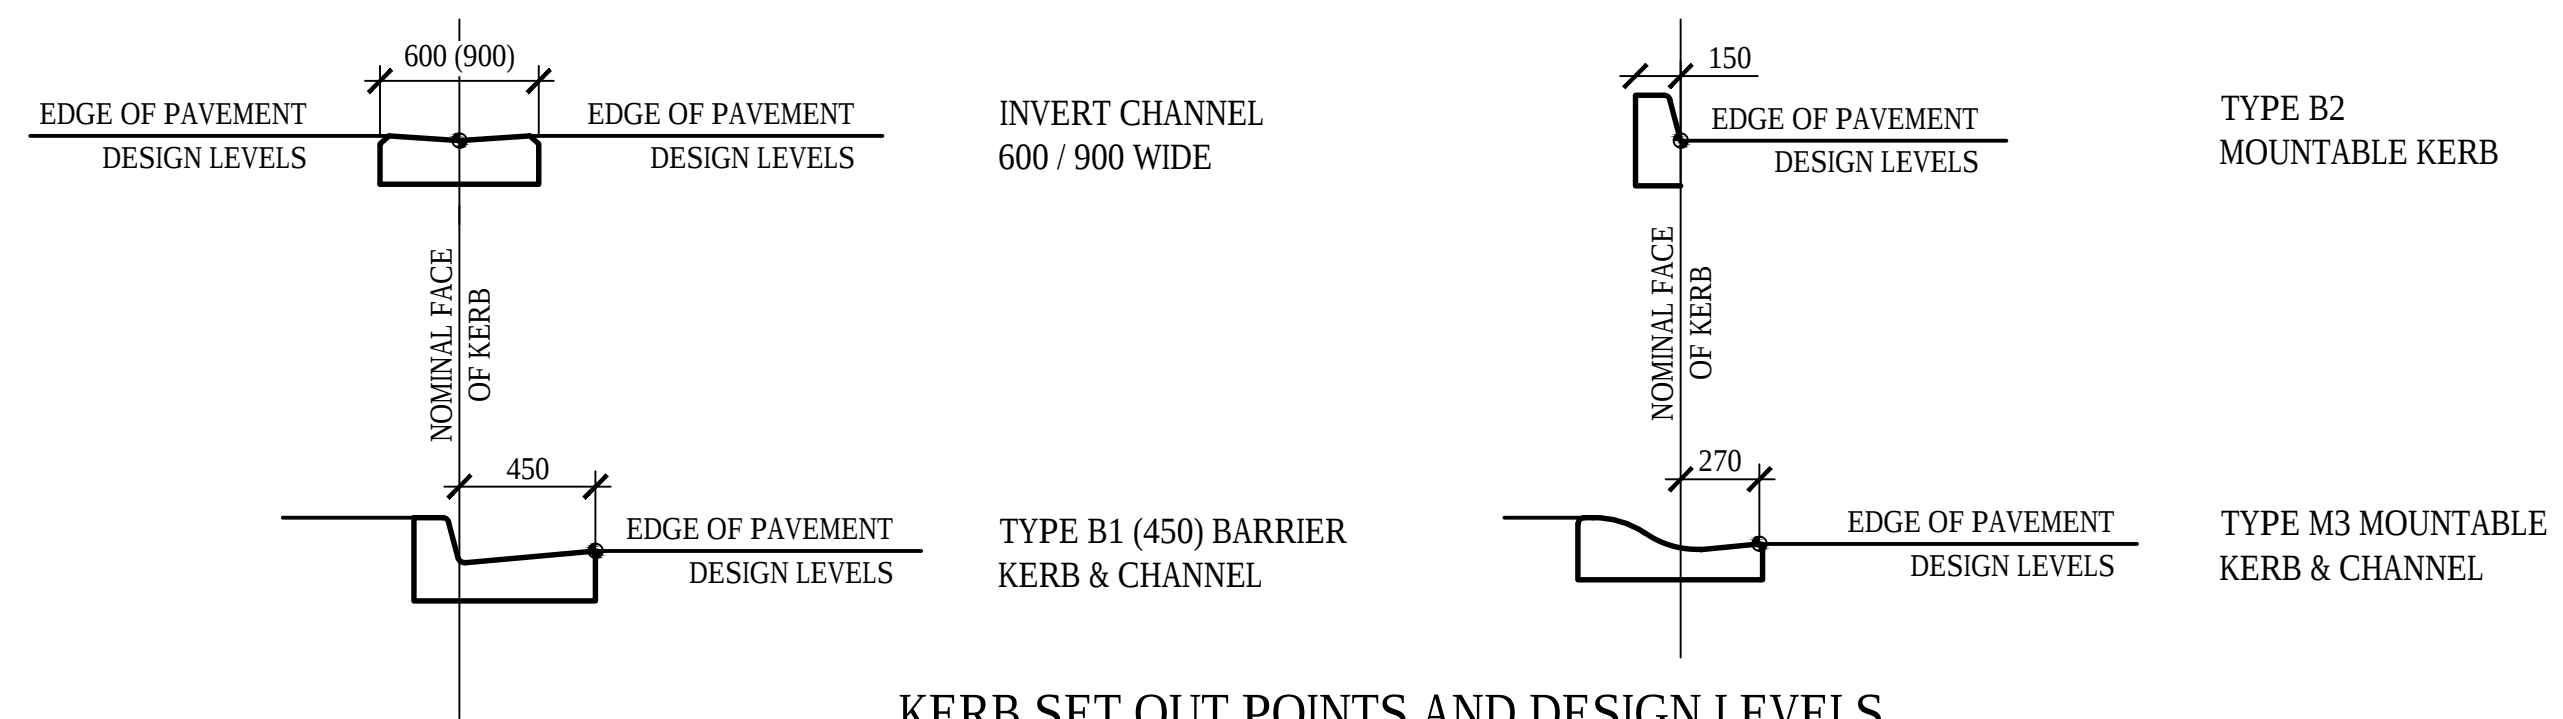

KERB SET OUT POINTS AND DESIGN LEVELS
REFER IPWEAQ STD DWG NO. RSD-200
SCALE 1:25
● DENOTES SETOUT POINT

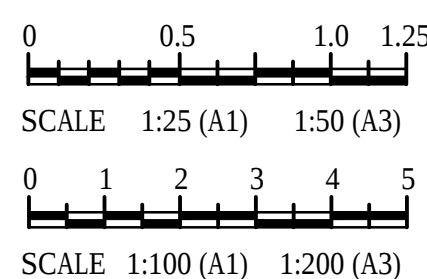

CONSULTANT: MPN CONSULTING PTY LTD
CONTACT:
TELEPHONE: (07) 3335 4555
DATE: -

C	01.09.25	FOR APPROVAL	KC	LS	
B	17.07.25	FOR APPROVAL	KC	LS	
A	11.07.25	PRELIMINARY ISSUE	JB	LS	
ISSUE	DATE	AMENDMENT	BY	APP	


YARRABILBA PRECINT 4H
YARRABILBA, QLD 4207

SCALES: AS SHOWN
DESIGN: KC
DRAWN: MA
CHKD:
APPRD:
DATE:


CLIENT: Stockland
ROADWORKS AND STORMWATER
DRAINAGE DETAILS

MPN CONSULTING
ABN: 39 062 191 799
P: 61 7 3335 4555
E: solutions@mpnc.au
Level 4, Building 3,
Kings Row Office Park,
42 McDougall Street, Milton, QLD, 4064
COPYRIGHT: THIS DESIGN AND PLANS ARE NOT TO BE USED OR REPRODUCED WHOLLY OR IN PART WITHOUT WRITTEN PERMISSION OF MPN CONSULTING PTY LIMITED 2023 ©


mpn JOB
10479
DRAWING No.
CP.2.01
REV
C

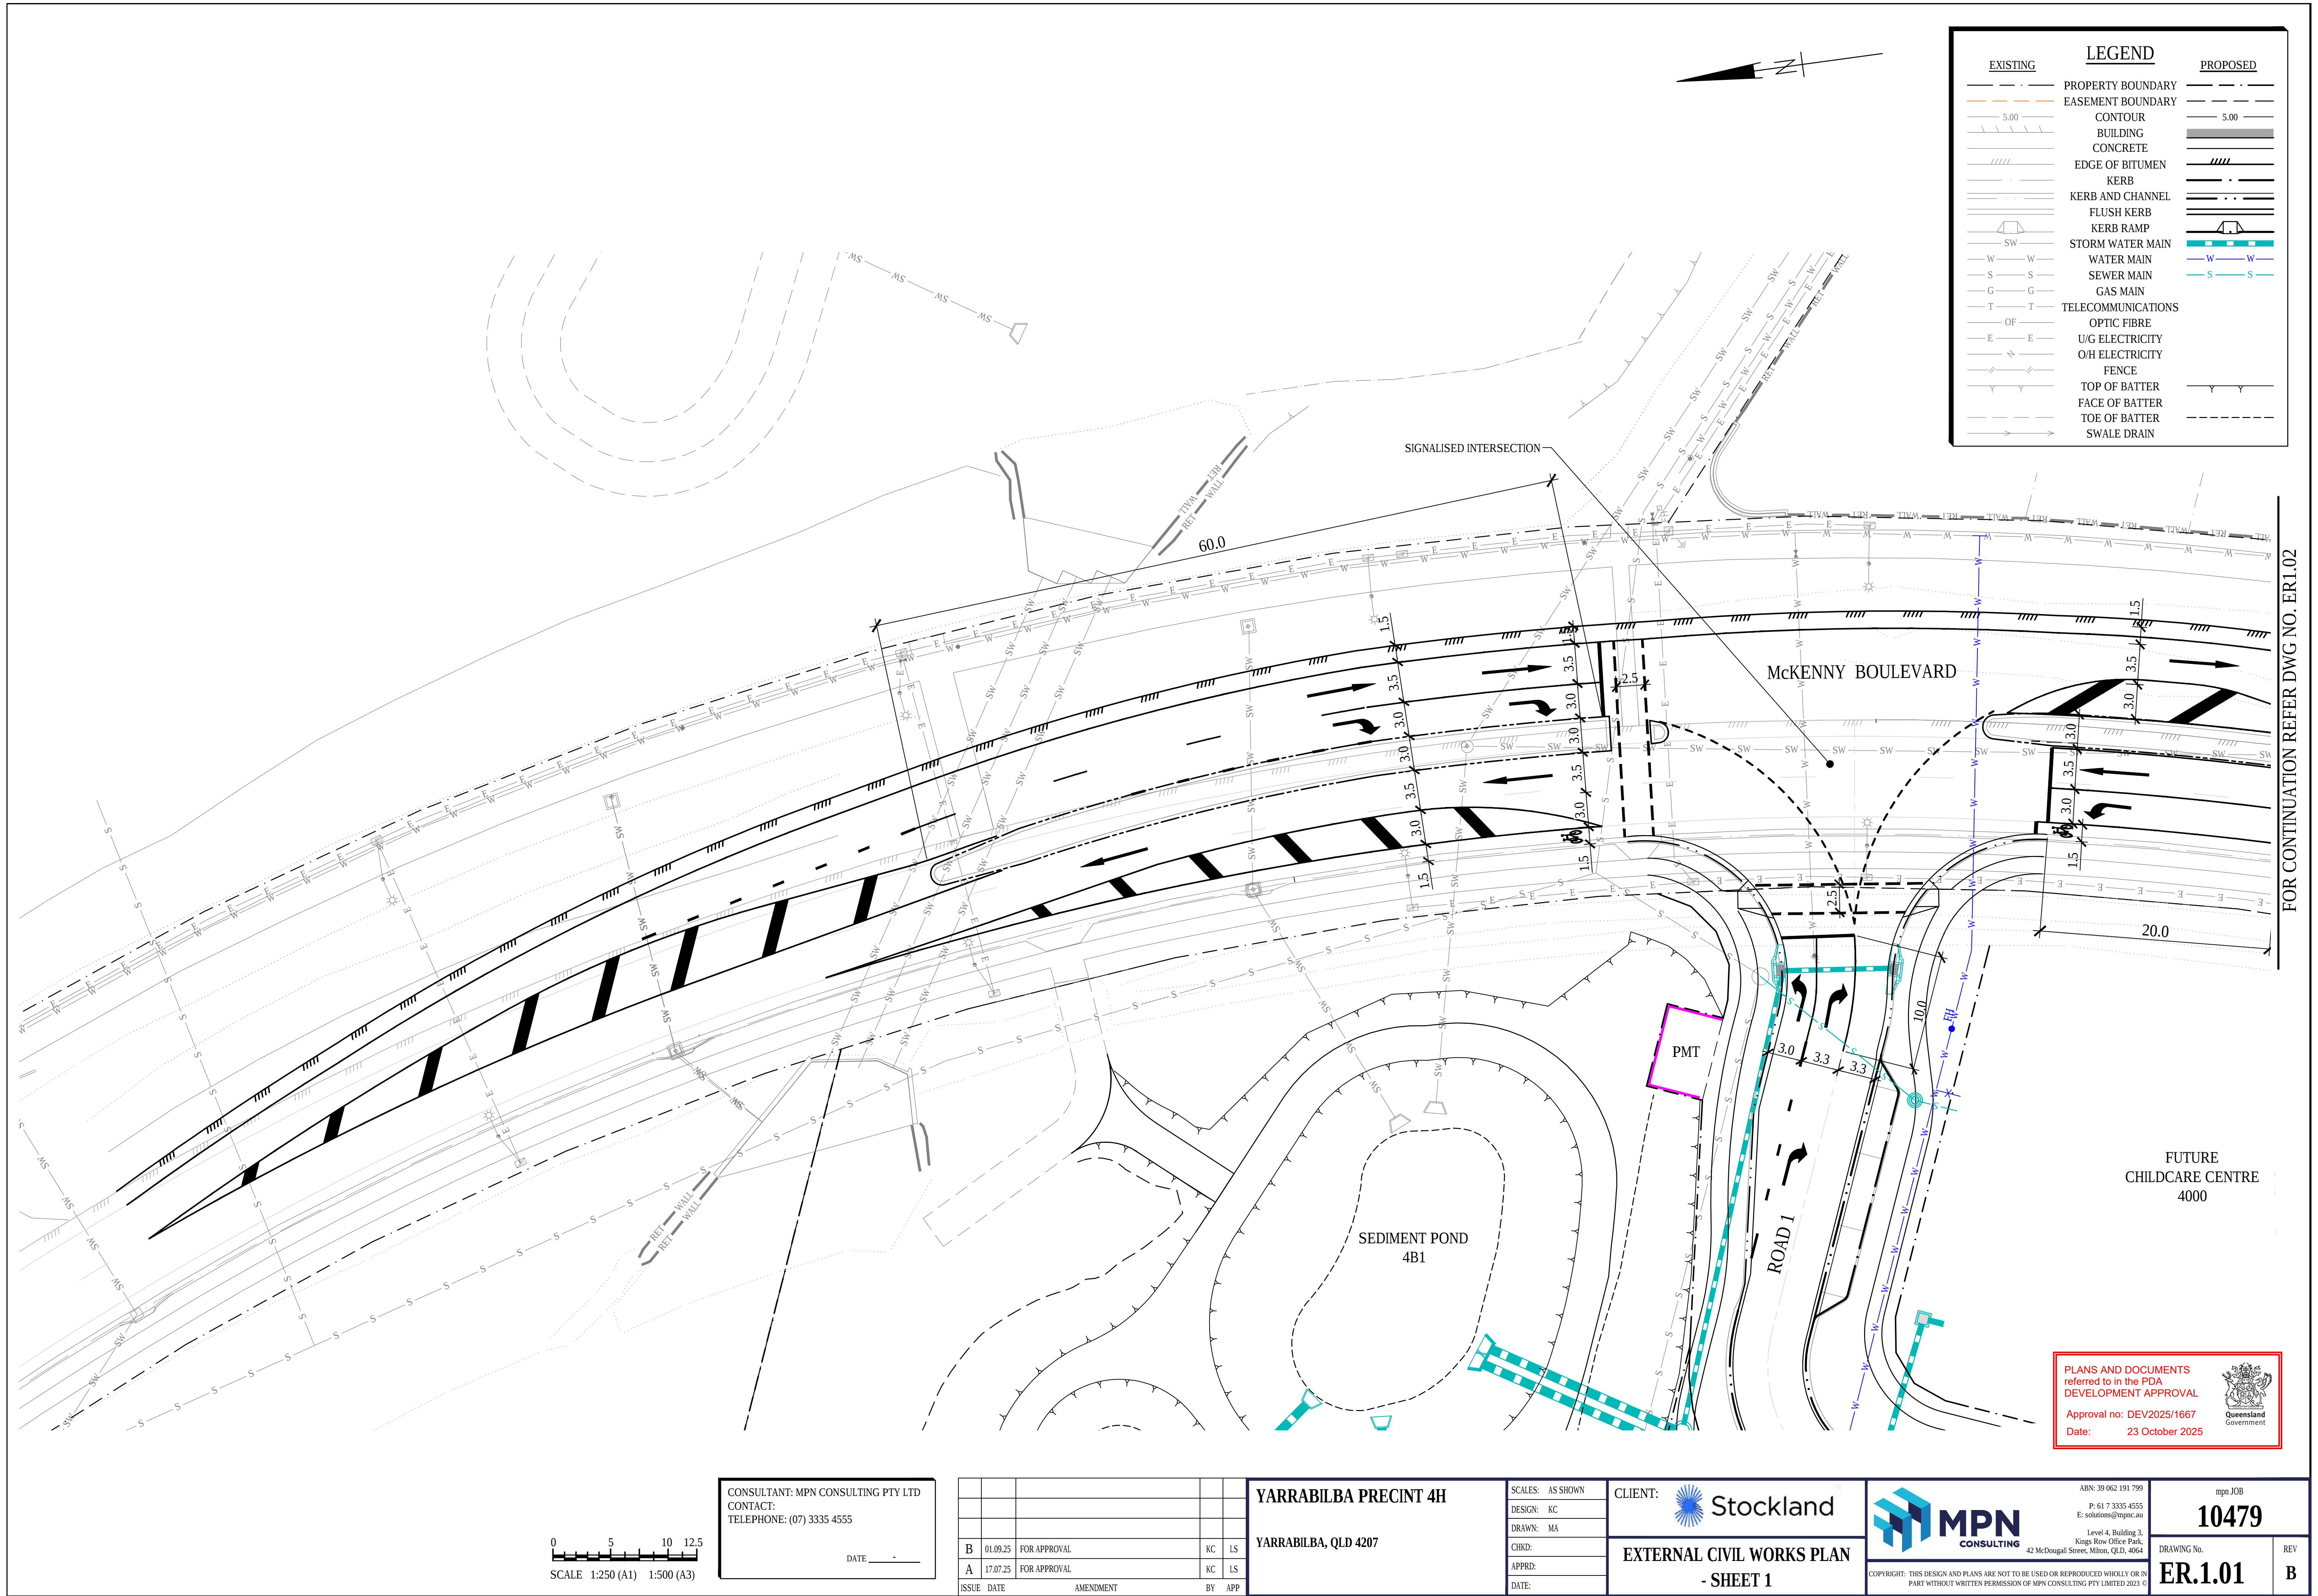

FOR CONTINUATION REFER DWG NO. ERI.01

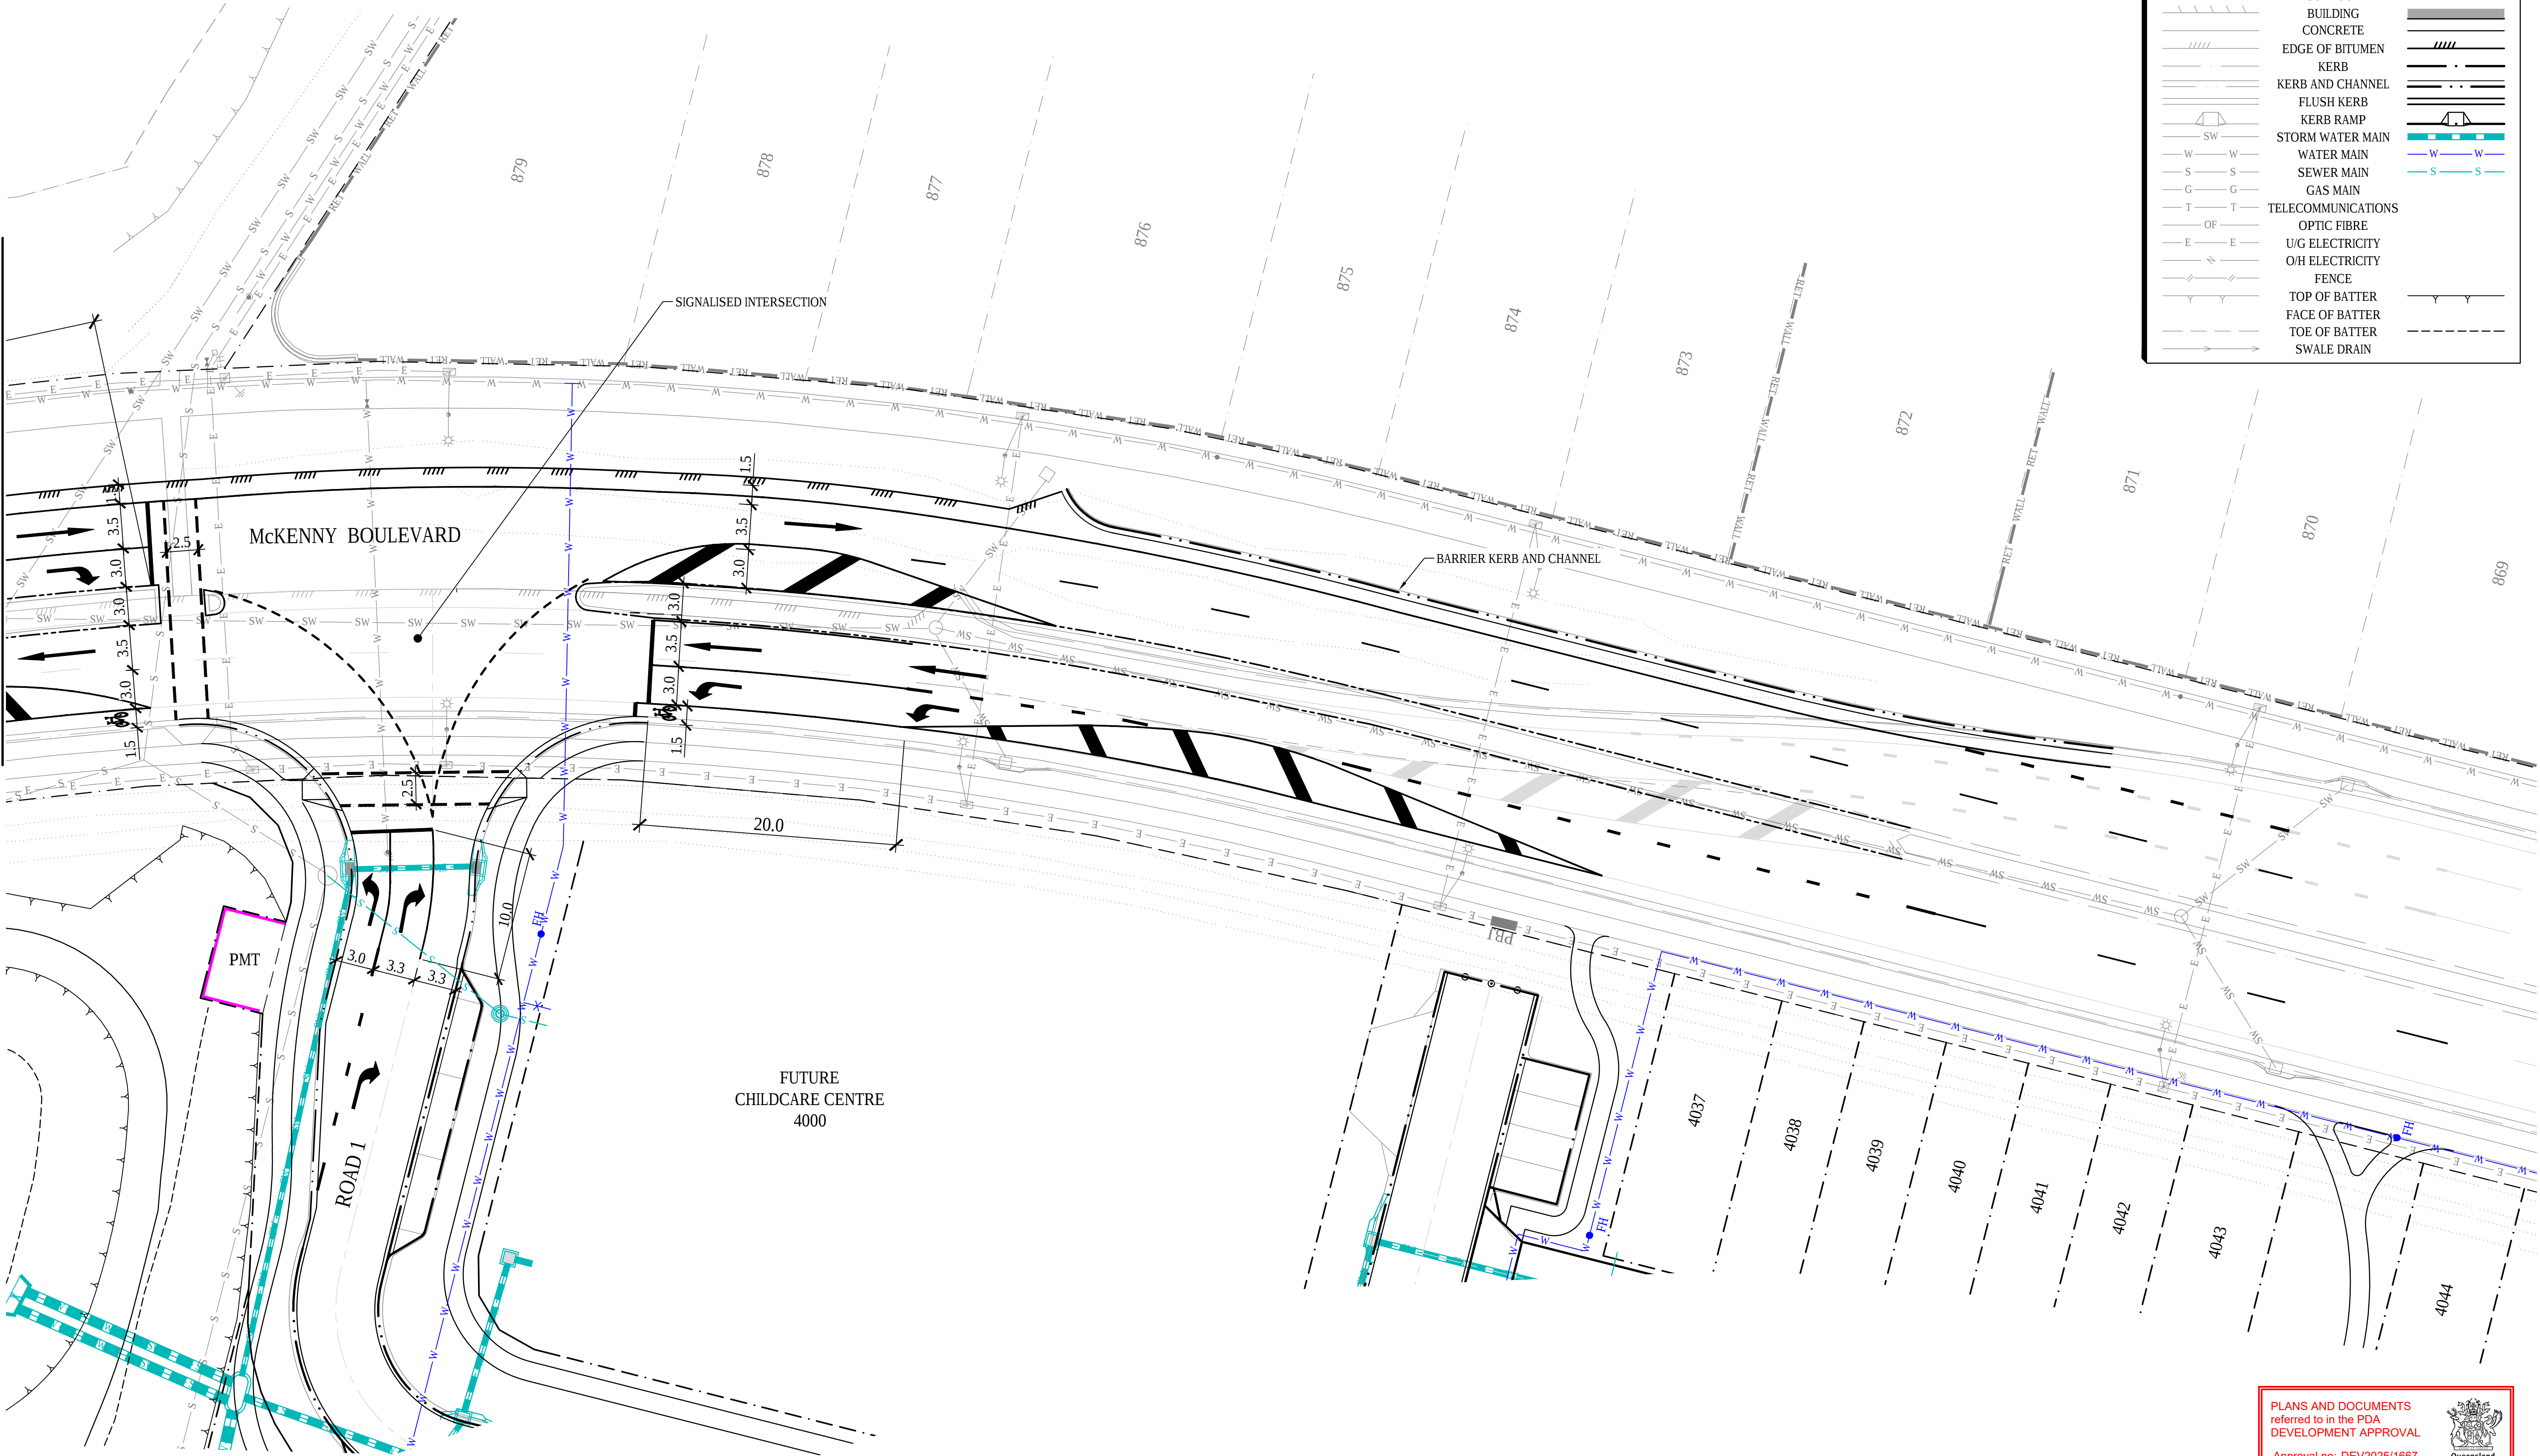

EXISTING	LEGEND	PROPOSED
	PROPERTY BOUNDARY	
	EASEMENT BOUNDARY	
	CONTOUR 5.00	
	BUILDING	
	CONCRETE	
	EDGE OF BITUMEN	
	KERB	
	KERB AND CHANNEL	
	FLUSH KERB	
	KERB RAMP	
	STORM WATER MAIN	
	WATER MAIN	
	SEWER MAIN	
	GAS MAIN	
	TELECOMMUNICATIONS	
	OPTIC FIBRE	
	U/G ELECTRICITY	
	O/H ELECTRICITY	
	FENCE	
	TOP OF BATTER	
	FACE OF BATTER	
	TOE OF BATTER	
	SWALE DRAIN	

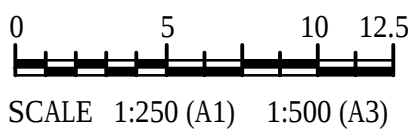

CONSULTANT: MPN CONSULTING PTY LTD
CONTACT:
TELEPHONE: (07) 3335 4555

DATE

ISSUE	DATE	AMENDMENT	BY	APP
B	01.09.25	FOR APPROVAL	KC	LS
A	17.07.25	FOR APPROVAL	KC	LS

YARRABILBA PRECINT 4H

YARRABILBA, QLD 4207

SCALES:	AS SHOWN
DESIGN:	KC
DRAWN:	MA
CHKD:	
APPRD:	
DATE:	

CLIENT:



EXTERNAL CIVIL WORKS PLAN
- SHEET 2



COPYRIGHT: THIS DESIGN AND PLANS ARE NOT TO BE USED OR REPRODUCED WHOLLY OR IN PART WITHOUT WRITTEN PERMISSION OF MPN CONSULTING PTY LIMITED 2023 ©

ABN: 39 062 191 799
P: 61 7 3335 4555
E: solutions@mpnc.au

Level 4, Building 3,
Kings Row Office Park,
42 McDougall Street, Milton, QLD, 4064

PLANS AND DOCUMENTS
referred to in the PDA
DEVELOPMENT APPROVAL
Approval no: DEV2025/1667
Date: 23 October 2025



mpn JOB


10479

DRAWING No.

ER.1.02

REV

B

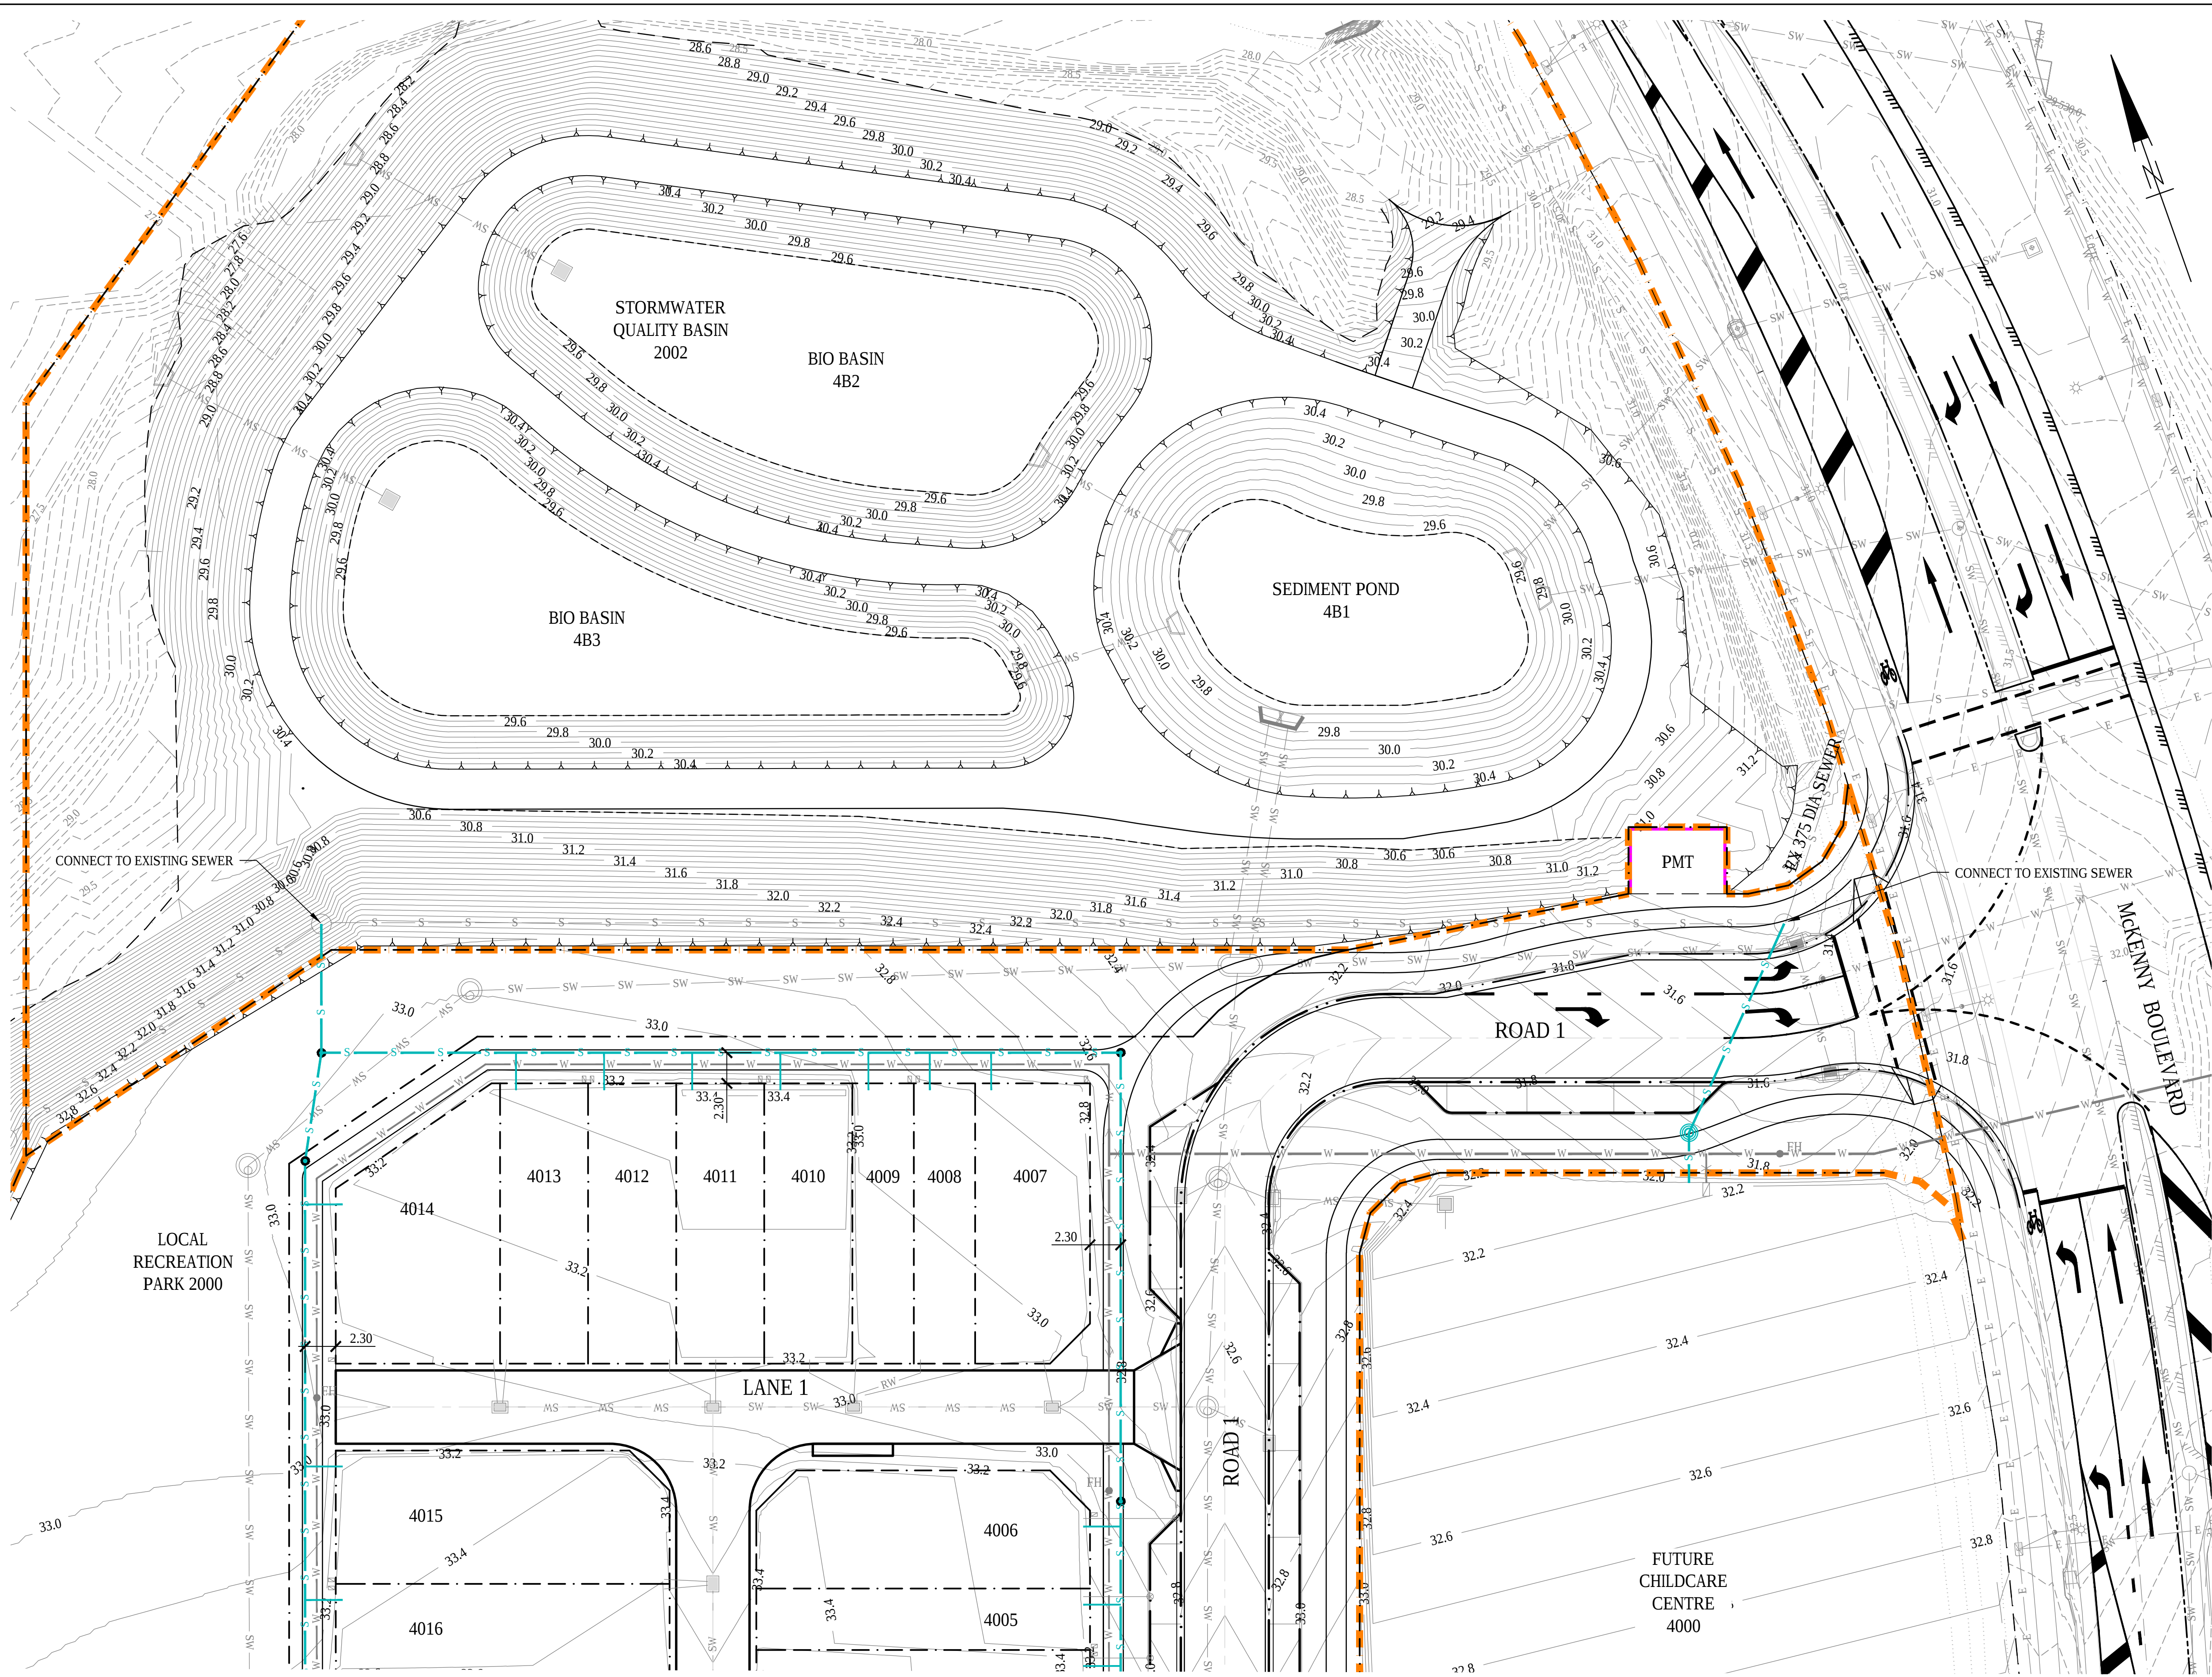

EXISTING

LEGEND

PROPOSED

PROPERTY BOUNDARY

EASEMENT BOUNDARY

CONTOUR

BUILDING

CONCRETE

EDGE OF BITUMEN

KERB

KERB AND CHANNEL

FLUSH KERB

SEWER MAIN

WATER

STAGE BOUNDARY

5.00


S

S

W


W

PLANS AND DOCUMENTS referred to in the PDA DEVELOPMENT APPROVAL
Approval no: DEV2025/1667
Date: 23 October 2025

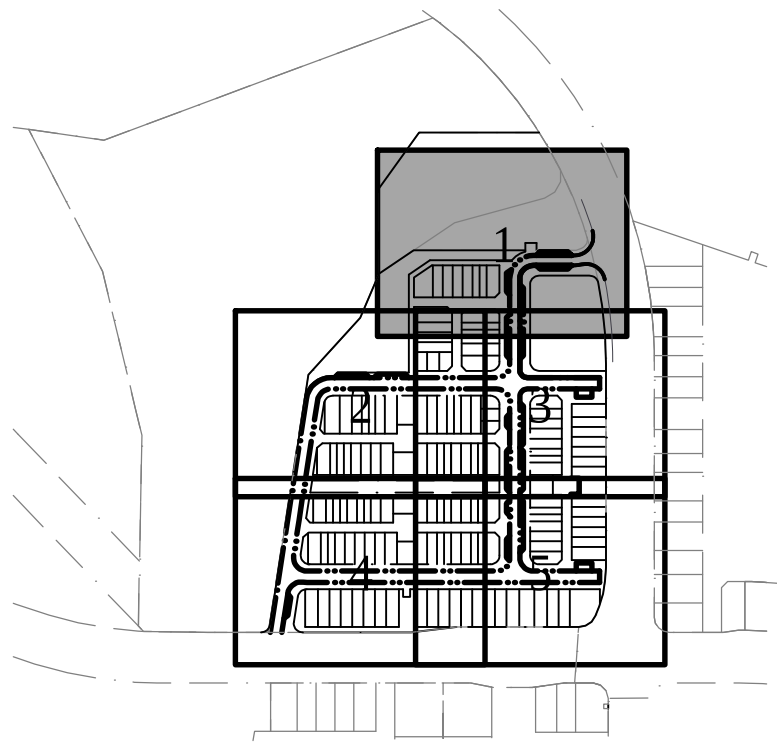

FOR CONTINUATION REFER DWG NO. SR.1.02

FOR CONTINUATION REFER DWG NO. SR.1.03

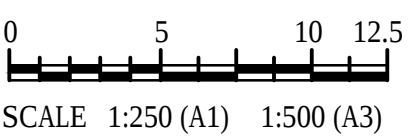

CONSULTANT: MPN CONSULTING PTY LTD
CONTACT:
TELEPHONE: (07) 3335 4555
DATE: _____

D	03.09.25	FOR APPROVAL	KC	LS
C	01.09.25	FOR APPROVAL	KC	LS
B	17.07.25	FOR APPROVAL	KC	LS
A	11.07.25	PRELIMINARY ISSUE	RvZ	LS
ISSUE DATE		AMENDMENT	BY	APP

YARRABILBA PRECINT 4H
YARRABILBA, QLD 4207

SCALES:	AS SHOWN
DESIGN:	KC
DRAWN:	RvZ
CHKD:	
APPRD:	
DATE:	

CLIENT: **Stockland**

SEWER LAYOUT PLAN
- SHEET 1


ABN: 39 062 191 799
P: 61 7 3335 4555
E: solutions@mpnc.au
Level 4, Building 3,
Kings Row Office Park,
42 McDougall Street, Milton, QLD, 4064

COPYRIGHT: THIS DESIGN AND PLANS ARE NOT TO BE USED OR REPRODUCED WHOLLY OR IN PART WITHOUT WRITTEN PERMISSION OF MPN CONSULTING PTY LIMITED 2023 ©

mpn JOB
10479

DRAWING No.
SR.1.01

REV
D

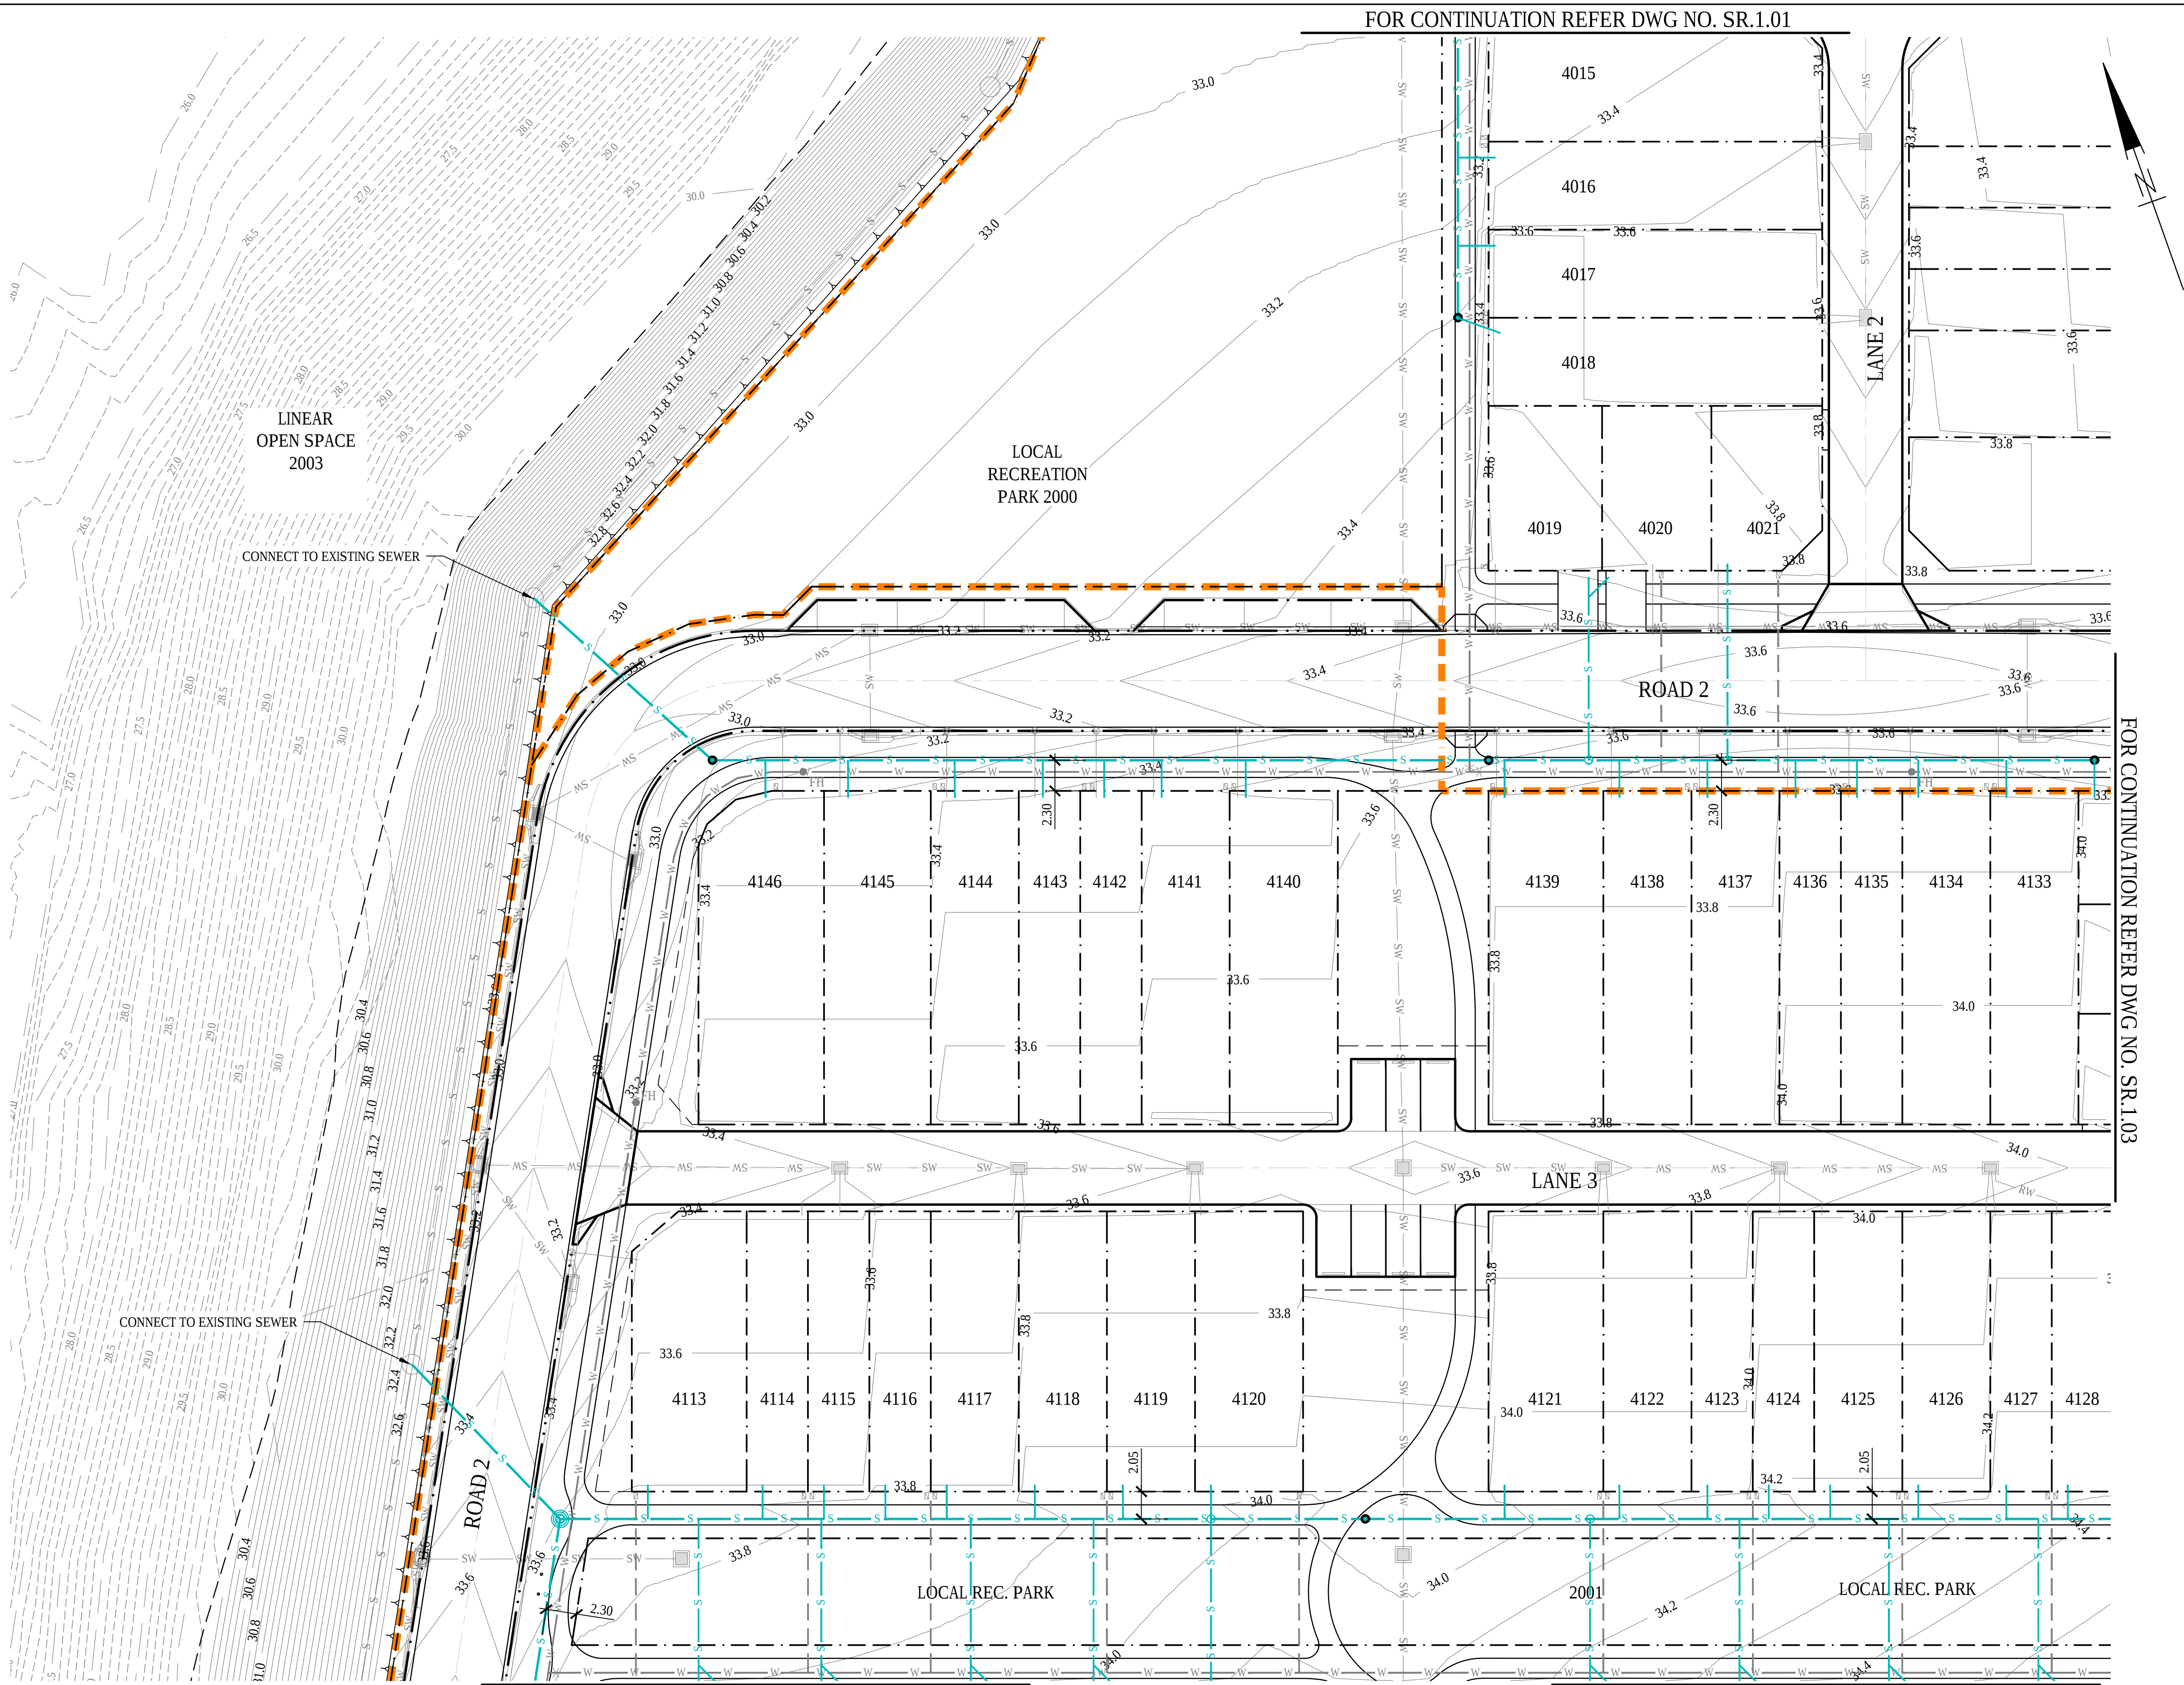

EXISTING

LEGEND

PROPOSED

PROPERTY BOUNDARY

EASEMENT BOUNDARY

CONTOUR

BUILDING

CONCRETE

EDGE OF BITUMEN

KERB

KERB AND CHANNEL

FLUSH KERB

SEWER MAIN


WATER

STAGE BOUNDARY

PLANS AND DOCUMENTS referred to in the PDA DEVELOPMENT APPROVAL


Approval no: DEV2025/1667

Date: 23 October 2025

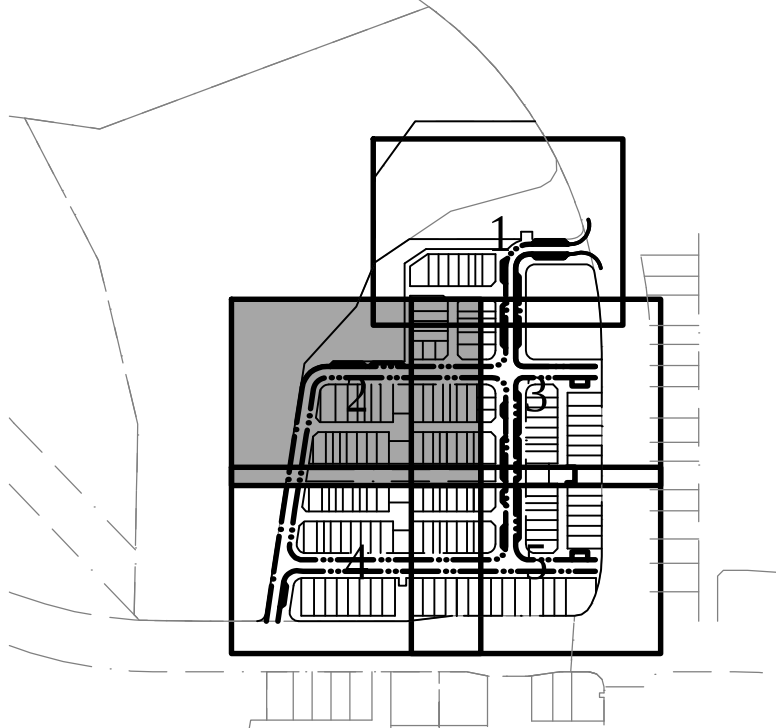

FOR CONTINUATION REFER DWG NO. SR.1.04

FOR CONTINUATION REFER DWG NO. SR.1.05

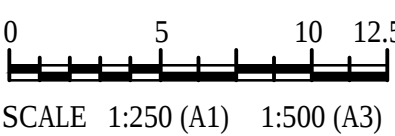

CONSULTANT: MPN CONSULTING PTY LTD

CONTACT: TELEPHONE: (07) 3335 4555

DATE: -

D	03.09.25	FOR APPROVAL	KC	LS
C	01.09.25	FOR APPROVAL	KC	LS
B	17.07.25	FOR APPROVAL	KC	LS
A	11.07.25	PRELIMINARY ISSUE	RvZ	LS
ISSUE DATE		AMENDMENT	BY	APP

YARRABILBA PRECINT 4H

YARRABILBA, QLD 4207

SCALES:	AS SHOWN
DESIGN:	KC
DRAWN:	RvZ
CHKD:	
APPRD:	
DATE:	

CLIENT: Stockland

SEWER LAYOUT PLAN

- SHEET 2

ABN: 39 062 191 799

P: 61 7 3335 4555

E: solutions@mpnc.au

Level 4, Building 3,
Kings Row Office Park,
42 McDougall Street, Milton, QLD, 4064

COPYRIGHT: THIS DESIGN AND PLANS ARE NOT TO BE USED OR REPRODUCED WHOLLY OR IN PART WITHOUT WRITTEN PERMISSION OF MPN CONSULTING PTY LIMITED 2023 ©

mpn JOB

10479


DRAWING No.

SR.1.02

REV

D

FOR CONTINUATION REFER DWG NO. SR.1.02

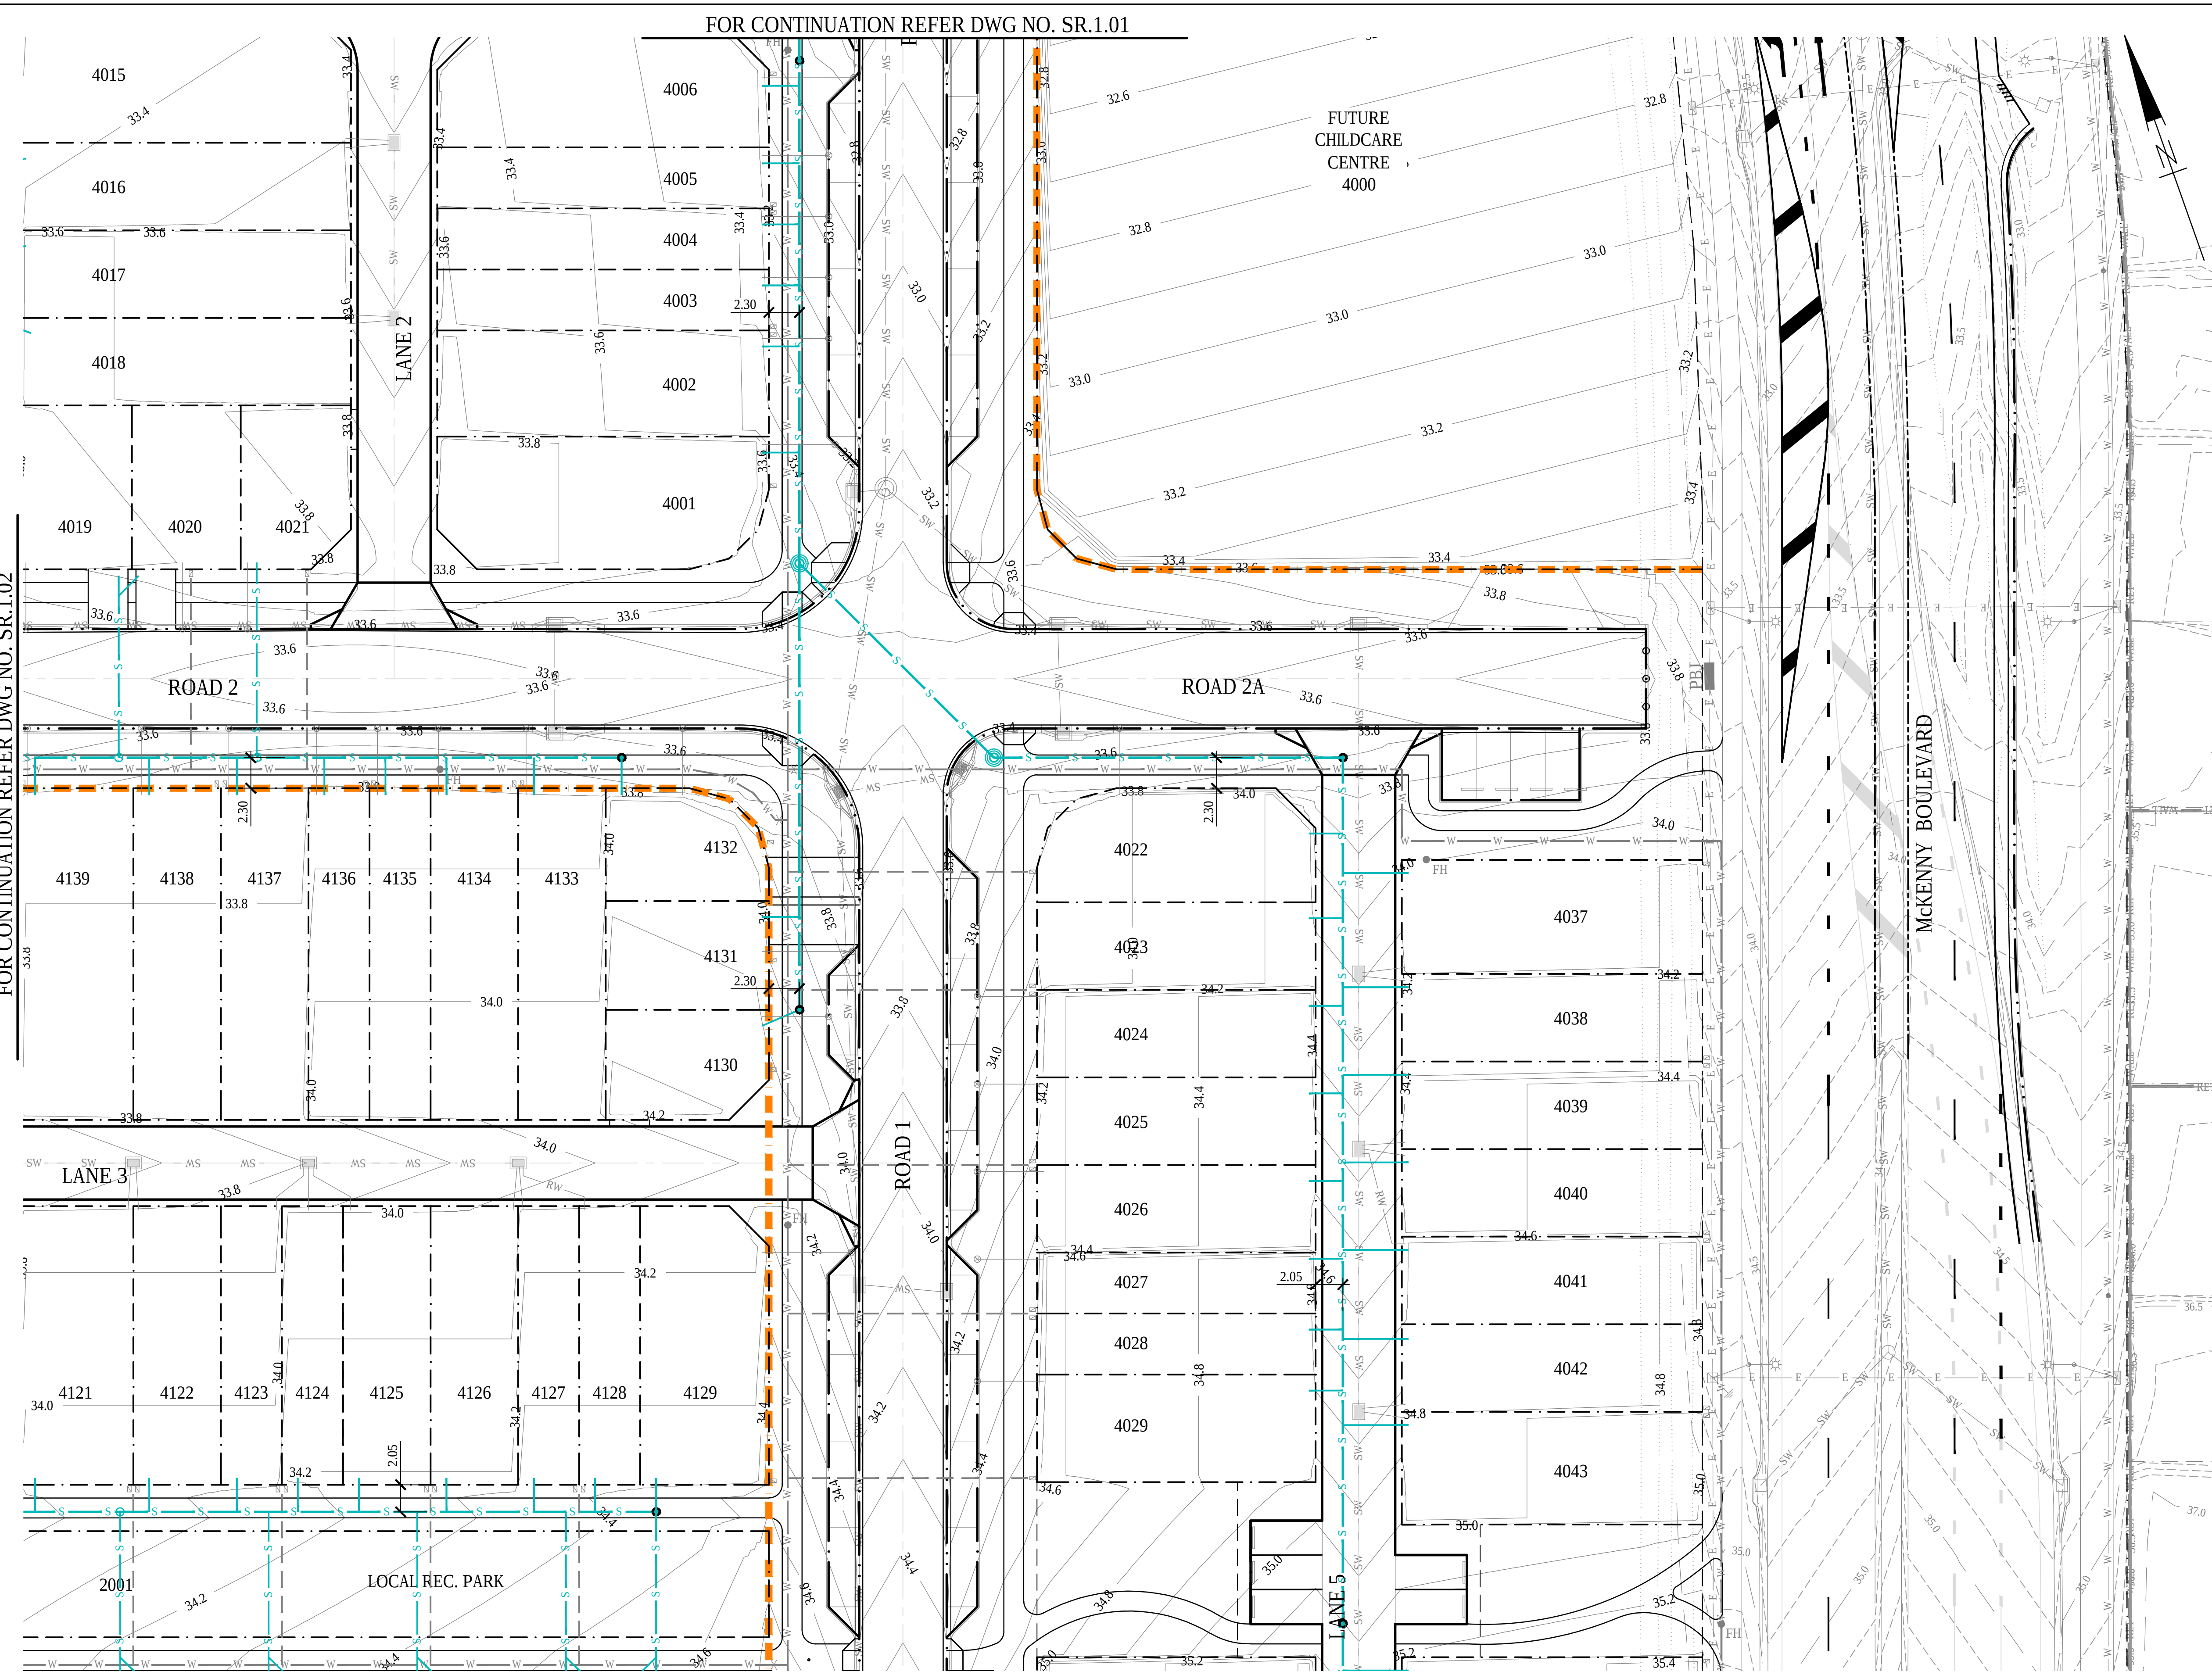

EXISTING

LEGEND

PROPOSED

PROPERTY BOUNDARY

EASEMENT BOUNDARY

CONTOUR

BUILDING

CONCRETE

EDGE OF BITUMEN

KERB

KERB AND CHANNEL

FLUSH KERB

SEWER MAIN

WATER

STAGE BOUNDARY

5.00

S

S



W

W

PLANS AND DOCUMENTS referred to in the PDA DEVELOPMENT APPROVAL

Approval no: DEV2025/1667

Date: 23 October 2025

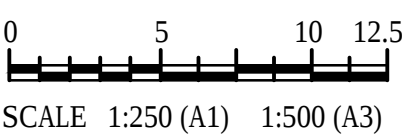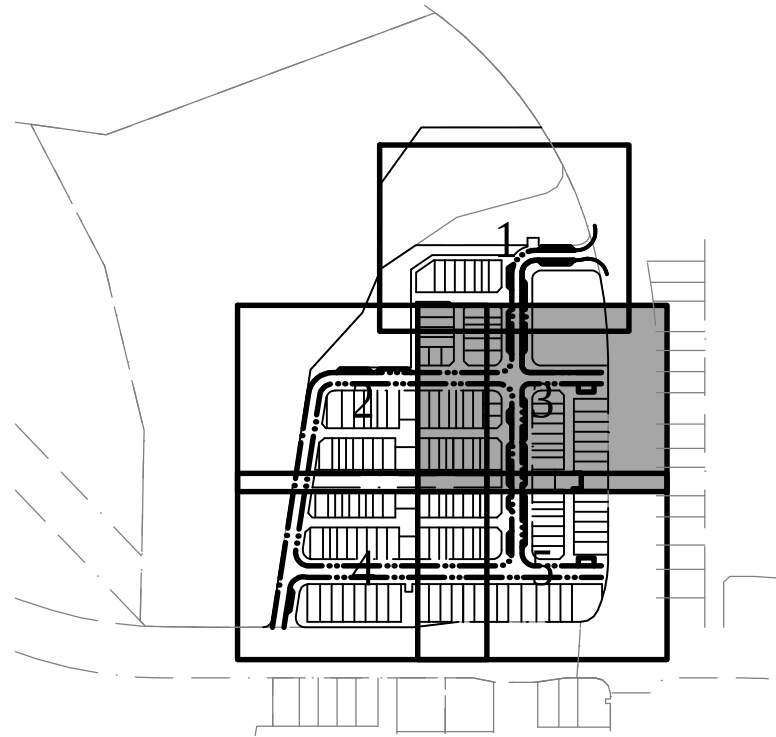

CONSULTANT: MPN CONSULTING PTY LTD

CONTACT: TELEPHONE: (07) 3335 4555

DATE: -

D	03.09.25	FOR APPROVAL	KC	LS
C	01.09.25	FOR APPROVAL	KC	LS
B	17.07.25	FOR APPROVAL	KC	LS
A	11.07.25	PRELIMINARY ISSUE	RvZ	LS
ISSUE DATE		AMENDMENT		BY APP

YARRABILBA PRECINT 4H

YARRABILBA, QLD 4207

SCALES: AS SHOWN

DESIGN: KC

DRAWN: RVZ

CHKD:

APPRD:

DATE:

CLIENT: Stockland

SEWER LAYOUT PLAN

- SHEET 3

ABN: 39 062 191 799

P: 61 7 3335 4555

E: solutions@mpnc.au

Level 4, Building 3,

Kings Row Office Park,

42 McDougall Street, Milton, QLD, 4064

COPYRIGHT: THIS DESIGN AND PLANS ARE NOT TO BE USED OR REPRODUCED WHOLLY OR IN PART WITHOUT WRITTEN PERMISSION OF MPN CONSULTING PTY LIMITED 2023 ©

mpn JOB

10479

DRAWING No.


SR.1.03

REV

D



FOR CONTINUATION REFER DWG NO. SR.1.02

FOR CONTINUATION REFER DWG NO. SR.1.03

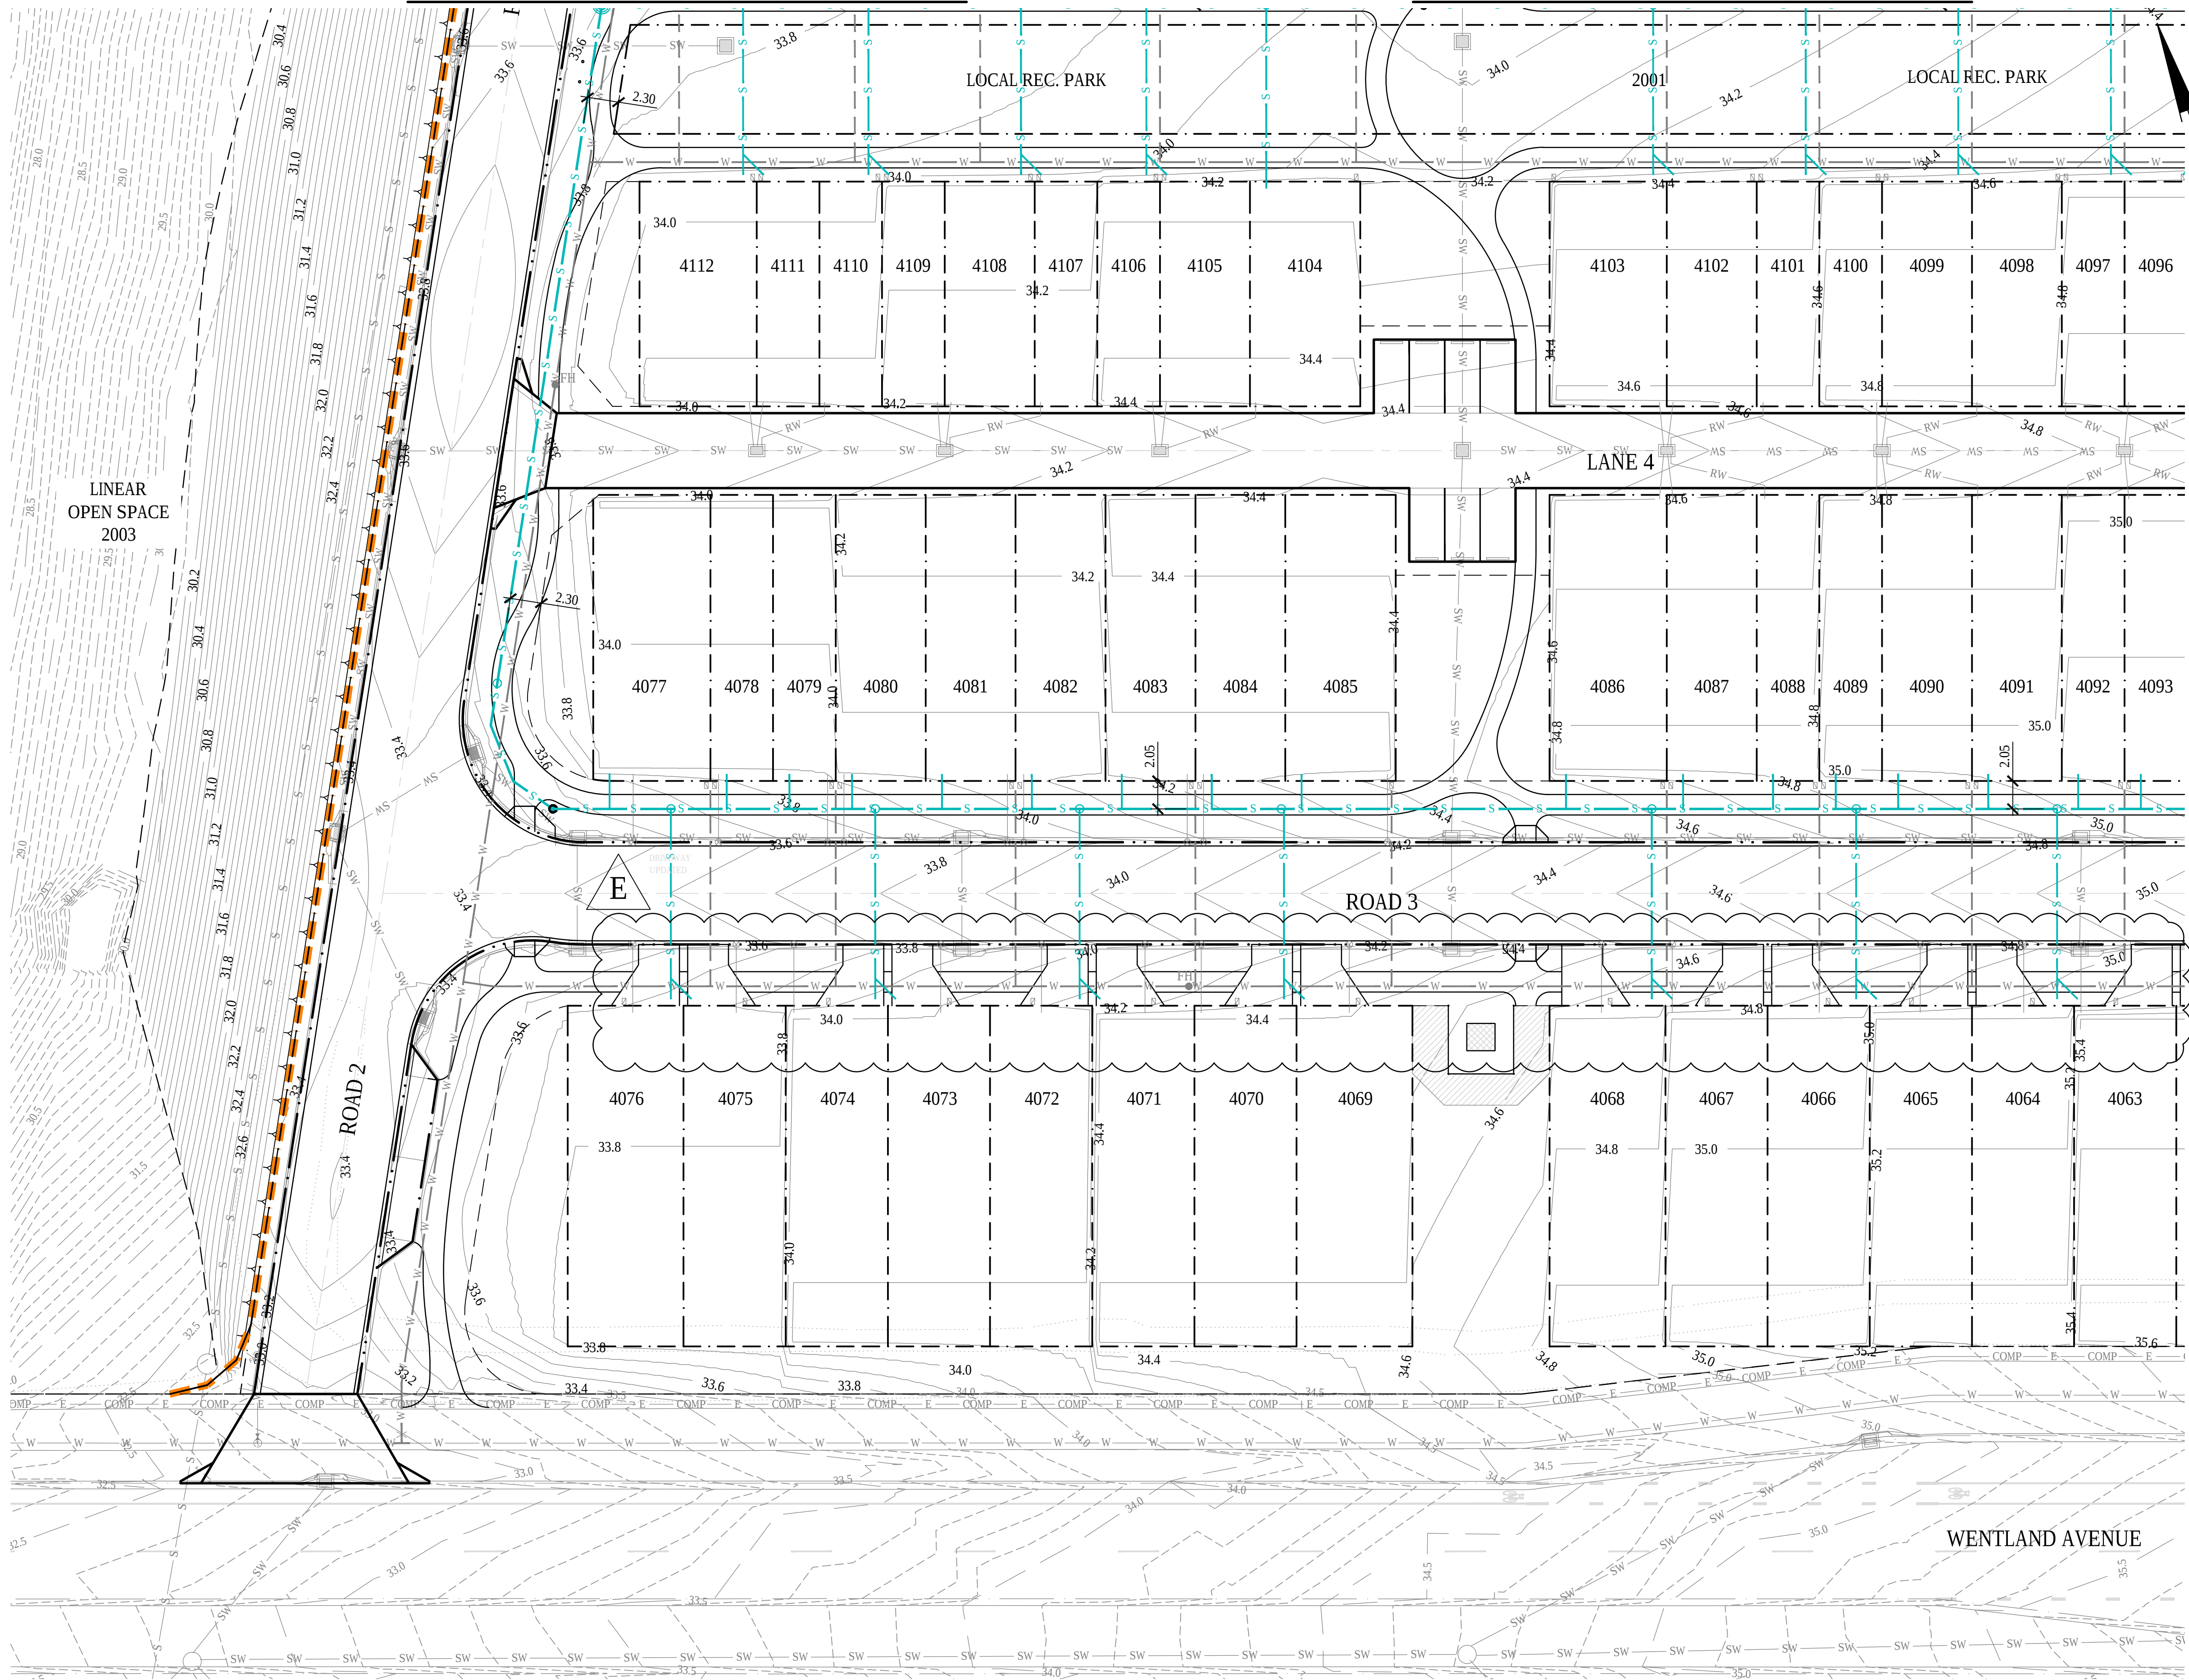

LEGEND	
EXISTING	PROPOSED
PROPERTY BOUNDARY	---
EASEMENT BOUNDARY	---
CONTOUR	5.00
BUILDING	---
CONCRETE	---
EDGE OF BITUMEN	---
KERB	---
KERB AND CHANNEL	---
FLUSH KERB	---
SEWER MAIN	---
WATER	---
STAGE BOUNDARY	---

PLANS AND DOCUMENTS referred to in the PDA DEVELOPMENT APPROVAL
Approval no: DEV2025/1667
Date: 23 October 2025

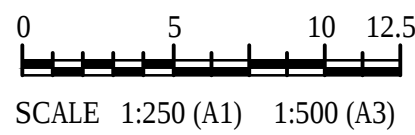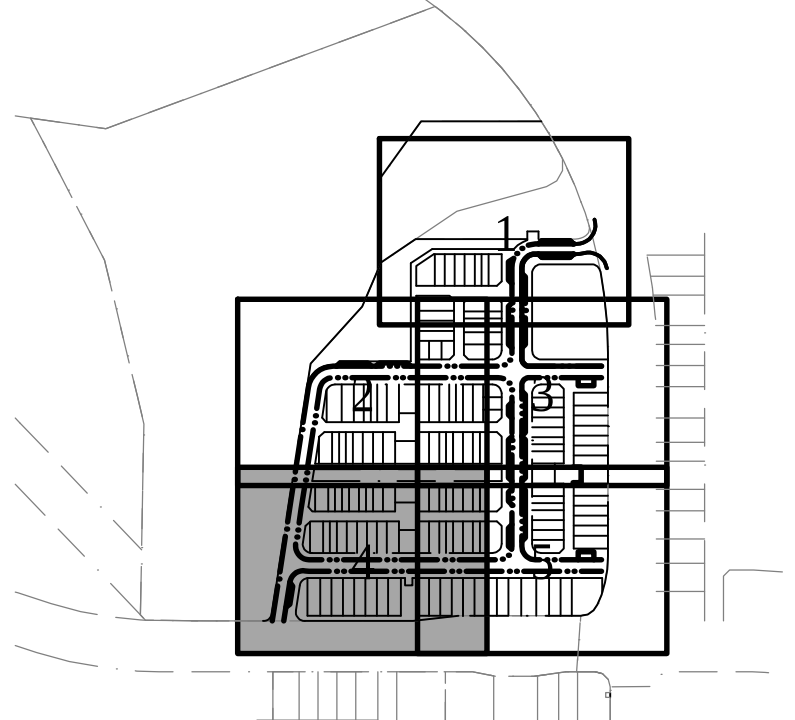

CONSULTANT: MPN CONSULTING PTY LTD
CONTACT:
TELEPHONE: (07) 3335 4555
DATE: -

E	14.10.25	FOR APPROVAL	KC	LS
D	03.09.25	FOR APPROVAL	KC	LS
C	01.09.25	FOR APPROVAL	KC	LS
B	17.07.25	FOR APPROVAL	KC	LS
A	11.07.25	PRELIMINARY ISSUE	RvZ	LS
ISSUE DATE		AMENDMENT		BY APP

YARRABILBA PRECINT 4H
YARRABILBA, QLD 4207

SCALES: AS SHOWN
DESIGN: KC
DRAWN: RVZ
CHKD:
APPRD:
DATE:

CLIENT: Stockland
SEWER LAYOUT PLAN
- SHEET 4


MPN CONSULTING
ABN: 39 062 191 799
P: 61 7 3335 4555
E: solutions@mpnc.au
Level 4, Building 3,
Kings Row Office Park,
42 McDougall Street, Milton, QLD, 4064
COPYRIGHT: THIS DESIGN AND PLANS ARE NOT TO BE USED OR REPRODUCED WHOLLY OR IN PART WITHOUT WRITTEN PERMISSION OF MPN CONSULTING PTY LIMITED 2023 ©

mpn JOB
10479
DRAWING No.
SR.1.04
REV
E

FOR CONTINUATION REFER DWG NO. SR.1.04

FOR CONTINUATION REFER DWG NO. SR.1.02

FOR CONTINUATION REFER DWG NO. SR.1.03

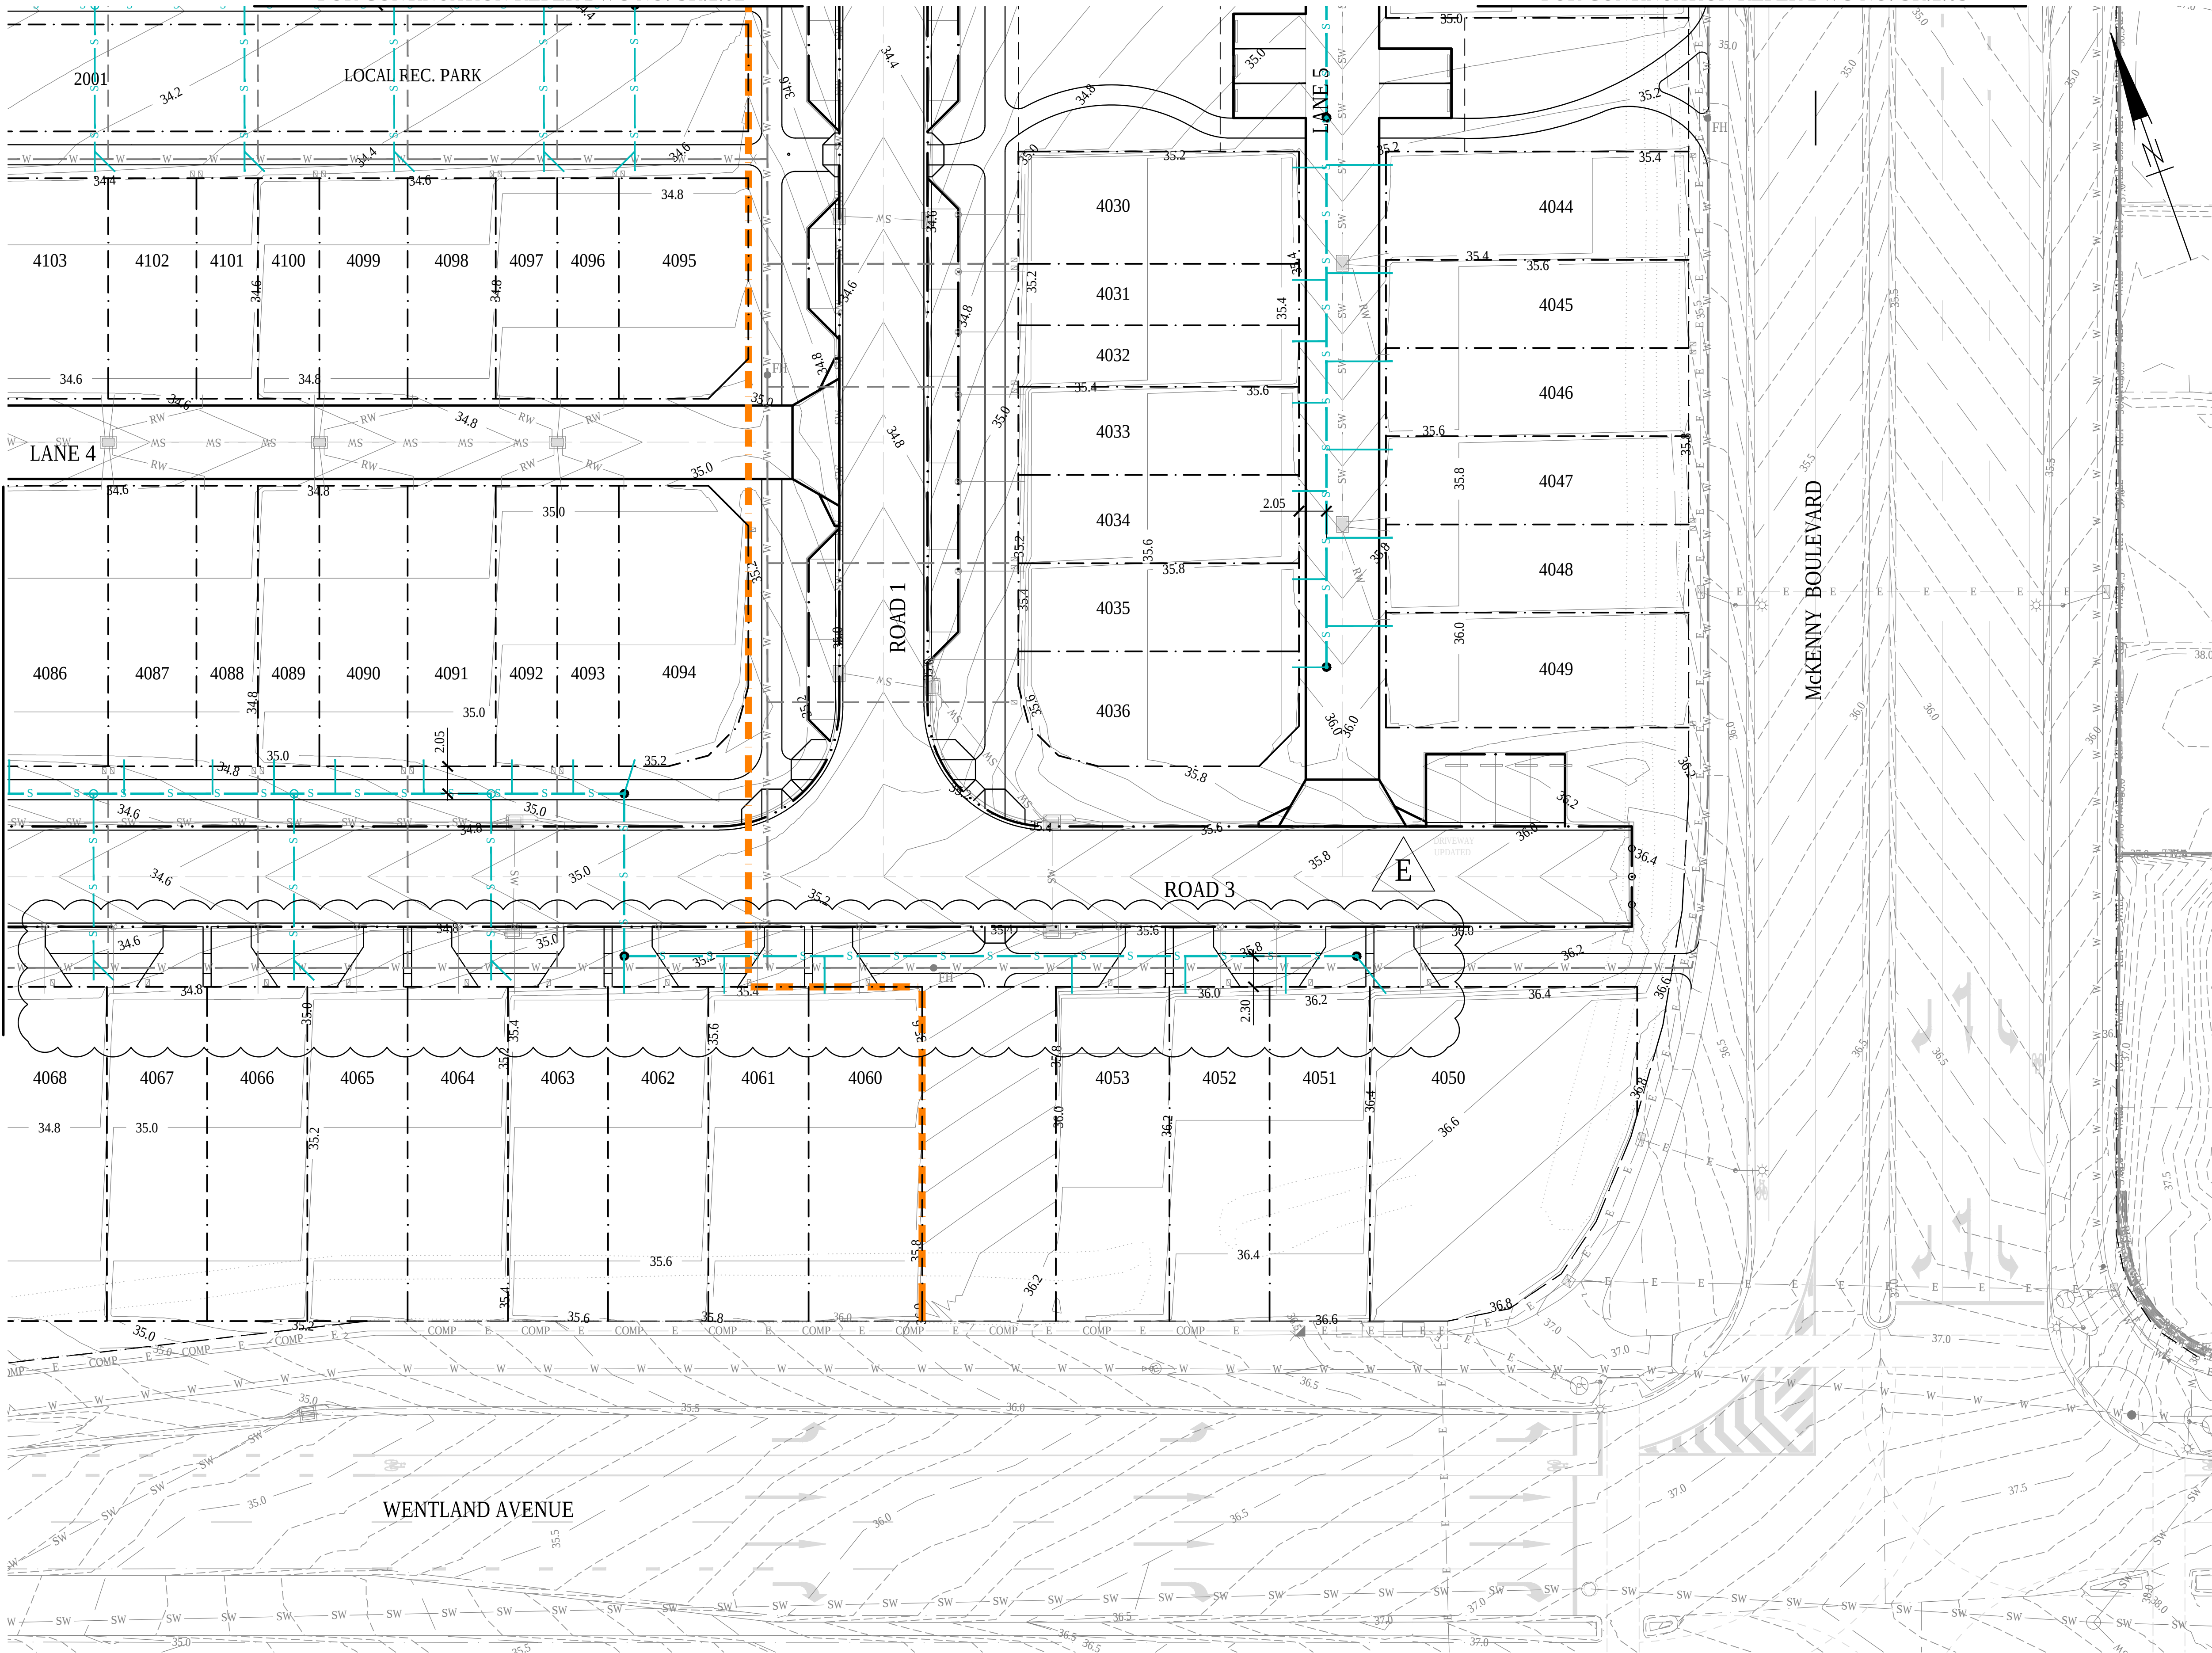

EXISTING

LEGEND

PROPOSED

PROPERTY BOUNDARY

EASEMENT BOUNDARY

CONTOUR

BUILDING

CONCRETE

EDGE OF BITUMEN

KERB

KERB AND CHANNEL


FLUSH KERB

SEWER MAIN

WATER

STAGE BOUNDARY

PLANS AND DOCUMENTS
referred to in the PDA
DEVELOPMENT APPROVAL
Approval no: DEV2025/1667
Date: 23 October 2025

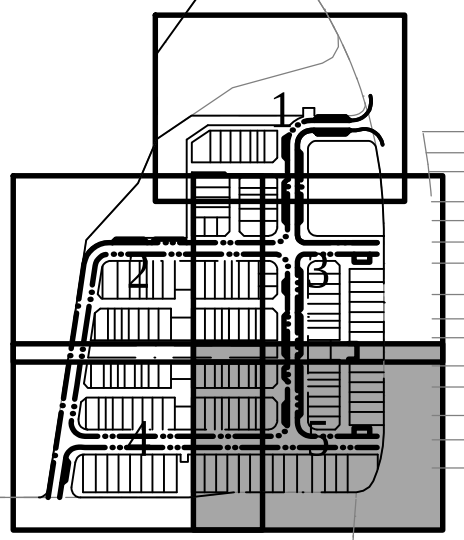

CONSULTANT: MPN CONSULTING PTY LTD
CONTACT:
TELEPHONE: (07) 3335 4555
DATE: _____

E	14.10.25	FOR APPROVAL	KC	LS
D	03.09.25	FOR APPROVAL	KC	LS
C	01.09.25	FOR APPROVAL	KC	LS
B	17.07.25	FOR APPROVAL	KC	LS
A	11.07.25	PRELIMINARY ISSUE	RvZ	LS
ISSUE DATE		AMENDMENT		BY APP

YARRABILBA PRECINT 4H
YARRABILBA, QLD 4207

SCALES: AS SHOWN
DESIGN: KC
DRAWN: RVZ
CHKD:
APPRD:
DATE:


CLIENT: Stockland
SEWER LAYOUT PLAN
- SHEET 5



COPYRIGHT: THIS DESIGN AND PLANS ARE NOT TO BE USED OR REPRODUCED WHOLLY OR IN PART WITHOUT WRITTEN PERMISSION OF MPN CONSULTING PTY LIMITED 2023 ©

ABN: 39 062 191 799
P: 61 7 3335 4555
E: solutions@mpnc.au
Level 4, Building 3,
Kings Row Office Park,
42 McDougall Street, Milton, QLD, 4064

mpn JOB
10479
DRAWING No.
SR.1.05
REV
E

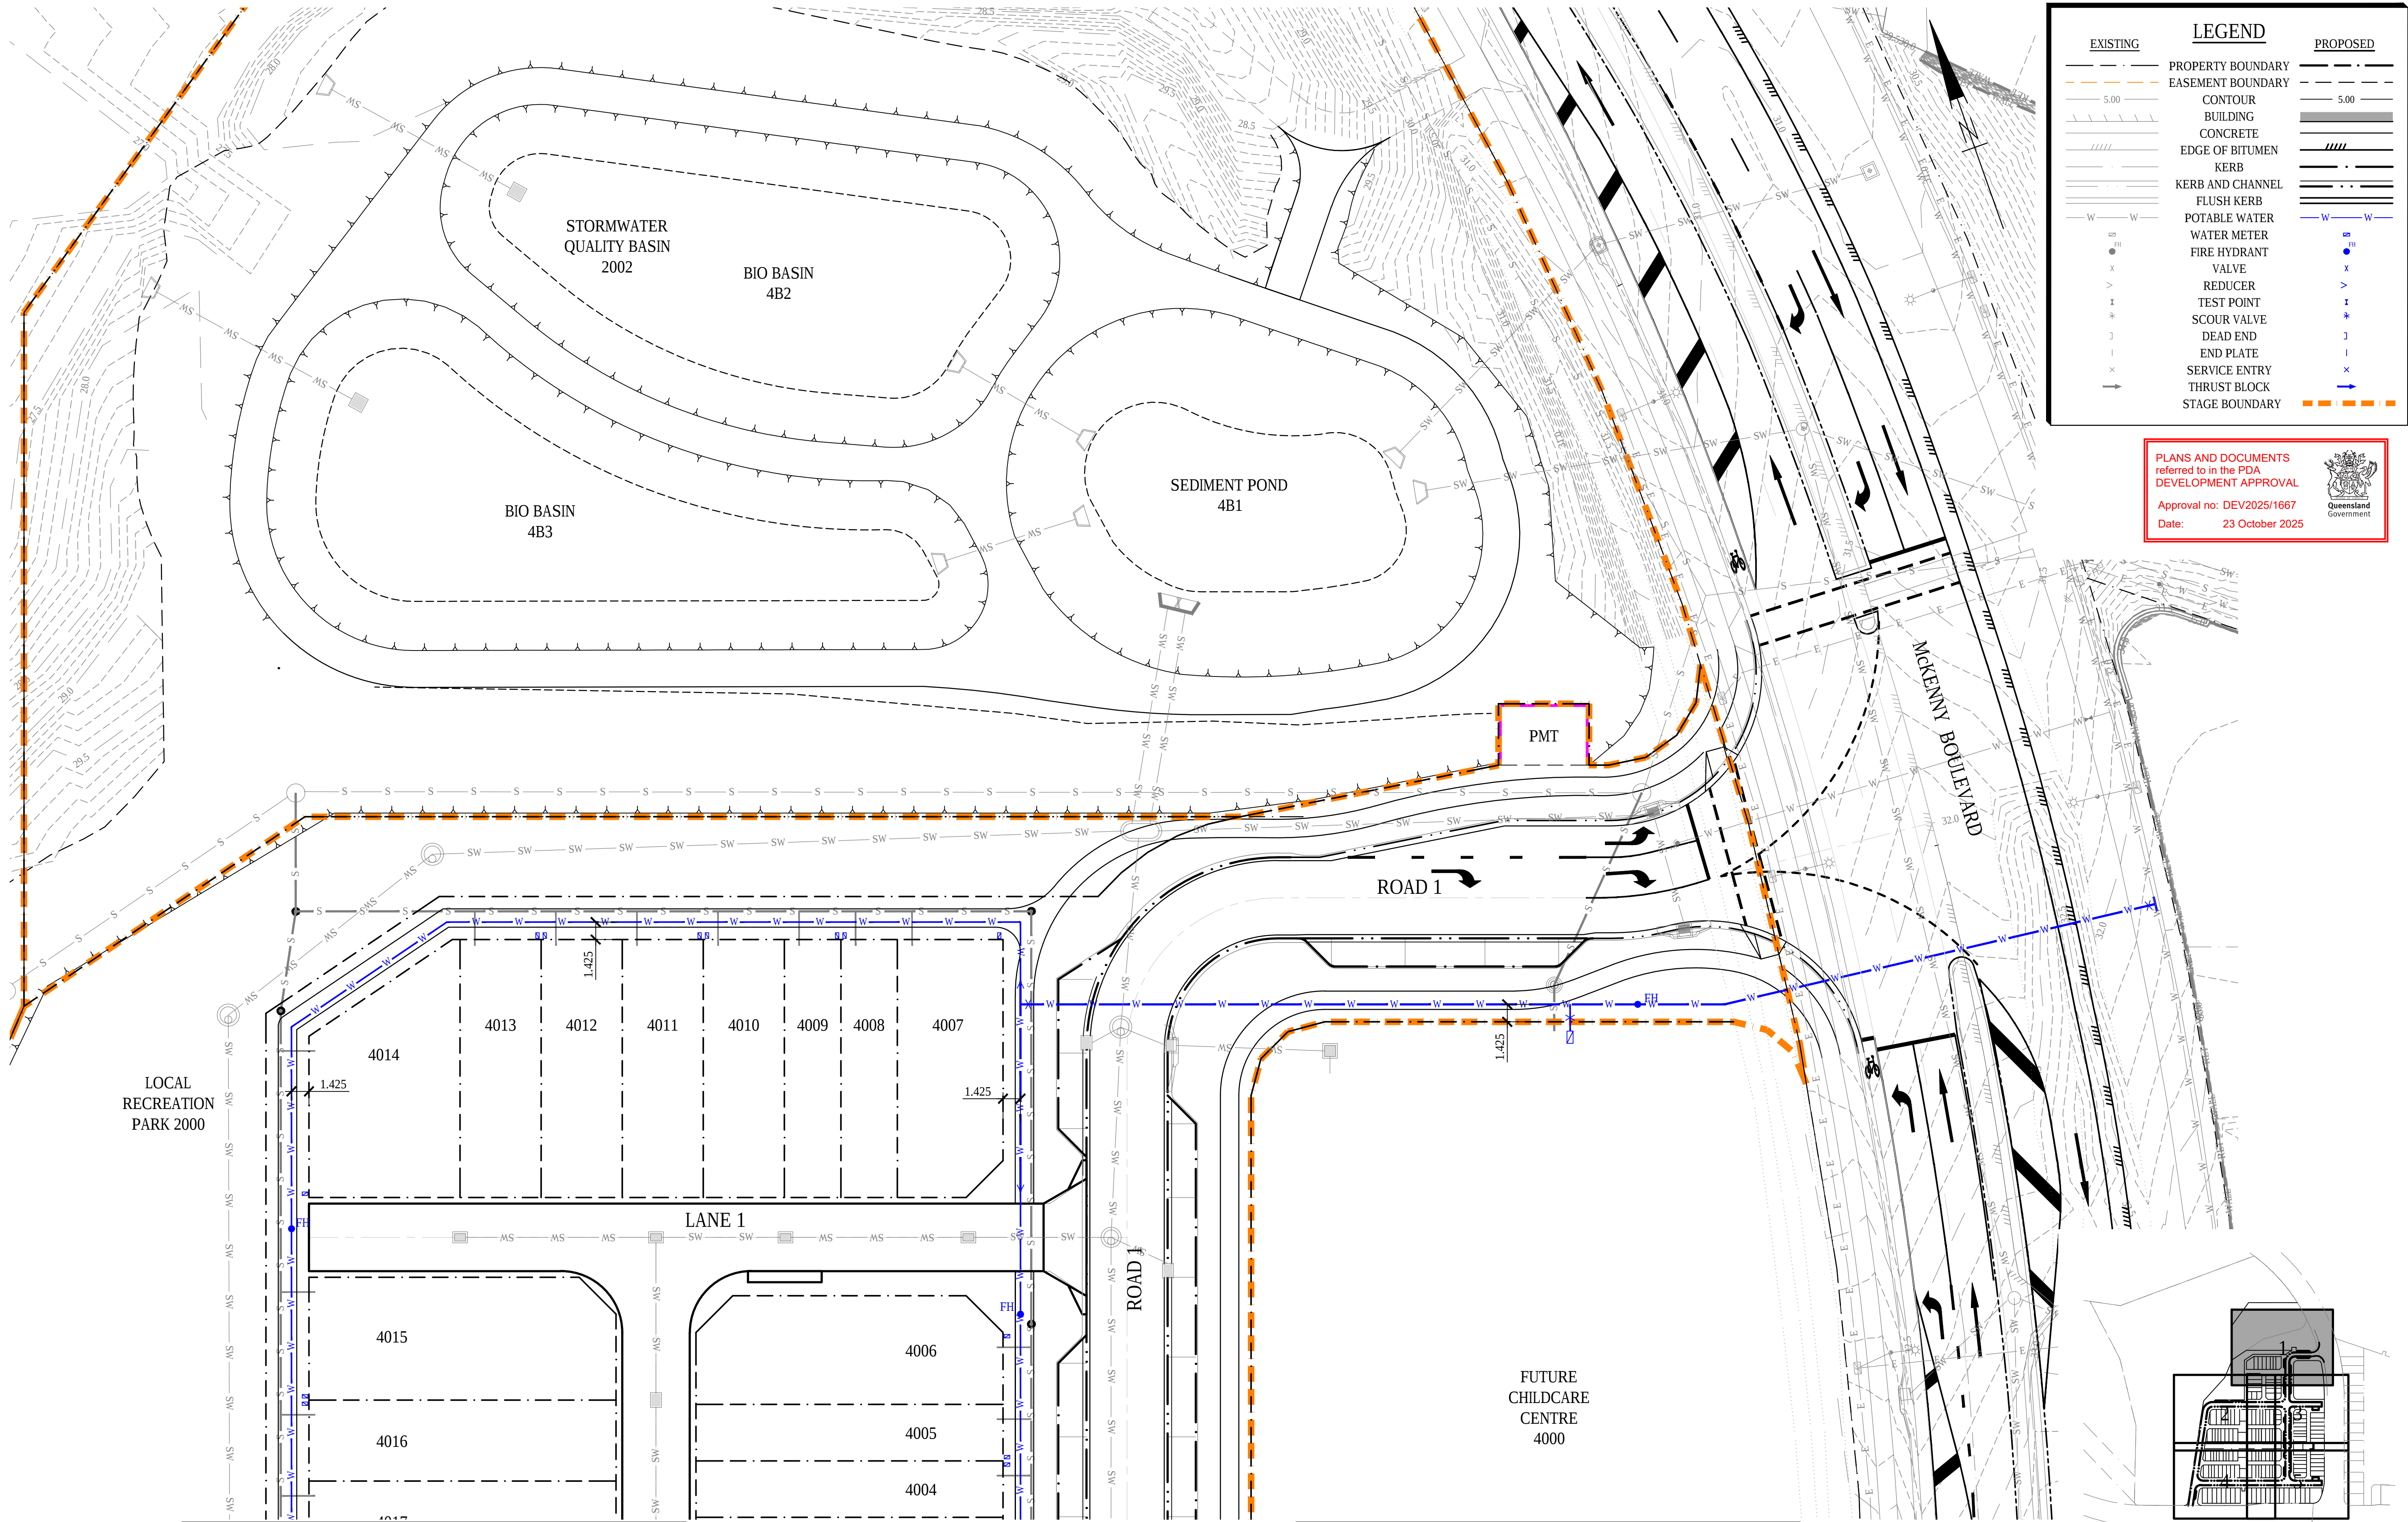

PLANS AND DOCUMENTS
referred to in the PDA
DEVELOPMENT APPROVAL
Approval no: DEV2025/1667
Date: 23 October 2025



FOR CONTINUATION REFER DWG NO. WR.1.02

FOR CONTINUATION REFER DWG NO. WR.1.03

CONSULTANT: MPN CONSULTING PTY LTD
CONTACT:
TELEPHONE: (07) 3335 4555
DATE: -

ISSUE	DATE	AMENDMENT	BY	APP
D	03.09.25	FOR APPROVAL	KC	LS
C	01.09.25	FOR APPROVAL	KC	LS
B	17.07.25	FOR APPROVAL	KC	LS
A	11.07.25	PRELIMINARY ISSUE	RvZ	LS

YARRABILBA PRECINT 4H
YARRABILBA, QLD 4207


SCALES:	AS SHOWN
DESIGN:	KC
DRAWN:	RvZ
CHKD:	
APPRD:	
DATE:	

CLIENT: Stockland
WATER LAYOUT PLAN
- SHEET 1

ABN: 39 062 191 799
P: 61 7 3335 4555
E: solutions@mpnc.au
Level 4, Building 3,
Kings Row Office Park,
42 McDougall Street, Milton, QLD, 4064
MPN CONSULTING
COPYRIGHT: THIS DESIGN AND PLANS ARE NOT TO BE USED OR REPRODUCED WHOLLY OR IN PART WITHOUT WRITTEN PERMISSION OF MPN CONSULTING PTY LIMITED 2023 ©


mpn JOB
10479
DRAWING No.
WR.1.01
REV
D

0 5 10 12.5
SCALE 1:250 (A1) 1:500 (A3)

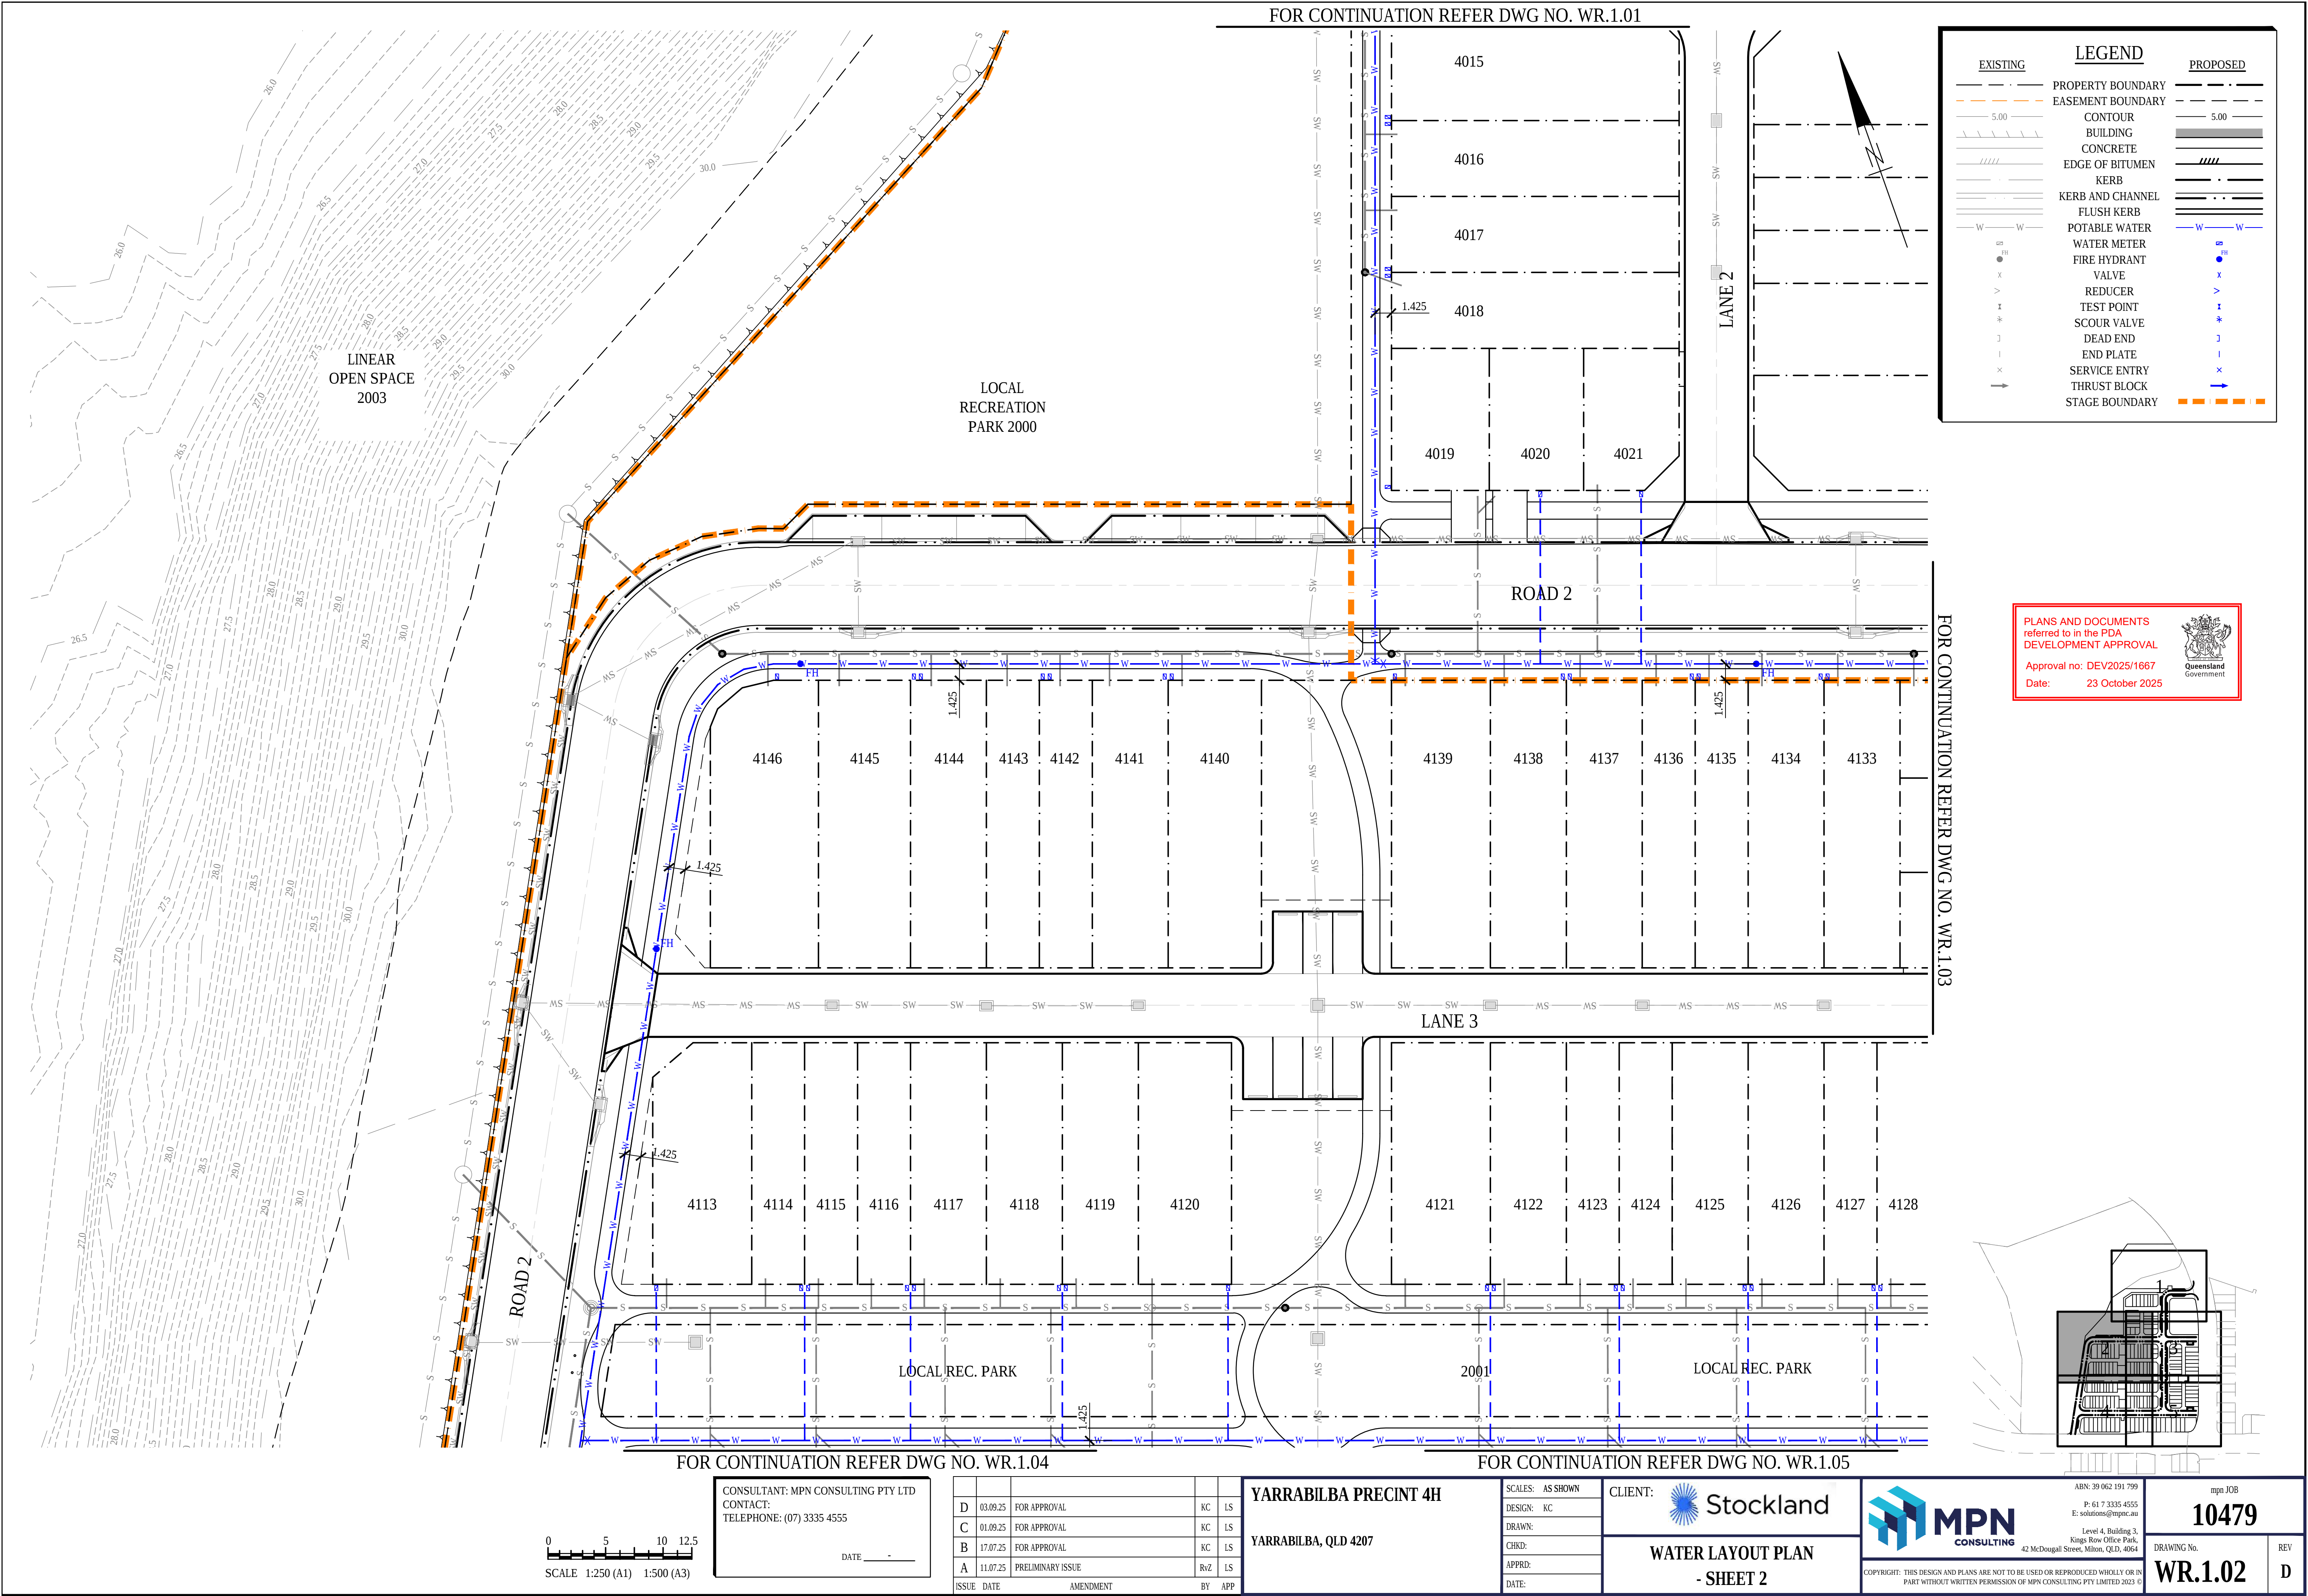


FOR CONTINUATION REFER DWG NO. WR.1.01

FOR CONTINUATION REFER DWG NO. WR.1.02

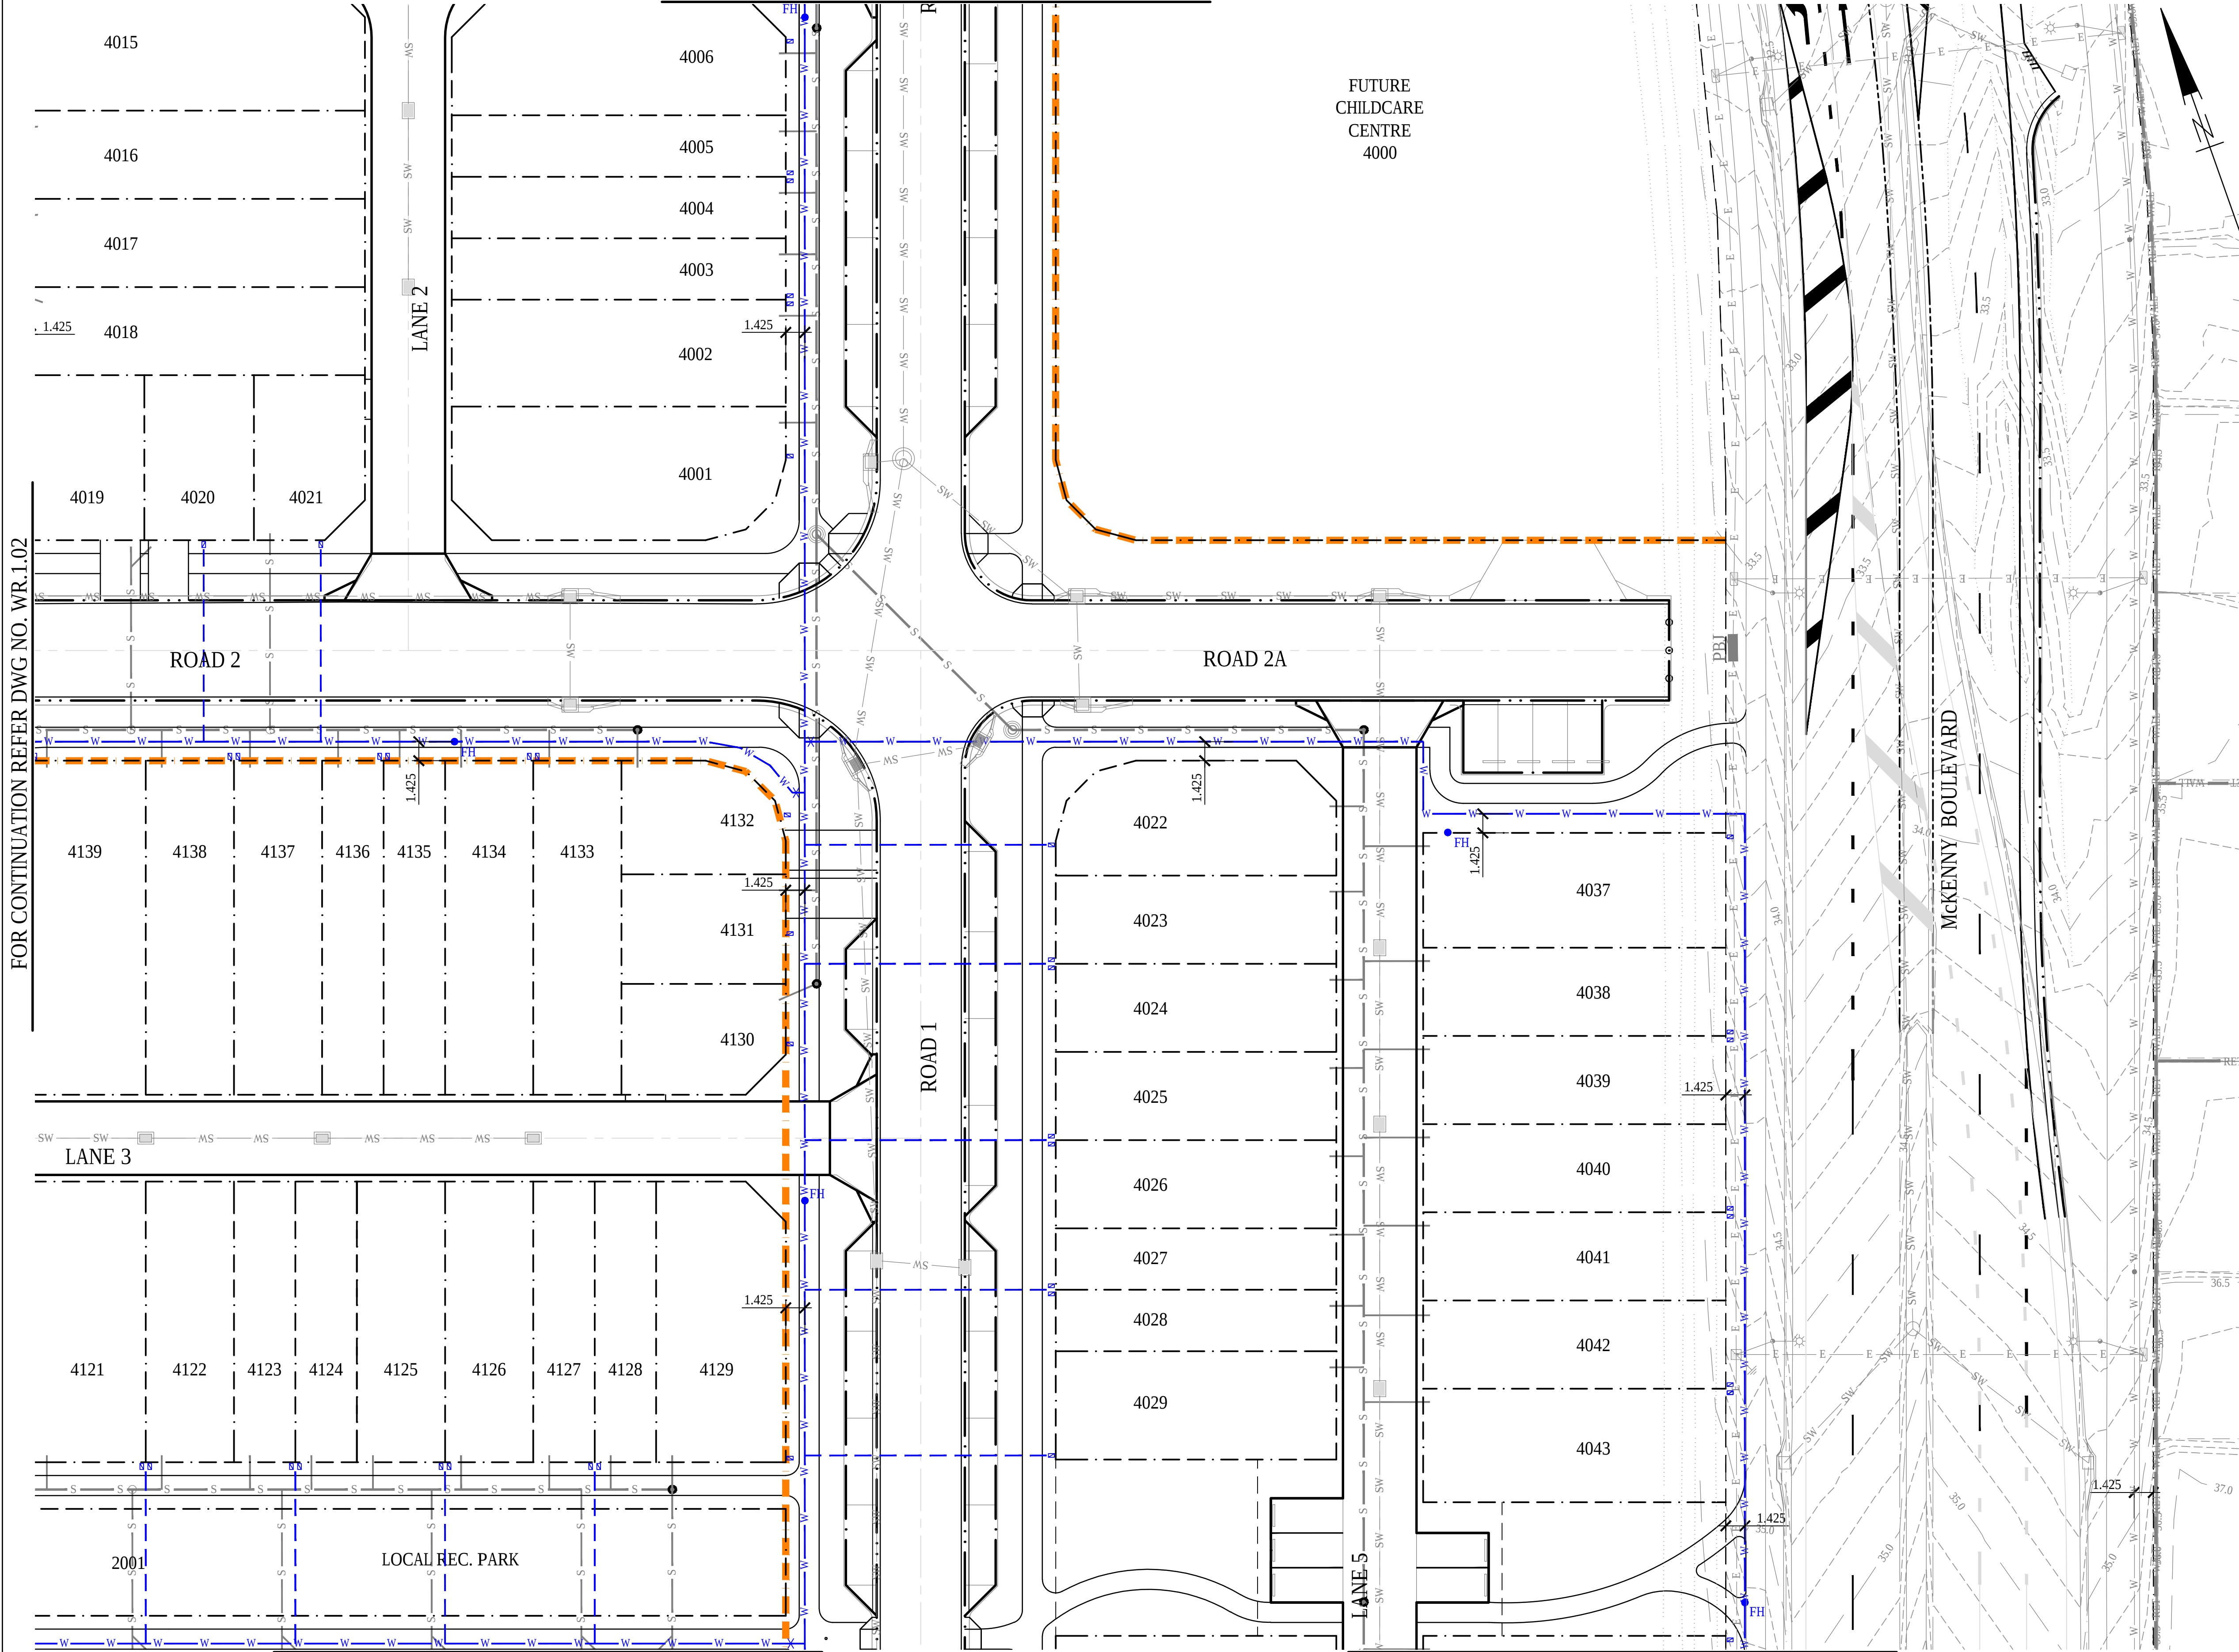


LEGEND	
EXISTING	PROPOSED

PLANS AND DOCUMENTS
referred to in the PDA
DEVELOPMENT APPROVAL
Approval no: DEV2025/1667
Date: 23 October 2025

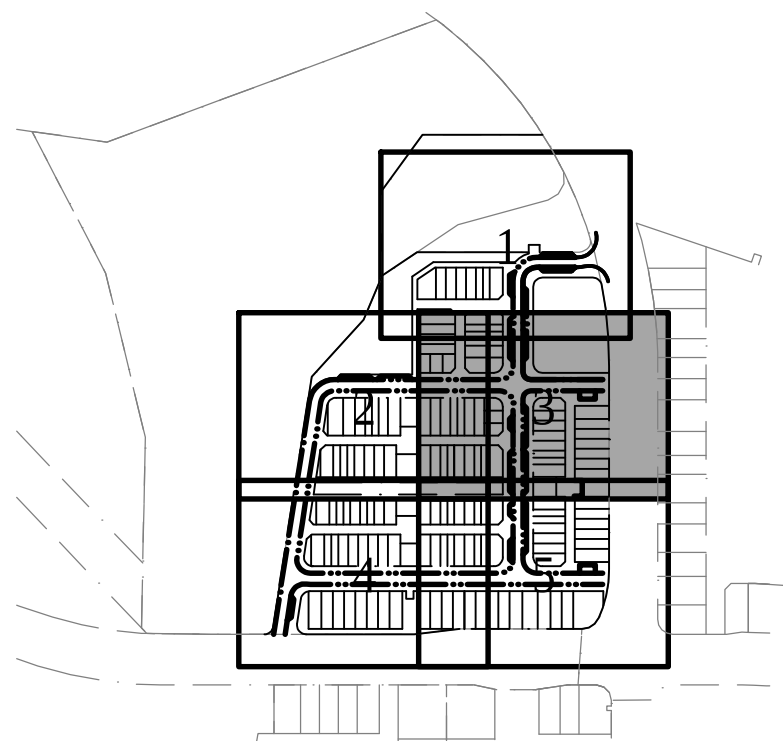

FOR CONTINUATION REFER DWG NO. WR.1.04

FOR CONTINUATION REFER DWG NO. WR.1.05

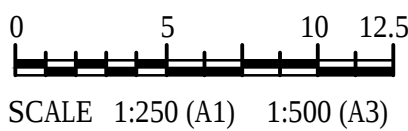

CONSULTANT: MPN CONSULTING PTY LTD
CONTACT:
TELEPHONE: (07) 3335 4555
DATE: _____

ISSUE	DATE	AMENDMENT	BY	APP
D	03.09.25	FOR APPROVAL	KC	LS
C	01.09.25	FOR APPROVAL	KC	LS
B	17.07.25	FOR APPROVAL	KC	LS
A	11.07.25	PRELIMINARY ISSUE	RvZ	LS


YARRABILBA PRECINT 4H
YARRABILBA, QLD 4207

SCALES: AS SHOWN
DESIGN: KC
DRAWN:
CHKD:
APPRD:
DATE:

CLIENT: Stockland
WATER LAYOUT PLAN
- SHEET 3

ABN: 39 062 191 799
P: 61 7 3335 4555
E: solutions@mpnc.au
Level 4, Building 3,
Kings Row Office Park,
42 McDougall Street, Milton, QLD, 4064
MPN CONSULTING
COPYRIGHT: THIS DESIGN AND PLANS ARE NOT TO BE USED OR REPRODUCED WHOLLY OR IN PART WITHOUT WRITTEN PERMISSION OF MPN CONSULTING PTY LIMITED 2023 ©


mpn JOB
10479
DRAWING No.
WR.1.03
REV
D

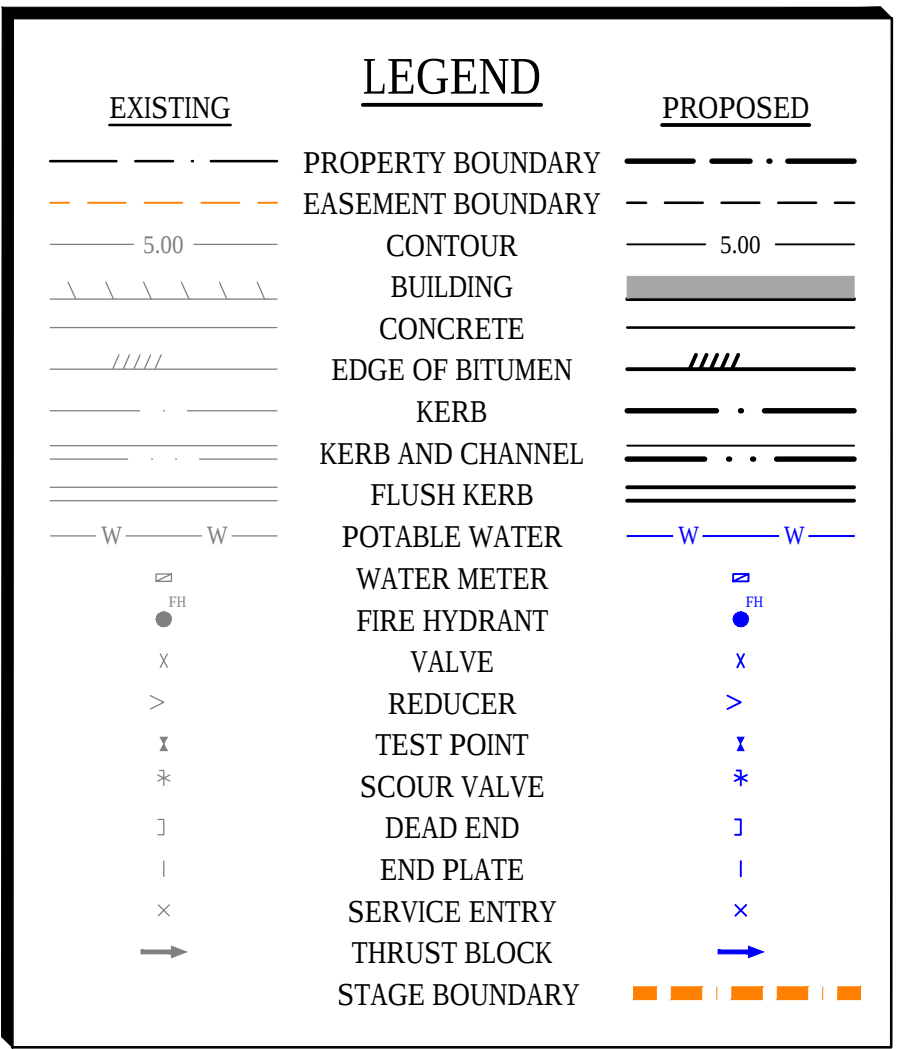

Approval no: DEV2025/1667
Date: 23 October 2025



FOR CONTINUATION REFER DWG NO. WR.1.05

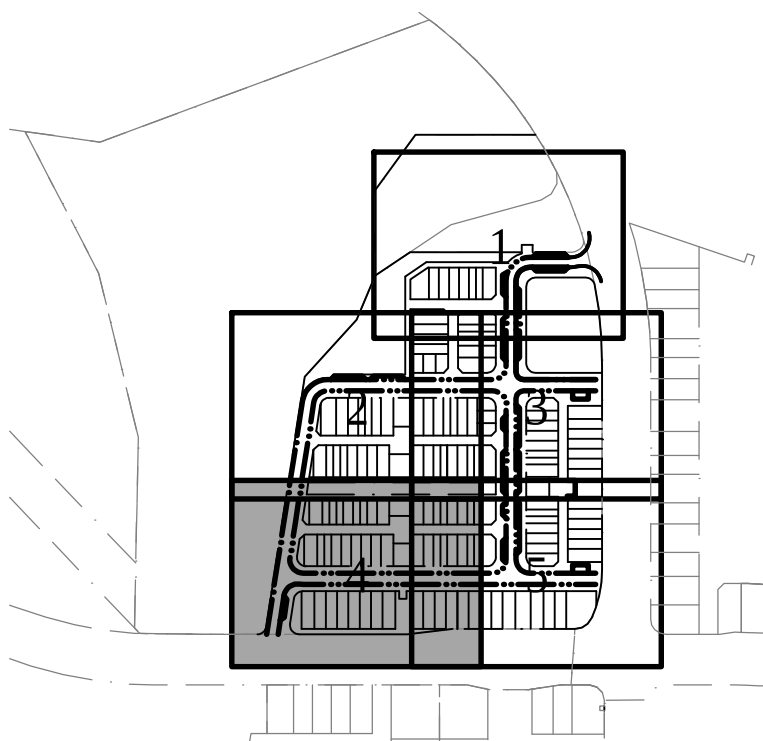

0 5 10 12.5
SCALE 1:250 (A1) 1:500 (A3)

CONSULTANT: MPN CONSULTING PTY LTD
CONTACT:
TELEPHONE: (07) 3335 4555

DATE _____

E	14.10.25	FOR APPROVAL	KC	LS
D	03.09.25	FOR APPROVAL	KC	LS
C	01.09.25	FOR APPROVAL	KC	LS
B	17.07.25	FOR APPROVAL	KC	LS
A	11.07.25	PRELIMINARY ISSUE	RvZ	LS
ISSUE	DATE	AMENDMENT	BY	APP

YARRABILBA PRECINT 4H

YARRABILBA, QLD 4207

SCALES:	AS SHOWN
DESIGN:	KC
DRAWN:	
CHKD:	
APPRD:	
DATE:	

CLIENT:  **Stockland**

WATER LAYOUT PLAN
- SHEET 4



COPYRIGHT: THIS DESIGN AND PLANS ARE NOT TO BE USED OR REPRODUCED WHOLLY OR IN PART WITHOUT WRITTEN PERMISSION OF MPN CONSULTING PTY LIMITED 2023

ABN: 39 062 191 799
P: 61 7 3335 4555
E: solutions@mpnc.au

Level 4, Building 3,
Kings Row Office Park,
Street, Milton, QLD, 4064


mpn JOB
10479

DRAWING No.


WR.1.04

REV
E

FOR CONTINUATION REFER DWG NO. WR.1.03

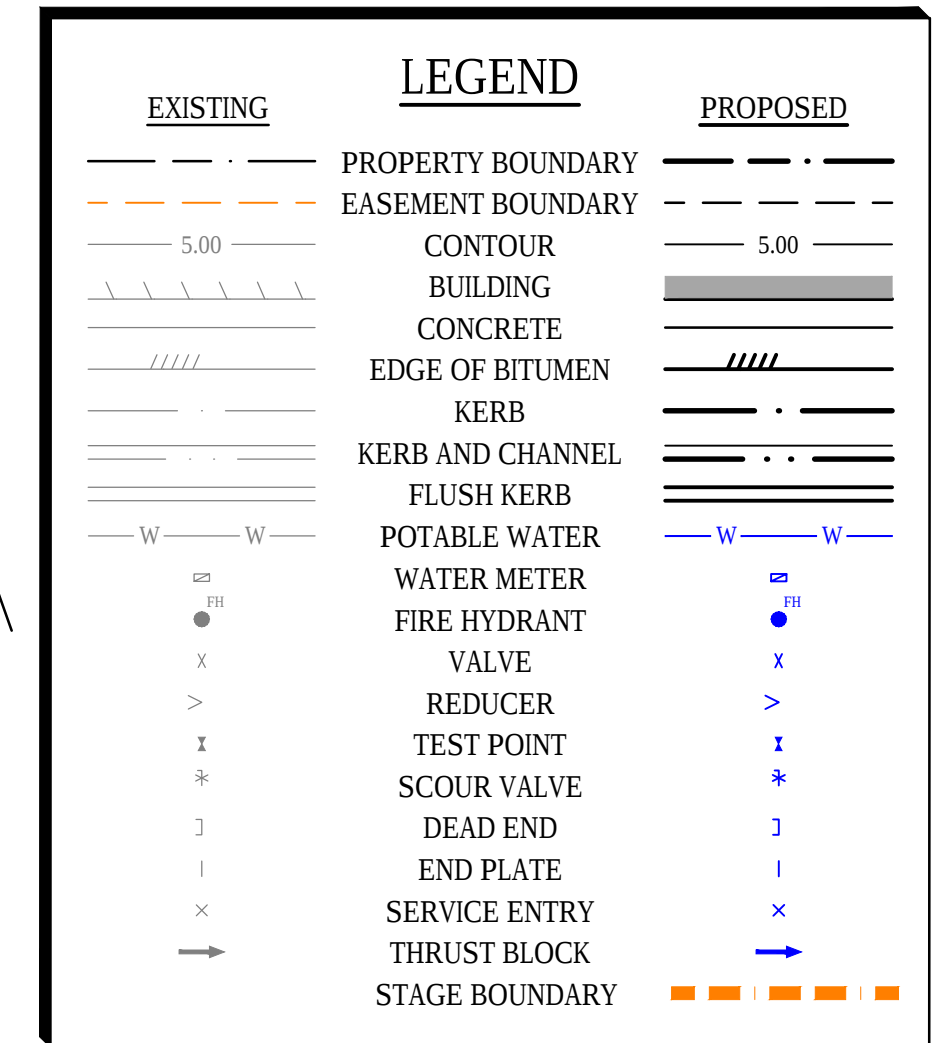

Approval no: DEV2025/1667
Date: 23 October 2025

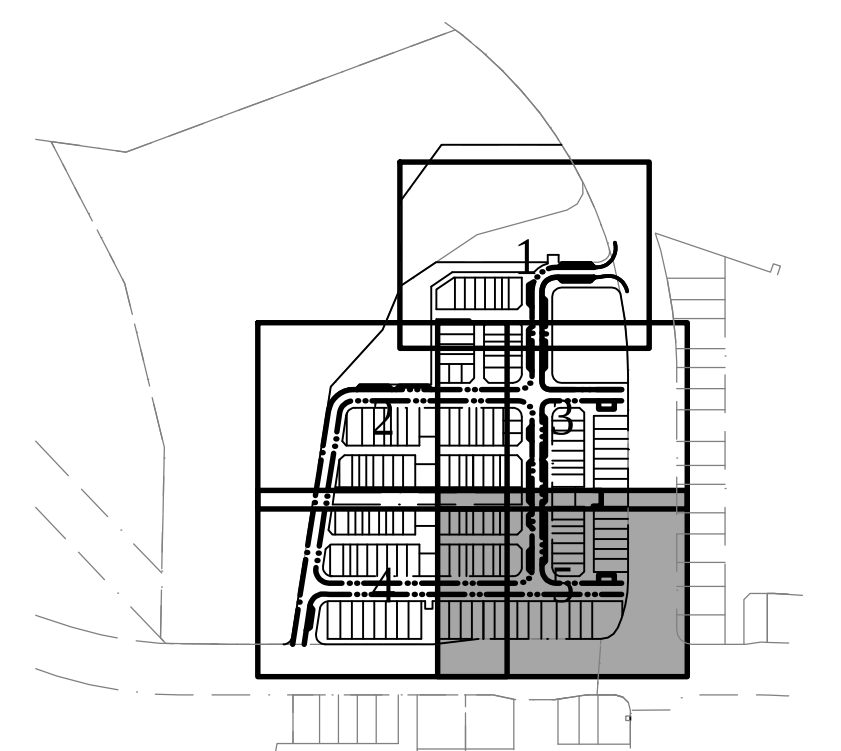

mpn JOB
10479
 DRAWING No.
WR.1.05