


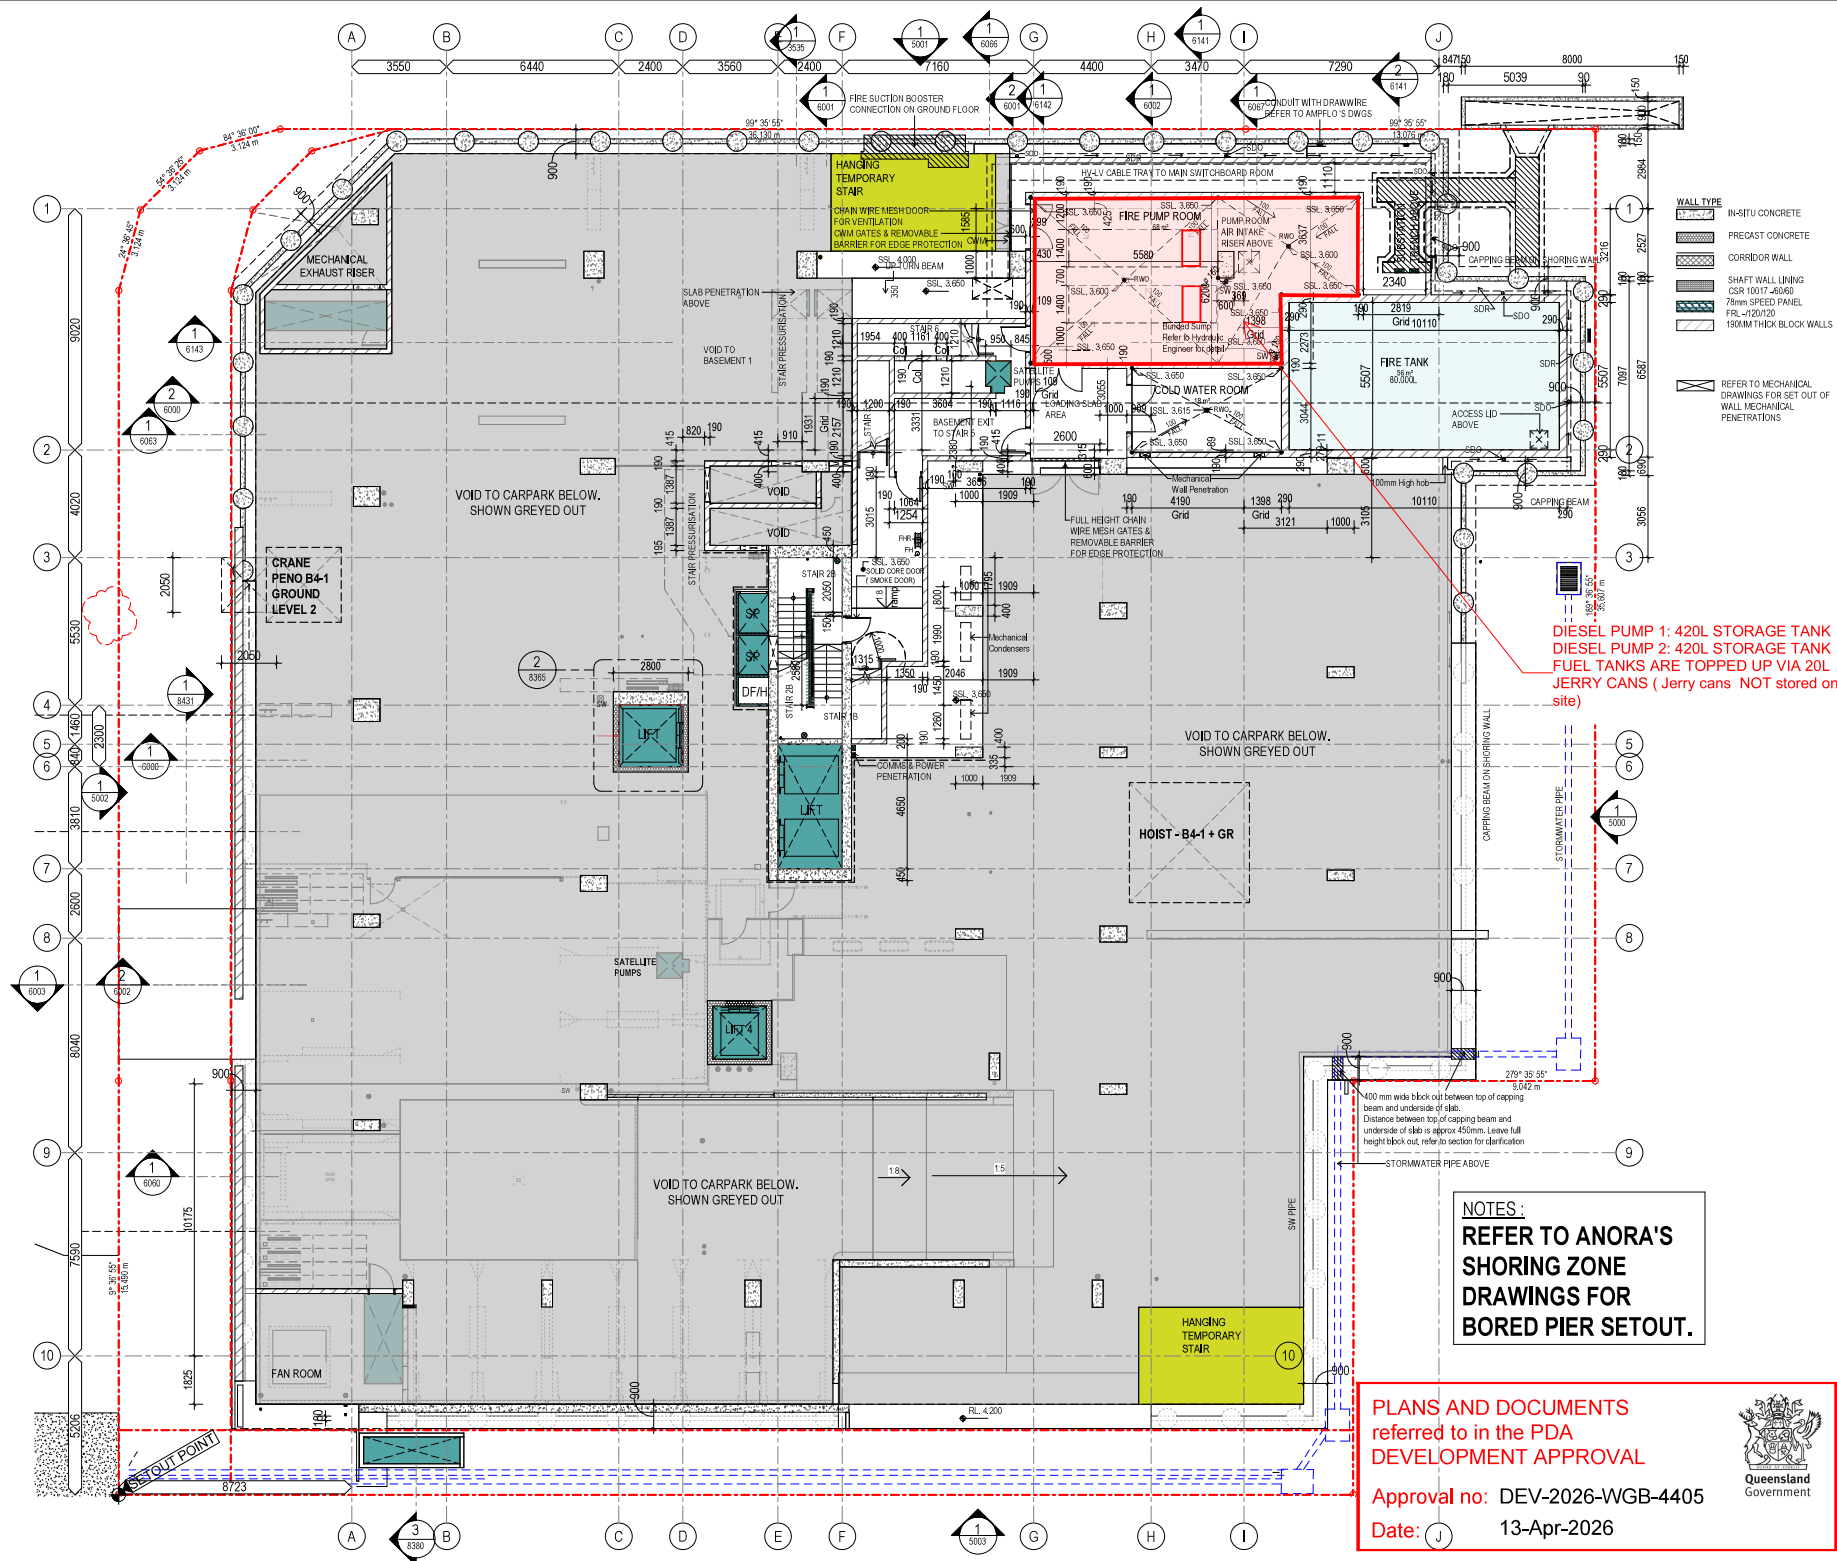

COPYRIGHT			
ALL RIGHTS RESERVED. THE WORKS COPYRIGHT CAN NOT BE REPRODUCED OR COMMUNICATED IN ANY MANNER, INCLUDING ELECTRONIC, MECHANICAL, OR PHOTOGRAPHIC, WITHOUT THE WRITTEN PERMISSION OF THE COPYRIGHT OWNER. ANY UNAUTHORIZED USE OF THIS DOCUMENT IS PROHIBITED. THE USER OF THIS DOCUMENT AGREES TO HOLD THE COPYRIGHT OWNER HARMLESS FROM AND TO INDEMNIFY THE COPYRIGHT OWNER FOR ANY AND ALL DAMAGES, LOSSES, AND EXPENSES, INCLUDING REASONABLE ATTORNEY'S FEES, THAT MAY BE INCURRED BY THE COPYRIGHT OWNER AS A RESULT OF THE USER'S NEGLIGENCE OR WILLFUL MISUSE OF THIS DOCUMENT.			
NOTES: USE REQUIRED DIMENSIONS IN PREFERENCE TO SCALES. CHECK ALL DIMENSIONS ON SITE PRIOR TO FURNISHING OR SETOUT.			
REV	DATE	BY	AMENDMENT
R	17.09.24	TBL	REALIGNED GRID 5, 6, 7, C, D WITH THE INTERVAL OF LIFT SHAFT WALLS
S	30.09.24	TBL	GENERAL AMENDMENTS
T	10.10.24	TBL	GENERAL AMENDMENTS
U	15.10.24	TBL	GENERAL AMENDMENTS
1	06.01.25	TBL	CONSTRUCTION ISSUE
02	14.03.25	TBL	CONSTRUCTION ISSUE
03	17.04.25	TBL	CONSTRUCTION ISSUE
04	09.05.25	JIS	CONSTRUCTION ISSUE
05	14.05.25	CA	CONSTRUCTION ISSUE
06	06.06.25	TBL	CONSTRUCTION ISSUE
07	11.07.25	TBL	CONSTRUCTION ISSUE
08	21.08.25	TBL	CONSTRUCTION ISSUE
09	08.08.25	TBL	CONSTRUCTION ISSUE
010	12.08.25	TBL	CONSTRUCTION ISSUE
011	03.11.25	TBL	CONSTRUCTION ISSUE



PROJECT:
MURCIA


AT:
**9 OVEREND ST & 33
WELLINGTON RD,
EAST BRISBANE**

DRAWING TITLE:
**GENERAL ARRANGEMENTS
BASEMENT 1 MEZZANINE**

PDF NAME: ARC-0999-GA_BAMZ-011
SCALE: 1:100@A1 1:200@A3
DATE: MAR 24
DRAWN: MHC
CHECKED: SZ
JOB No. 1825 Dwg. No. ARC-0999 REV 011

PLANS AND DOCUMENTS
referred to in the PDA
DEVELOPMENT APPROVAL
Approval no: DEV-2026-WGB-4405
Date: 13-Apr-2026



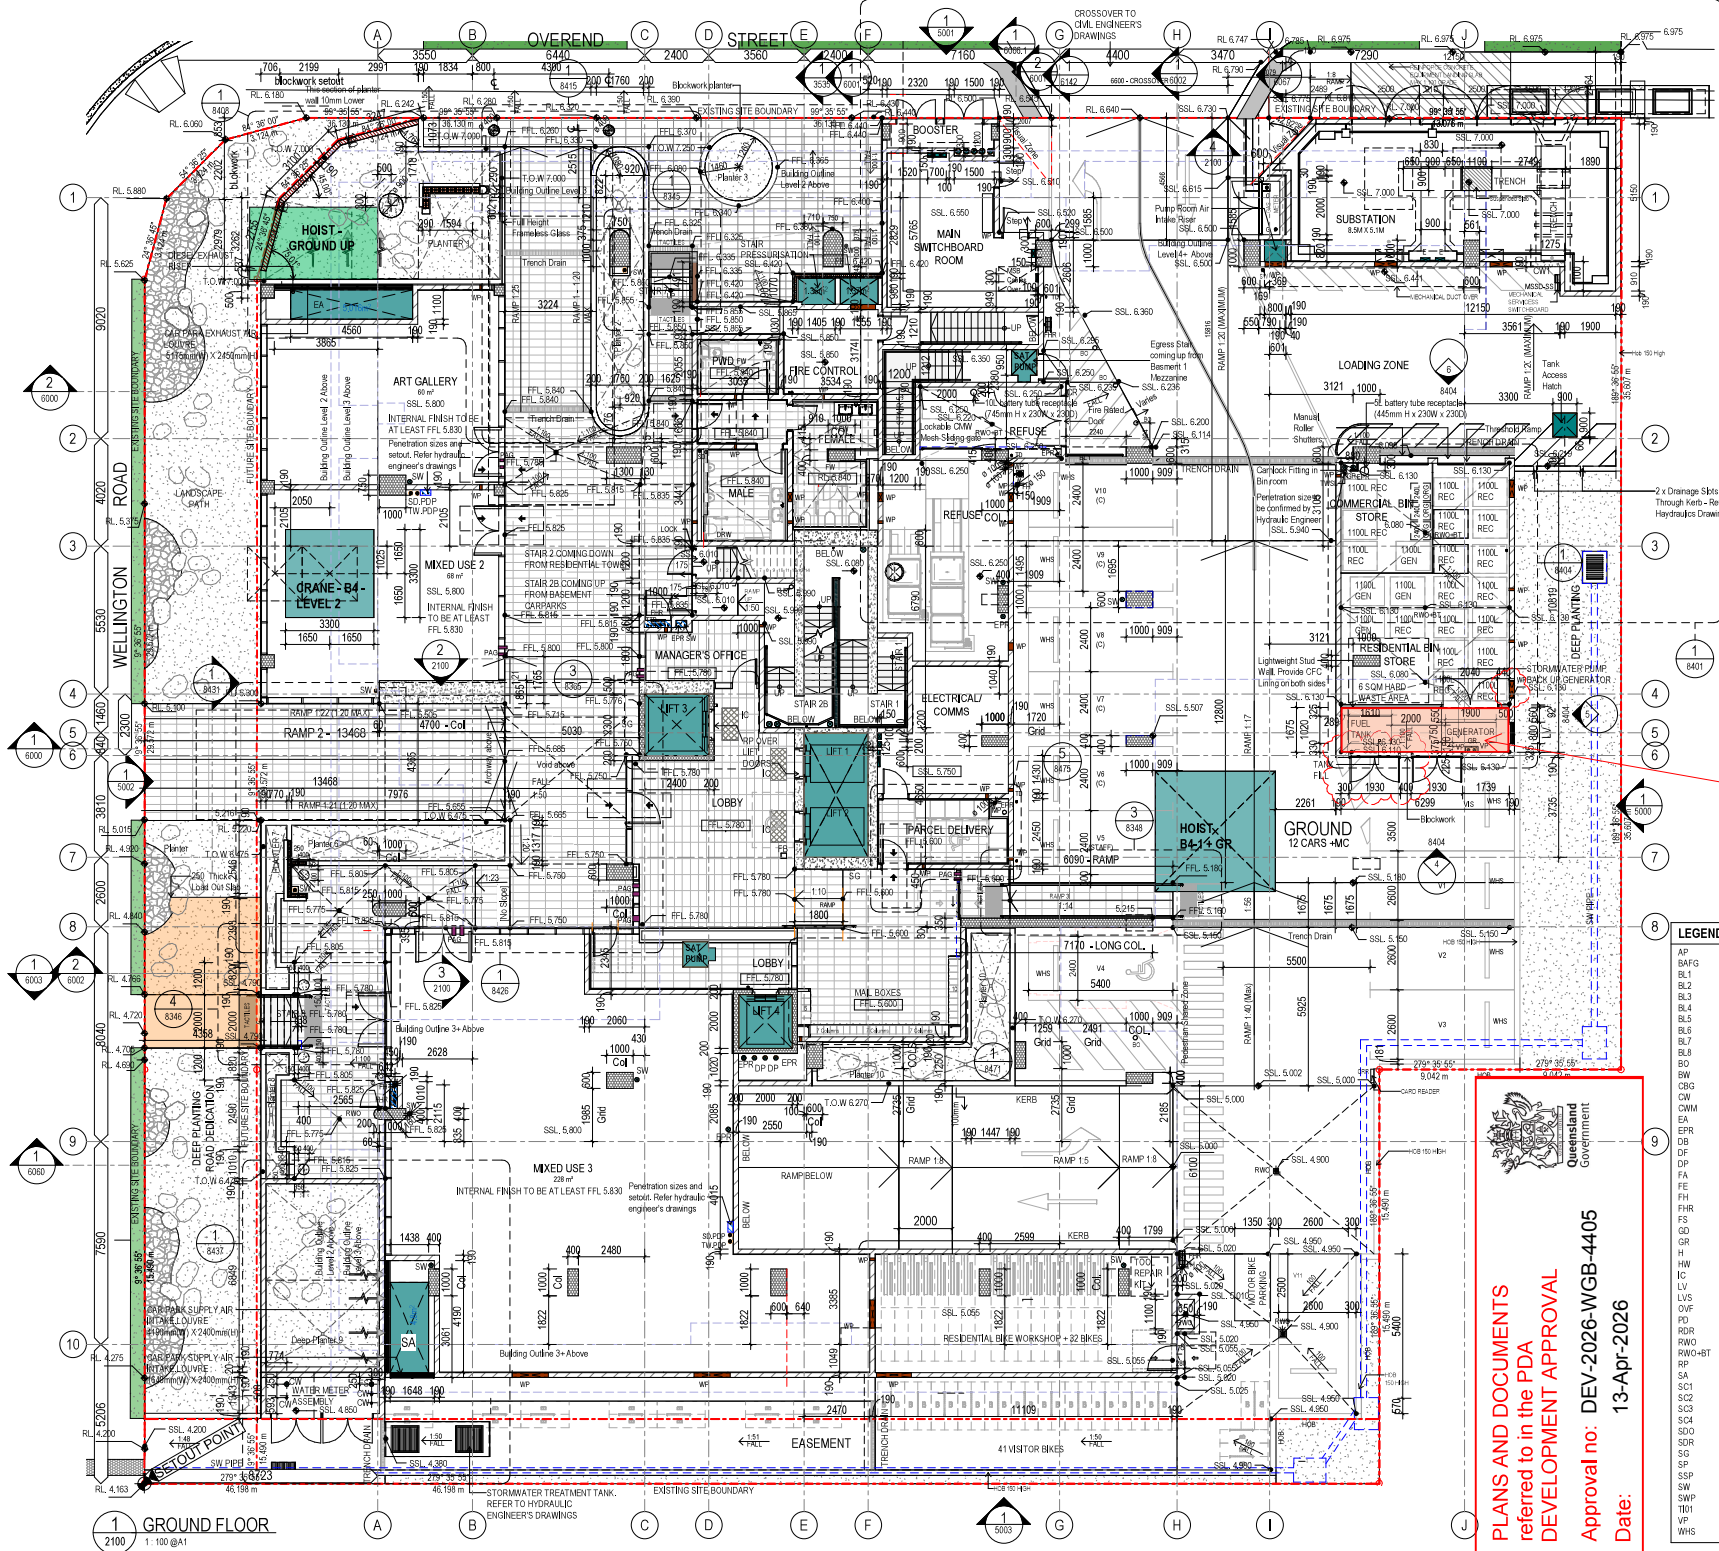

- WALL TYPE**
- IN-SITU CONCRETE
 - PRECAST CONCRETE
 - CORRIDOR WALL
 - SLAB PENETRATION
 - HYDRO-HEAT/DRY FIRE RISER - penetration with fire collars
 - WALL PENETRATION - Refer to Wall Fire and Mechanical drawings for wall penetration subset.
 - Refer Mechanical drawings for subset of penetration above glazing.

COPYRIGHT

ALL RIGHTS RESERVED. THIS WORK IS COPYRIGHT © AND CAN NOT BE REPRODUCED OR COPIED IN ANY FORM OR BY ANY MEANS, GRAPHIC, ELECTRONIC, MECHANICAL, INCLUDING PHOTOCOPYING, RECORDING, OR BY ANY INFORMATION STORAGE AND RETRIEVAL SYSTEM. ANY UNAUTHORIZED USE OF THIS DOCUMENT FOR ANY PURPOSE, WITHOUT THE WRITTEN PERMISSION OF THE ARCHITECT, IS PROHIBITED. THE USER AGREES TO INDEMNIFY AND HOLD THE ARCHITECT HARMLESS FROM AND AGAINST ALL CLAIMS, DAMAGES, LOSSES AND EXPENSES, INCLUDING REASONABLE ATTORNEY'S FEES, ARISING OUT OF OR FROM ANY SUCH UNAUTHORIZED USE.

NOTES

USE RELEVANT DIMENSIONS IN PREFERENCE TO SCALES.
CHECK ALL DIMENSIONS ON DRAWING TO PREVENT CONTRADICTIONS OR SETOUT.

REV	DATE	BY	AMENDMENT
05	09.06.25	JS	CONSTRUCTION ISSUE
06	05.06.25	TBL	CONSTRUCTION ISSUE
07	13.06.25	TBL	CONSTRUCTION ISSUE
08	27.06.25	TBL	CONSTRUCTION ISSUE
09	11.07.25	CA	CONSTRUCTION ISSUE
10	15.07.25	CA	CONSTRUCTION ISSUE
11	25.07.25	TBL	CONSTRUCTION ISSUE
12	01.08.25	TBL	CONSTRUCTION ISSUE
13	06.08.25	TBL	CONSTRUCTION ISSUE, DIMENSION ADDED
14	22.08.25	TBL	CONSTRUCTION ISSUE
15	29.08.25	TBL	CONSTRUCTION ISSUE
16	17.10.25	TBL	CONSTRUCTION ISSUE
17	03.11.25	TBL	CONSTRUCTION ISSUE
18	07.11.25	TBL	CONSTRUCTION ISSUE
19	11.11.25	TBL	CONSTRUCTION ISSUE
20	18.11.25	TBL	CONSTRUCTION ISSUE

K

Level 3b
181 Elizabeth Street Brisbane
PO Box 15485 City East
Brisbane QLD 4002

Telephone: (07) 3003 1160
Email: info@kris-kovalowski.com.au
ABN: 34653392001

Sarazin

BACKUP GENERATOR FOR STORMWATER PUMPS
GENERATOR INTERNAL TANK: 85 L
EXTERNAL FUEL TANK: 1080L

HUTCHINSON BUILDERS
Established 1912

- LEGEND**
- AP ALUMINUM PLANTER
 - BAFG BOX ALUM. GLAZING
 - BL1 BALUSTRADE - THREE RAIL
 - BL2 BALUSTRADE - FIRE STAIRS
 - BL3 BALUSTRADE - METAL (LEVEL 3)
 - BL4 BALUSTRADE - TYPICAL - GLASS
 - BL5 GLASS BALUSTRADE ON PLANTER SIDE
 - BL6 GLASS BALUSTRADE ON PLANTER TOP
 - BL7 HIGH GLASS BALUSTRADE
 - BL8 METAL BALUSTRADE
 - BL9 BOLLARD
 - BW BLOCKWORK
 - CBG COLOUR BACK GLASS
 - CM COLD WATER METER CURBBOARD
 - CWM CHAIN WIRE MESH PARTITION
 - EA CARPARK EXHAUST AIR
 - EPR ELECTRODYNAMIC PRESSURE REGULATOR
 - DB DRY FIRE
 - DF DOWN PIPE
 - DP FIRE ALARM RISER
 - FA FIRE EXTINGUISHER
 - FE FIRE HYDRANT
 - FR FIRE HOSE REEL
 - FS FIRE SERVICES RISER
 - GD GLASS DOOR
 - GR GUARD RAIL
 - H HYDRAULIC
 - HW HOT WATER RISER AND RETURN VALVE
 - HC INSERT CARPET
 - LV 1500X2000 LOUVER ABOVE FIX GLAZING
 - LVS LOUVER SCREEN
 - OVF OVERFLOW (100X400)
 - PO PLANTER ORANGE
 - RDR ROOF DRAINAGE RISER
 - RWO RAIN WATER OUTLET
 - RWO-BT RWO - BASKET TRAP
 - RP RAINY PANEL
 - SA CARPARK SUPPLY AIR
 - SC1 POWDERCOATED AL. SCREEN TYPE 1
 - SC2 POWDERCOATED AL. SCREEN TYPE 2
 - SC3 BREEZEBLOCK SCREEN TYPE 3
 - SC4 POWDERCOATED AL. SCREEN TYPE 4
 - SOD SPOON DRAIN OUTLET
 - SOD SPOON DRAIN
 - SG SIGNAGE
 - SP STAIR PRESSURISATION
 - SSP SERVICES SPINE FOR PLANTER
 - SW STORM WATER
 - SWP STORM WATER GRATED PIT
 - TBI TACTILE INDICATOR
 - VP VENT PIPE
 - WHS WHEEL STOP

PROJECT:
MURCIA

AT:
9 OVEREND ST & 33 WELLINGTON RD, EAST BRISBANE

DRAWING TITLE:
GENERAL ARRANGEMENTS

GROUND FLOOR

PDF NAME: ARC-1000-GA_GRD-020

SCALE: 1:100 @A1 1:200 @A3

DATE: MAR 24

DRAWN: MHC

CHECKED: SZ

JOB No. 1825 **Dwg. No.** ARC-1000 **REV** 020

PLANS AND DOCUMENTS
referred in the PDA
DEVELOPMENT APPROVAL

Approval no: DEV-2026-WGB-4405
Date: 13-Apr-2026