


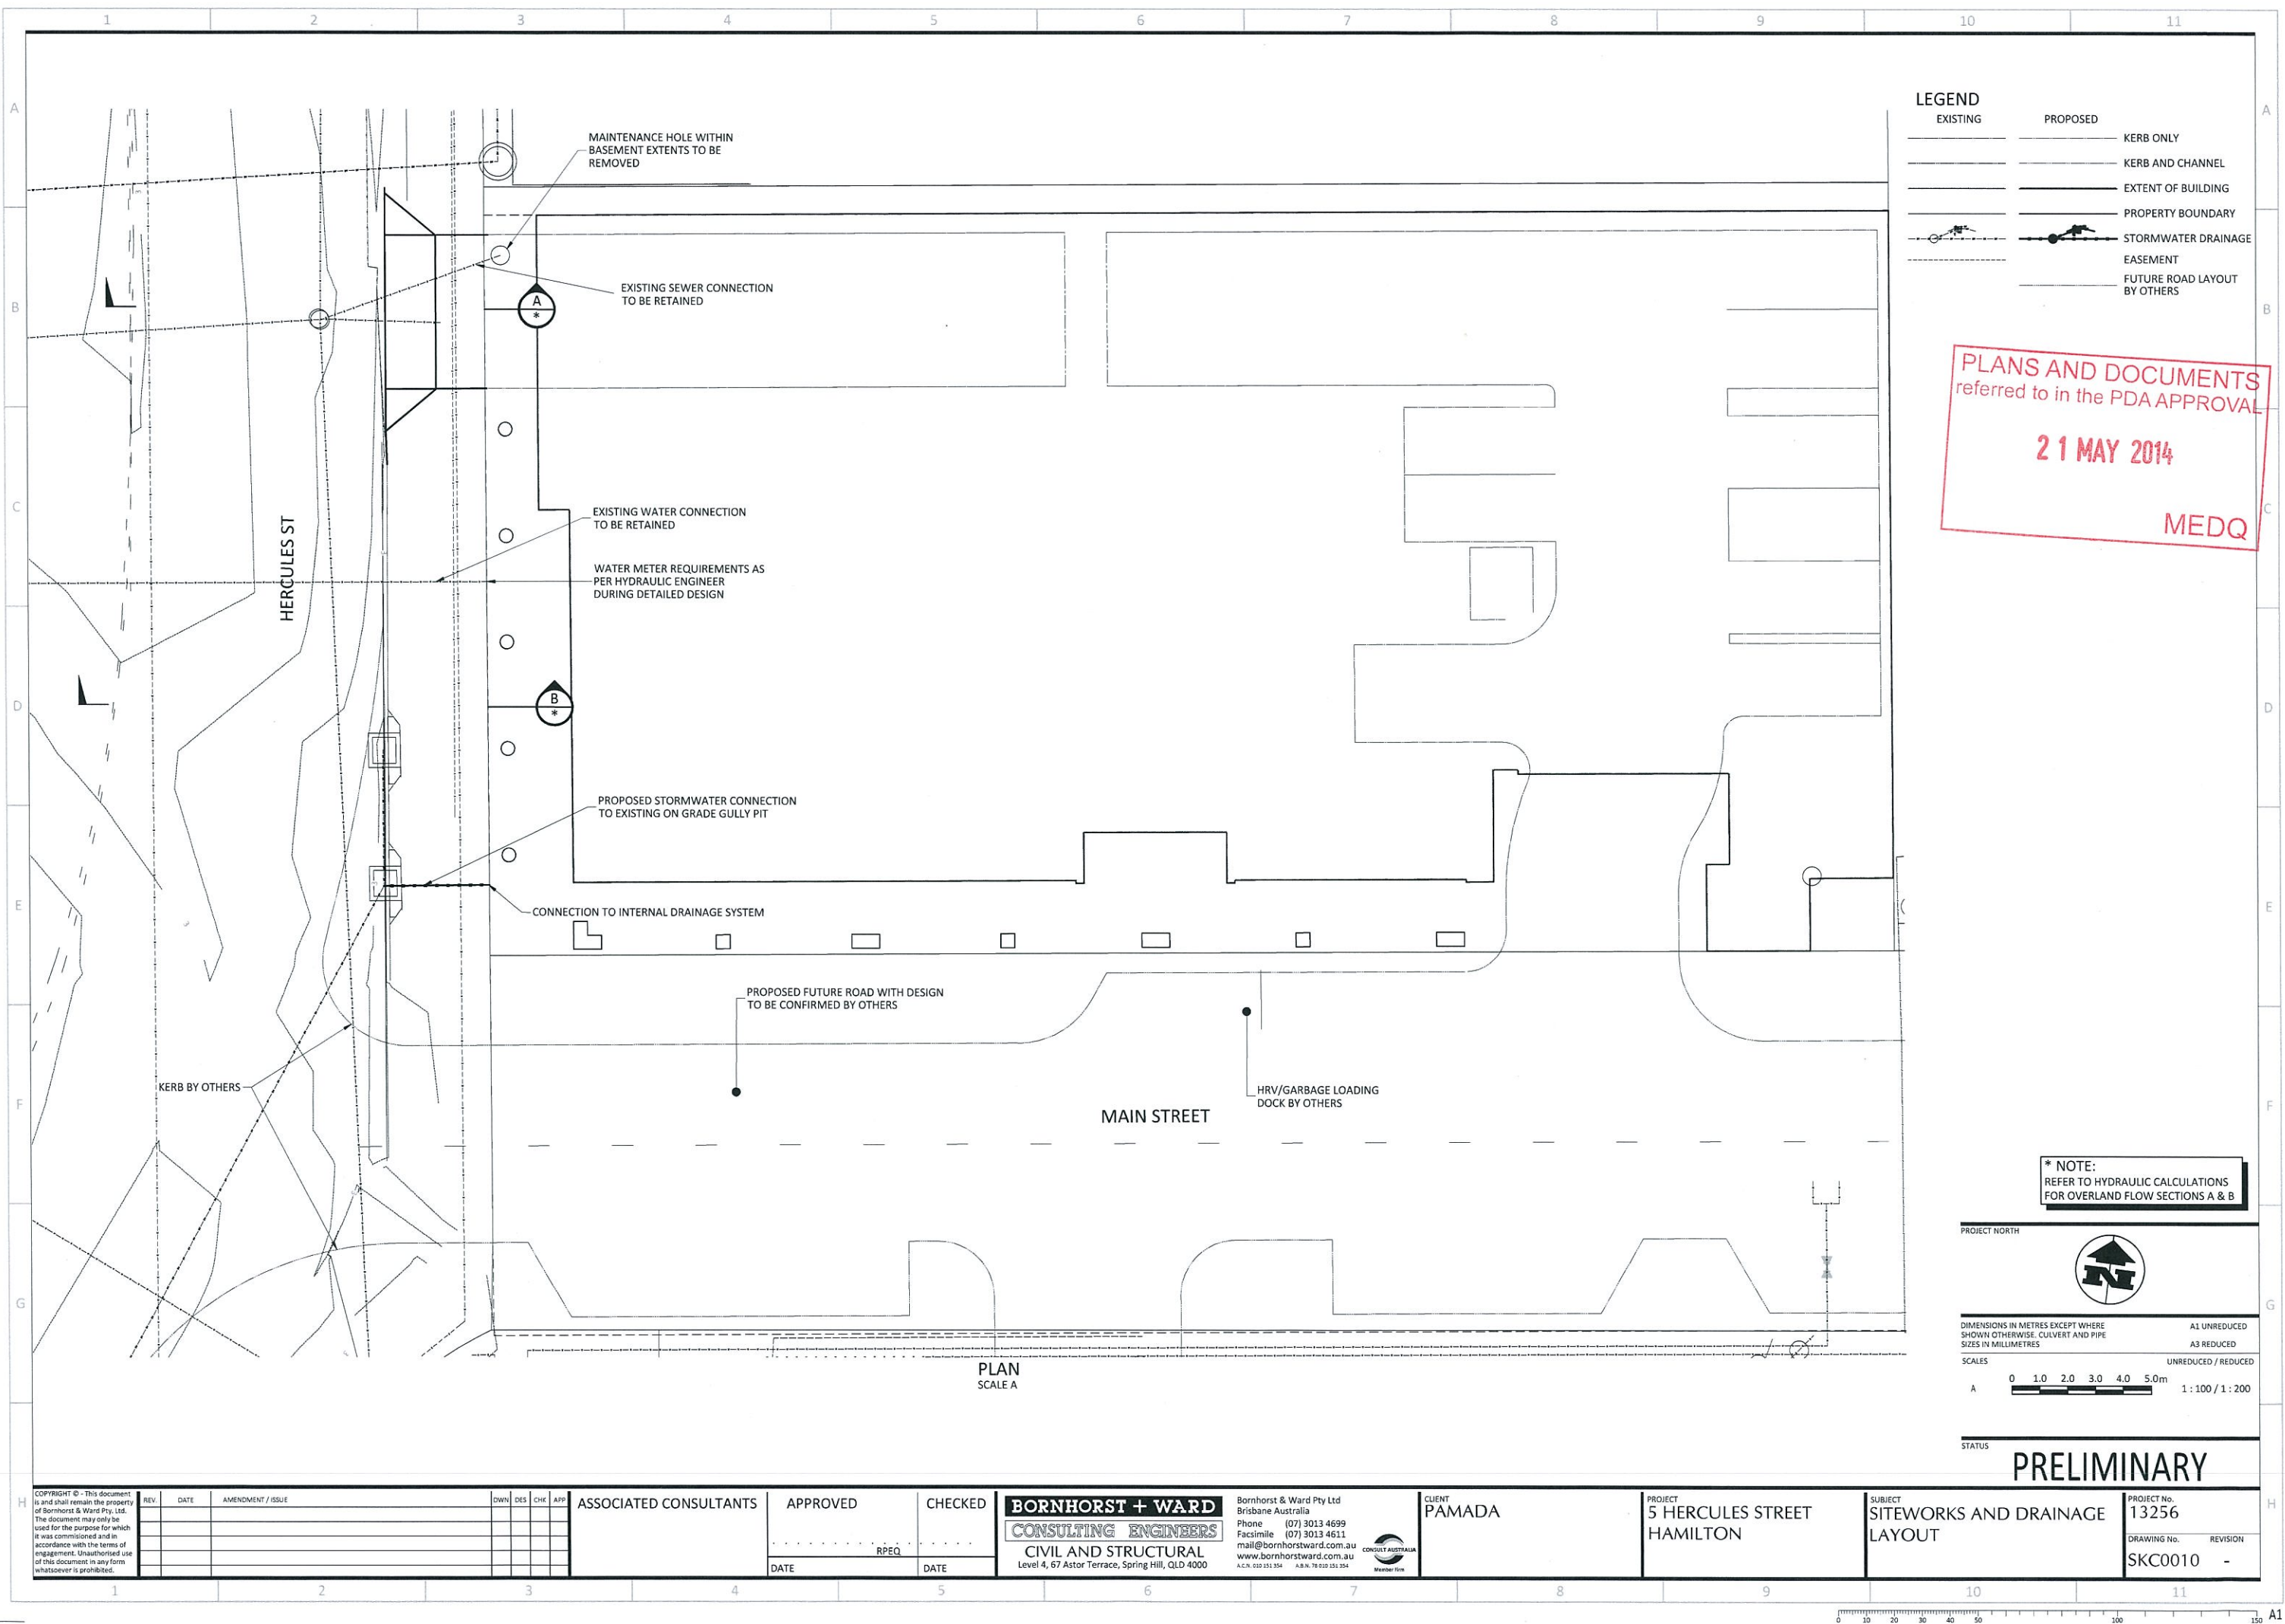

LEGEND	
	EXISTING
	PROPOSED
	KERB ONLY
	KERB AND CHANNEL
	EXTENT OF BUILDING
	PROPERTY BOUNDARY
	STORMWATER DRAINAGE
	EASEMENT
	FUTURE ROAD LAYOUT BY OTHERS

PLANS AND DOCUMENTS
referred to in the PDA APPROVAL

21 MAY 2014

MEDQ

*** NOTE:**
REFER TO HYDRAULIC CALCULATIONS
FOR OVERLAND FLOW SECTIONS A & B



DIMENSIONS IN METRES EXCEPT WHERE SHOWN OTHERWISE CULVERT AND PIPE SIZES IN MILLIMETRES		A1 UNREDUCED A3 REDUCED
SCALES		UNREDUCED / REDUCED
A		1 : 100 / 1 : 200

STATUS **PRELIMINARY**

COPYRIGHT © - This document is and shall remain the property of Borchorst & Ward Pty. Ltd. The document may only be used for the purpose for which it was commissioned and in accordance with the terms of engagement. Unauthorised use of this document in any form whatsoever is prohibited.	REV	DATE	AMENDMENT / ISSUE	DWN	DES	CHK	APP	ASSOCIATED CONSULTANTS	APPROVED	CHECKED	BORNHORST + WARD  CONSULTING ENGINEERS CIVIL AND STRUCTURAL Level 4, 67 Astor Terrace, Spring Hill, QLD 4000 Bornhorst & Ward Pty Ltd Brisbane Australia Phone (07) 3013 4699 Facsimile (07) 3013 4611 mail@bornhorstward.com.au www.bornhorstward.com.au A.C.N. 000 025 354 A.B.N. 78 025 354 354	CLIENT PAMADA	PROJECT 5 HERCULES STREET HAMILTON	SUBJECT SITWORKS AND DRAINAGE LAYOUT	PROJECT No. 13256 DRAWING No. REVISION SKC0010 -