
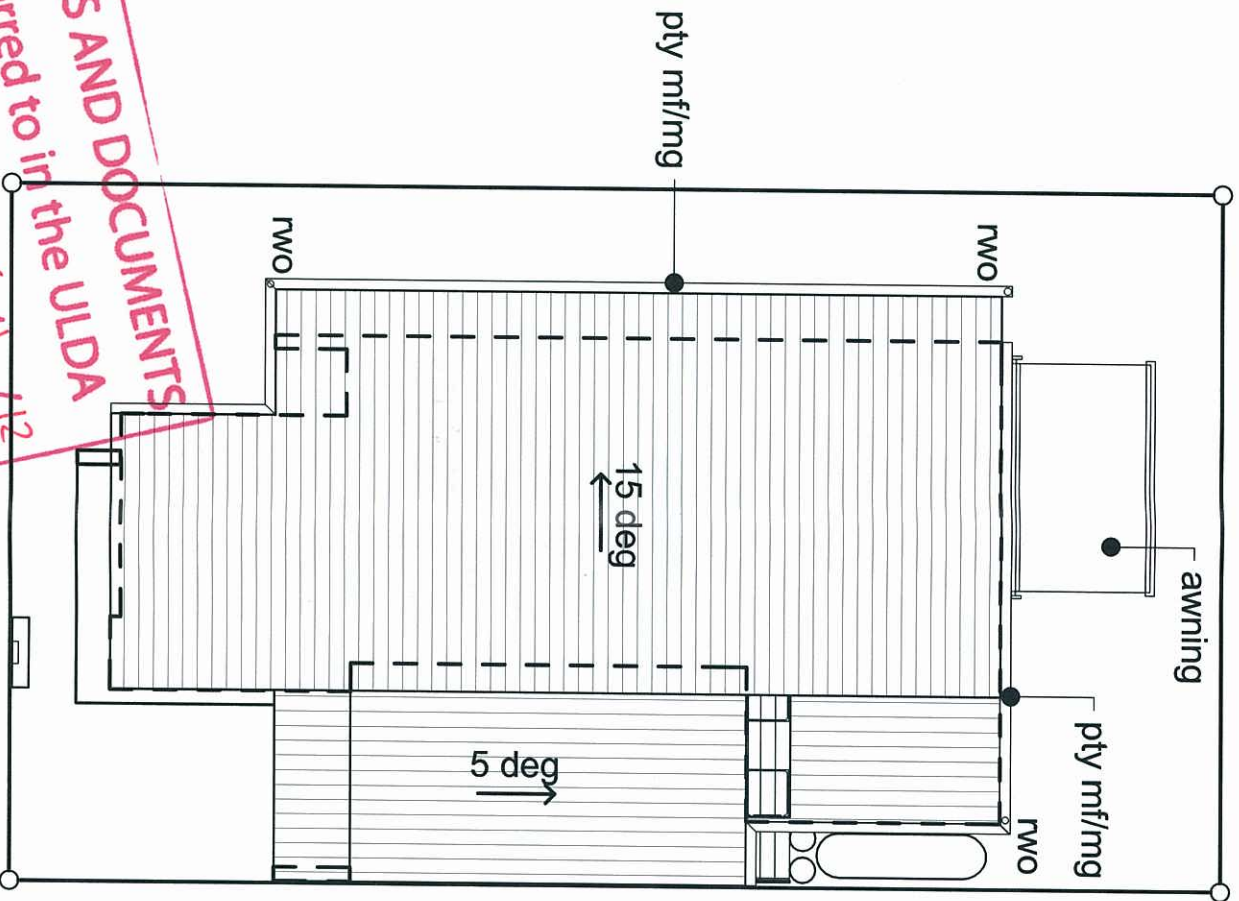


LIGHTING AND COMMUNICATIONS LEGEND	
	Recessed Compact Fluorescent
	Low Voltage Compact Fluorescent
	Compact Fluorescent Pendant
	LED Brick Light
	External Grade Wall mounted Light
	Skylight/Light/Vent/Exhaust Fan
	Manhole
	1 Pole Light Switch
	2 Pole Light Switch
	3 Pole Light Switch
	4 Pole Light Switch
	2 Way Light Switch
	Security Motion Sensor
	Door Bell
	Hard Wired Smoke Detector
	Ceiling Fan and Light

POWER AND APPLIANCE LEGEND	
	Single GPO at 1200mm AFF
	Double GPO
	Weatherproof GPO
	TV Point
	Telephone
	Meter Box
	Main Distrib'n Frame / Circuit Braker
	Direct Wiring
	Submersible Pump
	Position of Future AC Condenser




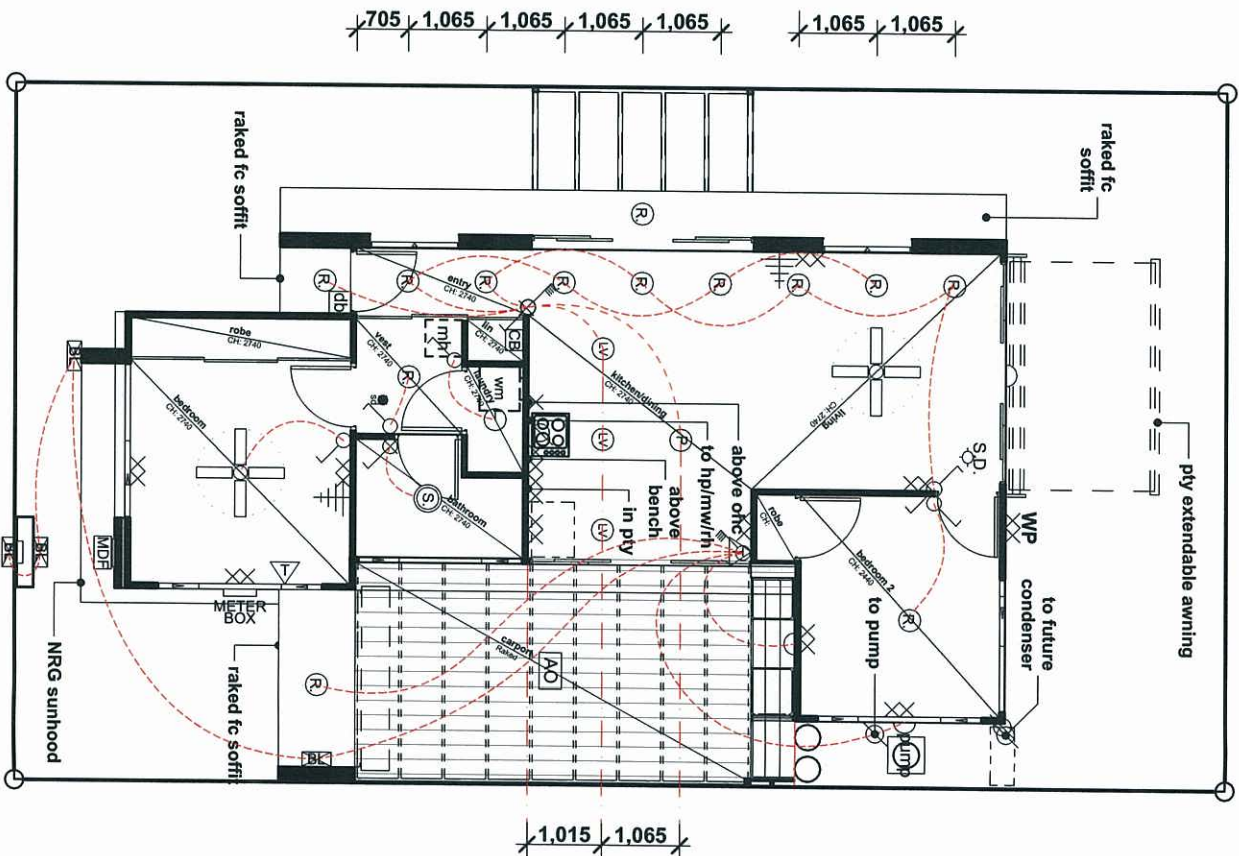


PLANS AND DOCUMENTS
referred to in the ULDA
APPROVAL dated 6 / 1 / 12

AMMENDMENTS			
A	28.12.11	Design Guideline Assessment	ad AD



Client		Status: Contract	Date: 28.12.11
G + D Lawrie Builders		Scale: N/A	Drawn by: tbd/ad
Project Name		Drawing Title:	
Lot 503 Hillclose, Clinton		Roof & Electrical Plans	
Project No:		Drawing No.:	
GDM001-03 A		CD 02.03	

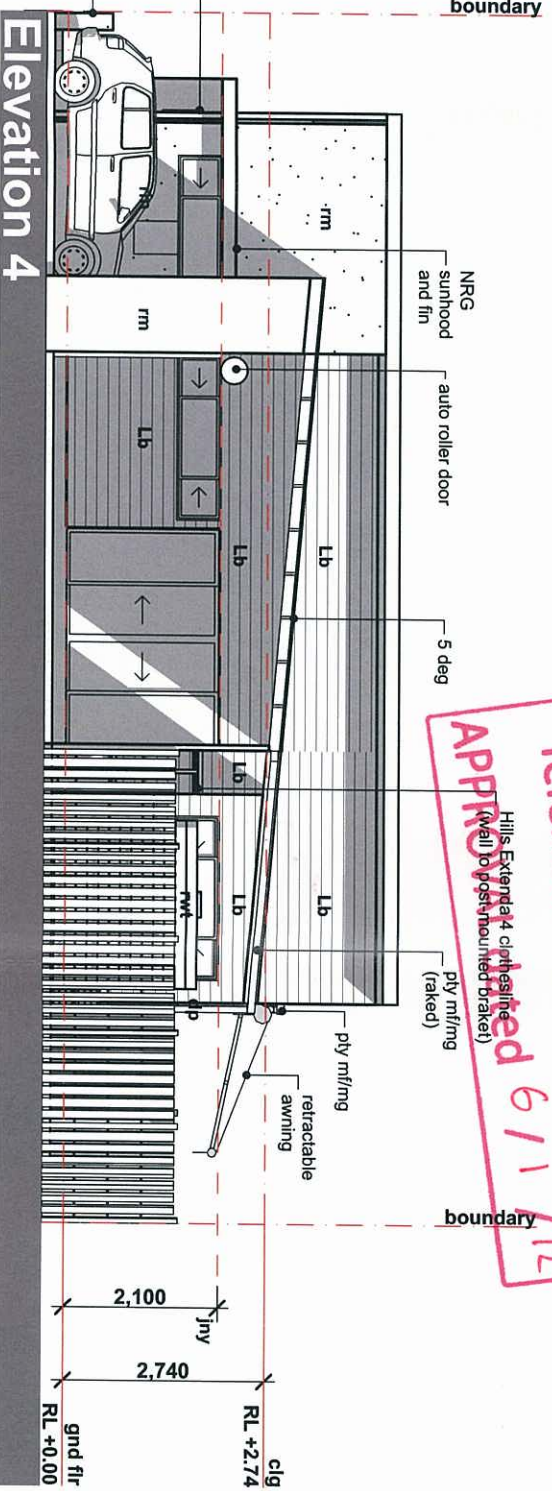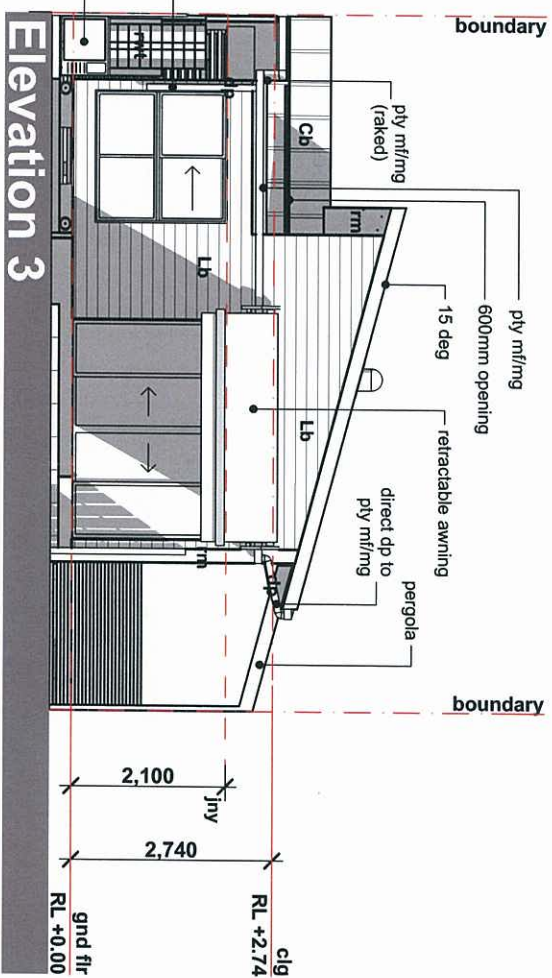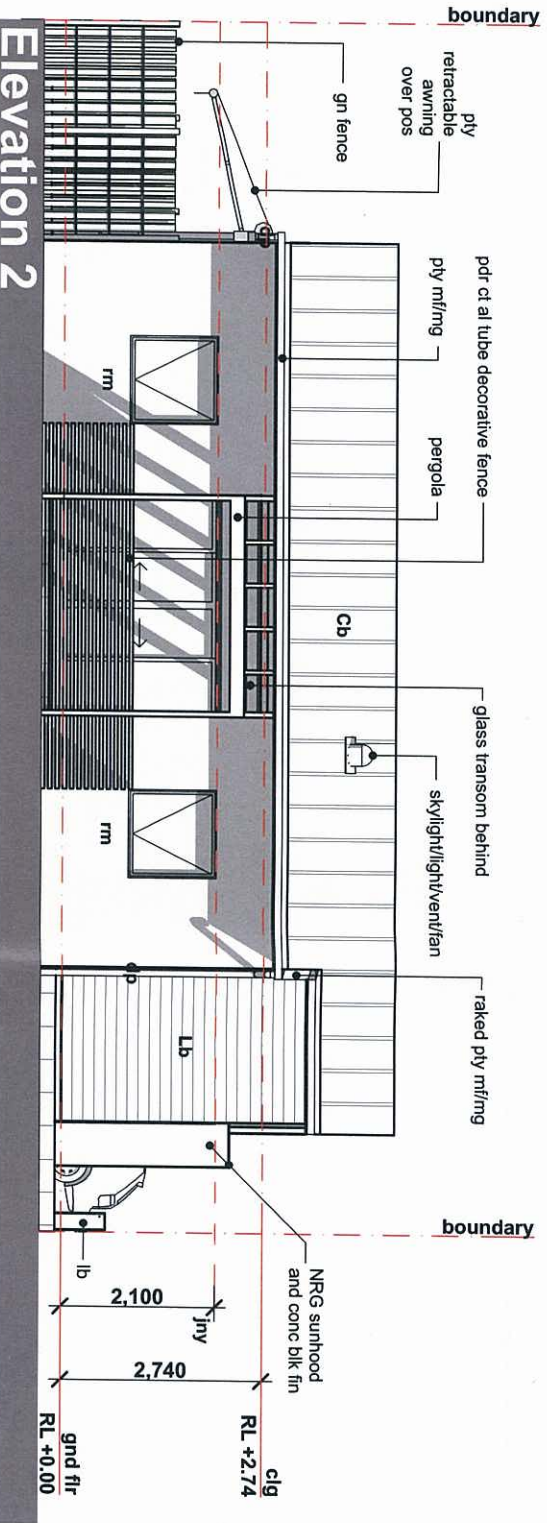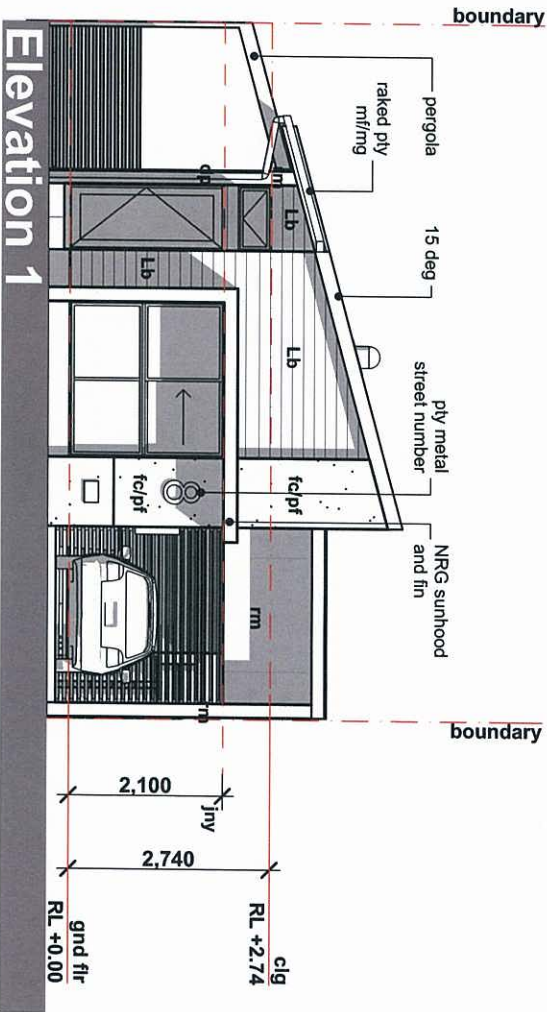

PLANS AND DOCUMENTS
referred to in the ULDA
APPROVED 6/11/12
Hills Extension 4 (previously
referred to as Hillside Drakes)

This plan may not be photocopied without the express written authority of the author. The author is not responsible for any errors or omissions in the drawings. The drawings remain the property of the author and are not to be used for any other purpose without the express written permission of the author.

Contract and other data shown on the drawing have been derived from a combination of site-consultant drawings obtained in digital format. This drawing was prepared for the purpose and exclusive use of the ULDA to represent the proposed development. It is not to be used for any other purpose. The author is not responsible for any errors or omissions in the drawings. The drawings remain the property of the author and are not to be used for any other purpose without the express written permission of the author.



The author is responsible for the site verification of all dimensions. Figure dimensions are approximate and scaled values.

DO NOT SCALE DRAWINGS.

AMENDMENTS			
A	28.12.11	Design Guideline Assessment	ad AD



Client		Status: Contract	Date: 28.12.11
G + D Lawrie Builders		Scale: N/A	Drawn by: tld
Project Name		Drawing Title: Elevations	Drawing No.: GDM001-03 A CD 03.01
Lot 503 Hillclose, Clinton		Project No: GDM001-03 A	

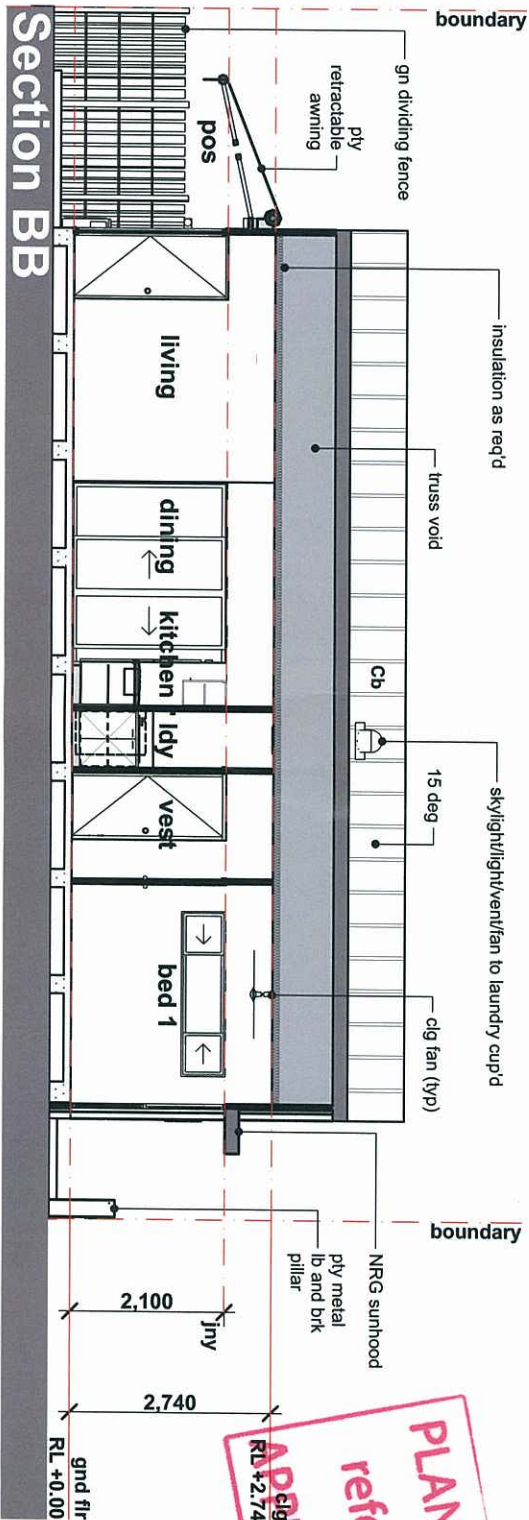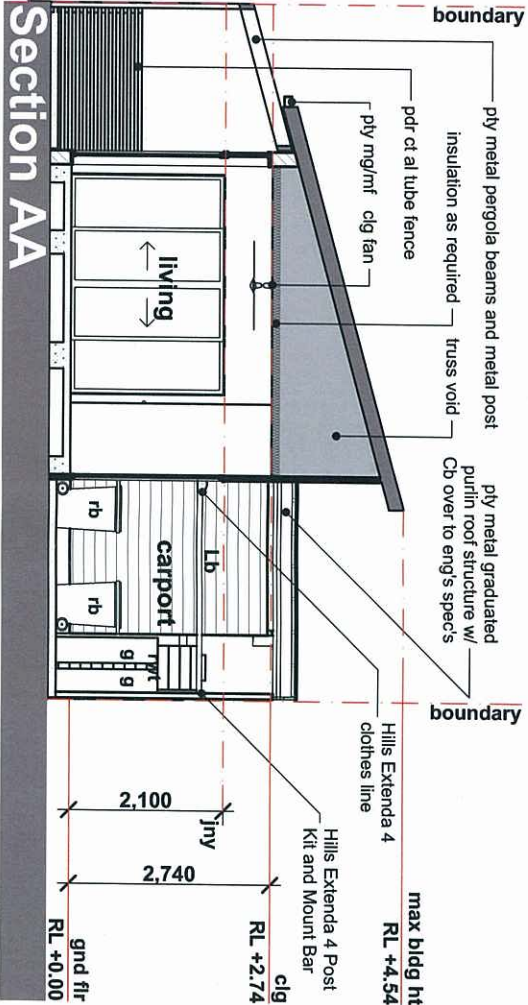

This plan may not be photocopied without the express written authority of the Urban Land Development Authority (ULDA). Development of the copyright of these drawings remains in the ownership and control of the ULDA, unless expressly written permission has been granted otherwise. Contractors and other third parties shown on this drawing have been advised that a construction of this drawing is not to be used for any other purpose without the express written permission of the ULDA. The Drawing was prepared for the purpose and exclusive use of the ULDA to assess the proposed development and does not constitute a contract or any other legal document. It is not to be used for construction or any other use without the express written permission of the ULDA. DESIGNED BY: Lot 503 Hillclose, Clinton The Builder is responsible for the site verification of all dimensions. It was not intended. Figure Dimensions are in meters unless otherwise stated. DO NOT SCALE DRAWINGS			
AMENDMENTS			
A	28.12.11	Design Guideline Assessm't	ad AD
		Client G + D Lawrie Builders	
Project Name Lot 503 Hillclose, Clinton		Status: Contract Scale: N/A	
Project No.: GDM001-03 A		Date: 28.12.11	
Drawing Title: Sections		Drawn by: tb/ad	
Drawing No.: CD 04.01			