


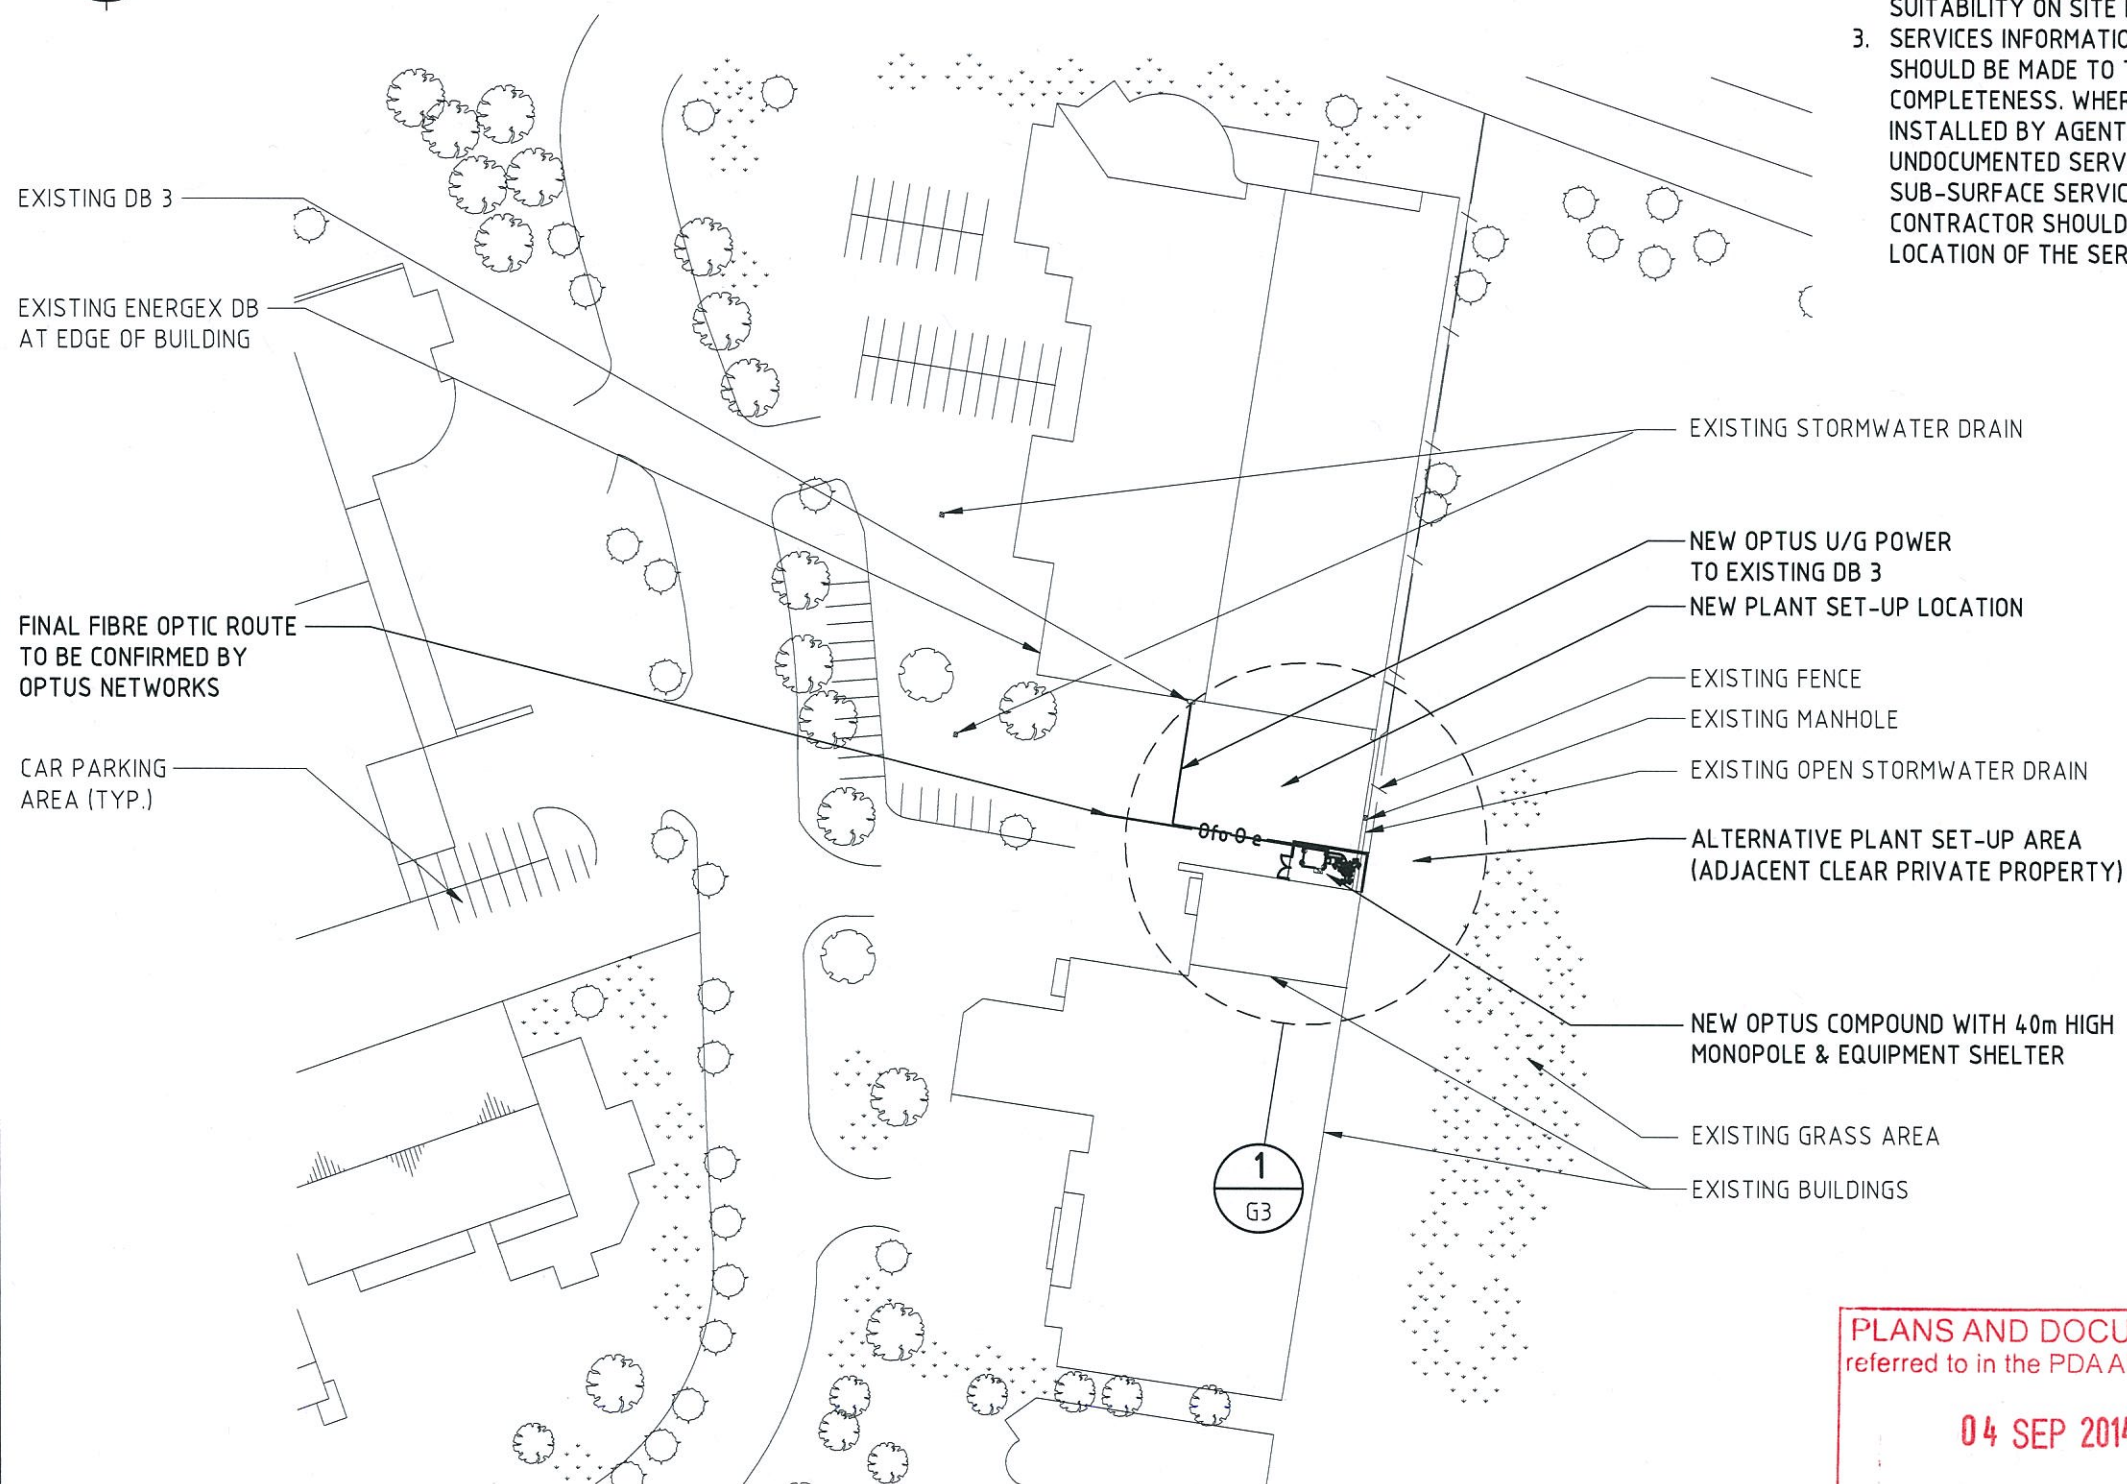

OVERALL SITE PLAN
SCALE 1:1000

NOTES:

1. ALL INFORMATION TO BE CHECKED ON SITE PRIOR TO FABRICATION AND CONSTRUCTION.
2. PROPOSED EWP SET-UP/PARKING LOCATION, CONSTRUCTION CONTRACTOR TO CONFIRM SUITABILITY ON SITE PRIOR TO WORK COMMENCING.
3. SERVICES INFORMATION CONTAINED ON THIS DRAWING IS INDICATIVE ONLY AND REFERENCE SHOULD BE MADE TO THE AUTHORITIES DRAWINGS TO CONFIRM ACCURACY AND COMPLETENESS. WHERE INFORMATION IS AVAILABLE, THE SUB-SURFACE SERVICES INSTALLED BY AGENTS OTHER THAN AUTHORITIES HAVE BEEN SHOWN, BUT ADDITIONAL UNDOCUMENTED SERVICES MAY BE PRESENT. SHOULD THE CONTRACTOR BELIEVE THAT SUB-SURFACE SERVICES ARE AT RISK OF DAMAGE DURING CONSTRUCTION, THE CONTRACTOR SHOULD NOTIFY THE RELEVANT AUTHORITIES AND ESTABLISH THE EXACT LOCATION OF THE SERVICES.

LEGEND

---	---	PROPERTY BOUNDARY
— 0 e — 0 e —		OPTUS U/G POWER
— 0 fo — 0 fo —		OPTUS FIBRE ROUTE
— / — / —		OPTUS FENCE

VISIONSTREAM - OPTUS WIRELESS PROJECT				
CHECK/VERIFICATION PRINT STAMP				
PERSONNEL	INITIAL CHECK ☒		FINAL CHECK ☐	
	INITIALS	DATE	INITIALS	DATE
CAD DESIGNER	ON	11.07.14		
PROJECT ENGINEER				
STRUCTURAL ENGINEER				
ELECTRICAL ENGINEER				
VERIFICATION BY OTHER DISCIPLINES				
1.				
2.				
3.				
VERIFIER				
DESIGN MANAGER				
ALTERATIONS & COMMENTS TO BE SHOWN IN RED COMPLETED ALTERATIONS TO BE HIGHLIGHTED IN YELLOW CORRECT/ACTIONED ITEMS TO BE HIGHLIGHTED IN GREEN				

PLANS AND DOCUMENTS
referred to in the PDA APPROVAL

04 SEP 2014

MEDQ

Rev	Date	Revision Details	Consultant	CAD	Designer	Verifier	Approver
B	11.07.14	ISSUED FOR CONSTRUCTION (e-JV)	VPL	ON	JD		
A	04.04.12	ISSUED NOT FOR CONSTRUCTION	F+	VR	HCJ	ES	JYW

visionstream
CREATING TELECOMMUNICATIONS
VISIONSTREAM PTY LTD
236 East Boundary Road
2 North Drive Virginia Park Bentleigh East VIC 3165
Tel: (03) 9258 5700 Fax: (03) 9563 7481
www.visionstream.com.au

Client:



Project:

**MOBILE NETWORK
AUSTRALIA**
SITE No:- B8114
EAGLE FARM INDUSTRIAL
6-18 EAGLEVIEW PLACE

Drawing Title:

OVERALL SITE PLAN

Drawing Status:

FOR CONSTRUCTION

Drawing No.

B8114-G2

Revision

B



NEW OPTUS 600 WIDE CABLE
LADDER WITH SUPPORT POST

NEW OPTUS PIT. REFER STANDARD
DRG OSD-570 FOR DETAILS.

NEW OPTUS (CRANKED) COMPOUND
SECURITY FENCE WITH 3.0m WIDE DOUBLE
ACCESS GATES. REFER STANDARD DRG
OSD-140 FOR DETAILS

NEW OPTUS LEASE AREA
(10.4m x 5.4m)

NEW OPTUS U/G POWER TO
EXISTING DB3 MOUNTED TO
EXISTING TILT UP PANEL WALL

NEW OPTUS FIBRE ROUTE

NEW OPTUS PHASE 8 EQUIPMENT
SHELTER (3.0m x 2.5m) ON CONCRETE
PLINTHS. REFER STANDARD DRG
OSD-210 FOR DETAILS

EXISTING CONCRETE
TILT-PANEL BUILDING

OPTUS 1200x600x300mm
HIGH CONCRETE STEP WITH
SL81 MESH TOP (50 COVER).
REFER STANDARD DRG
OSD-220 FOR DETAILS

NEW OPTUS 40m HIGH MONOPOLE
WITH CIRCULAR HEADFRAME AND
OUTRIGGERS. REFER TO DRG. ???
FOR DETAILS

MGA ZONE 56
E 508 463
N 6 965 192
AT € MONOPOLE

DETAIL 1
SCALE 1:100 G2

NOTES:

1. REFER TO DRAWING B8114-A1 FOR ANTENNA SYSTEM CONFIGURATION.
2. NEW RRUs (28 OFF) TO BE INSTALLED ON NEW CIRCULAR HEADFRAME AND RRU CLUSTER MOUNT.
3. NEW COMBINERS (6 OFF), DIPLEXERS (3 OFF) AND MHA's (9 OFF) TO BE MOUNTED ON ANTENNA MOUNTING POLES BELOW AND BEHIND THE ANTENNAS.
4. NEW (20 OFF) AVA5-50 FEEDER CABLES TO BE RUN INTERNALLY THROUGH THE MONOPOLE AND NEW (6-OFF) FIBRE TRUNK CABLES TO BE RUN THROUGH NEW 300mm WIDE EXTERNAL CABLE LADDER.
3. ALL INFORMATION TO BE CHECKED ON SITE PRIOR TO FABRICATION AND CONSTRUCTION.

LEGEND

---	PROPERTY BOUNDARY
0 e 0 e	OPTUS U/G POWER
0 fo 0 fo	OPTUS FIBRE ROUTE
/ /	OPTUS FENCE
	EXISTING
	NEW OR REPLACE

EXISTING OPEN
STORMWATER DRAIN
LOCATION TO BE
CONFIRMED

EXISTING FENCE

NEW "TQB-D609017/Q172717DER-60F"
PANEL ANTENNAS (6-OFF) MOUNTED ON
CIRCULAR HEADFRAME & OUTRIGGERS

NEW RRUs (28 OFF) MOUNTED ON CIRCULAR
HEADFRAME AND NEW RRU CLUSTER MOUNT.
REFER TO DRG. VPL-STD-S152 AND
B8114-S1 FOR DETAILS

PLANS AND DOCUMENTS
referred to in the PDA APPROVAL

04 SEP 2014

MEDQ

VISIONSTREAM - OPTUS WIRELESS PROJECT				
CHECK/VERIFICATION PRINT STAMP				
PERSONNEL	INITIAL CHECK ☒		FINAL CHECK ☐	
	INITIALS	DATE	INITIALS	DATE
CAD DESIGNER	ON	11.07.14		
PROJECT ENGINEER				
STRUCTURAL ENGINEER				
ELECTRICAL ENGINEER				
VERIFICATION BY OTHER DISCIPLINES				
1.				
2.				
3.				
VERIFIER				
DESIGN MANAGER				
ALTERATIONS & COMMENTS TO BE SHOWN IN RED COMPLETED ALTERATIONS TO BE HIGHLIGHTED IN YELLOW CORRECT/ACTIONED ITEMS TO BE HIGHLIGHTED IN GREEN				

Rev	Date	Revision Details	Consultant	CAD	Designer	Verifier	Approver
B	11.07.14	ISSUED FOR CONSTRUCTION (e-JV)	VPL	ON	JD		
A	04.04.12	ISSUED FOR CONSTRUCTION	F+	VR	HJC	ES	JYW

visionstream
CREATING TELECOMMUNICATIONS
VISIONSTREAM PTY LTD
236 East Boundary Road
2 North Drive Virginia Park Bentleigh East VIC 3165
Tel: (03) 9258 5700 Fax: (03) 9563 7481
www.visionstream.com.au

Client:

OPTUS yes

Project:

MOBILE NETWORK
AUSTRALIA
SITE No:- B8114
EAGLE FARM INDUSTRIAL
6-18 EAGLEVIEW PLACE

Drawing Title:

SITE LAYOUT AND SETOUT PLAN

Drawing Status:

FOR CONSTRUCTION

Drawing No.

B8114-G3

Revision

B

Rev	Date	Revision Details	Consultant	CAD	Designer	Verifier	Approver
B	11.07.14	ISSUED FOR CONSTRUCTION (e-JV)	VPL	ON	JD		
A	04.04.12	ISSUED FOR CONSTRUCTION	F+	VR	HCJ	ES	JYW



visionstream

CREATING TELECOMMUNICATIONS

VISIONSTREAM PTY LTD

236 East Boundary Road

2 North Drive Virginia Park Bentleigh East VIC 3165

Tel- (03) 9268 5700 Fax- (03) 9563 7481

www.visionstream.com.au

Client:



Project:

MOBILE NETWORK AUSTRALIA

SITE No:- B8114

EAGLE FARM INDUSTRIAL

6-18 EAGLEVIEW PLACE

Drawing Title:

SITE ELEVATION

FOR CONSTRUCTION

Drawing Status:

Drawing No.

Revision

B8114-G4

B

