

PLANS AND DOCUMENTS
referred to in the ULDA
APPROVAL dated 12/10/2012

DO NOT SCALE THIS DRAWING
IF IN DOUBT - ASK!



KEY PLAN



REVISIONS

No	Description	Date	By
A	COUNCIL APPROVAL	15/11/10	GBG
B	COUNCIL APPROVAL	28/01/11	GBG
C	COUNCIL APPROVAL	25/02/11	GBG
D	FOR APPROVAL	31/10/11	TMR

Client



Project

Yarrabilba
A COMPLETE TOWN, A BETTER OUTCOME
YARRABILBA
RESIDENTIAL PRECINCT




LEVEL 2 - 71 GREY STREET
SOUTH BRISBANE
QUEENSLAND 4101
PHONE 07 3017 1900
FAX 07 3017 1911
EMAIL kng@knpl.com.au
ABN 35 112 053 611

Approved Director - RPEQ 1988


Drawing Title
**CONCEPTUAL DRAINAGE PLAN
SHEET 1 OF 5**

Drawn TMR	Designed RC	Checked GBG	Date NOV 10
Scale 1 : 2000	PW No A1000PDU0804	Sheet 31 of 47	Revision D
A3	10-175-D1		

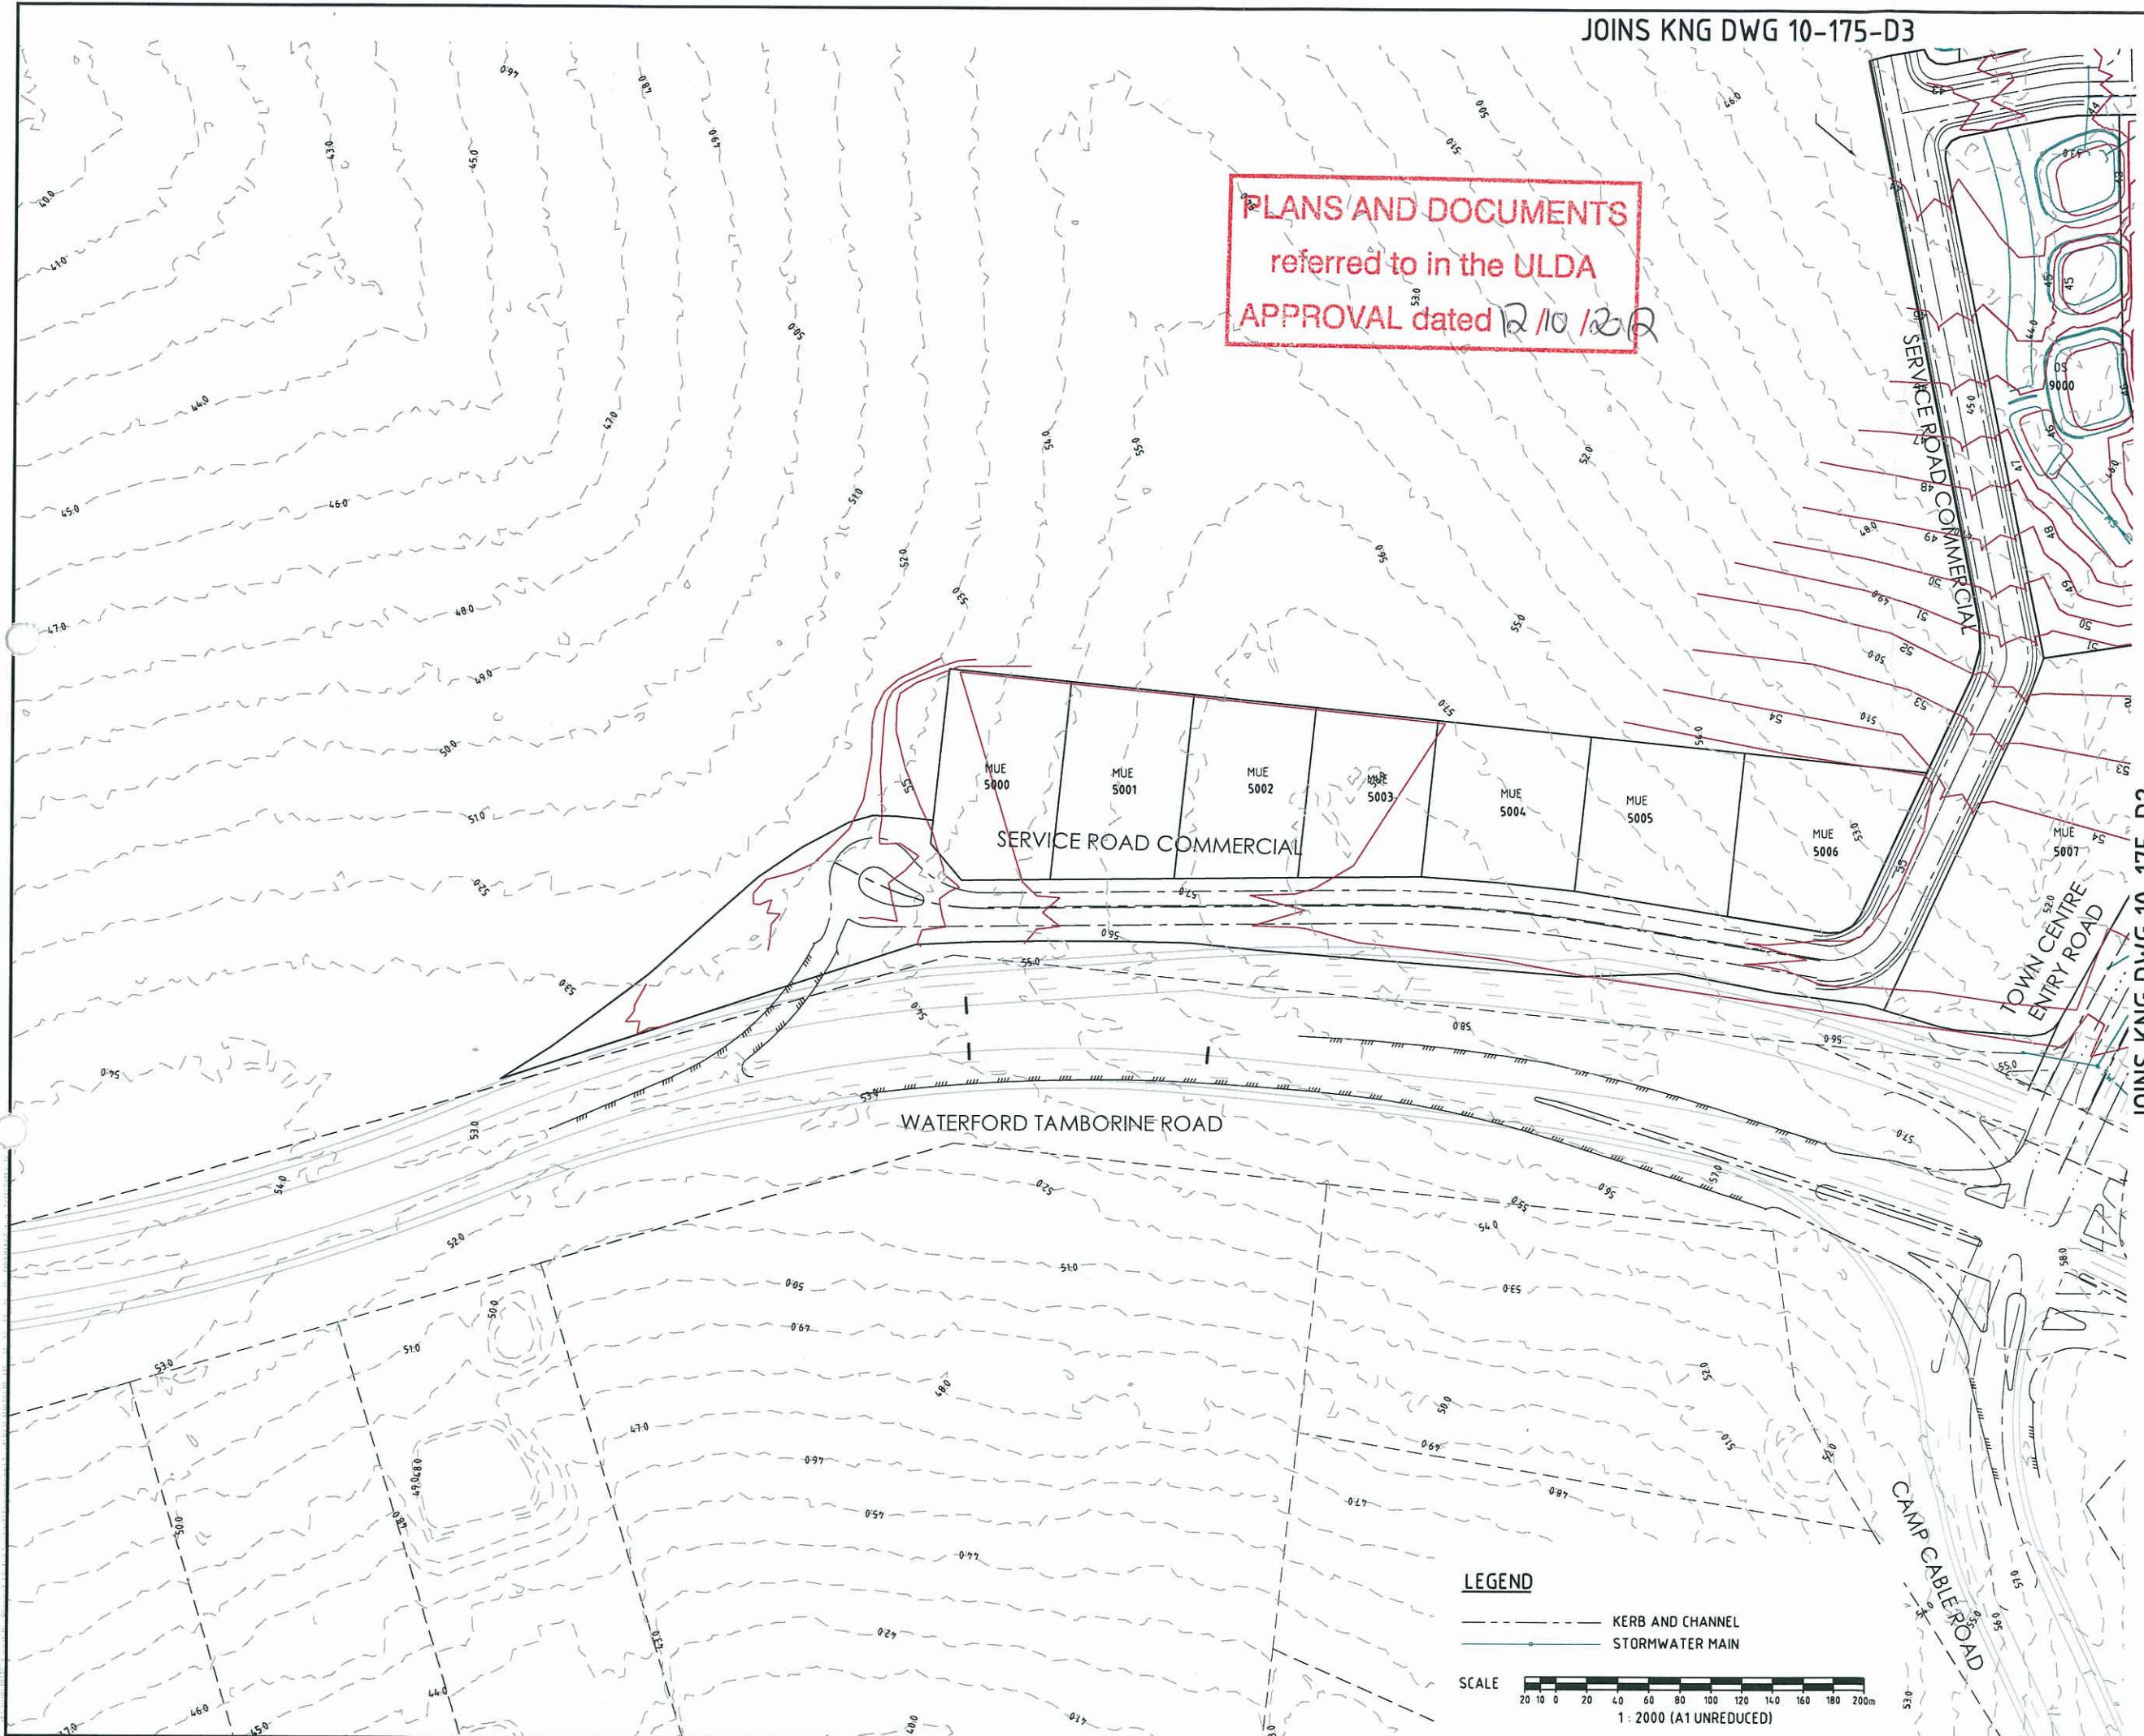

LEGEND

 - KERB AND CHANNEL
- STORMWATER MAIN




JOINS KNG DWG 10-175-D3

JOINS KNG DWG 10-175-D5

DO NOT SCALE THIS DRAWING
IF IN DOUBT - ASK!

KEY PLAN

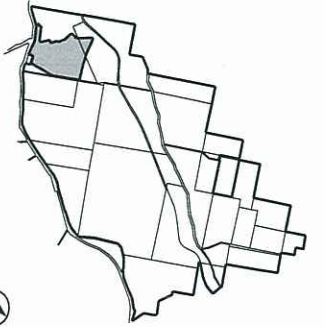

REVISIONS

No	Description	Date	By
A	COUNCIL APPROVAL	15/11/10	GBG
B	COUNCIL APPROVAL	28/01/11	GBG
C	COUNCIL APPROVAL	25/02/11	GBG
D	FOR APPROVAL	31/10/11	TMR

Client



Project

Yarrabilba
A COMPLETE TOWN, A BETTER OUTCOME
YARRABILBA
RESIDENTIAL PRECINCT



LEVEL 2 - 71 GREY STREET
SOUTH BRISBANE
QUEENSLAND 4101
PHONE 07 3017 1900
FAX 07 3017 1911
EMAIL kng@knpl.com.au
ABN 35 112 053 611

Approved Director - RPEQ 1988

Drawing Title

**CONCEPTUAL DRAINAGE PLAN
SHEET 2 OF 5**

Drawn TMR	Designed RC	Checked GBG	Date NOV 10
Scale 1 : 2000	PW No A1000PDU0804	Sheet 32 of 47	Revision D
A3	10-175-D2		


PLANS AND DOCUMENTS
referred to in the ULDA
APPROVAL dated 12/10/2012

LEGEND

--- KERB AND CHANNEL
--- STORMWATER MAIN


SCALE
20 10 0 20 40 60 80 100 120 140 160 180 200m
1 : 2000 (A1 UNREDUCED)

JOINS KNG DWG 10-175-D1

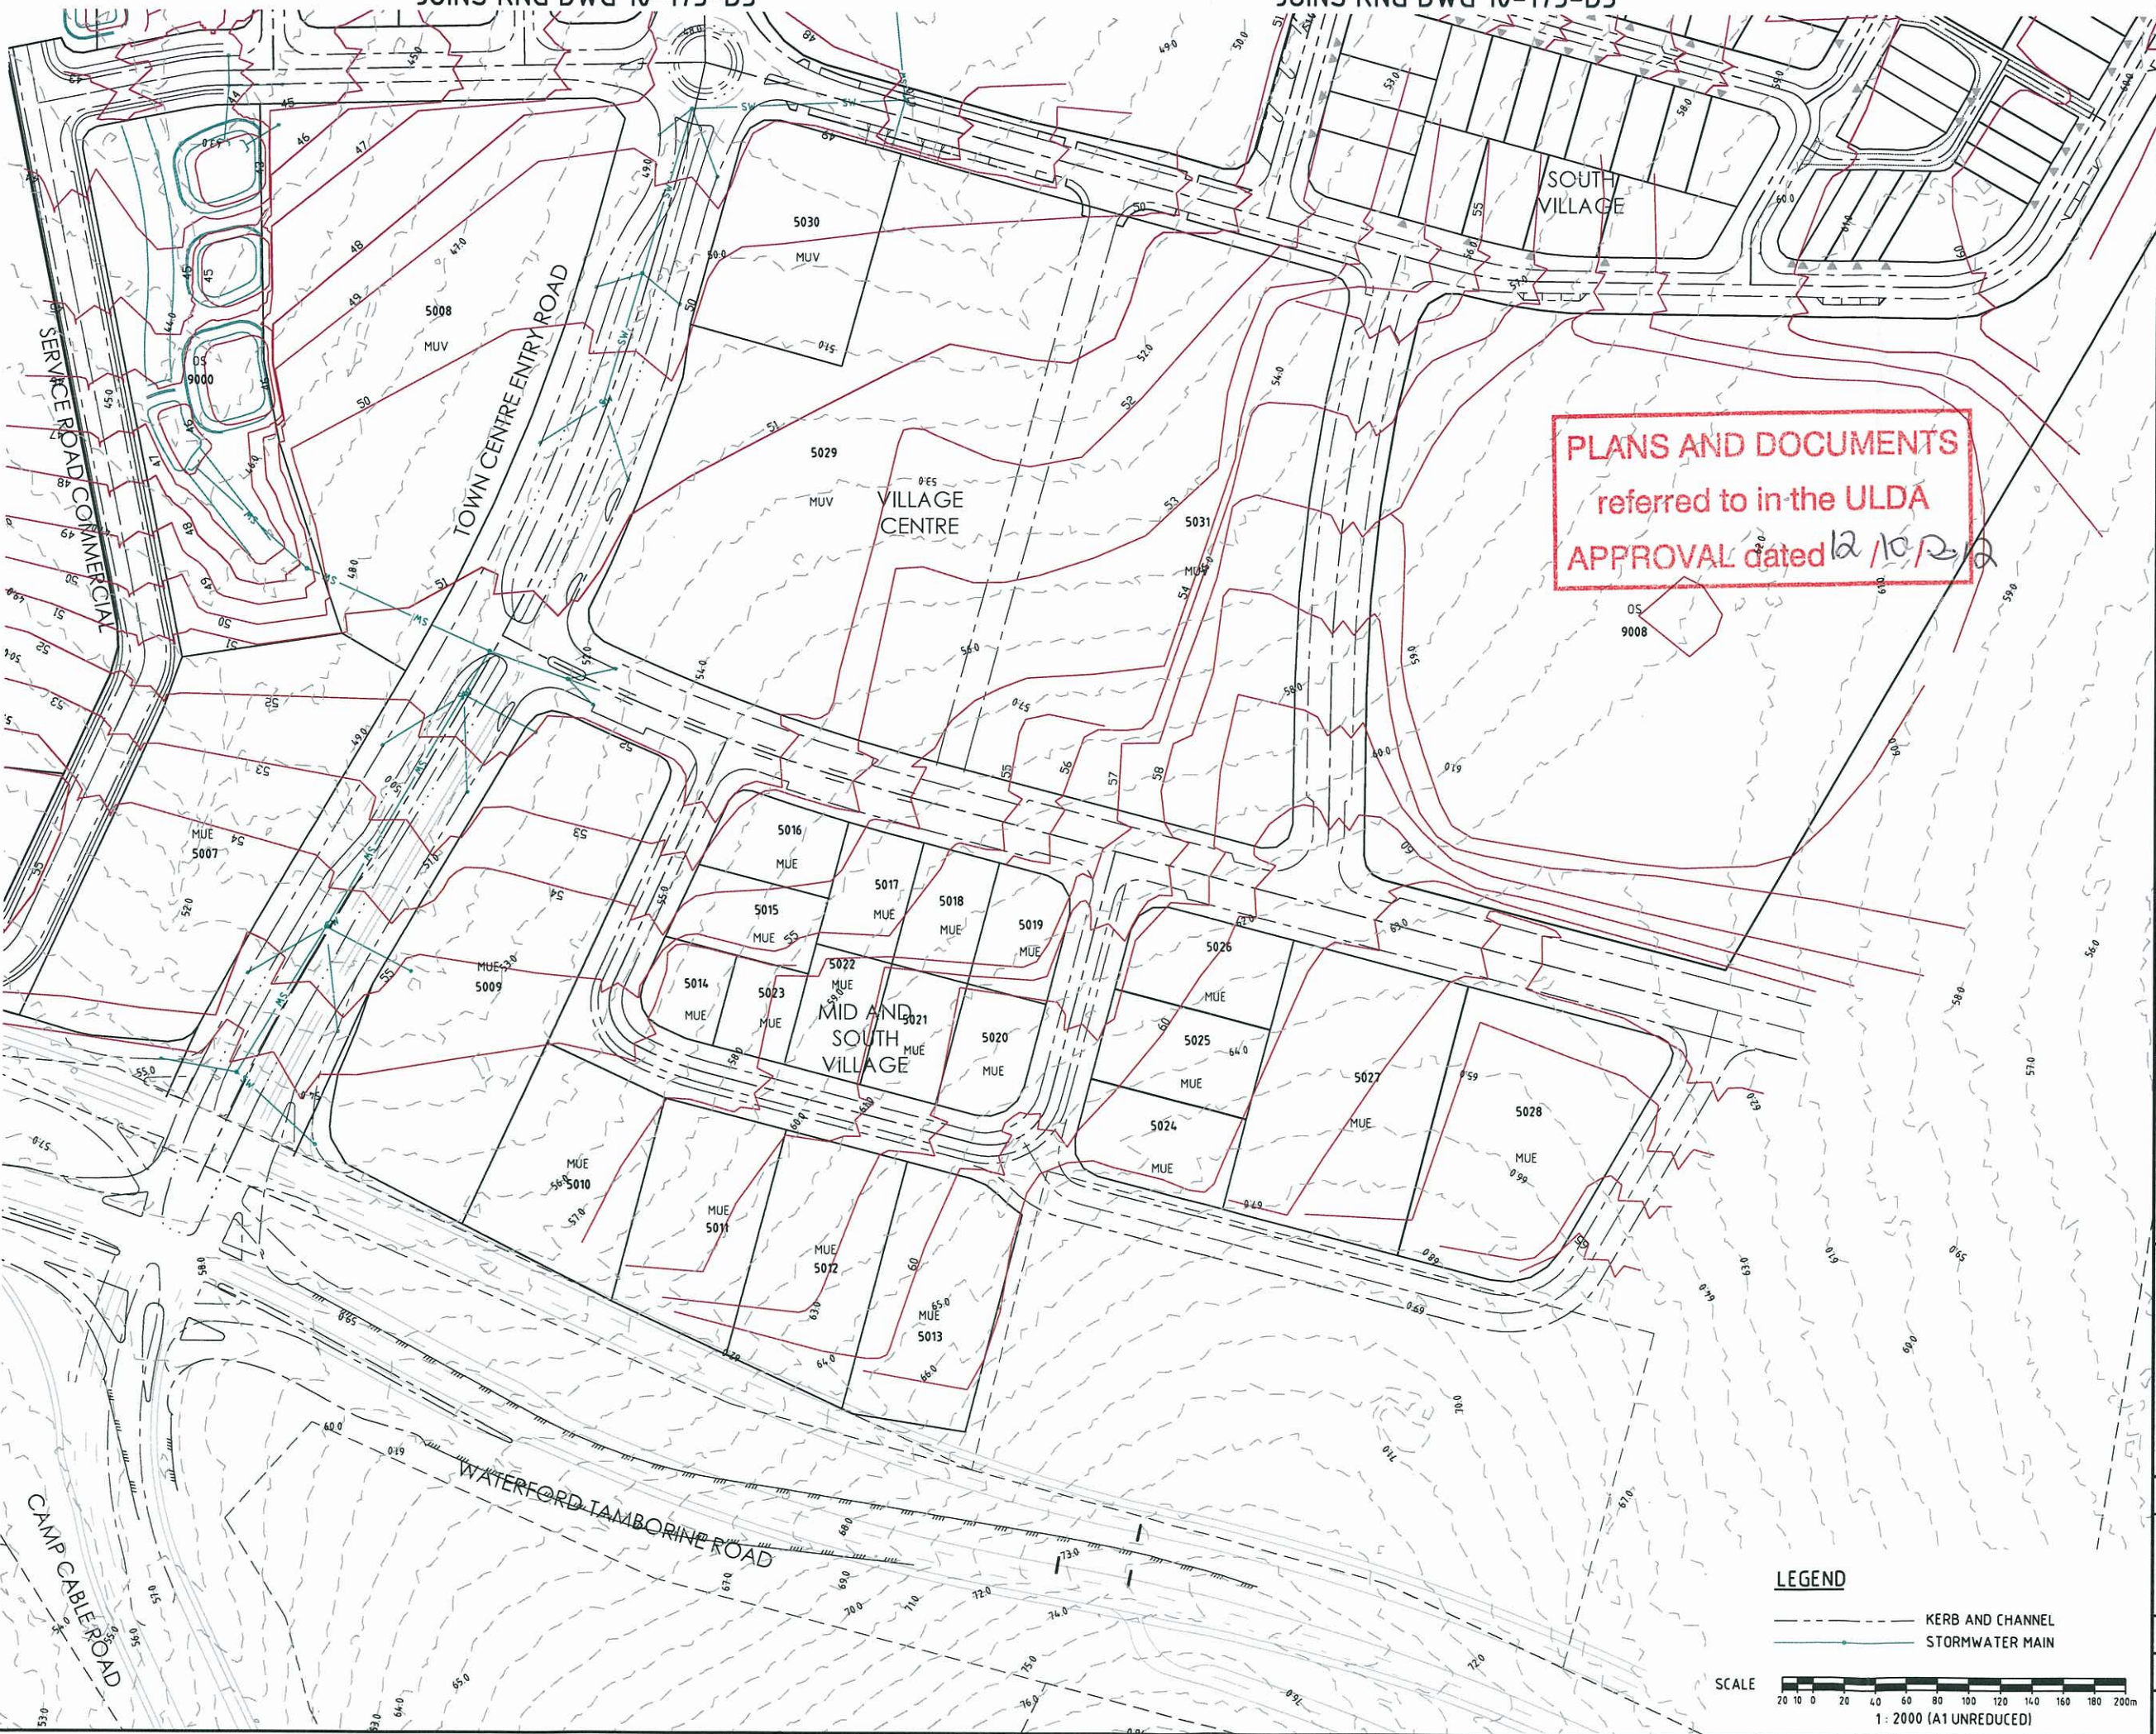

JOINS KNG DWG 10-175-D1

JOINS KNG DWG 10-175-D2

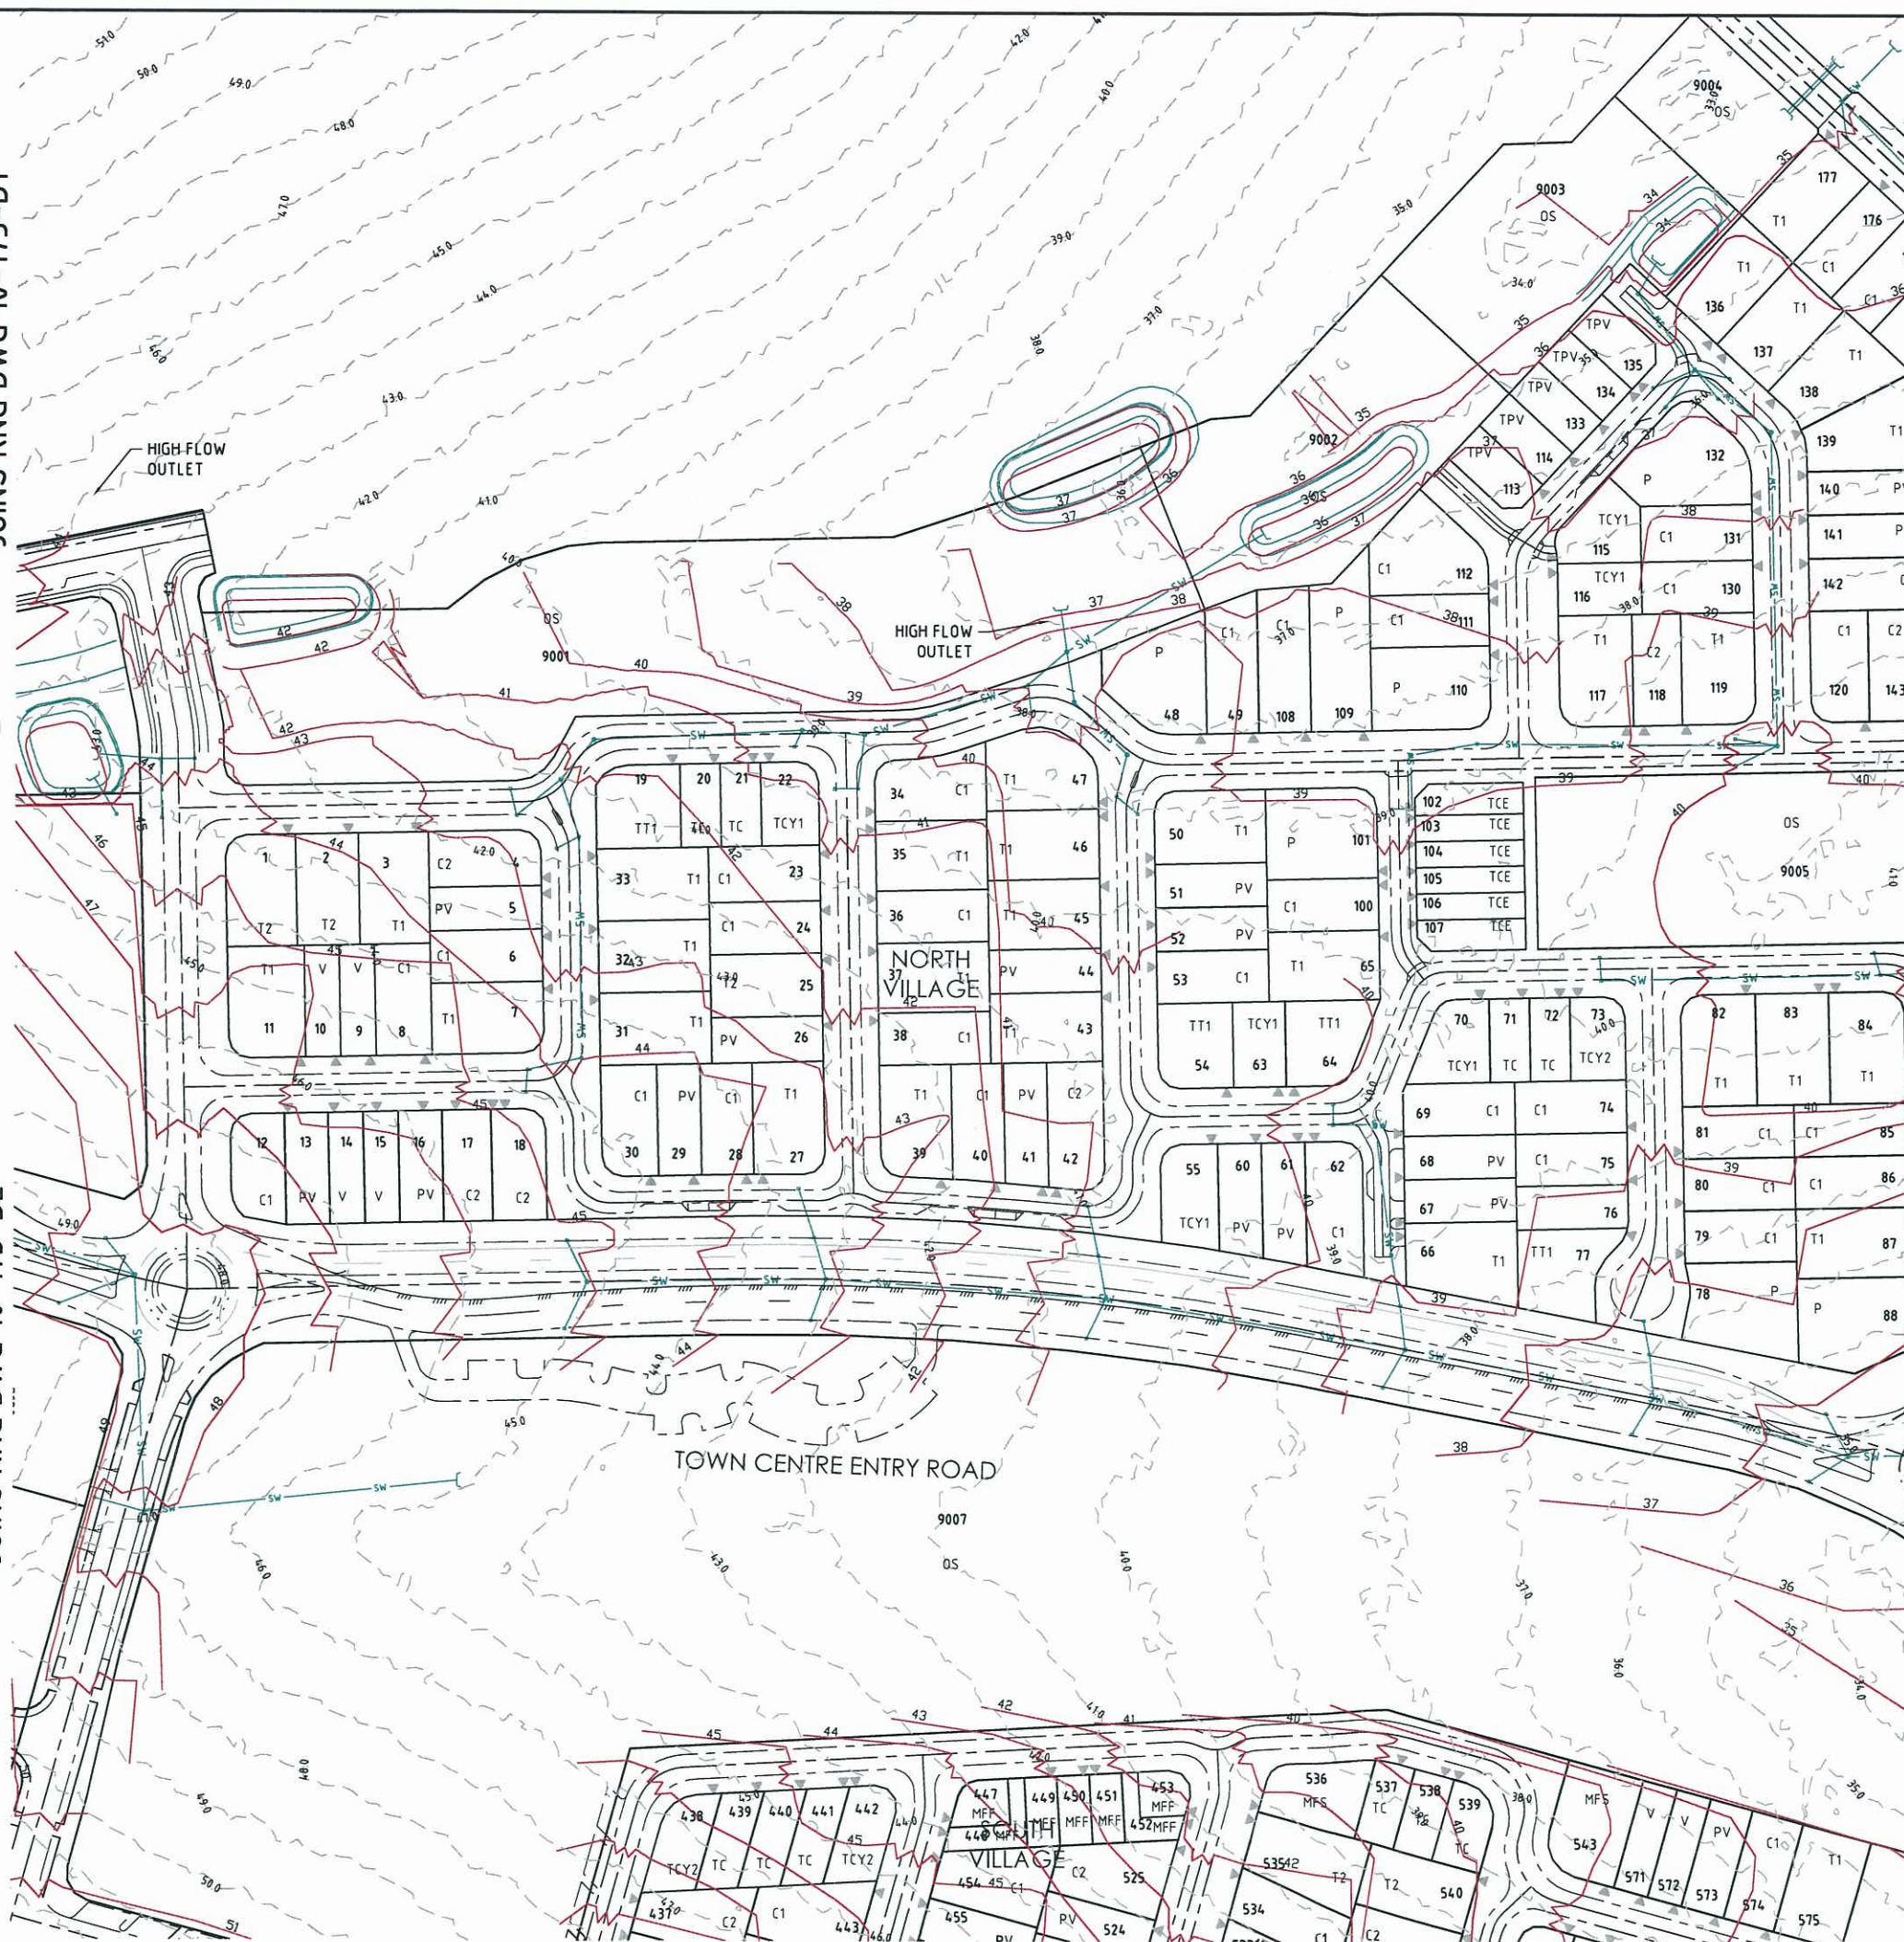


JOINS KNG DWG 10-175-D5

PLANS AND DOCUMENTS
referred to in the ULDA
APPROVAL dated 12/10/2012

JOINS KNG DWG 10-175-D2

LEGEND

 
— KERB AND CHANNEL
— STORMWATER MAIN



DO NOT SCALE THIS DRAWING
IF IN DOUBT - ASK!



KEY PLAN

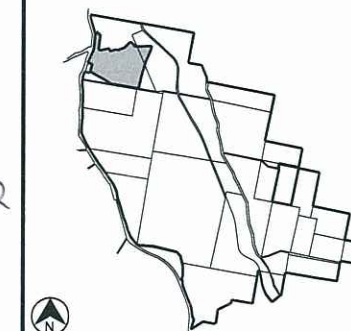

REVISIONS

No	Description	Date	By
A	COUNCIL APPROVAL	15/11/10	GBG
B	COUNCIL APPROVAL	28/01/11	GBG
C	COUNCIL APPROVAL	25/02/11	GBG
D	FOR APPROVAL	31/10/11	TMR

Client



Project

Yarrabilba
A COMPLETE TOWN, A BETTER OUTCOME
YARRABILBA
RESIDENTIAL PRECINCT




LEVEL 2 - 71 GREY STREET
SOUTH BRISBANE
QUEENSLAND 4101
PHONE 07 3017 1900
FAX 07 3017 1911
EMAIL kng@knpl.com.au
ABN 35 112 053 611

Approved Director - RPEQ 1998

Drawing Title

CONCEPTUAL DRAINAGE PLAN
SHEET 3 OF 5


Drawn TMR	Designed RC	Checked GBG	Date NOV 10
Scale 1 : 2000	PW No A1000PDU0804	Sheet 33 of 47	Revision D
A3	10-175-D3		

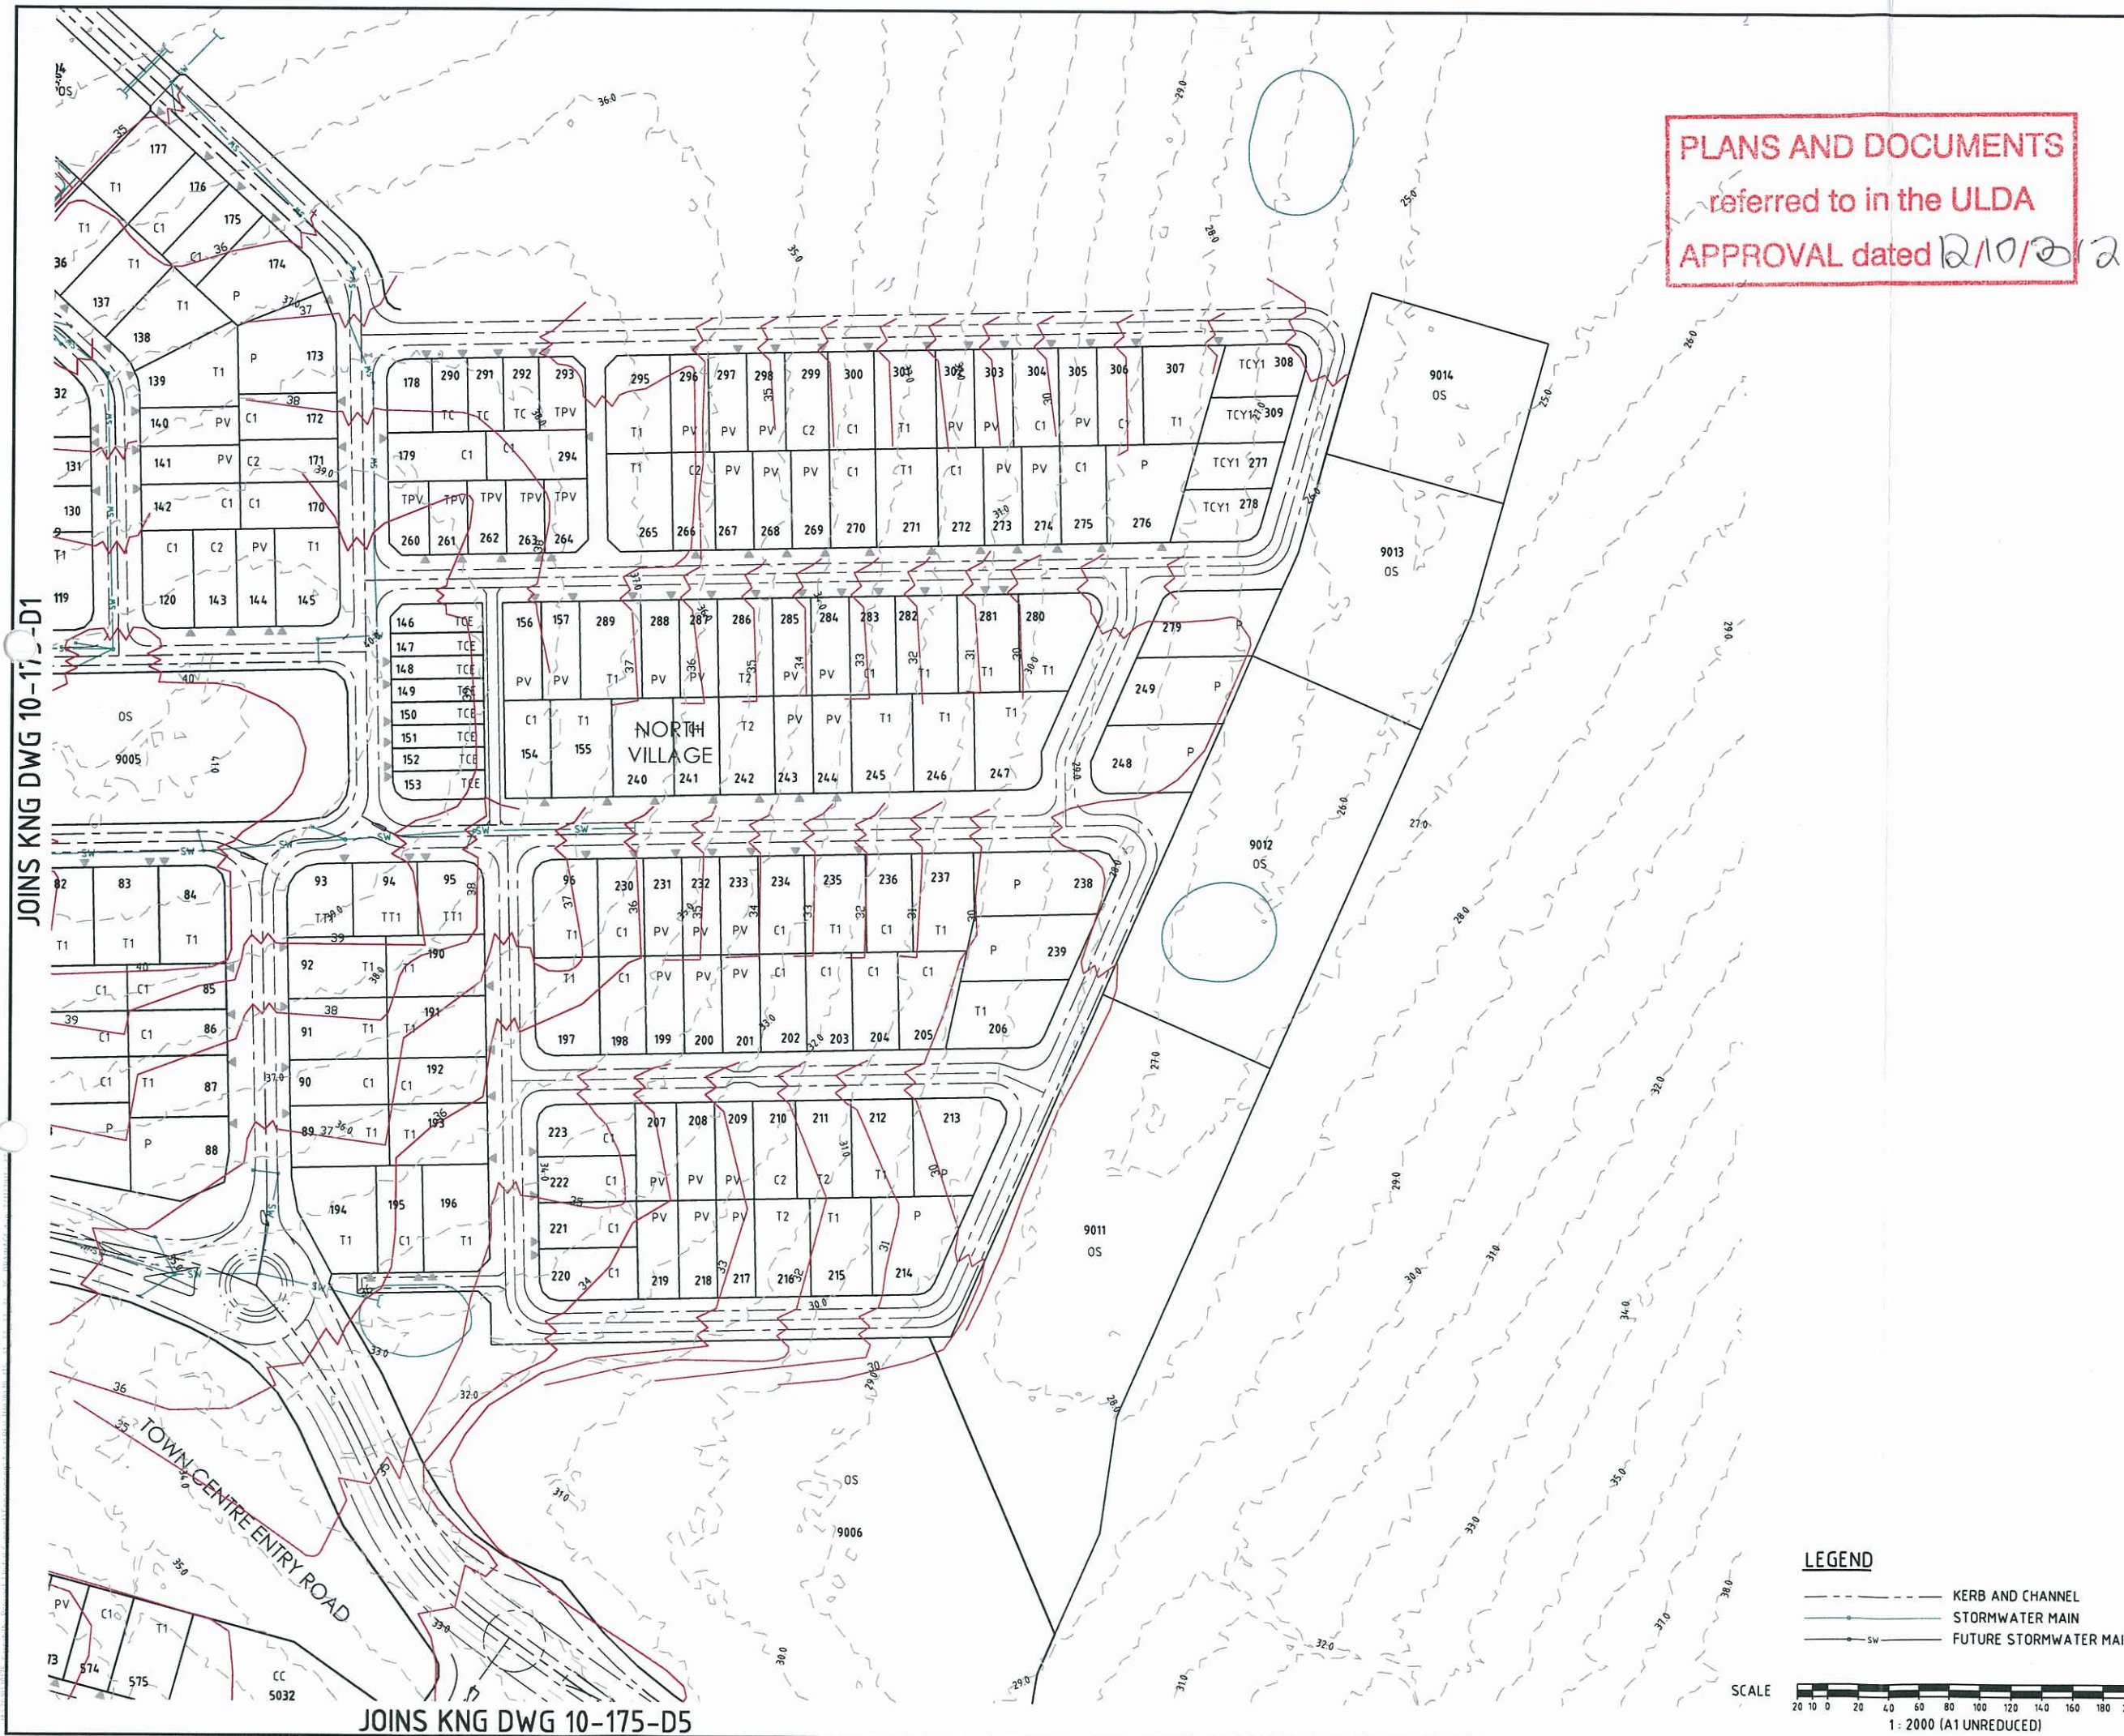

DO NOT SCALE THIS DRAWING
IF IN DOUBT - ASK!


NORTH

KEY PLAN

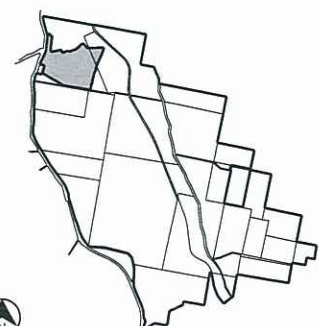

REVISIONS

No	Description	Date	By
A	COUNCIL APPROVAL	15/11/10	GBG
B	COUNCIL APPROVAL	28/01/11	GBG
C	COUNCIL APPROVAL	25/02/11	GBG
D	FOR APPROVAL	31/10/11	TMR

Client


Delfin
Land Lease

Project

Yarrabilba
A COMPLETE TOWN, A BETTER OUTCOME
YARRABILBA
RESIDENTIAL PRECINCT


KN GROUP PTY LTD
CONSULTING ENGINEERS

LEVEL 2 - 71 GREY STREET
SOUTH BRISBANE
QUEENSLAND 4101
PHONE 07 3017 1900
FAX 07 3017 1911
EMAIL knp@knpl.com.au
ABN 35 112 053 611

Approved Director - RPEQ 1988

Drawing Title

**CONCEPTUAL DRAINAGE PLAN
SHEET 4 OF 5**

Drawn	Designed	Checked	Date
TMR	RC	GBG	NOV 10

Scale	PW No	Sheet
1:2000	A1000PDU0804	34 of 47

Drawing No	Revision
A3	10-175-D4


JOINS KNG DWG 10-175-D3

JOINS KNG DWG 10-175-D4

PLANS AND DOCUMENTS
referred to in the ULDA
APPROVAL dated 12/02/11

DO NOT SCALE THIS DRAWING
IF IN DOUBT - ASK!

KEY PLAN

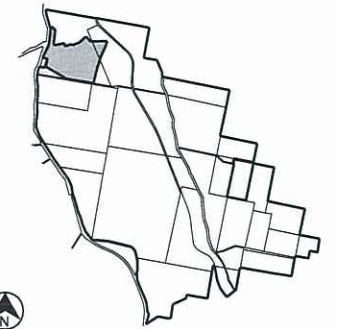

REVISIONS

No	Description	Date	By
A	COUNCIL APPROVAL	15/11/10	GBG
B	COUNCIL APPROVAL	28/01/11	GBG
C	COUNCIL APPROVAL	25/02/11	GBG
D	FOR APPROVAL	31/10/11	TMR

Client



Delfin
Lend Lease

Project

Yarrabilba
A COMPLETE TOWN, A BETTER OUTCOME
YARRABILBA
RESIDENTIAL PRECINCT



LEVEL 2 - 71 GREY STREET
SOUTH BRISBANE
QUEENSLAND 4101
PHONE 07 3017 1900
FAX 07 3017 1911
EMAIL kng@knpl.com.au
ABN 35 112 053 611

Approved Director - RPEQ 1998

Drawing Title

**CONCEPTUAL DRAINAGE PLAN
SHEET 5 OF 5**

Drawn	Designed	Checked	Date
TMR	RC	GBG	NOV 10
Scale	PW No	Drawing No	Sheet
1 : 2000	A1000PDU0804	10-175-D5	35 of 47
A3			D

JOINS KNG DWG 10-175-D2



LEGEND

— KERB AND CHANNEL
— STORMWATER MAIN

SCALE 1 : 2000 (A1 UNREDUCED)