
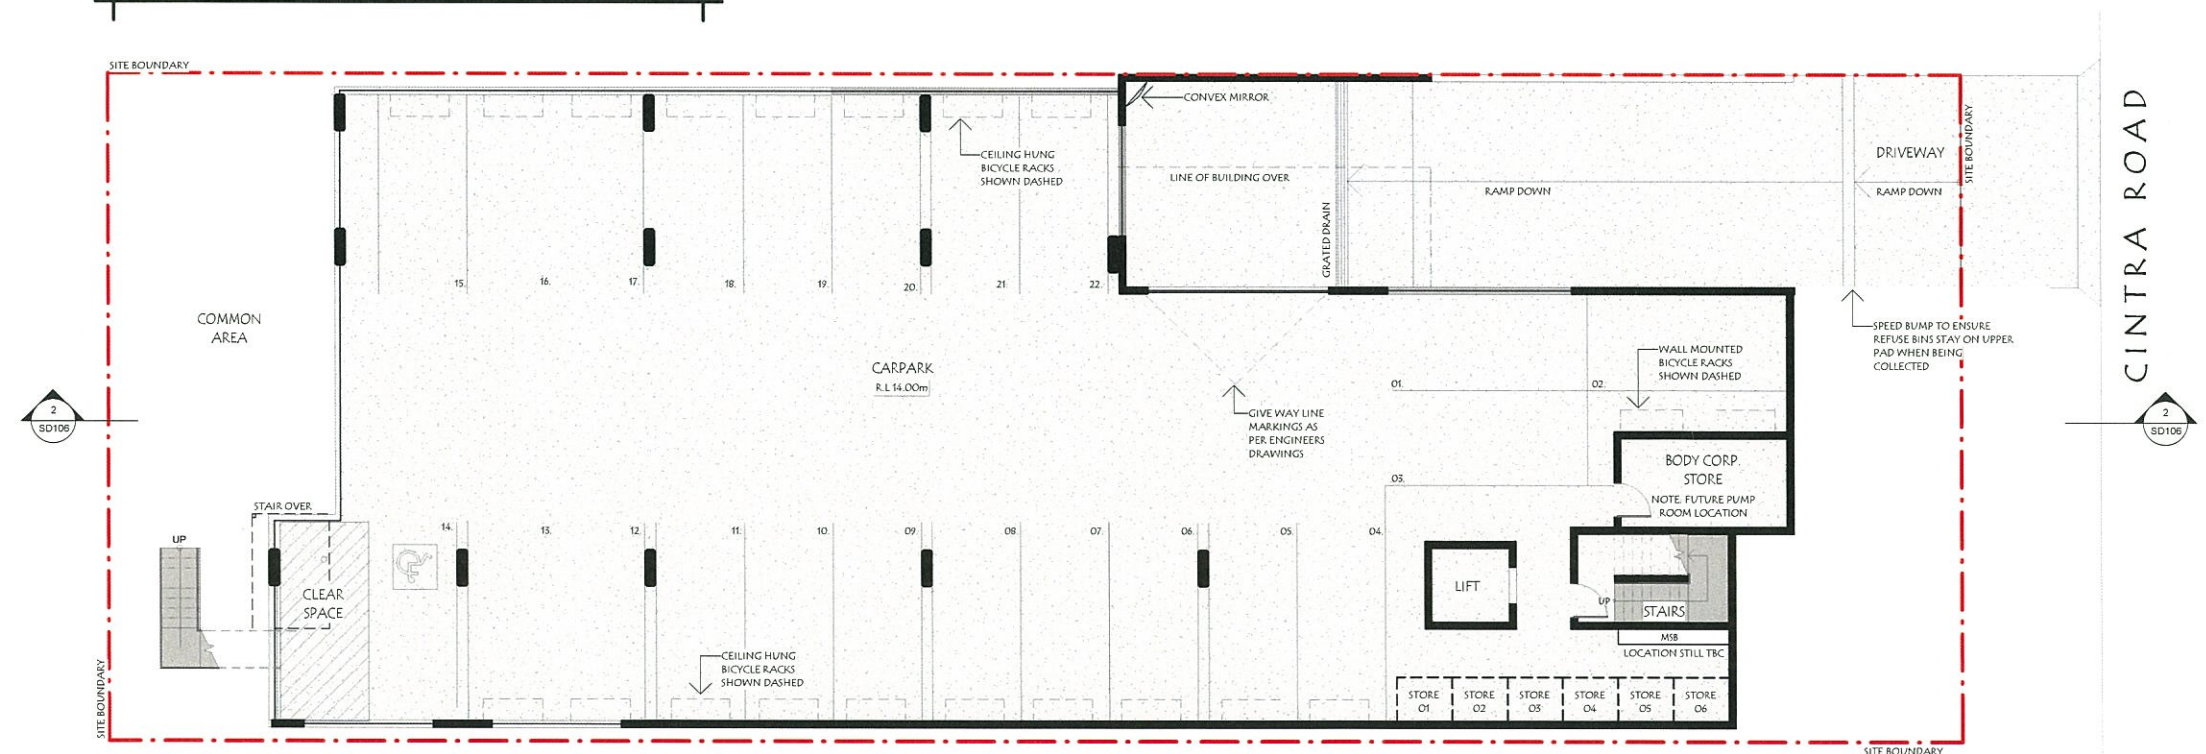


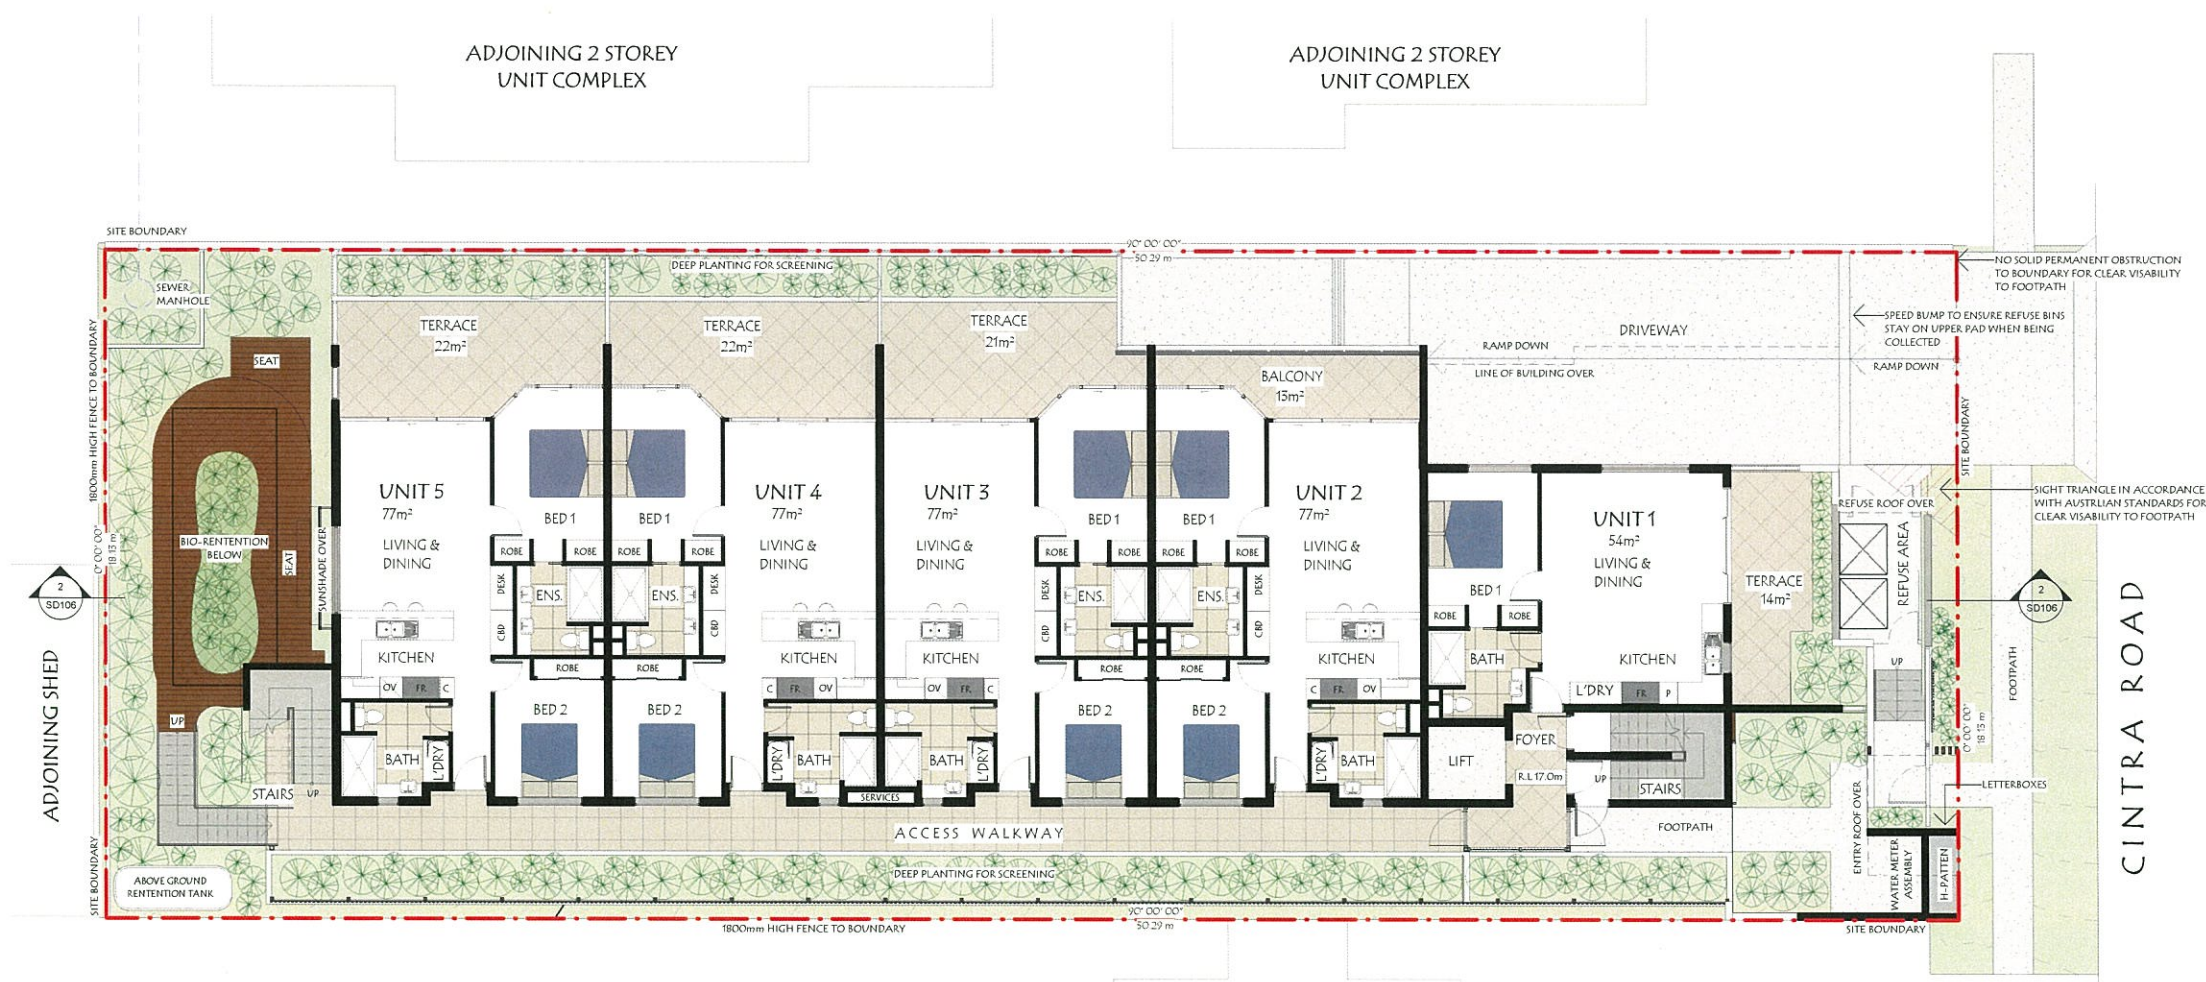

ISSUE	DESCRIPTION	DRAWN	DATE
A	PRELIMINARY ISSUE FOR REVIEW	AC	24.07.2014
B	FOR REVIEW	AC	01.08.2014
C	PRELIM. MCU FOR REVIEW	AC	08.08.2014
D	MCU ISSUE	AC	13.08.2014
E	REVISED FOR REVIEW	AC	17.09.2014
F	REVISED MCU ISSUE	AC	22.09.2014
G	FOR REVIEW/COMMENT	AC	30.10.2014
H	REVISED	AC	31.10.2014
I	REVISED MCU ISSUE	AC	05.11.2014
J	MARKETING ISSUE	AC	17.11.2014
K	REVISED MCU ISSUE	AC	18.12.2014
L	REVISED MCU ISSUE	AJM	03.02.2015

PLANS AND DOCUMENTS referred to in the PDA APPROVAL

12 FEB 2015

MEDQ

SITE INFORMATION

LOT: 18 & 20
ON PLAN: RP10094
PARISH: NORTH BRISBANE
COUNTY: STANLEY
AREA: 911m²

BUILDING INFORMATION

CONSTRUCTION TYPE: A
BUILDING CLASSIFICATION: 2

GENERAL NOTES

CONTRACTOR TO CONFIRM ALL DIMENSIONS AND LEVELS ON SITE PRIOR TO COMMENCEMENT OF ANY WORK.

DO NOT SCALE OFF DRAWINGS

FIGURED DIMENSIONS TAKE PREFERENCE OVER SCALE READINGS

ALL CONSTRUCTION TO COMPLY WITH THE BUILDING CODE OF AUSTRALIA AND RELEVANT AUSTRALIAN STANDARDS

ALL GLAZING TO BE IN ACCORDANCE WITH AUSTRALIAN STANDARDS

REFER TO CONSULTING ENGINEERS DRAWINGS FOR ALL CIVIL STRUCTURAL, MECHANICAL, HYDRAULIC & ELECTRICAL DETAILS



Sunshine Coast
Office 1, 80-82 Sixth Avenue
Maroochydore Q 4558
T: +61 7 5443 3726

Brisbane
Office 3, 36 Bryants Road
Loganholme Q 4129
T: +61 7 3806 1855

E: admin@brdg.com.au

Interiors ■ Residential ■ Commercial ■ Planning ■ Hospitality ■ Institutional

www.brdg.com.au

MEMBERS OF:



© This drawing is protected by copyright. All rights are reserved. Unless permitted under the Copyright Act 1968, no part of this drawing may in any form or by any means be reproduced, published, broadcast, transmitted, or altered in any way without the prior written permission of:

BRAD READ DESIGN GROUP PTY LTD.

PROJECT
MULTI-UNIT DEVELOPMENT

 
LOCATION
48 CINTRA ROAD, BOWEN HILLS


CLIENT
CINTRA ROAD HOLDINGS PTY LTD.

TITLE
PROPOSED FLOOR PLANS

date: JANUARY 2015
scale: 1:100 @A1; 1:200 @A3
drawing no: 0699-SD102 L

drawn: AC
checked: [blank]
drawing no: [blank]



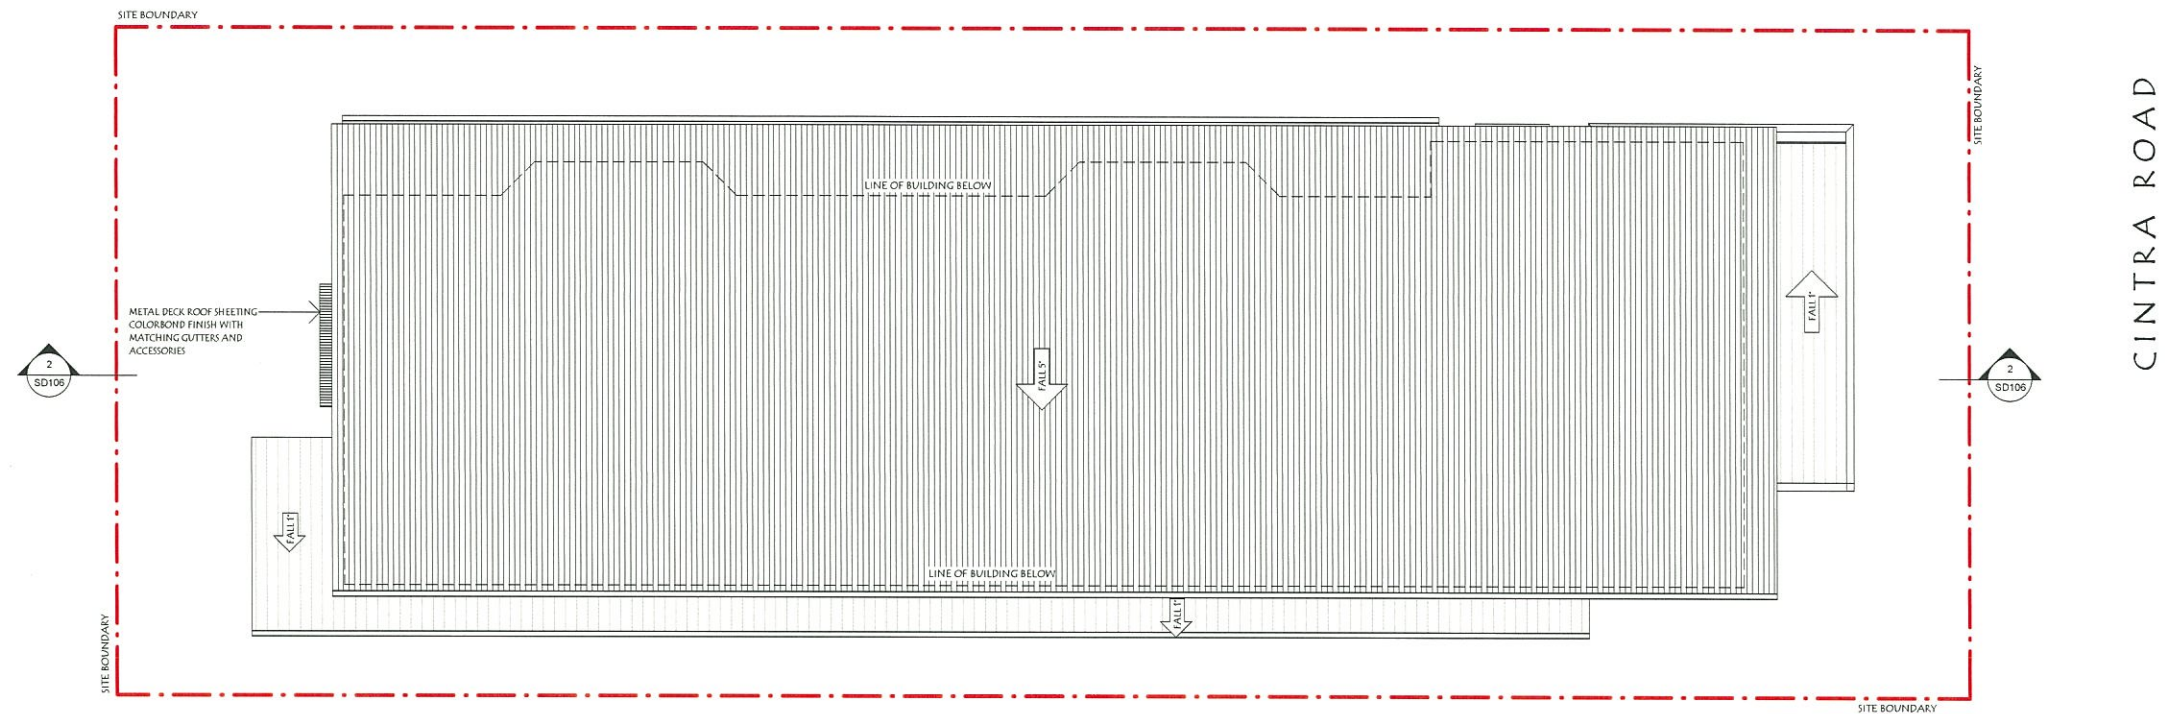

ROOF PLAN


MULTI-UNIT DEVELOPMENT

1:100

PLANS AND DOCUMENTS
referred to in the PDA APPROVAL

12 FEB 2015

MEDQ

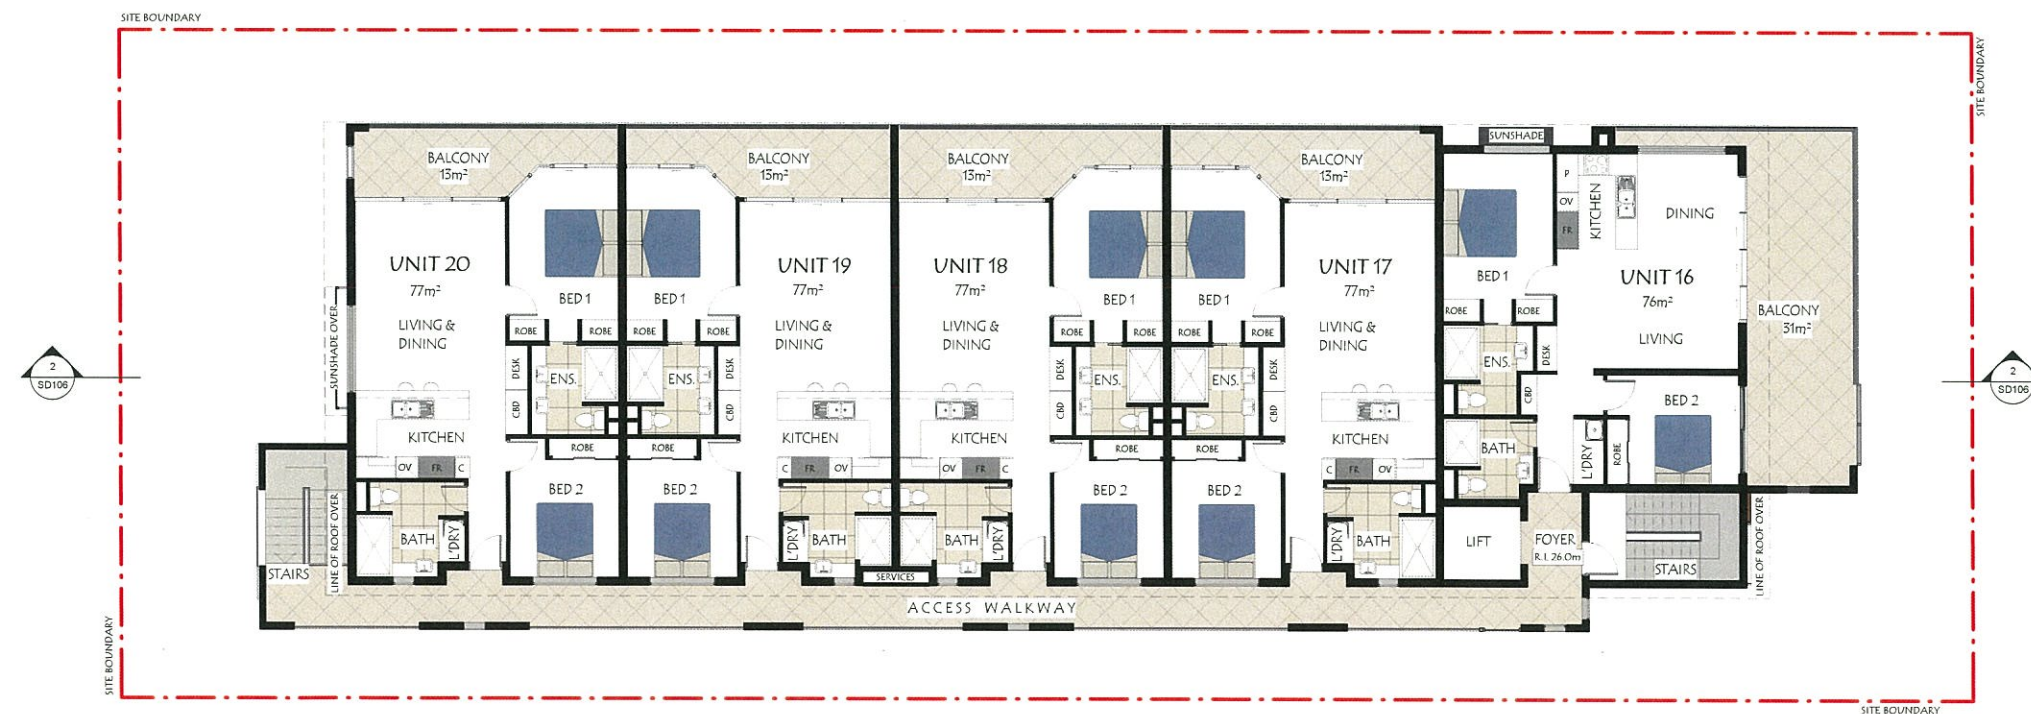

LEVEL 4

MULTI-UNIT DEVELOPMENT

1:100



VISUAL SCALE 1:100 @ A1

ISSUE	DESCRIPTION	DRAWN	DATE
A	PRELIMINARY ISSUE FOR REVIEW	AC	24.07.2014
B	FOR REVIEW	AC	01.08.2014
C	PRELIM. MCU FOR REVIEW	AC	08.08.2014
D	MCU ISSUE	AC	13.08.2014
E	REVISED MCU ISSUE	AC	22.09.2014
F	MARKETING ISSUE	AC	17.11.2014
G	REVISED MCU ISSUE - ADDED REAR STAIR	AC	18.12.2014
H	REVISED MCU ISSUE	AJM	03.02.2015

SITE INFORMATION

LOT: 18 & 20
ON PLAN: RP10094
PARISH: NORTH BRISBANE
COUNTY: STANLEY
AREA: 911m²

BUILDING INFORMATION

CONSTRUCTION TYPE: A
BUILDING CLASSIFICATION: 2

GENERAL NOTES

CONTRACTOR TO CONFIRM ALL DIMENSIONS AND LEVELS ON SITE PRIOR TO COMMENCEMENT OF ANY WORK
DO NOT SCALE OFF DRAWINGS
FIGURED DIMENSIONS TAKE PREFERENCE OVER SCALE READINGS
ALL CONSTRUCTION TO COMPLY WITH THE BUILDING CODE OF AUSTRALIA AND RELEVANT AUSTRALIAN STANDARDS
ALL GLAZING TO BE IN ACCORDANCE WITH AUSTRALIAN STANDARDS
REFER TO CONSULTING ENGINEERS DRAWINGS FOR ALL CIVIL, STRUCTURAL, MECHANICAL, HYDRAULIC & ELECTRICAL DETAILS



Sunshine Coast
Office 1, 80-82 Sixth Avenue
Maroochydore Q 4558
T: +61 7 5443 3726

Brisbane
Office 3, 36 Bryants Road
Loganholme Q 4129
T: +61 7 3806 1855

E: admin@brdg.com.au

Interiors ■ Residential ■ Commercial ■ Planning ■ Hospitality ■ Institutional

www.brdg.com.au

MEMBERS OF:



© This drawing is protected by copyright. All rights are reserved. Unless permitted under the Copyright Act 1968, no part of this drawing may in any form or by any means be reproduced, published, broadcast, transmitted, or altered in any way without the prior written permission of:
BRAD READ DESIGN GROUP PTY LTD.

PROJECT

MULTI-UNIT DEVELOPMENT

LOCATION

48 CINTRA ROAD, BOWEN HILLS

CLIENT

CINTRA ROAD HOLDINGS PTY LTD.

TITLE

PROPOSED FLOOR PLANS AND

ROOF PLAN


date: JANUARY 2015

scale: 1:100 @A1; 1:200 @A3

drawing no: 0699-SD104 H

drawn: AC

checked: MEDQ

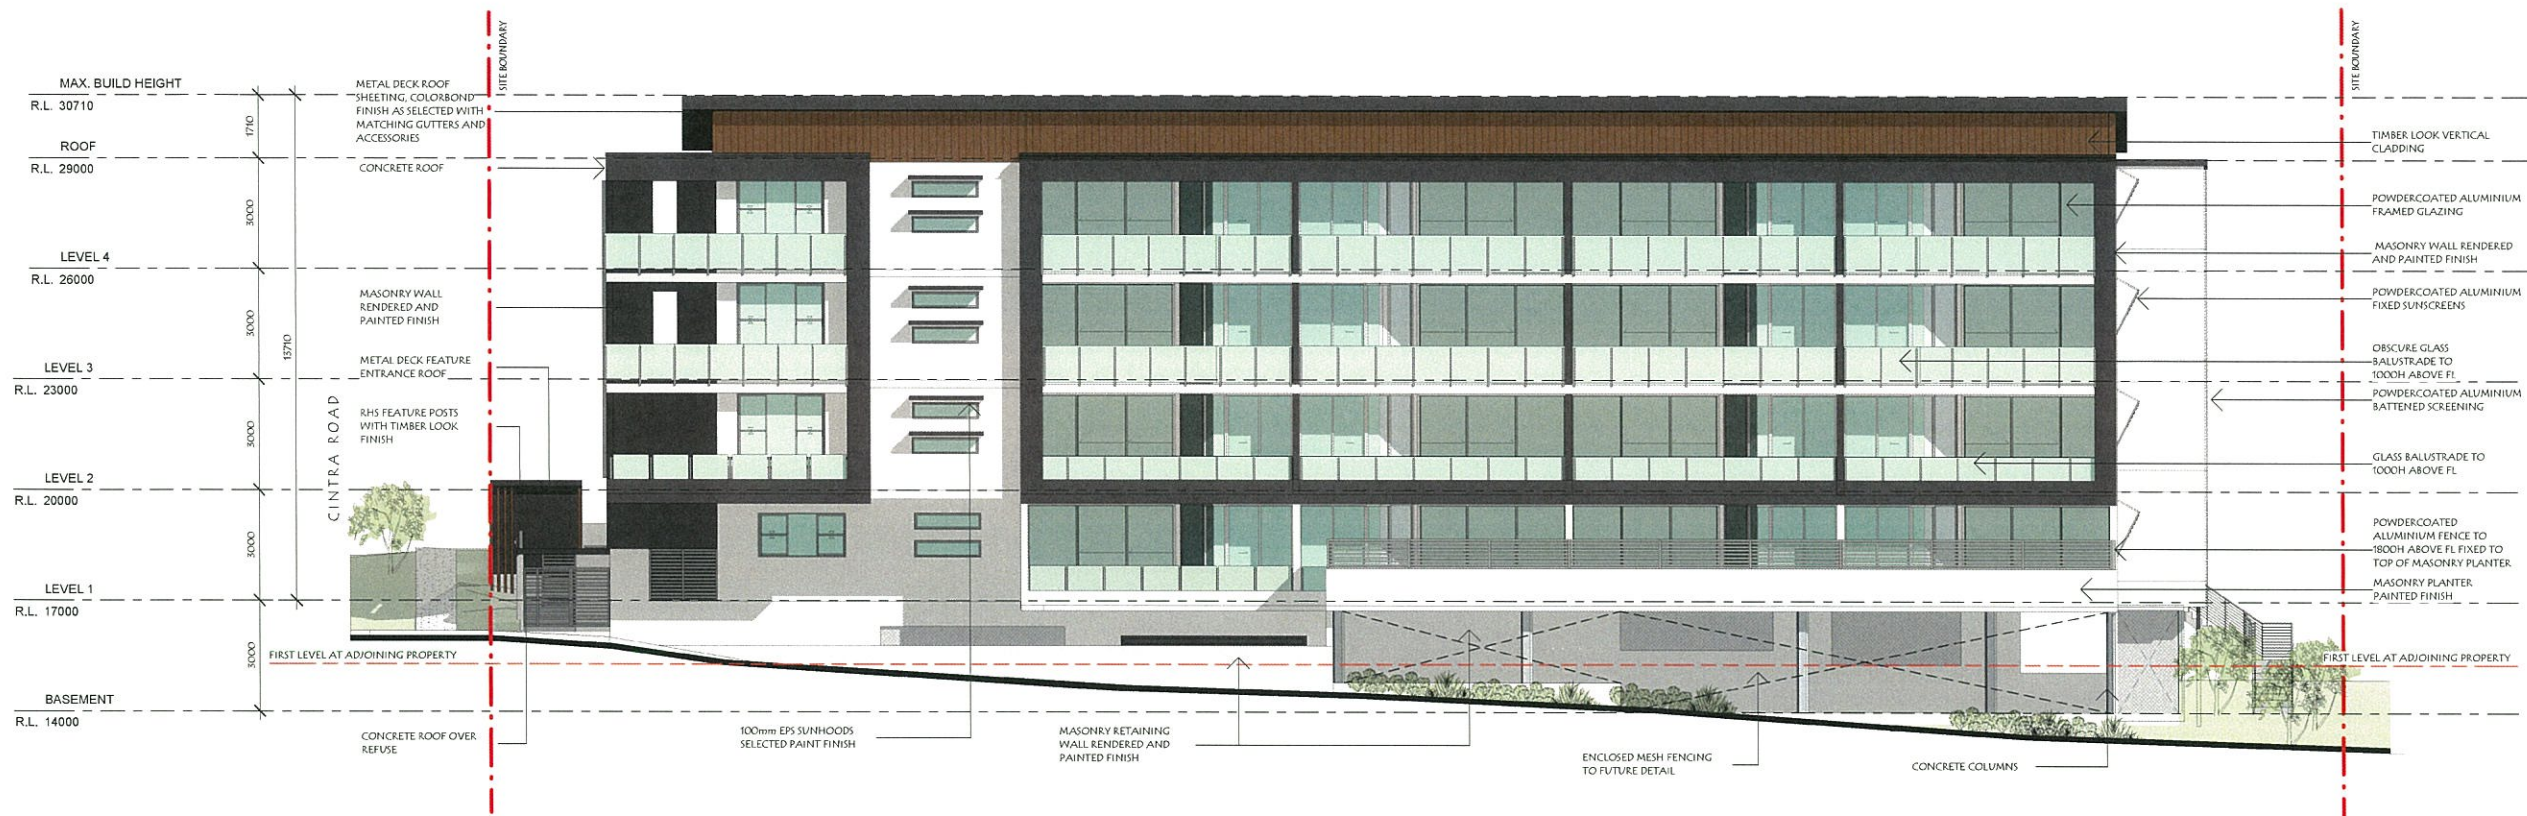


NORTH ELEVATION
MULTI-UNIT DEVELOPMENT
1:100

PLANS AND DOCUMENTS
referred to in the PDA APPROVAL

12 FEB 2015


MEDQ

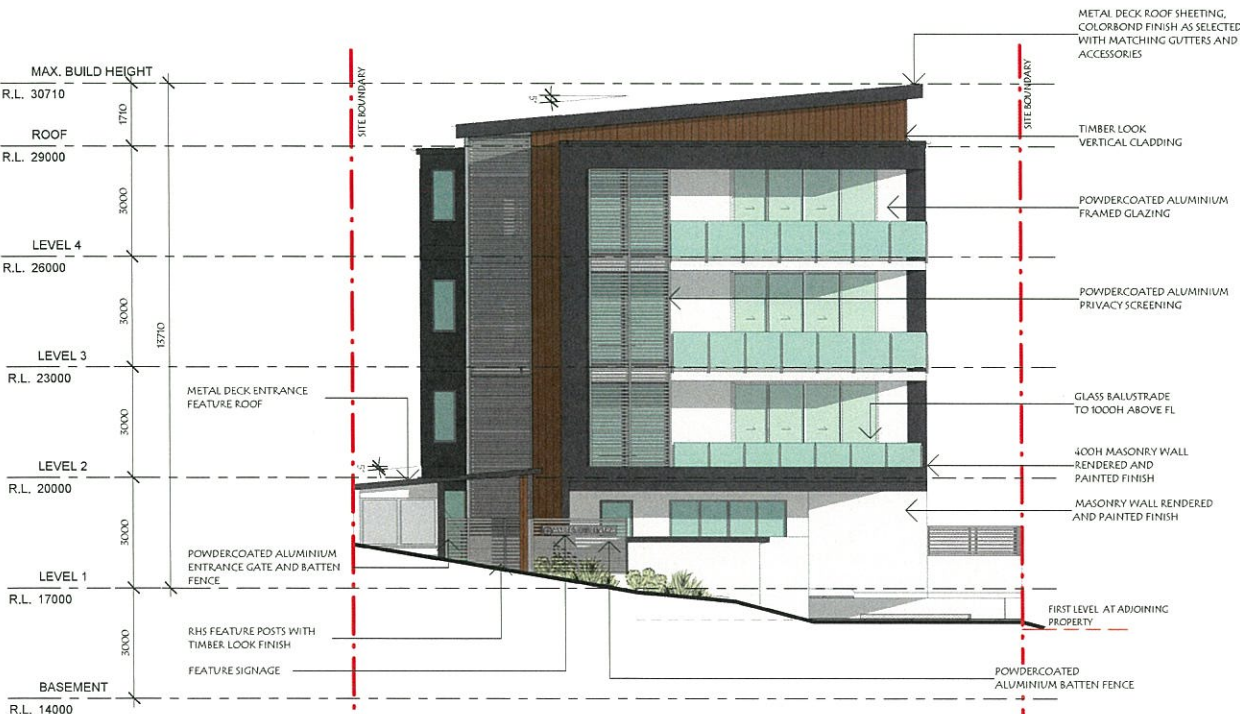

EAST ELEVATION
MULTI-UNIT DEVELOPMENT
1:100



 WEST ELEVATION
MULTI-UNIT DEVELOPMENT
1:100



ISSUE	DESCRIPTION	DRAWN	DATE
A	PRELIMINARY ISSUE FOR REVIEW	AC	24.07.2014
B	FOR REVIEW	AC	01.08.2014
C	PRELIM. MCU FOR REVIEW	AC	08.08.2014
D	MCU ISSUE	AC	13.08.2014
E	REVISED FOR REVIEW	AC	17.09.2014
F	REVISED MCU ISSUE	AC	22.09.2014
G	REVISED	AC	03.11.2014
H	MARKETING ISSUE	AC	17.11.2014
I	REVISED MCU ISSUE - ADDED REAR STAIR	AC	18.12.2014
J	REVISED MCU ISSUE	AJM	03.02.2015

SITE INFORMATION
LOT: 18 & 20
ON PLAN: RP10094
PARISH: NORTH BRISBANE
COUNTY: STANLEY
AREA: 911m²

BUILDING INFORMATION
CONSTRUCTION TYPE: A
BUILDING CLASSIFICATION: 2

GENERAL NOTES
CONTRACTOR TO CONFIRM ALL DIMENSIONS AND LEVELS ON SITE PRIOR TO COMMENCEMENT OF ANY WORK
DO NOT SCALE OFF DRAWINGS
FIGURED DIMENSIONS TAKE PREFERENCE OVER SCALE READINGS
ALL CONSTRUCTION TO COMPLY WITH THE BUILDING CODE OF AUSTRALIA AND RELEVANT AUSTRALIAN STANDARDS
ALL GLAZING TO BE IN ACCORDANCE WITH AUSTRALIAN STANDARDS
REFER TO CONSULTING ENGINEERS DRAWINGS FOR ALL CIVIL STRUCTURAL, MECHANICAL, HYDRAULIC & ELECTRICAL DETAILS

Sunshine Coast
Office 1, 80-82 Sixth Avenue
Maroochydore Q 4558
T: +61 7 5443 3726

Brisbane
Office 3, 36 Bryants Road
Loganholme Q 4129
T: +61 7 3006 1855

E: admin@brdg.com.au

Interiors ■ Residential ■ Commercial ■ Planning ■ Hospitality ■ Institutional

www.brdg.com.au ABN 48 111 443 891 CREC 11/02/07

MEMBERS OF:

© This drawing is protected by copyright. All rights are reserved. Unless permitted under the Copyright Act 1968, no part of this drawing may in any form or by any means be reproduced, published, broadcast, transmitted, or altered in any way without the prior written permission of:

BRAD READ DESIGN GROUP PTY LTD.

PROJECT
MULTI-UNIT DEVELOPMENT


LOCATION
48 CINTRA ROAD, BOWEN HILLS

CLIENT
CINTRA ROAD HOLDINGS PTY LTD.

TITLE
PROPOSED ELEVATIONS

date: JANUARY 2015
scale: 1:100 @A1; 1:200 @A3
drawing no: 0699-SD105 J

drawn: AC
checked:

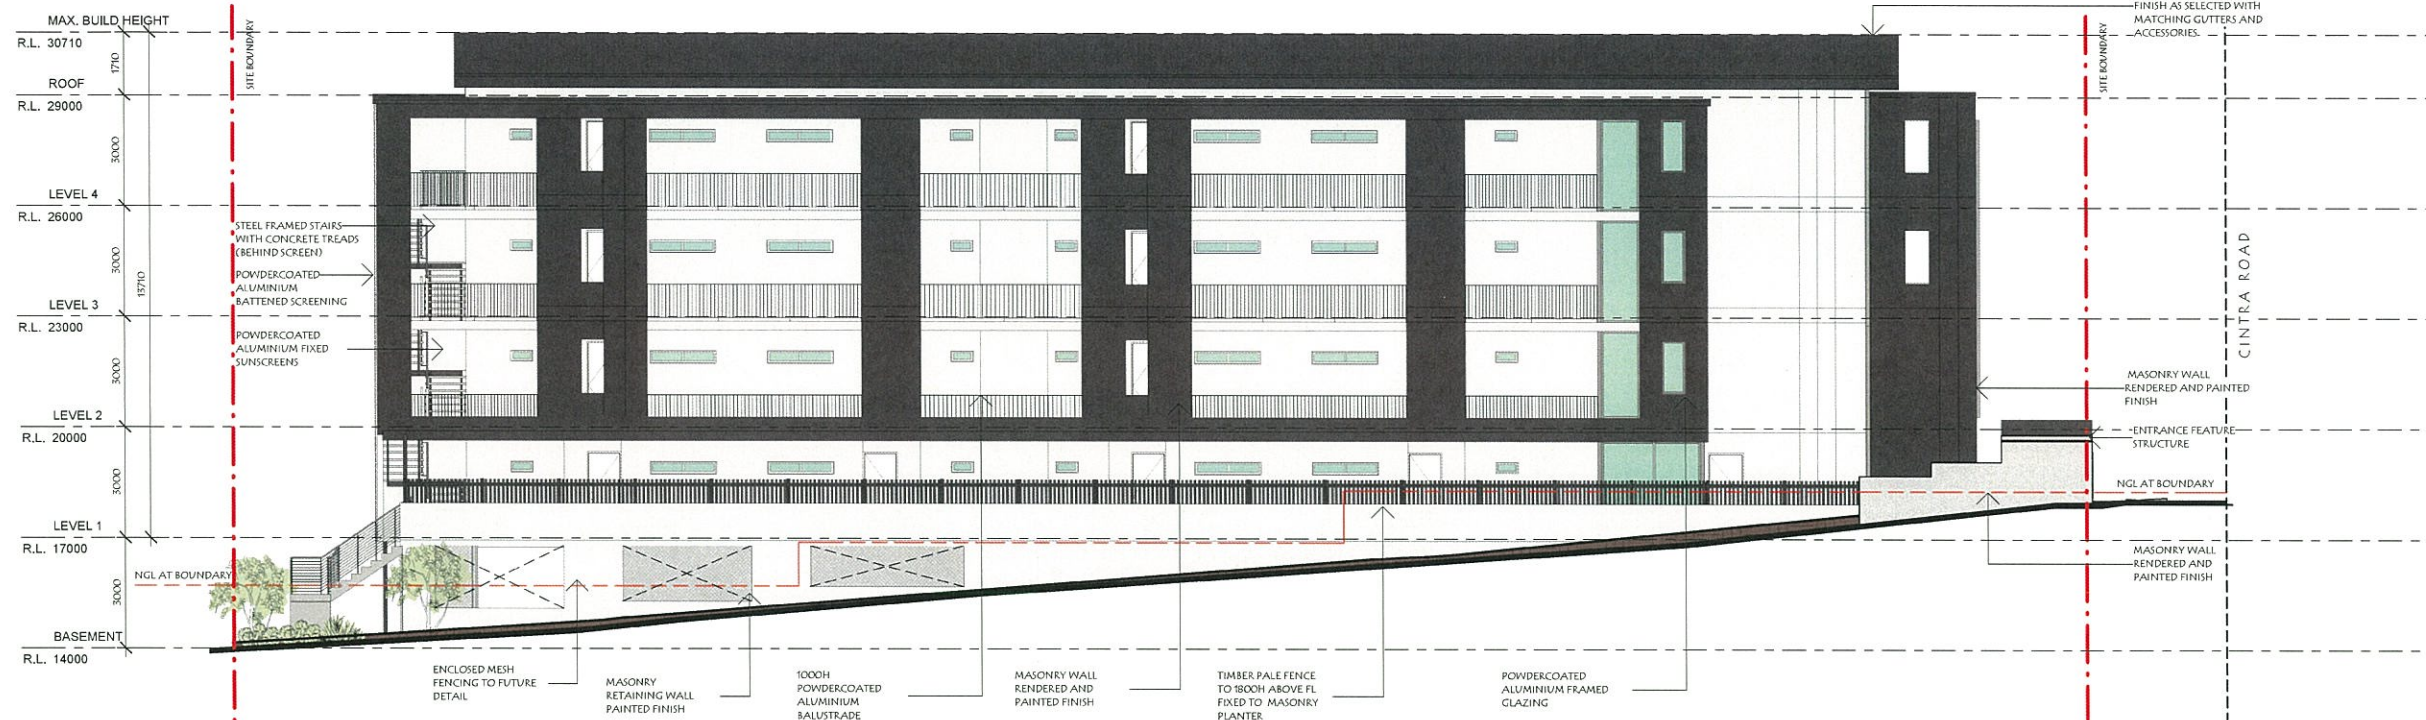

SOUTH ELEVATION


MULTI-UNIT DEVELOPMENT

1:100

PLANS AND DOCUMENTS
referred to in the PDA APPROVAL

12 FEB 2015

MEDQ

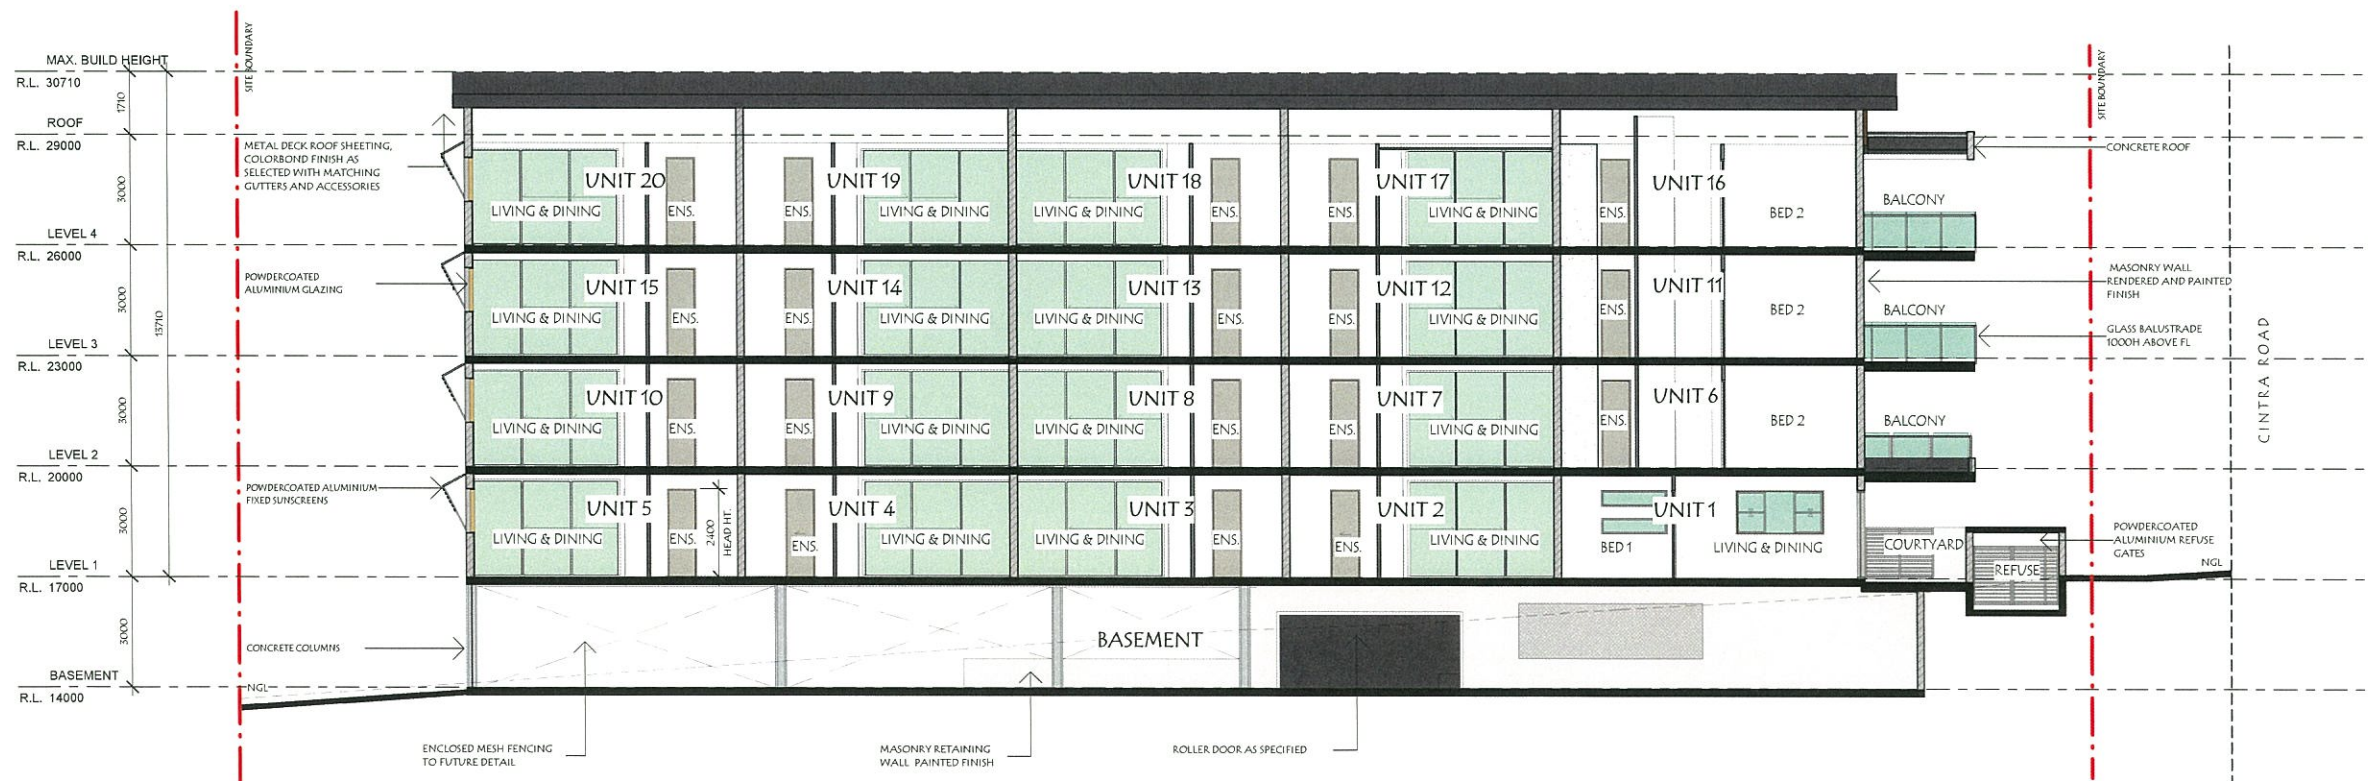

SECTION A

MULTI-UNIT DEVELOPMENT

1:100



VISUAL SCALE 1:100 @ A1

ISSUE	DESCRIPTION	DRAWN	DATE
A	PRELIMINARY ISSUE FOR REVIEW	AC	24.07.2014
B	FOR REVIEW	AC	01.08.2014
C	PRELIM. MCU FOR REVIEW	AC	08.08.2014
D	MCU ISSUE	AC	13.08.2014
E	REVISED FOR REVIEW	AC	17.09.2014
F	REVISED MCU ISSUE	AC	22.09.2014
G	REVISED MCU ISSUE	AC	05.11.2014
H	MARKETING ISSUE	AC	17.11.2014
I	REVISED MCU ISSUE - ADDED REAR STAIRS	AC	18.12.2014
J	REVISED MCU ISSUE	AJM	03.02.2015

SITE INFORMATION

LOT: 18 & 20
ON PLAN: RP10094
PARISH: NORTH BRISBANE
COUNTY: STANLEY
AREA: 911m²

BUILDING INFORMATION

CONSTRUCTION TYPE: A

BUILDING CLASSIFICATION: 2

GENERAL NOTES

CONTRACTOR TO CONFIRM ALL DIMENSIONS AND LEVELS ON SITE PRIOR TO COMMENCEMENT OF ANY WORK

DO NOT SCALE OFF DRAWINGS

FIGURED DIMENSIONS TAKE PREFERENCE OVER SCALE READINGS

ALL CONSTRUCTION TO COMPLY WITH THE BUILDING CODE OF AUSTRALIA AND RELEVANT AUSTRALIAN STANDARDS

ALL GLAZING TO BE IN ACCORDANCE WITH AUSTRALIAN STANDARDS

REFER TO CONSULTING ENGINEERS DRAWINGS FOR ALL CIVIL STRUCTURAL, MECHANICAL, HYDRAULIC & ELECTRICAL DETAILS



Sunshine Coast
Office 1, 80-82 Sixth Avenue
Maroochydore Q 4558
T: +61 7 5443 3726

Brisbane
Office 3, 36 Bryants Road
Loganholme Q 4129
T: +61 7 5806 1855

E: admin@brdg.com.au

Interiors ■ Residential ■ Commercial ■ Planning ■ Hospitality ■ Institutional

www.brdg.com.au NEW 08 131 001491 (QCE 154692) Brad Read Design Group Pty Ltd

MEMBERS OF:



© This drawing is protected by copyright. All rights are reserved. Unless permitted under the Copyright Act 1968, no part of this drawing may in any form or by any means be reproduced, published, broadcast, transmitted, or altered in any way without the prior written permission of:

BRAD READ DESIGN GROUP PTY LTD.

PROJECT

MULTI-UNIT DEVELOPMENT

LOCATION

48 CINTRA ROAD, BOWEN HILLS

CLIENT

CINTRA ROAD HOLDINGS PTY LTD.

TITLE

PROPOSED ELEVATIONS AND SECTION

date: JANUARY 2015

scale: 1:100 @A1; 1:200 @A3

drawing no: 0699-SD106 J

drawn: AC

checked: AC

0699-SD106 J