


SITE LOCATION

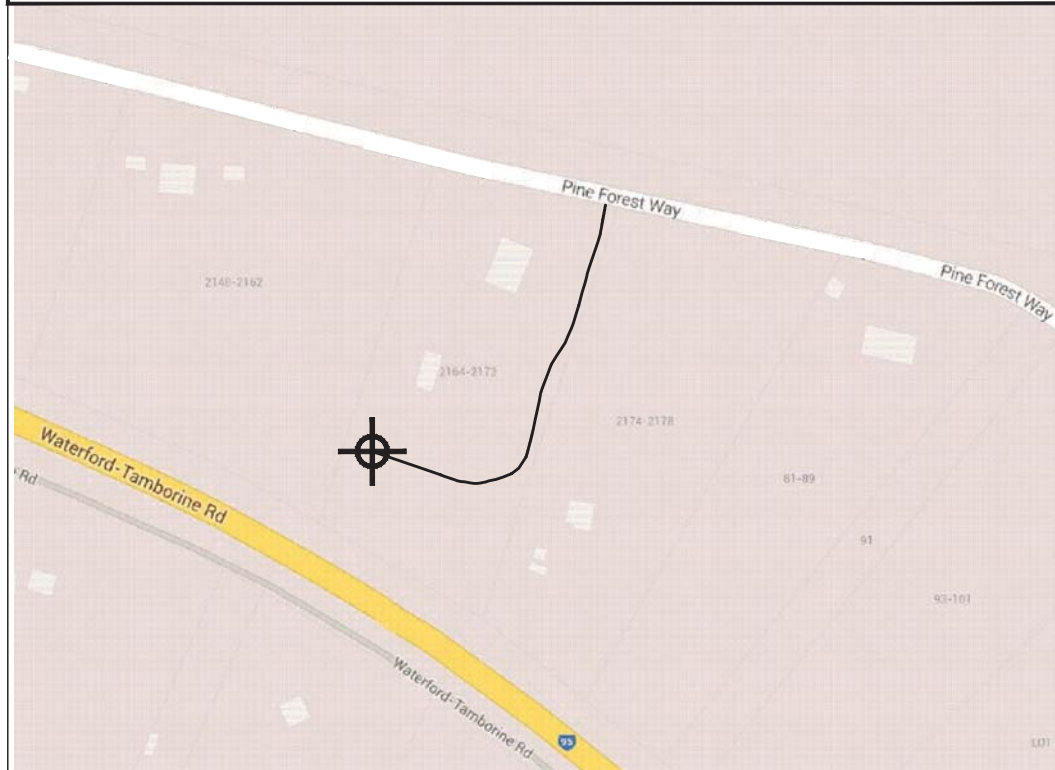

REPRODUCED WITH PERMISSION FROM GOOGLE EARTH PRO

SITE CO-ORDINATES

MONOPOLE LOCATION

DATUM: MGA(GDA 94)	ZONE: 56
EASTING	511 313
NORTHING	6 920 560
LATITUDE	-27.83960°
LONGITUDE	153.11489°

DBYD Job No. 10075357
Enquiry Date: 17/12/2015
CONTRACTOR TO REVALIDATE
AT TIME OF CONSTRUCTION!

PUBLIC UTILITIES LEGEND

TELCO TELECOMMUNICATIONS

LEGEND

NUE	NBN UNDERGROUND POWER
AE	OVERHEAD POWER LINE
UE	UNDERGROUND POWER
---	PROPERTY BOUNDARY
- - -	NBN COMPOUND SECURITY FENCE



NOTE:
1. ALL UNDERGROUND SERVICES SHOWN
INDICATIVE ONLY.

EXISTING TREE TO 25m HIGH

LOT21/SP140110

EXISTING SHED

PROPERTY BOUNDARY FENCE

NBN INSTALLATION

1
C3

NBN CONTRACTOR TO SUPPLY AND INSTALL
NBN UNDERGROUND SUB MAINS CABLE
(APPROX. 60m RUN)

NBN CONTRACTOR TO SUPPLY AND INSTALL
COMMON METER PANEL/MAIN SWITCHBOARD
(H-FRAME MOUNTED) TO ACCOMMODATE
EXISTING METERS AND NBN METER.

NBN CONTRACTOR TO SUPPLY AND INSTALL
UNDERGROUND SUB MAINS CABLE TO
PROPERTY DB (APPROX. 10m RUN, IN SAME
TRENCH AS CONSUMER MAINS)

EXISTING LOCKED GATES

EXISTING POWER POLE #761890

EXISTING LV O/H THREE PHASE
POWER LINE

PLANS AND DOCUMENTS
referred to in the PDA
DEVELOPMENT APPROVAL

Approval no: DEV2016/777
Date: 17 November 2016



OVERALL SITE PLAN

SCALE 1:1000

PINE FOREST WAY

HOUSE

LOT22/SP140110

DAM

LOT31/RP857259

EXISTING ACCESS
TRACK

NBN CONTRACTOR TO SUPPLY
AND INSTALL UNDERGROUND
CONSUMERS MAINS CABLE
(APPROX 15m RUN)

EXISTING METER PANEL ON PRIVATE
POLE (POINT OF SUPPLY)

NBN CONTRACTOR TO RELOCATE THE
EXISTING METERS TO THE COMMON
METER PANEL/MAIN SWITCHBOARD

EXISTING O/H SERVICE CABLE TO BE
UPGRADED BY ENERGEX

EXISTING POWER POLE #115066

WATERFORD TAMBORINE RD

Client:



Client:



Client:

Project:

NATIONAL BROADBAND
NETWORK
SITE No: 4LOG-51-17-YARS
YARRABILBA
SOUTH
59-67 PINE FOREST WAY
TAMBORINE
QLD 4270

FOR CONSTRUCTION

A	16.05.16	DRAFT FOR CONSTRUCTION	GC
02	29.01.16	ERICSSON REVIEW	CDB
Rev	Date	Revision Details	CAD



VISIONSTREAM PTY LTD
20 Corporate Drive
Heatherton, VIC 3202
Tel: (03) 9258 5700 Fax: (03) 9563 7481
www.visionstream.com.au

DRAFTED BY: OL
CHECKED BY: TT
APPROVED BY: MW

Drawing Title:
**OVERALL SITE
PLAN**

Drawing No.	Revision
4LOG-51-17-YARS-C2	A



Colour of monopole and all attachments are to be treated as contained within Condition 6 of PDA Development Approval

NOTES:

1. EXISTING VEGETATION NOT SHOWN FOR CLARITY.
2. LOCATION AND ORIENTATION OF NBN STRUCTURE, ODC AND ASSOCIATED EQUIPMENT WITHIN THE NBN COMPOUND ARE SHOWN INDICATIVELY AND ARE SUBJECT TO CHANGE.

Client:



Client:



Client:

Project:

NATIONAL BROADBAND NETWORK
SITE No: 4LOG-51-17-YARS
YARRABILBA SOUTH
59-67 PINE FOREST WAY
TAMBORINE
QLD 4270

FOR CONSTRUCTION

A	16.05.16	DRAFT FOR CONSTRUCTION	GC
02	29.01.16	ERICSSON REVIEW	CDB
Rev	Date	Revision Details	CAD



VISIONSTREAM PTY LTD
20 Corporate Drive
Heatherton, VIC 3202
Tel: (03) 9258 5700 Fax: (03) 9563 7481
www.visionstream.com.au

DRAFTED BY: OL
CHECKED BY: TT
APPROVED BY: MW

Drawing Title:
SITE SETOUT PLAN

Drawing No. 4LOG-51-17-YARS-C3
Revision A

PROPERTY BOUNDARY FENCE

AMENDED IN RED

By: Tom Barker
Date: 17 November 2016



NBN CONTRACTOR TO REMOVE EXISTING SECURITY FENCE (12m), INSTALL NEW NBN SECURITY FENCE FOR COMPOUND AND RECONNECT EXISTING SECURITY FENCE TO CORNER POSTS.

NBN GPS UNIT MOUNTED ON CABLE LADDER SUPPORT P1000 UNISTRUT REFER NBN-STD-0013 FOR DETAILS

NBN PDB ON H-FRAME SUPPORT REFER NBN-STD-0022 FOR DETAILS

NBN OUTDOOR CABINET BBS6101 ON CONCRETE SLAB

NBN OUTDOOR CABINET SSC-02 ON CONCRETE SLAB REFER NBN-STD-0016 & 0034 FOR DETAILS

NBN COMPOUND SECURITY FENCE (12m x 10m x 2.4m H) REFER NBN-STD-0012 FOR DETAILS

NBN MONOPOLE FOUNDATION

NBN Ø600 PARABOLIC ANTENNA TO TAMBORINE NORTH

NBN 45m MONOPOLE REFER GA9467 FOR DETAILS

NBN MONOPOLE STEP PEGS AND FALL ARREST

NBN PANEL ANTENNA (3-OFF) WITH RRU (6-OFF)

NBN 300mm WIDE CABLE LADDER (5m) WITH SUPPORT POST (1-OFF) REFER NBN-STD-0013, 0014 & 0015 FOR DETAILS

NBN 3m WIDE DOUBLE ACCESS GATES REFER NBN-STD-0012 FOR DETAILS

NBN 75mm THICK SINGLE SIZED GRAVEL OVER WEED MAT WITH TIMBER EDGE REFER NBN-STD-0012 FOR DETAILS

DETAIL 1
SCALE 1:100



PLANS AND DOCUMENTS referred to in the PDA DEVELOPMENT APPROVAL

Approval no: DEV2016/777
Date: 17 November 2016



LEGEND

— NUE —	NBN UNDERGROUND POWER
— AE —	OVERHEAD POWER LINE
— UE —	UNDERGROUND POWER
- - - - -	PROPERTY BOUNDARY
— \ — \ —	NBN COMPOUND SECURITY FENCE

20 10 0 10 20 30 40 50mm

1. ~~NEW PANEL ANTENNAS TO BE FACTORY COLOUR (LIGHT GREY).~~
2. NBN CABLE FEEDER TO RUN INTERNAL OF MONOPOLE.
3. STEP PEGS AND FALL ARREST OMITTED FOR CLARITY.
4. STANDARD CABLE WINDOW LOCATION FOR 45m HIGH NBN MONOPOLE AS PER BELOW TABLE..

INGAL EPS - MONOPOLE									
STRUCTURE	CABLE WINDOW HEIGHTS (EL)								
20m TYPE 2 & 3	2.4m(2)	7m(4)	12.2m(4)	15m(4)	17m(4)	18m(4)	19.2m(2)		
25m TYPE 2 & 3	2.4m(2)	14m(4)	17.2m(4)	20m(4)	22m(4)	23m(4)	24.2m(2)		
30m TYPE 2 & 3	2.4m(2)	8.9m(4)	19.2m(4)	22.6m(4)	25m(4)	27m(4)	28m(4)	29.2m(2)	
35m TYPE 2	2.4m(2)	13m(4)	23.7m(4)	27.2m(4)	30m(4)	32m(4)	33m(4)	34.2m(2)	
35m TYPE 3	2.4m(2)	8.6m(4)	23.7m(4)	27.2m(4)	30m(4)	32m(4)	33m(4)	34.2m(2)	
40m TYPE 2 & 3	2.4m(2)	8.4m(4)	18.7m(4)	29.3m(4)	32.2m(4)	35m(4)	37m(4)	38m(4)	39.2m(2)
45m TYPE 2 & 3	2.4m(2)	11.5m(4)	21.5m(4)	31.9m(4)	37.2m(4)	40m(4)	42m(4)	43m(4)	44.2m(2)

Date: 17 November 2016



Date: 17 November 2016



Colour of monopole and all attachments are to be treated as contained within Condition 6 of PDA Development Approval

NBN COMPOUND SECURITY FENCE
(12m x 10m x 2.4m H)
WITH 3m WIDE DOUBLE ACCESS GATES



Project:
**NATIONAL BROADBAND
NETWORK**
SITE No: 4LOG-51-17-YARS
**YARRABILBA
SOUTH**
59-67 PINE FOREST WAY
TAMBORINE
QLD 4270

FOR CONSTRUCTION

A	16.05.16	DRAFT FOR CONSTRUCTION	GC
02	29.01.16	ERICSSON REVIEW	CDB
Rev	Date	Revision Details	CAD

visionstream 

VISIONSTREAM PTY LTD
20 Corporate Drive
Heatherton, VIC 3202
Tel- (03) 9258 5700 Fax- (03) 9563 7481
www.visionstream.com.au

DRAFTED BY:	OL
CHECKED BY:	TT
APPROVED BY:	MW

Drawing Title:
SITE ELEVATION

Drawing No.	Revised
4LOG-51-17-YARS-C4	

Revision
A

AutoCAD File: M:\National\Ericsson NBN Wireless\16.0 SAED\QLD T82.0 Asimmore Cluster1.0 All Sites\Yarrabubba South_4\LOG-51-17-YARS-G_RevA.dwg Date: Monday, 16 May 2016 11:41:50 AM Login: cbunt



PLANS AND DOCUMENTS
referred to in the PDA
DEVELOPMENT APPROVAL



Approval no: DEV2016/777

Date: 17 November 2016

Client:



Client:



Client:

Project:

**NATIONAL BROADBAND
NETWORK**
SITE No: 4LOG-51-17-YARS
**YARRABILBA
SOUTH**
59-67 PINE FOREST WAY
TAMBORINE
QLD 4270

FOR CONSTRUCTION

A	16.05.16	DRAFT FOR CONSTRUCTION	GC
02	29.01.16	ERICSSON REVIEW	CDB
Rev	Date	Revision Details	CAD



VISIONSTREAM PTY LTD
20 Corporate Drive
Heatherton, VIC 3202
Tel- (03) 9258 5700 Fax- (03) 9563 7481
www.visionstream.com.au

DRAFTED BY: OL
CHECKED BY: TT
APPROVED BY: MW

Drawing Title:
**ALLOTMENT
PLAN**

Drawing No.	Revision
4LOG-51-17-YARS-C5	A

ALLOTMENT PLAN
SCALE 1:2000

20 10 0 10 20 30 40 50mm